


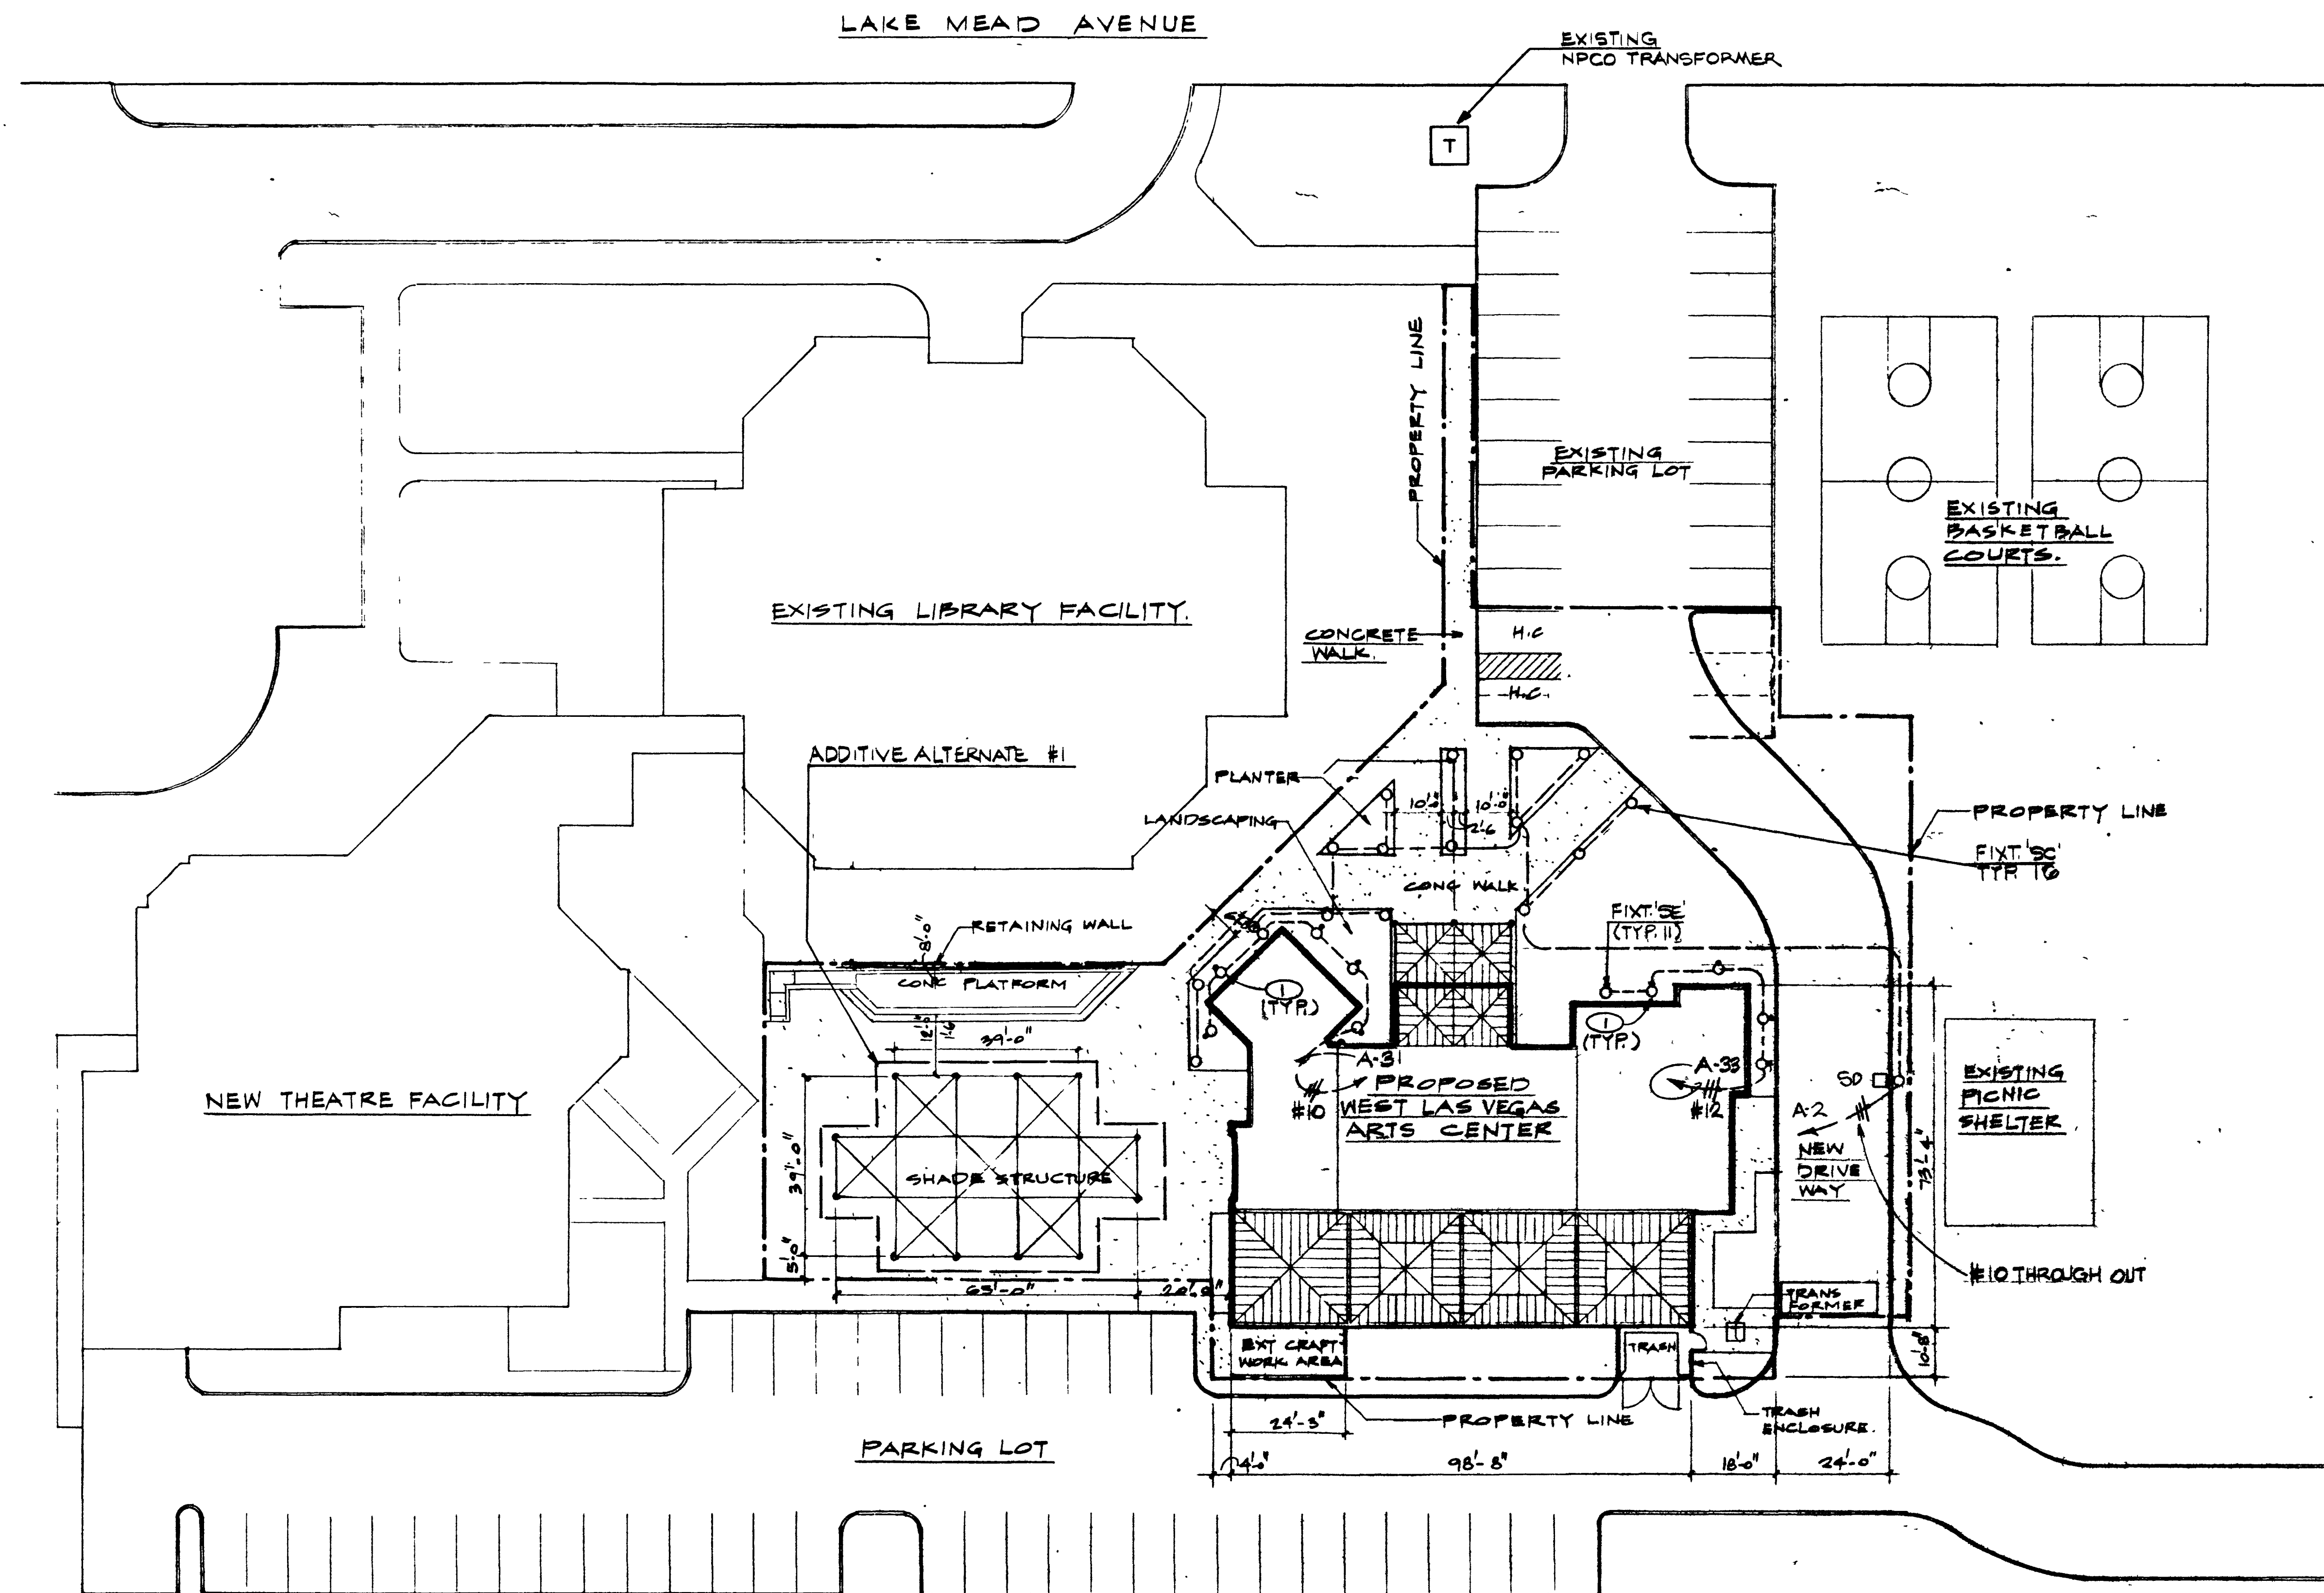


SITE PLAN

NOTES

- CONTRACTOR SHALL PROVIDE 12"x12"x12"D CONCRETE BASE FOR GROUND MOUNTED FLOOD LIGHTS

NOTICE

- CONTRACTOR SHALL COORDINATE FIXTURE LOCATIONS W/ LANDSCAPE/ARCHITECTURAL DRAWINGS.

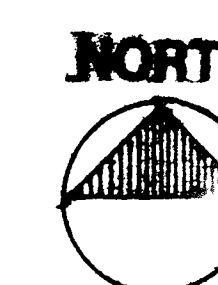

CEM:
NOCCOR/AMERICAN
3/22/95

671-46

Revisions <table border="1"> <tr><td> </td><td> </td></tr> <tr><td> </td><td> </td></tr> <tr><td> </td><td> </td></tr> <tr><td> </td><td> </td></tr> <tr><td> </td><td> </td></tr> <tr><td> </td><td> </td></tr> <tr><td> </td><td> </td></tr> <tr><td> </td><td> </td></tr> <tr><td> </td><td> </td></tr> <tr><td> </td><td> </td></tr> </table>																					
CONSULTING ENGINEERS jba 1000 W. LAS VEGAS AVENUE SUITE 200 LAS VEGAS, NV 89103 TEL: 792-1111 FAX: 792-1111																					
any architects 1000 W. LAS VEGAS AVENUE SUITE 200 LAS VEGAS, NV 89103 TEL: 792-1111 FAX: 792-1111																					
WEST LAS VEGAS ARTS CENTER DOOLITTLE PARK - LAS VEGAS, NEVADA																					
SITE PLAN																					
AS-BUILT																					
Project No. 92100 Scale: 1" = 20'-0" Date: 8-83 Drawn By: KNF Checked By: DOB Project No. 92100 Scale: 1" = 20'-0" Date: 8-83 Drawn By: KNF Checked By: DOB																					
ES10																					

