



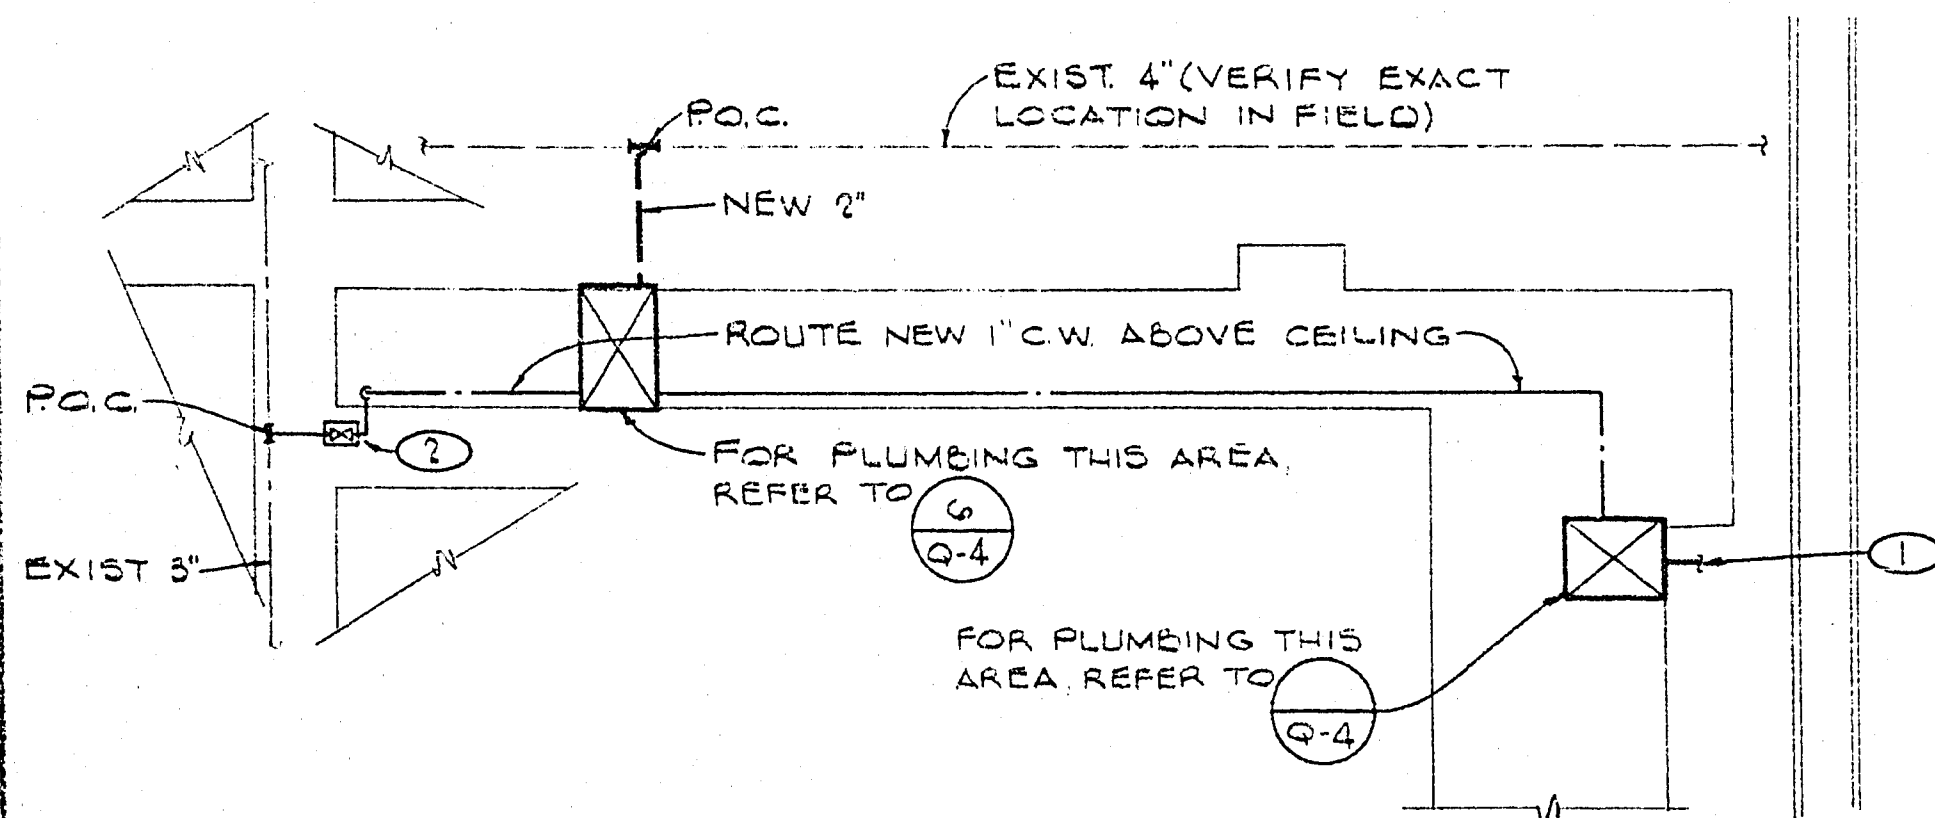

5 PARTIAL PLOT PLAN
Q-2 SCALE: 1/8" = 1'-0"

NOTES:


- 1 ROUTE NEW 4" TO NEAREST EXISTING SEWER, VERIFY EXACT ROUTING IN FIELD
- 2 NEW 1" C.W. & SHUT-OFF VALVE, IN CONCR. BOX REFER TO (6) FOR CONT. OF KITCHEN PIPING
- 3 ALL ITEMS SHALL REMAIN AS INDICATED (A) UNLESS OTHERWISE NOTED (E-1)
- 4 CONCEAL BEHIND E.W.C.
- 5 PROVIDE PRUDENTIAL #P-1221-48RS-WA W/I-F40T12 CW/RS LAMP CLG. MTD.

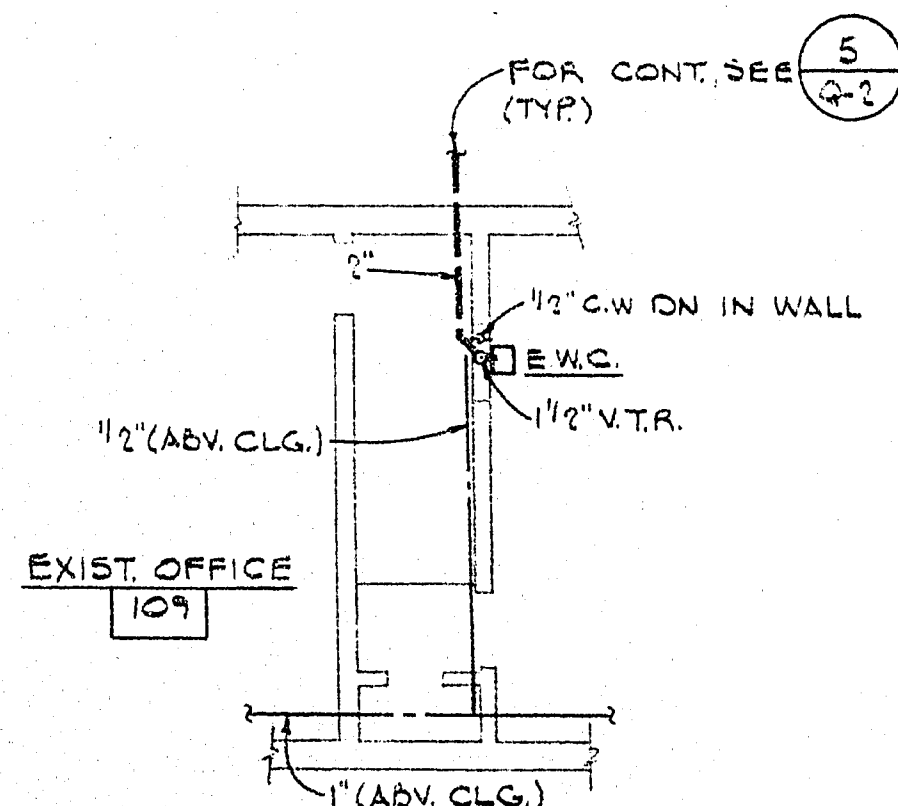


6 PLUMB. PART PLAN
Q-2 SCALE: 1/8" = 1'-0"

PLUMBING SYMBOLS & LEGEND

ABBR.	SYMBOL	DESCRIPTION
Sor W	---	SOIL, WASTE OR SEWER BEL. GR.
Sor W	---	SOIL, WASTE OR SEWER ADV. GR.
V	---	VENT
C.W.	---	COLD WATER
H.W.	---	HOT WATER
S.O.V.	⊗	SHUT OFF VALVE
V.T.R.	○	VENT THRU ROOF
P.O.C.	○	POINT OF CONNECTION

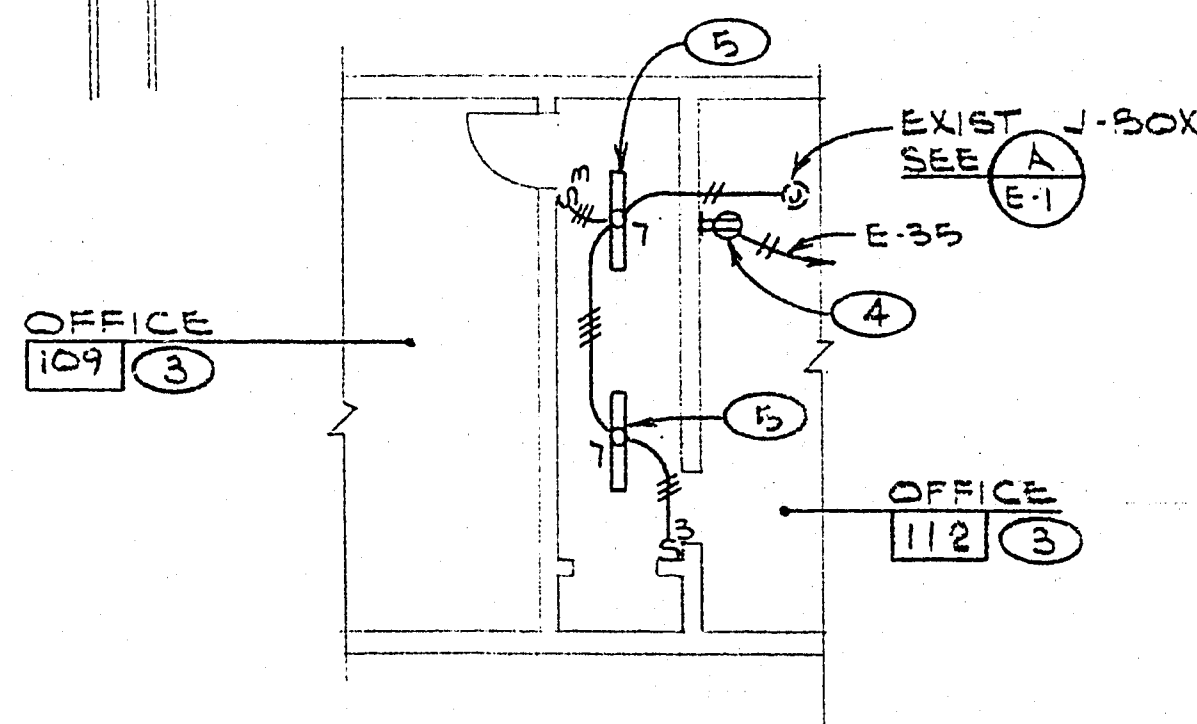




7 ELECT. PART PLAN
Q-2 SCALE: 1/8" = 1'-0"

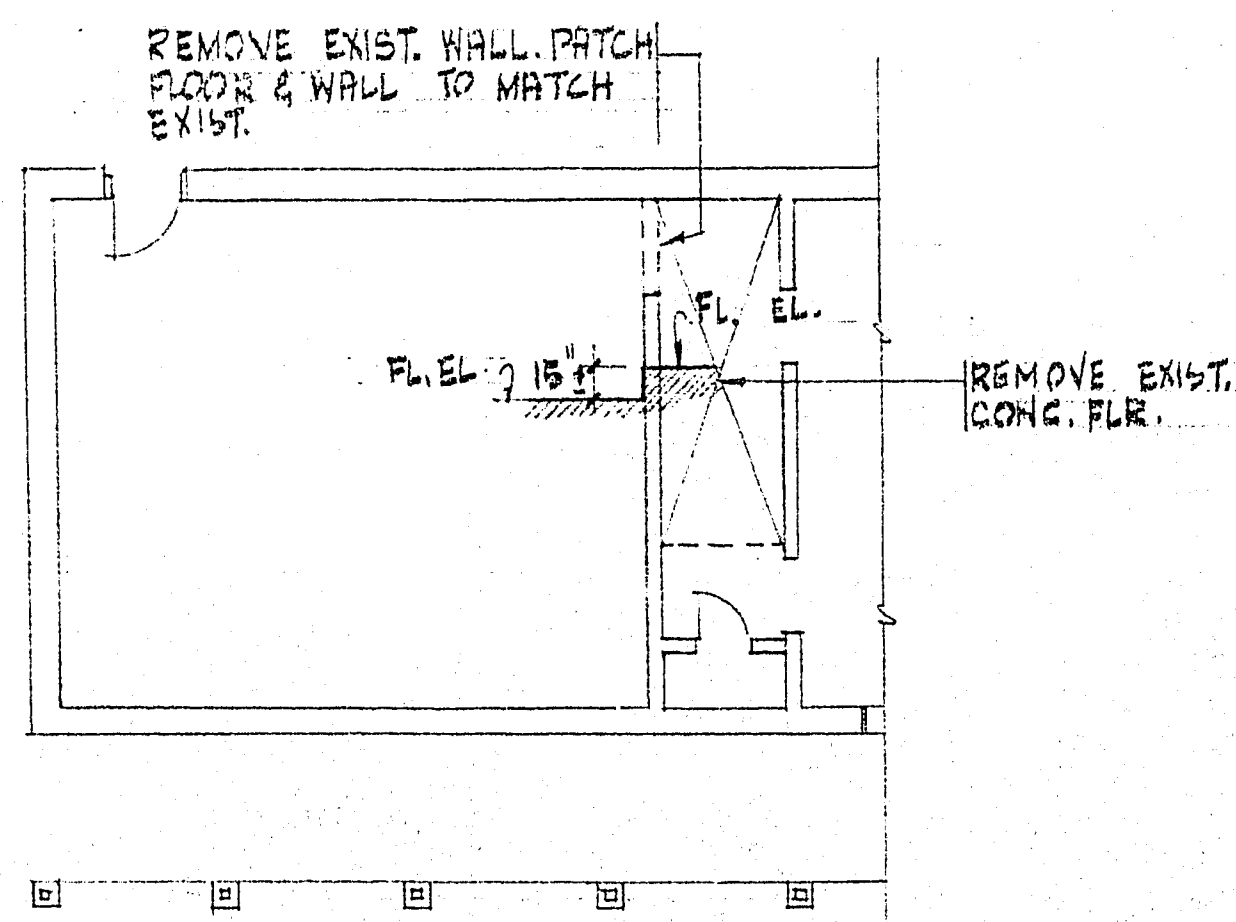

1 DEMOLITION PLAN
Q-2 SCALE: 1/8" = 1'-0"

PLUMBING FIXTURE SCHEDULE

ABBR.	FIXTURE	H.W.	C.W.	V.	TRAP	Sor W	REMARKS
W.C.	WATER CLOSET	1/2	1/2	2	---	4	FLUSH TANK, FLR. MTD.
L.	LAVATORY	1/2	1/2	1 1/2	1 1/2	1 1/2	WALL HUNG
M.S.	MOP SINK	1/2	1/2	2	2	2	FLOOR MTD.
E.W.C.	ELEC. WATER COOLER	---	1/2	1 1/2	1 1/2	1 1/2	WALL HUNG

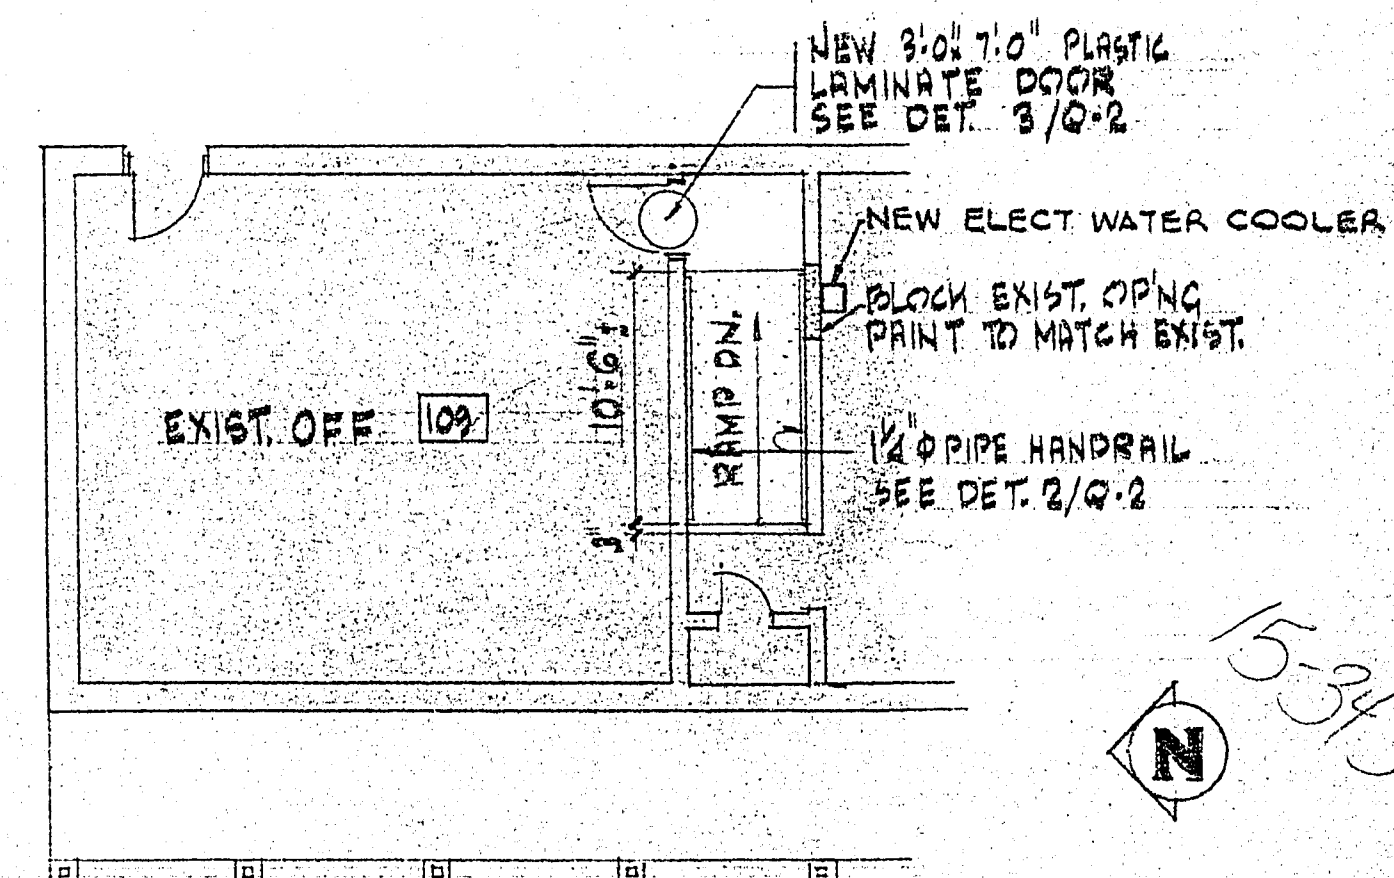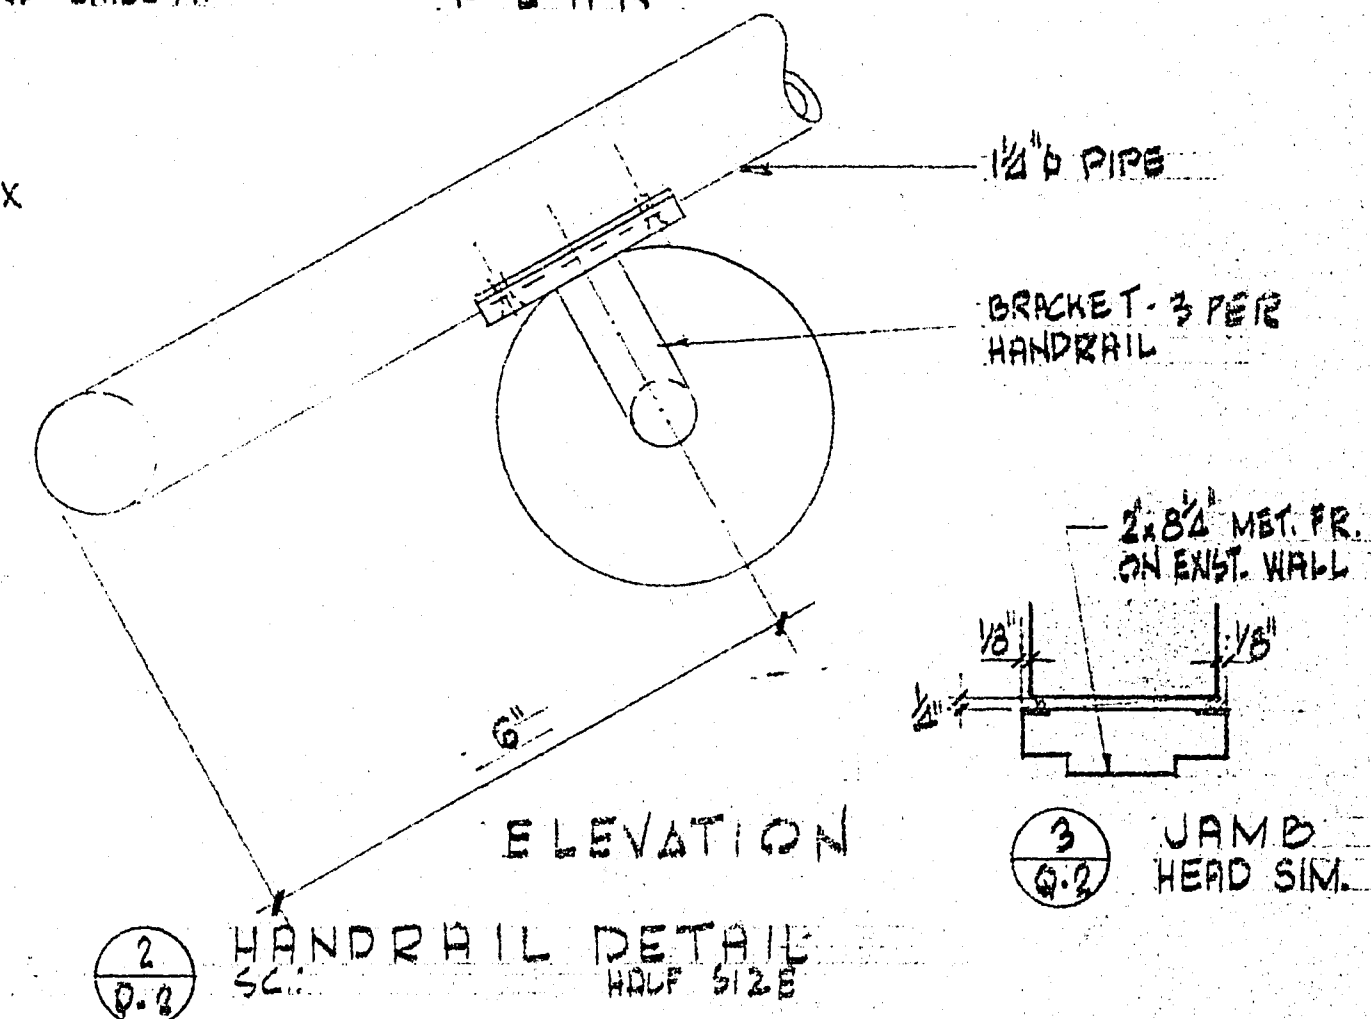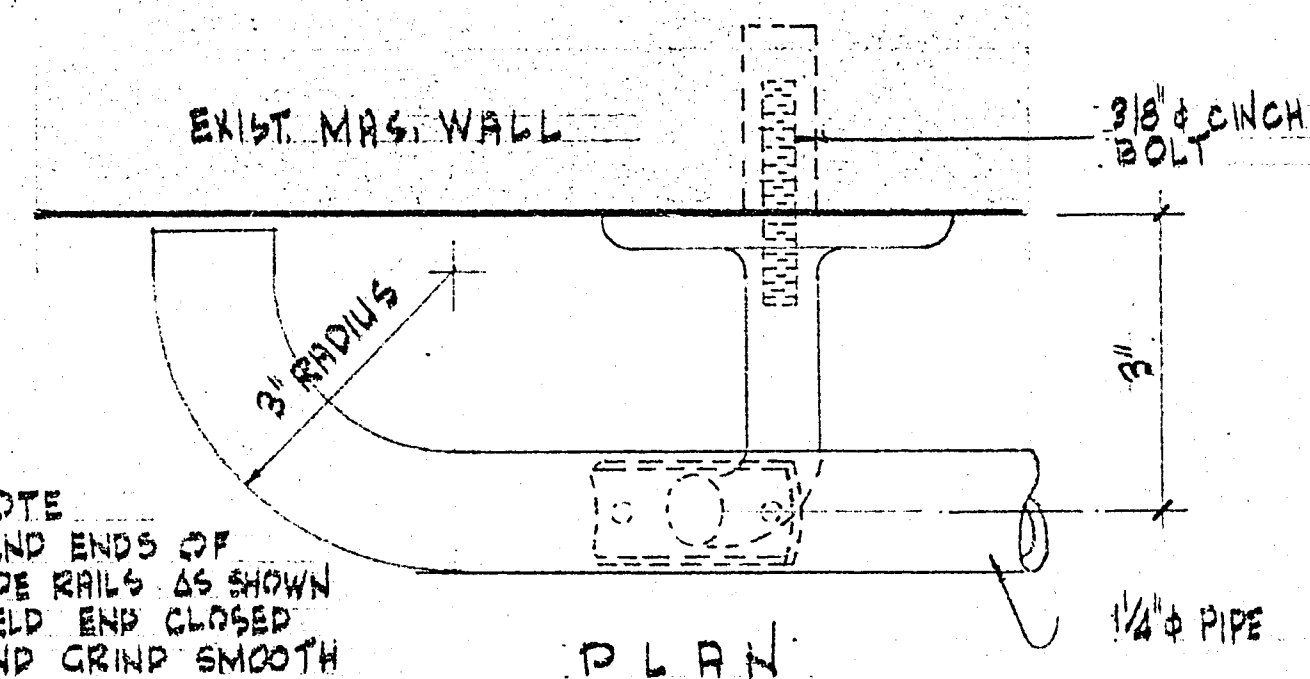

4 PARTIAL FLOOR PLAN
Q-2 SCALE: 1/8" = 1'-0"

TITLE: PHASE I WESTSIDE GRADE SCHOOL RENOVATION LAS VEGAS, NEVADA		SHEET TITLE: DEMOLITION PLAN, FLR. PLAN (HANDRAIL DET.)		SHEET NO. Q-2A
FROM THE OFFICE OF: WALTER F. ZICK & HARRIS R. SHARP ARCHITECTS-ENGINEERS, INC. LAS VEGAS, NEVADA		DATE: AUG. 23, 77	DRAWN: R.H.	CHECKED: GRS