


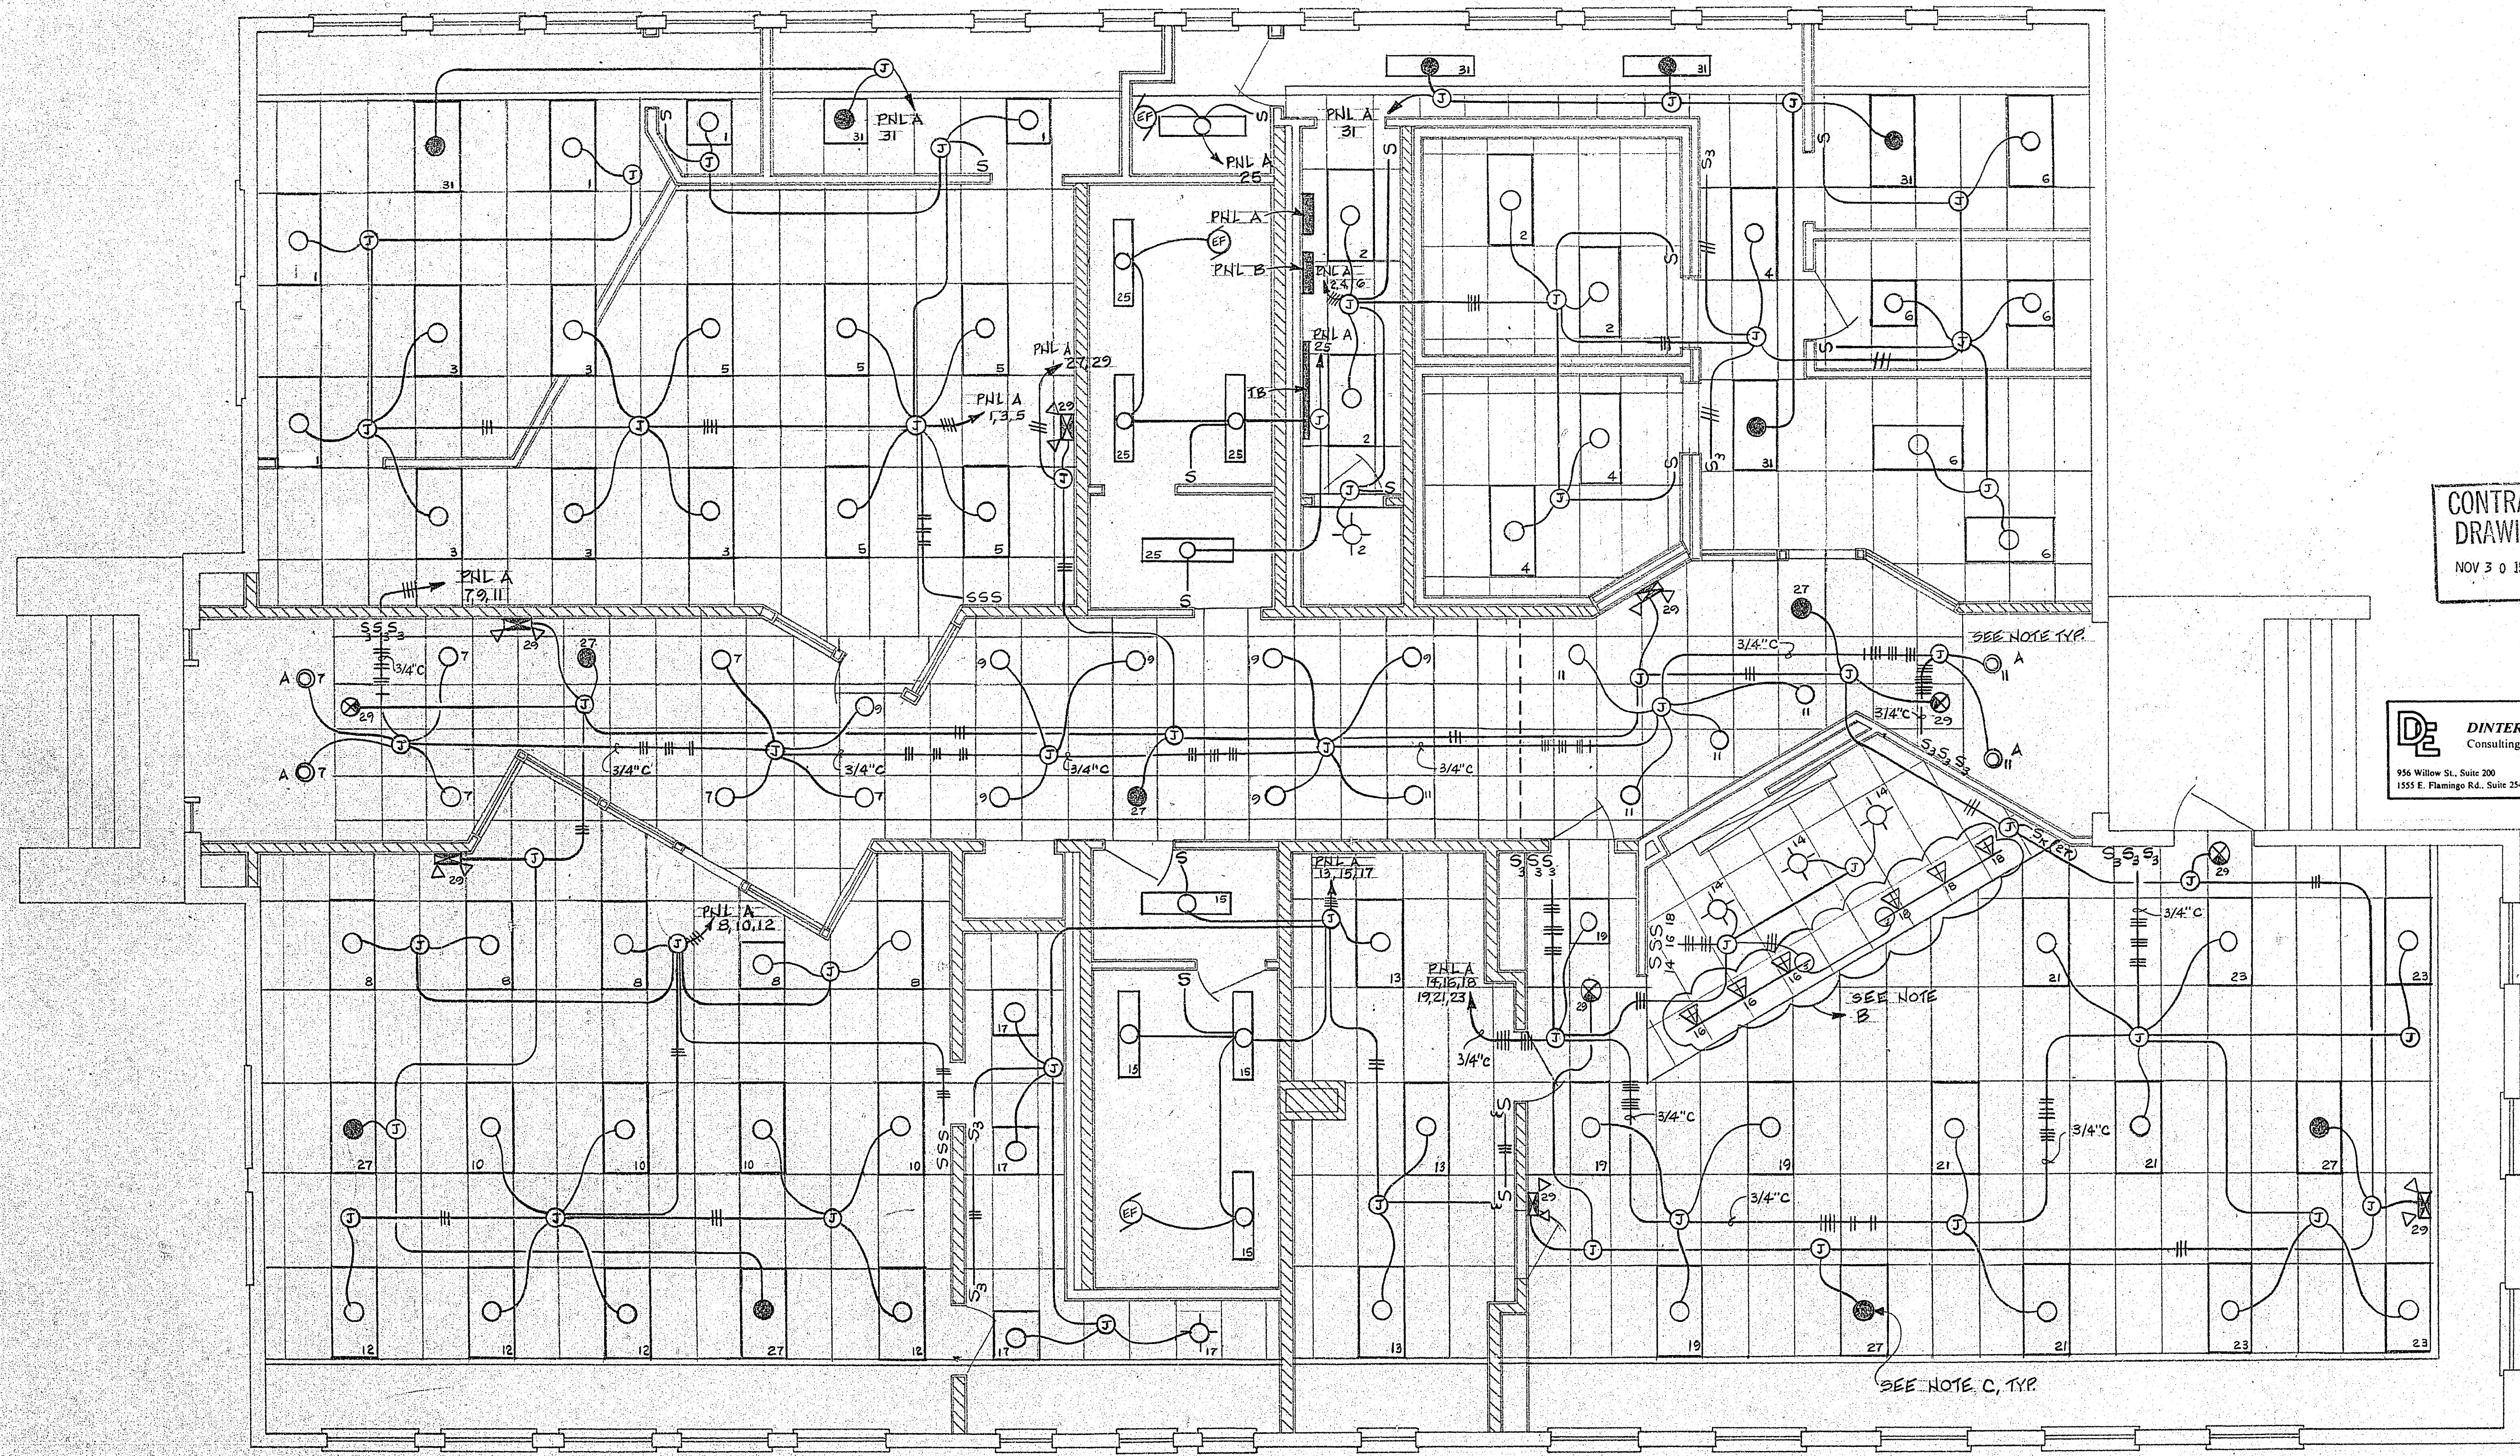

CONTRACT
DRAWING
NOV 3 0 1982

DINTER ENGINEERING CO., Ltd.
Consulting Electrical & Mechanical Engineers
956 Willow St., Suite 200 Reno Nevada 89502 (702) 329-0206
1555 E. Flamingo Rd., Suite 254 Las Vegas, Nevada 89109 (702) 369-1178

BONGBER-WHITNEY, INC.
1816 INDUSTRIAL RD.
LAS VEGAS - NEVADA
382-1371

NOTES

- A. FIXTURES SHALL BE SUPPLIED WITH A 30°± SLOPE TO MATCH CEILING. VERIFY PRIOR TO ORDER.
- B. TRACK LIGHTING INSTALLED ON VERTICAL FACE OF CEILING TRANSITION. MOUNT AS HIGH AS POSSIBLE TO ALLOW FULL MOVEMENT OF LIGHTS. VERIFY PRIOR TO INSTALLATION.
- C. FIXTURES SO DESIGNATED SHALL SERVE AS "NIGHT LIGHTS" AND SHALL NOT BE SWITCHED.

AS BUILT

Scale (1/4" = 1' - 0")		Scale (V)	W.D. 2162
Fid. bk. no.		Date AUG. 1982	
Design by M. GOODMAN		Drawn by NORMA GOMEZ	
APPROVED BY CITY ENGINEER			
Professional Engineer - State of Nevada			
Department of Public Services		Engineering Design Division	
WEST SIDE SCHOOL RENOVATION		LIGHTING PLAN	
Drawing no. 513-53			
53			
57			