

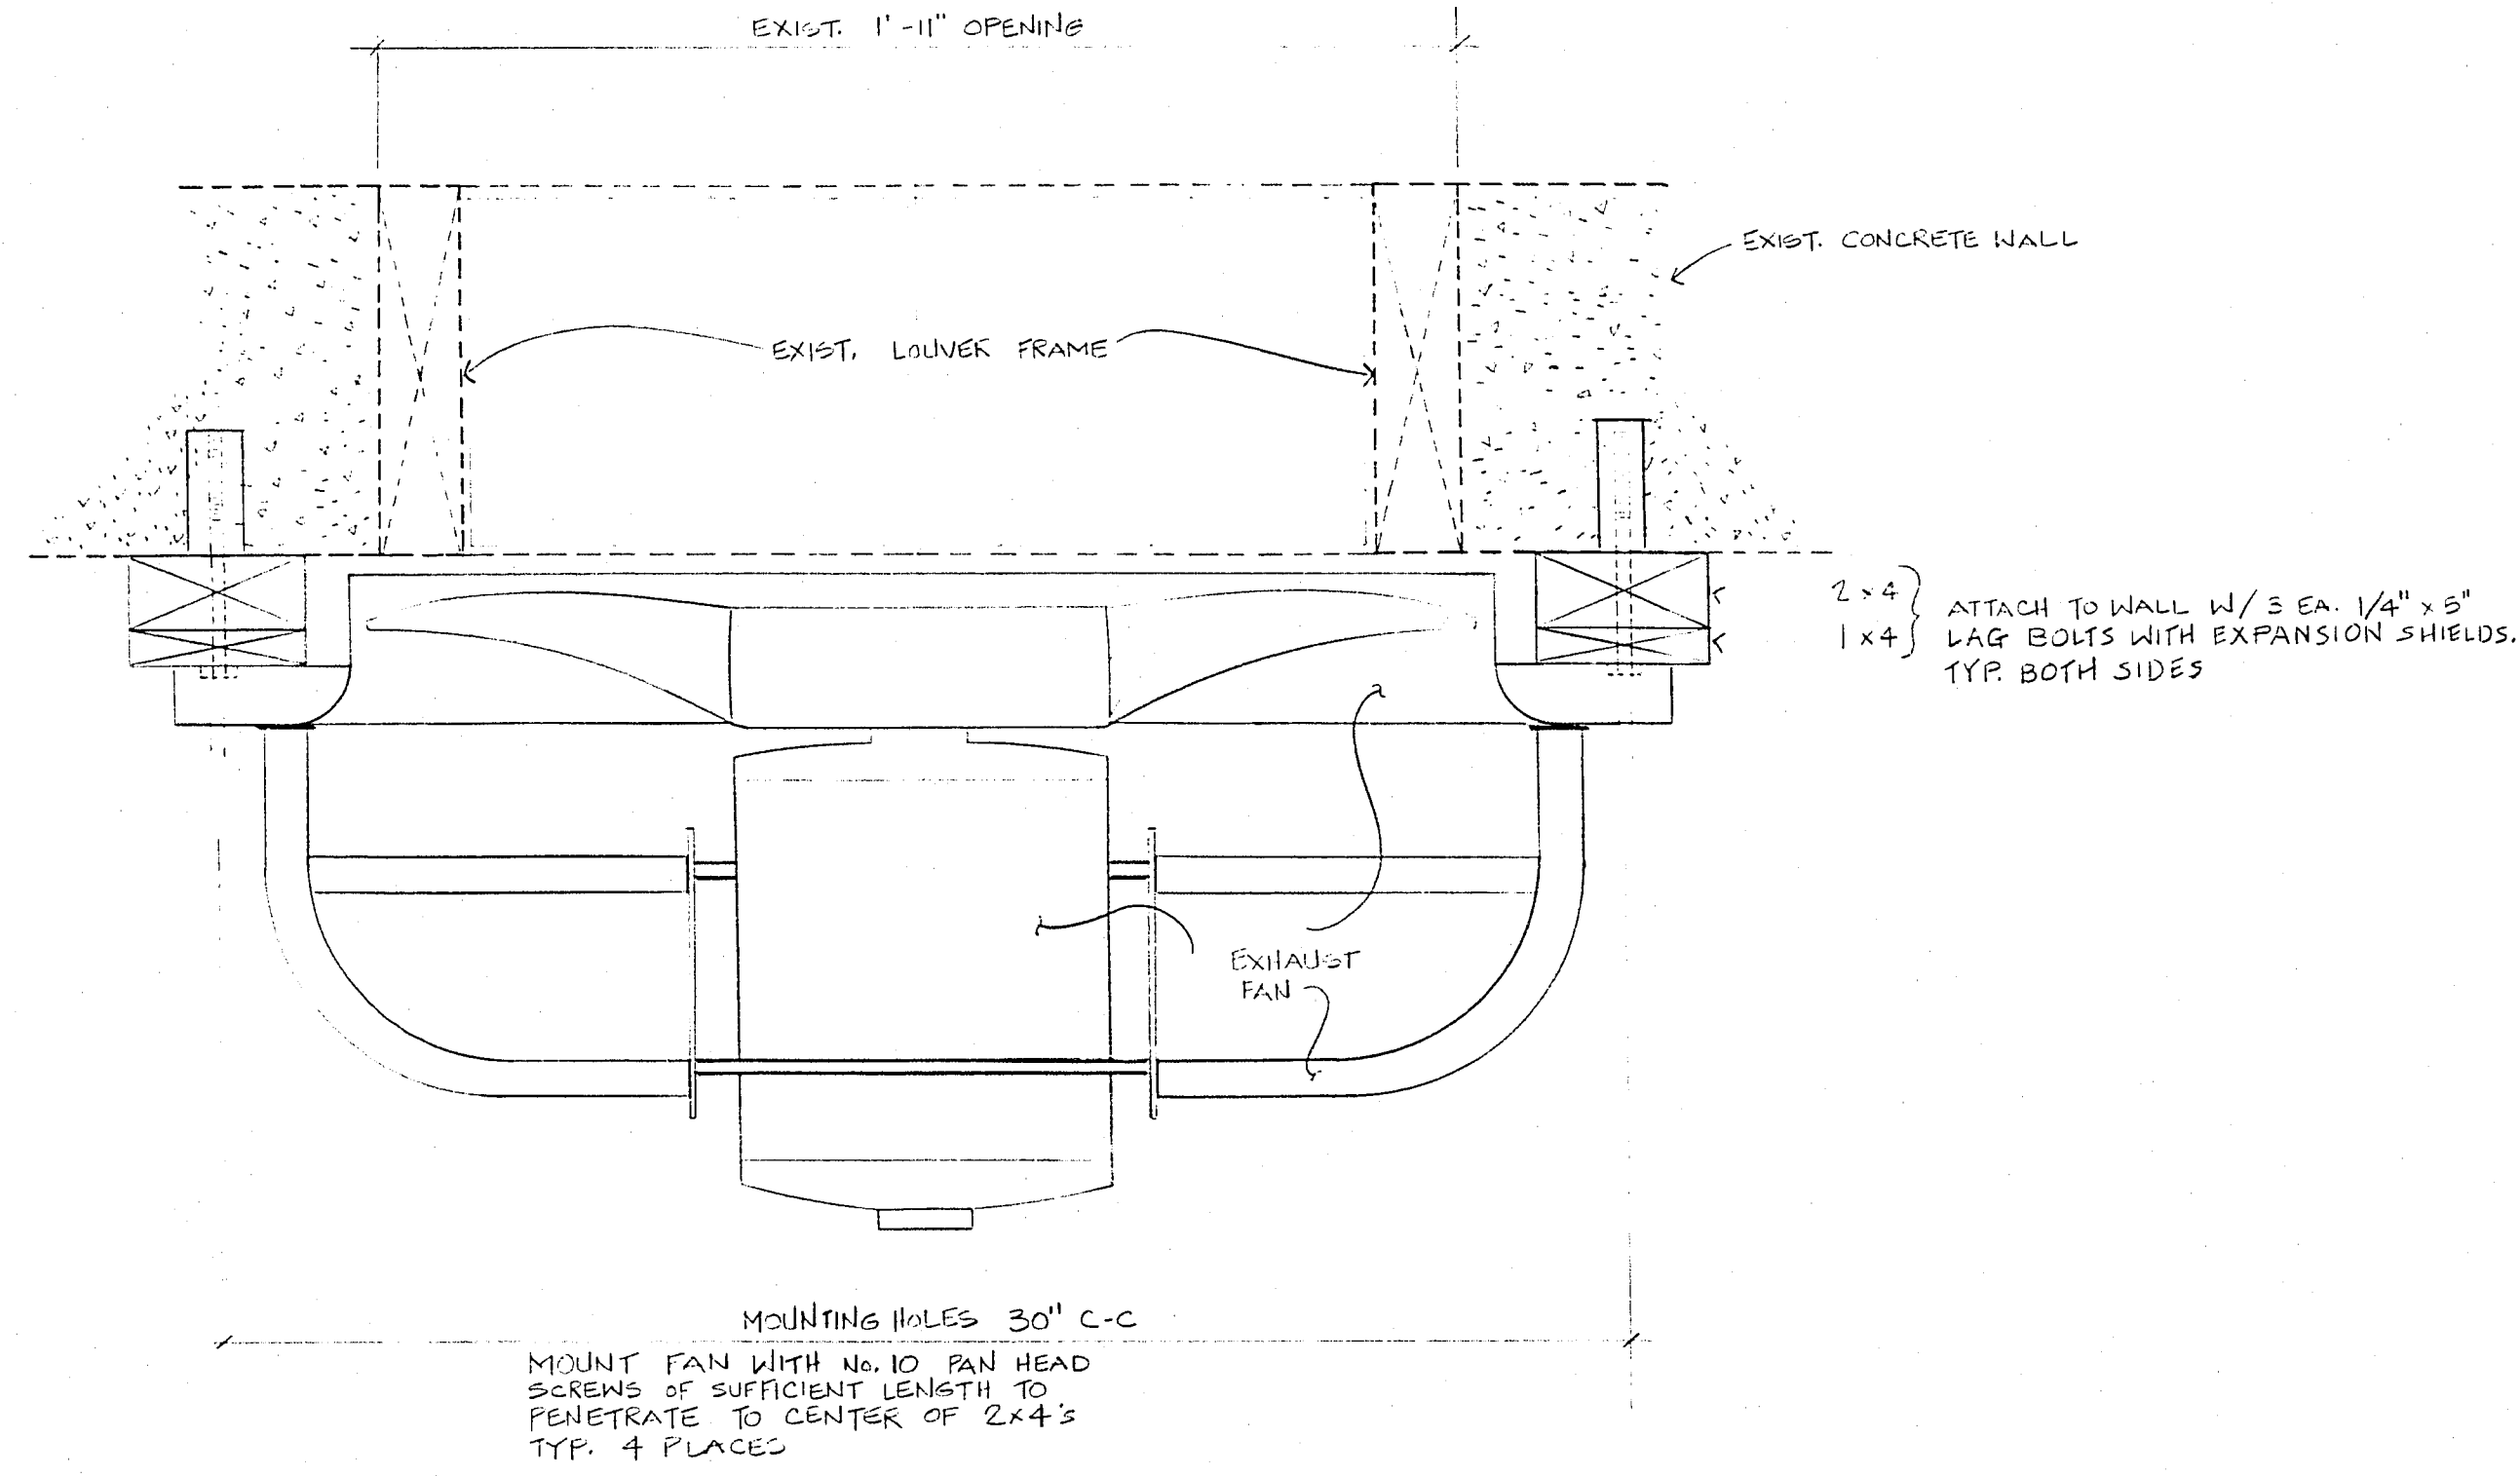


DETAIL 1
(SECTION) M-3

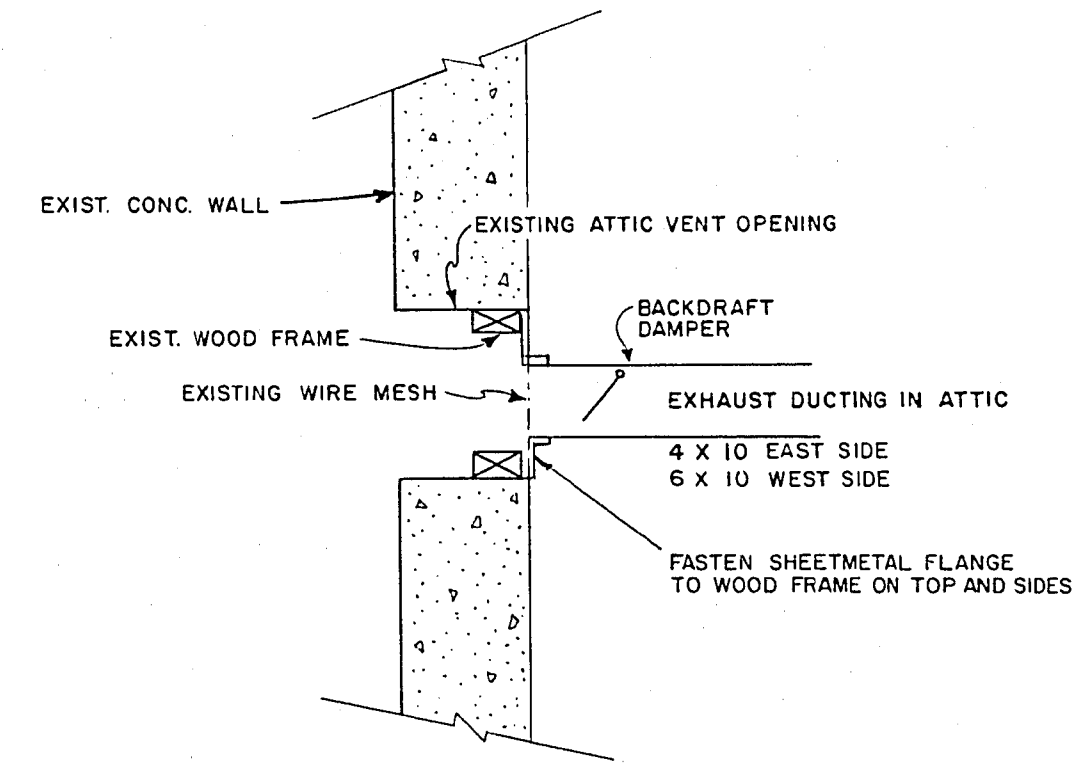


ATTIC EXHAUST FAN MOUNTING DETAIL 2
X-SECTION VIEW FROM TOP SCALE: 3" = 1'-0" M-3

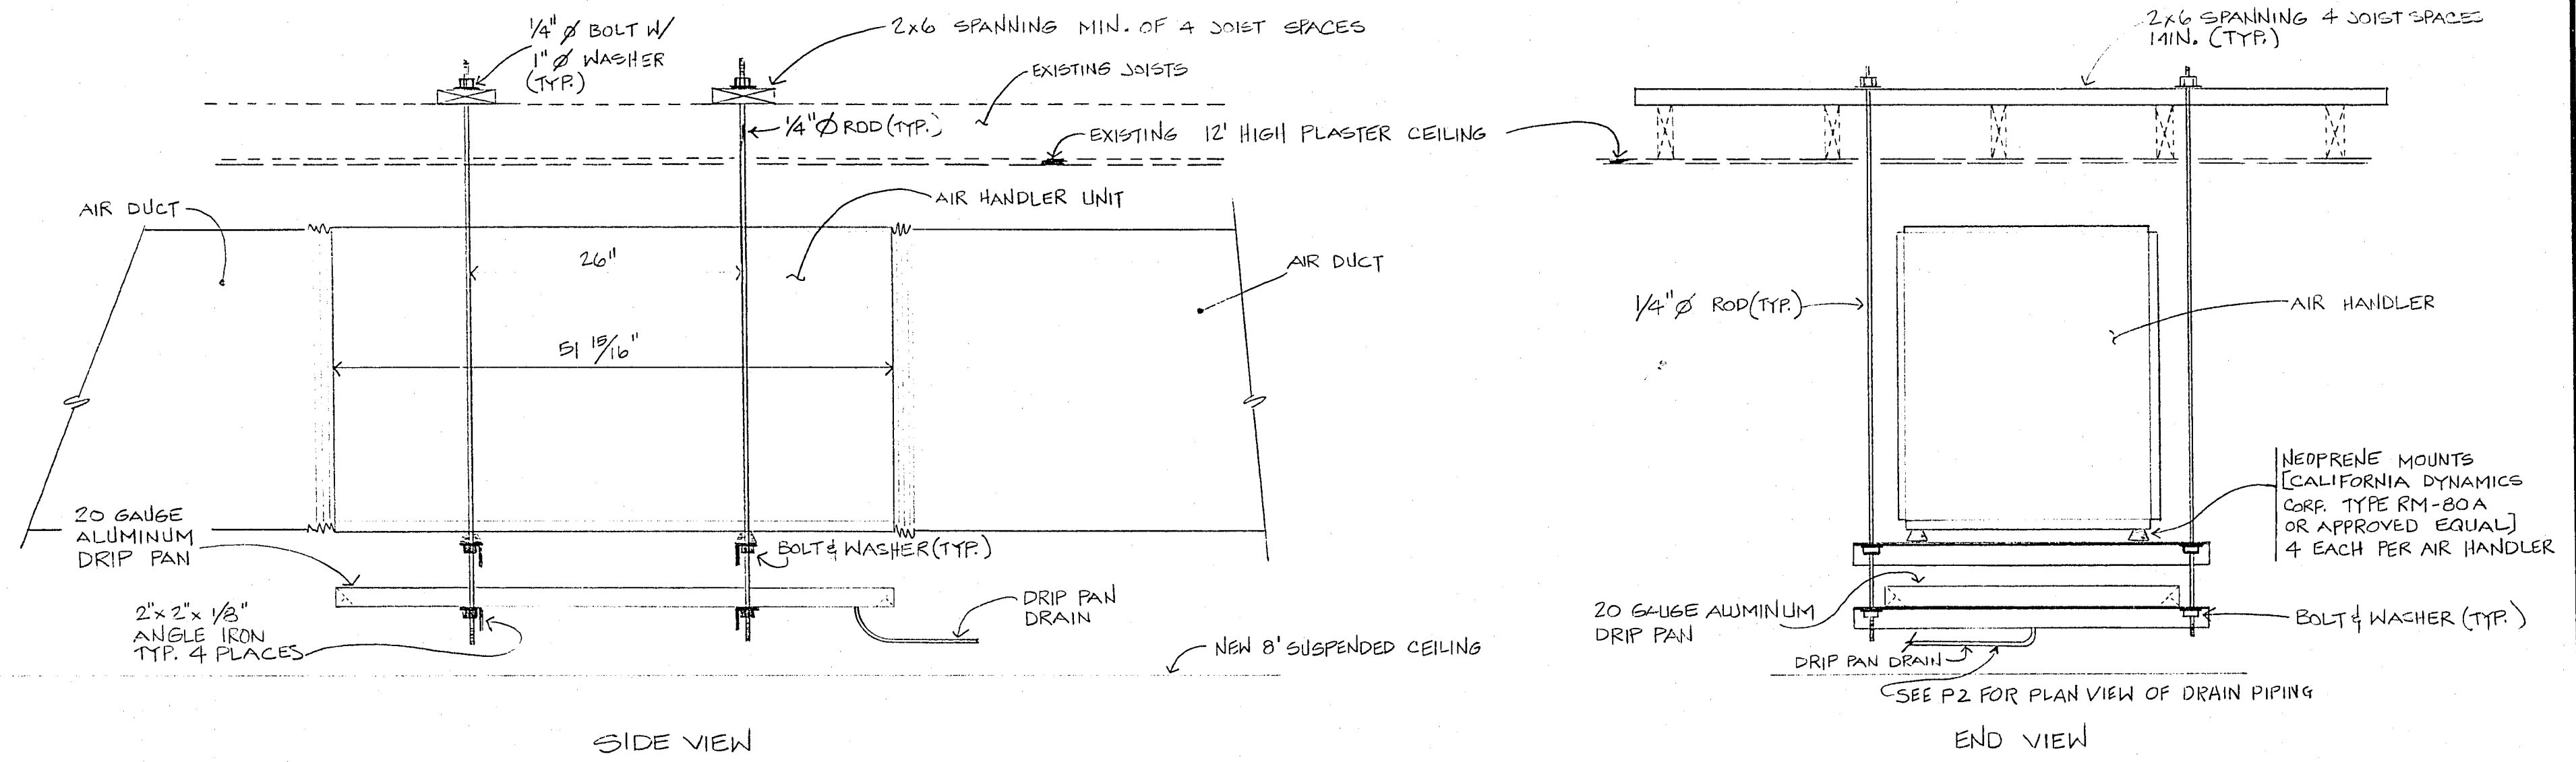

MOUNTING DETAIL FOR AIR HANDLER UNITS 3
SCALE: 1" = 1'-0" M-3

Scale (h)	Scale (v)	W.I.	Date	Design by	Drawn by	Revisions	Date
Fid. bk. no. N/A	Date 9-30-80	2162	9-30-80	ANZAI	NORMA GOMEZ		
DESIGNED BY BERT ANZAI						APPROVED BY [Signature]	

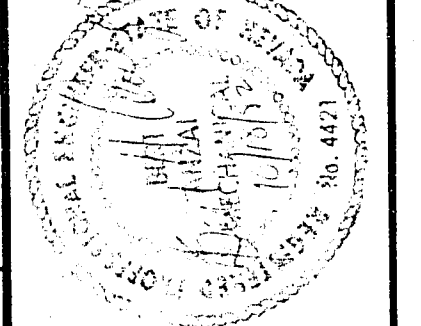

Department of Public Services Engineering Design Division
HVAC DETAILS
WEST SIDE SCHOOL RENOVATION



Drawing no. 513-53 M-3 57