


IMPROVEMENT PLANS

FOR

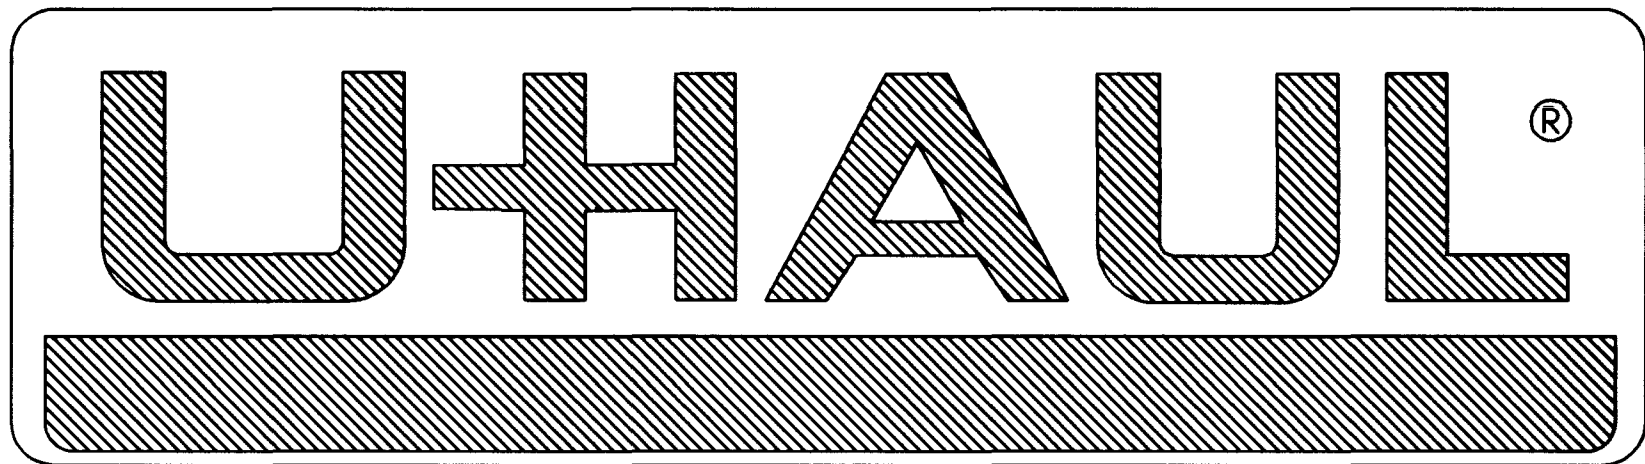

NELLIS BLVD AND STEWART AVE.
CITY OF LAS VEGAS
STATE OF NEVADA

U-HAUL INTERNATIONAL

2727 N. CENTRAL AVENUE
PHOENIX, ARIZONA 85004
(602) 263-6502

APPROVALS

	2-18-99
CITY PLANNING ENGINEER - CHARLES KAJKOWSKI, JR PE# 4784	DATE
APPROVAL OF THESE PLANS IS LIMITED TO THOSE IMPROVEMENTS CONSTRUCTED IN THE DEDICATED RIGHT-OF-WAY AND/OR DEDICATED EASEMENTS. THIS APPROVAL DOES NOT AUTHORIZE THE CONSTRUCTION ON ANY IMPROVEMENTS THAT DEVIATE FROM ADOPTED STANDARDS AND/OR SPECIFICATIONS EXCEPT THOSE SPECIFICALLY LISTED UNDER DEVIATIONS FROM STANDARD THE ENGINEER SHALL RESOLVE ANY DEVIATION OTHER THAN THOSE LISTED IN DEVIATIONS FROM STANDARDS IN FAVOR OF THE UNIFORM STANDARD DRAWINGS AND SPECIFICATIONS CLARK COUNTY AREA NEVADA.	
	12-10-98
CITY FIRE MARSHALL	DATE
	2-25-99
LAS VEGAS VALLEY WATER DISTRICT	DATE
	12-10-98
NEVADA POWER COMPANY	DATE
	12-10-98
SOUTHWEST GAS CORPORATION	DATE
	12-10-98
SPRINT	DATE

ENGINEERS LOGO	U-HAUL INTERNATIONAL
CLIENT'S LOGO	U-HAUL INTERNATIONAL
COVER SHEET	U-HAUL NELLIS BOULEVARD
SHEET	TITLE
DRAWN BY: RFW	06/24/98
DESIGNED BY: MC	06/24/98
CHECKED BY: MC	06/24/98
PROJECT NO: 51804	SCALE:
SEAL VERNON R. HARRIS PROFESSIONAL ENGINEER - STATE OF NEVADA No. 9898 11-5-98	
SHEET C1 1 OF 9 SHEETS	
DRAWING NO. 107-V2989	

IMPROVEMENT PLANS

FOR



NELLIS BLVD AND STEWART AVE
CITY OF LAS VEGAS
STATE OF NEVADA

U-HAUL INTERNATIONAL

2727 N. CENTRAL AVENUE
PHOENIX, ARIZONA 85004
(602) 263-6502

APPROVALS

Paul H. Smith 2-12-99
City Engineer

U-HAUL INTERNATIONAL
2727 N. CENTRAL AVENUE
PHOENIX, ARIZONA 85004
(602) 263-6502

John Smith 2-12-99
City Engineer

John Smith 2-12-99
City Engineer




John Smith 2-12-99
City Engineer

John Smith 2-12-99
City Engineer

John Smith 2-12-99
City Engineer

U-HAUL INTERNATIONAL	
DATE	2-12-99
TIME	10:00 AM
LOCATION	NELLIS BLVD AND STEWART AVE
PROJECT	IMPROVEMENT PLANS
ENGINEER	PAUL H. SMITH
CITY	CITY OF LAS VEGAS
STATE	NEVADA
U-HAUL	2727 N. CENTRAL AVENUE PHOENIX, ARIZONA 85004 (602) 263-6502
APPROVALS	<i>Paul H. Smith</i> 2-12-99 <i>John Smith</i> 2-12-99 <i>John Smith</i> 2-12-99 <i>John Smith</i> 2-12-99 <i>John Smith</i> 2-12-99
U-HAUL	2727 N. CENTRAL AVENUE PHOENIX, ARIZONA 85004 (602) 263-6502

C:\DRAWINGS\FRIENDLY\DWG\PLZ-SHT4.dwg, Dec 10 14:55:43 1997 PLOTTED BY M.H.

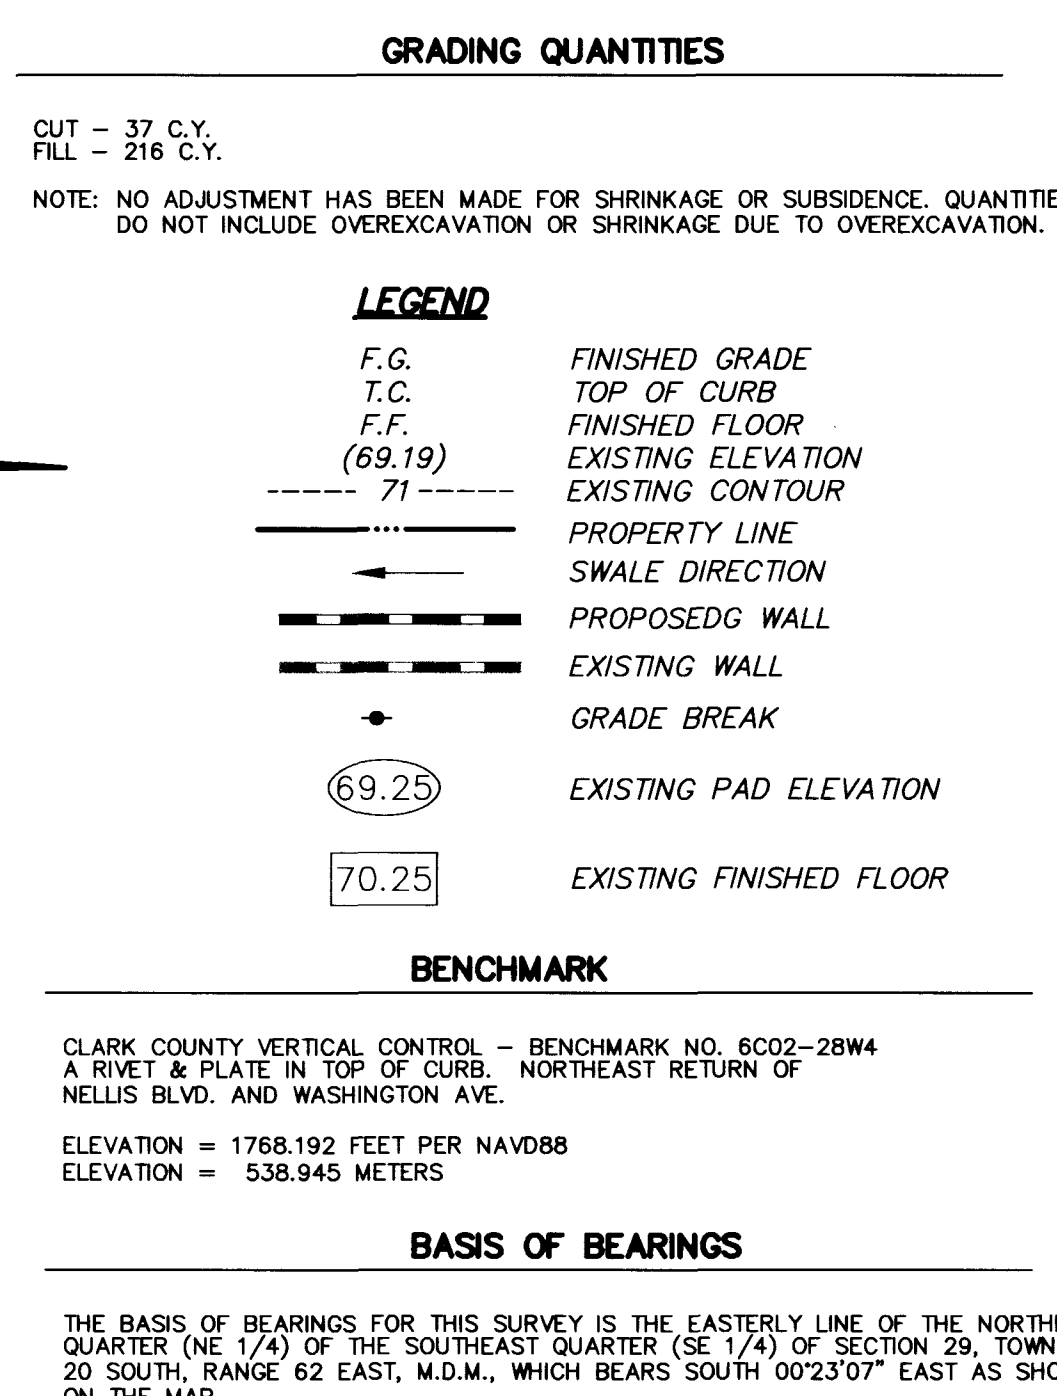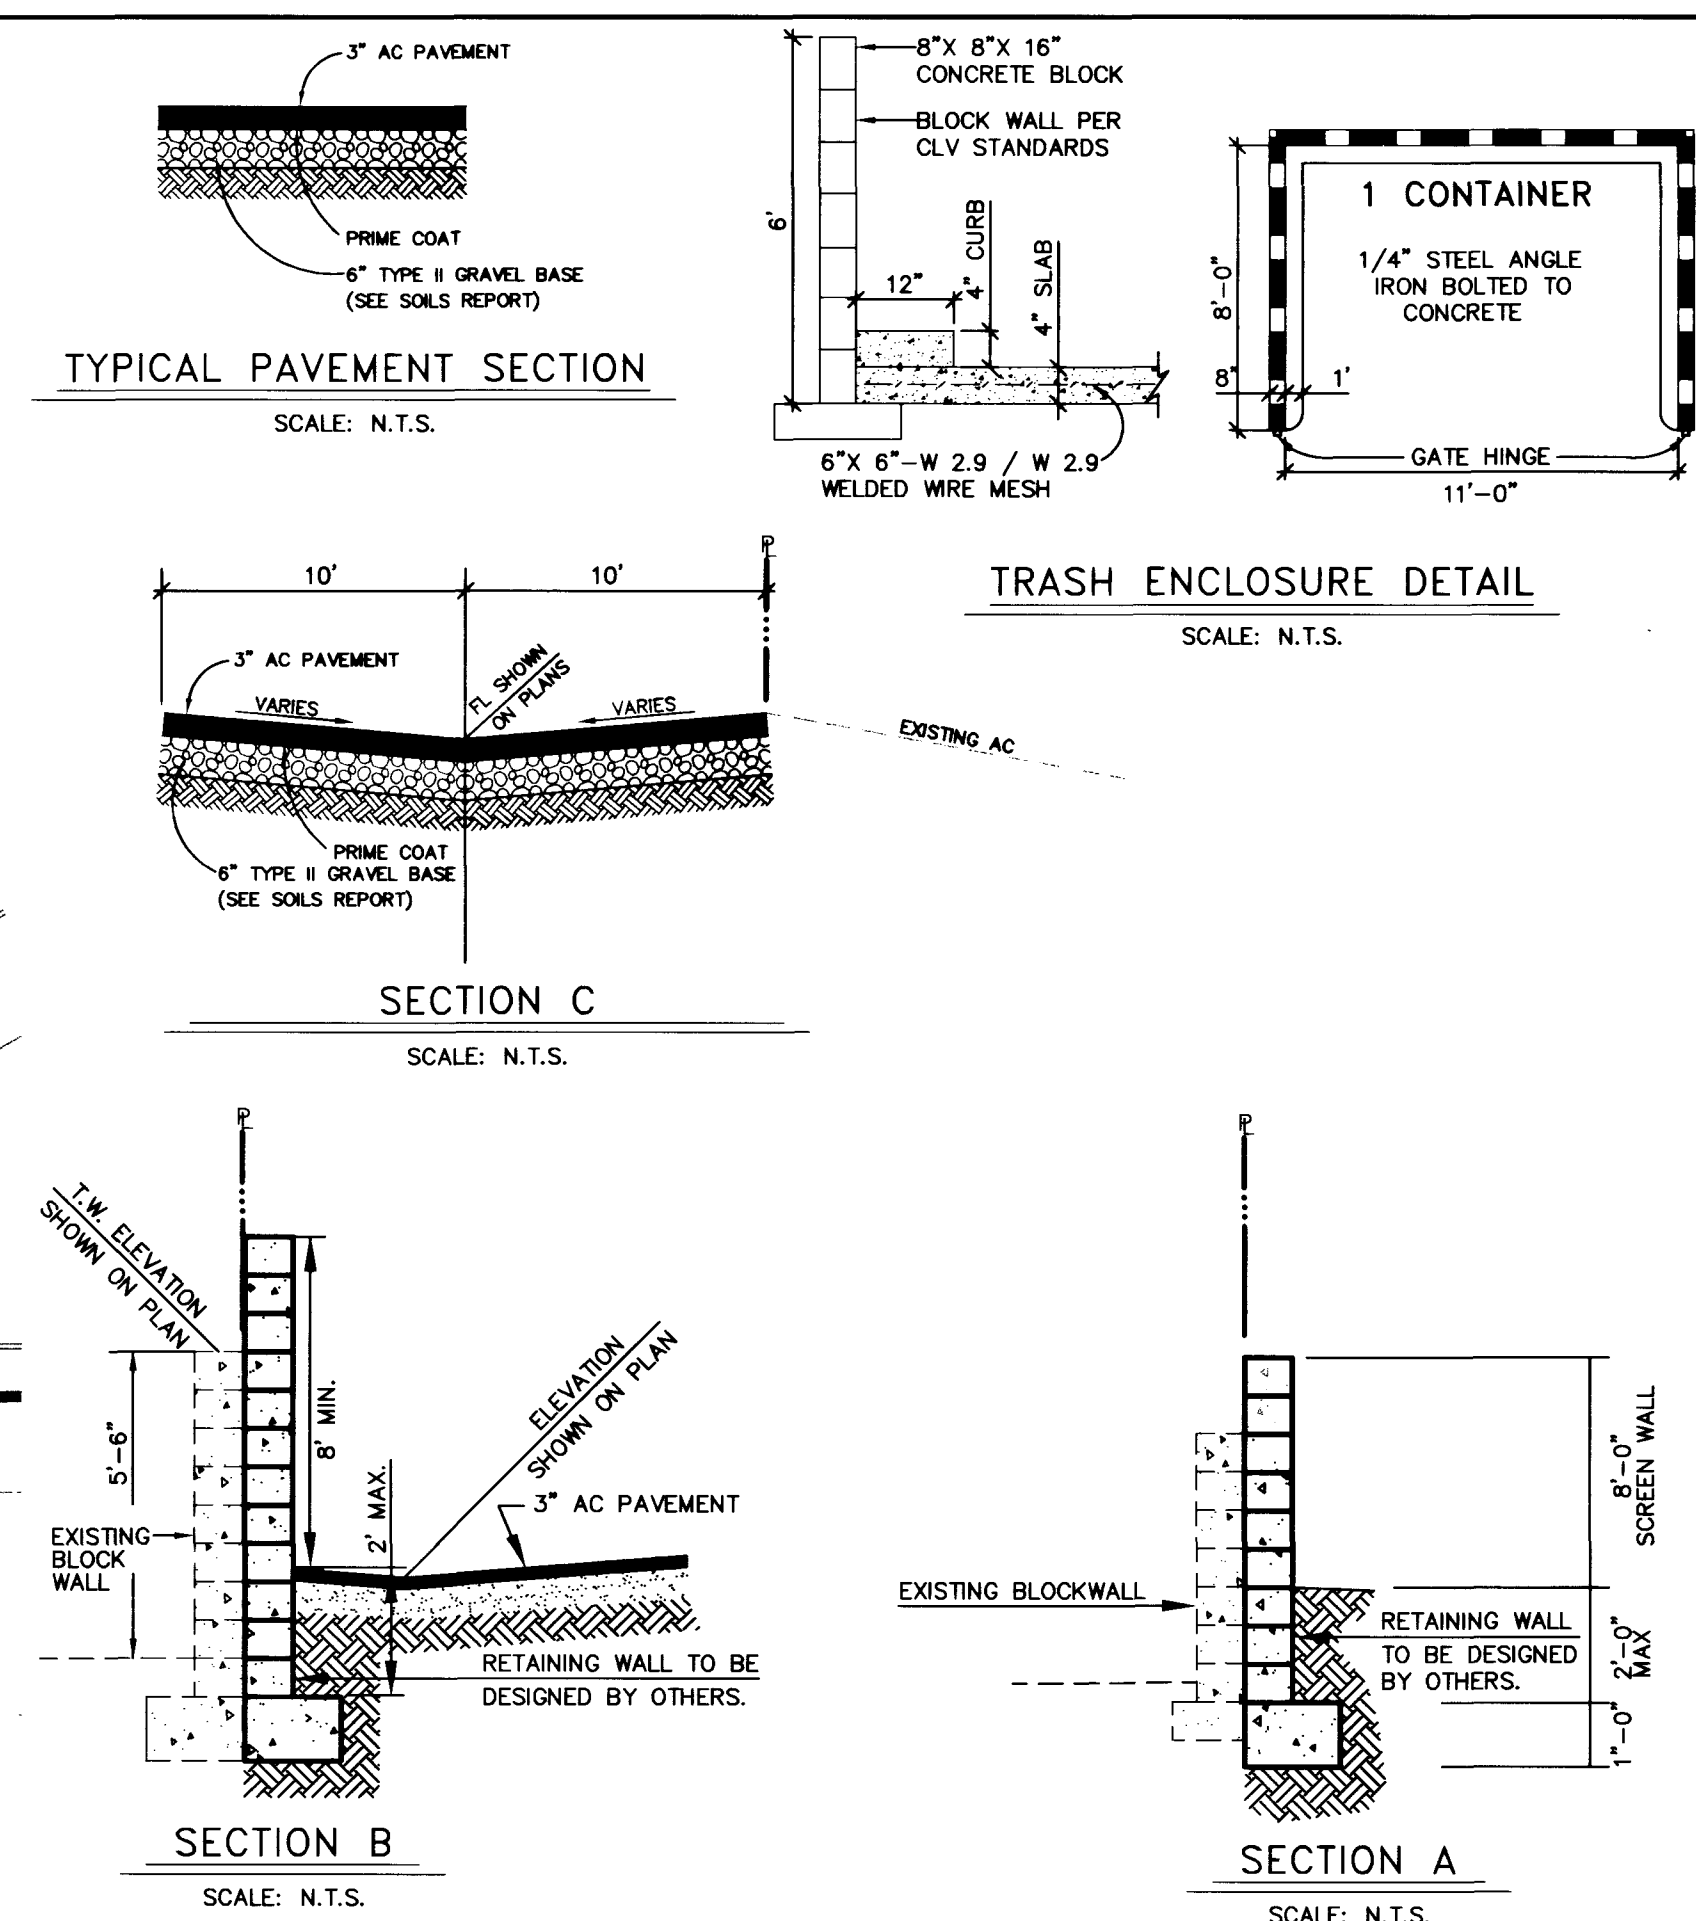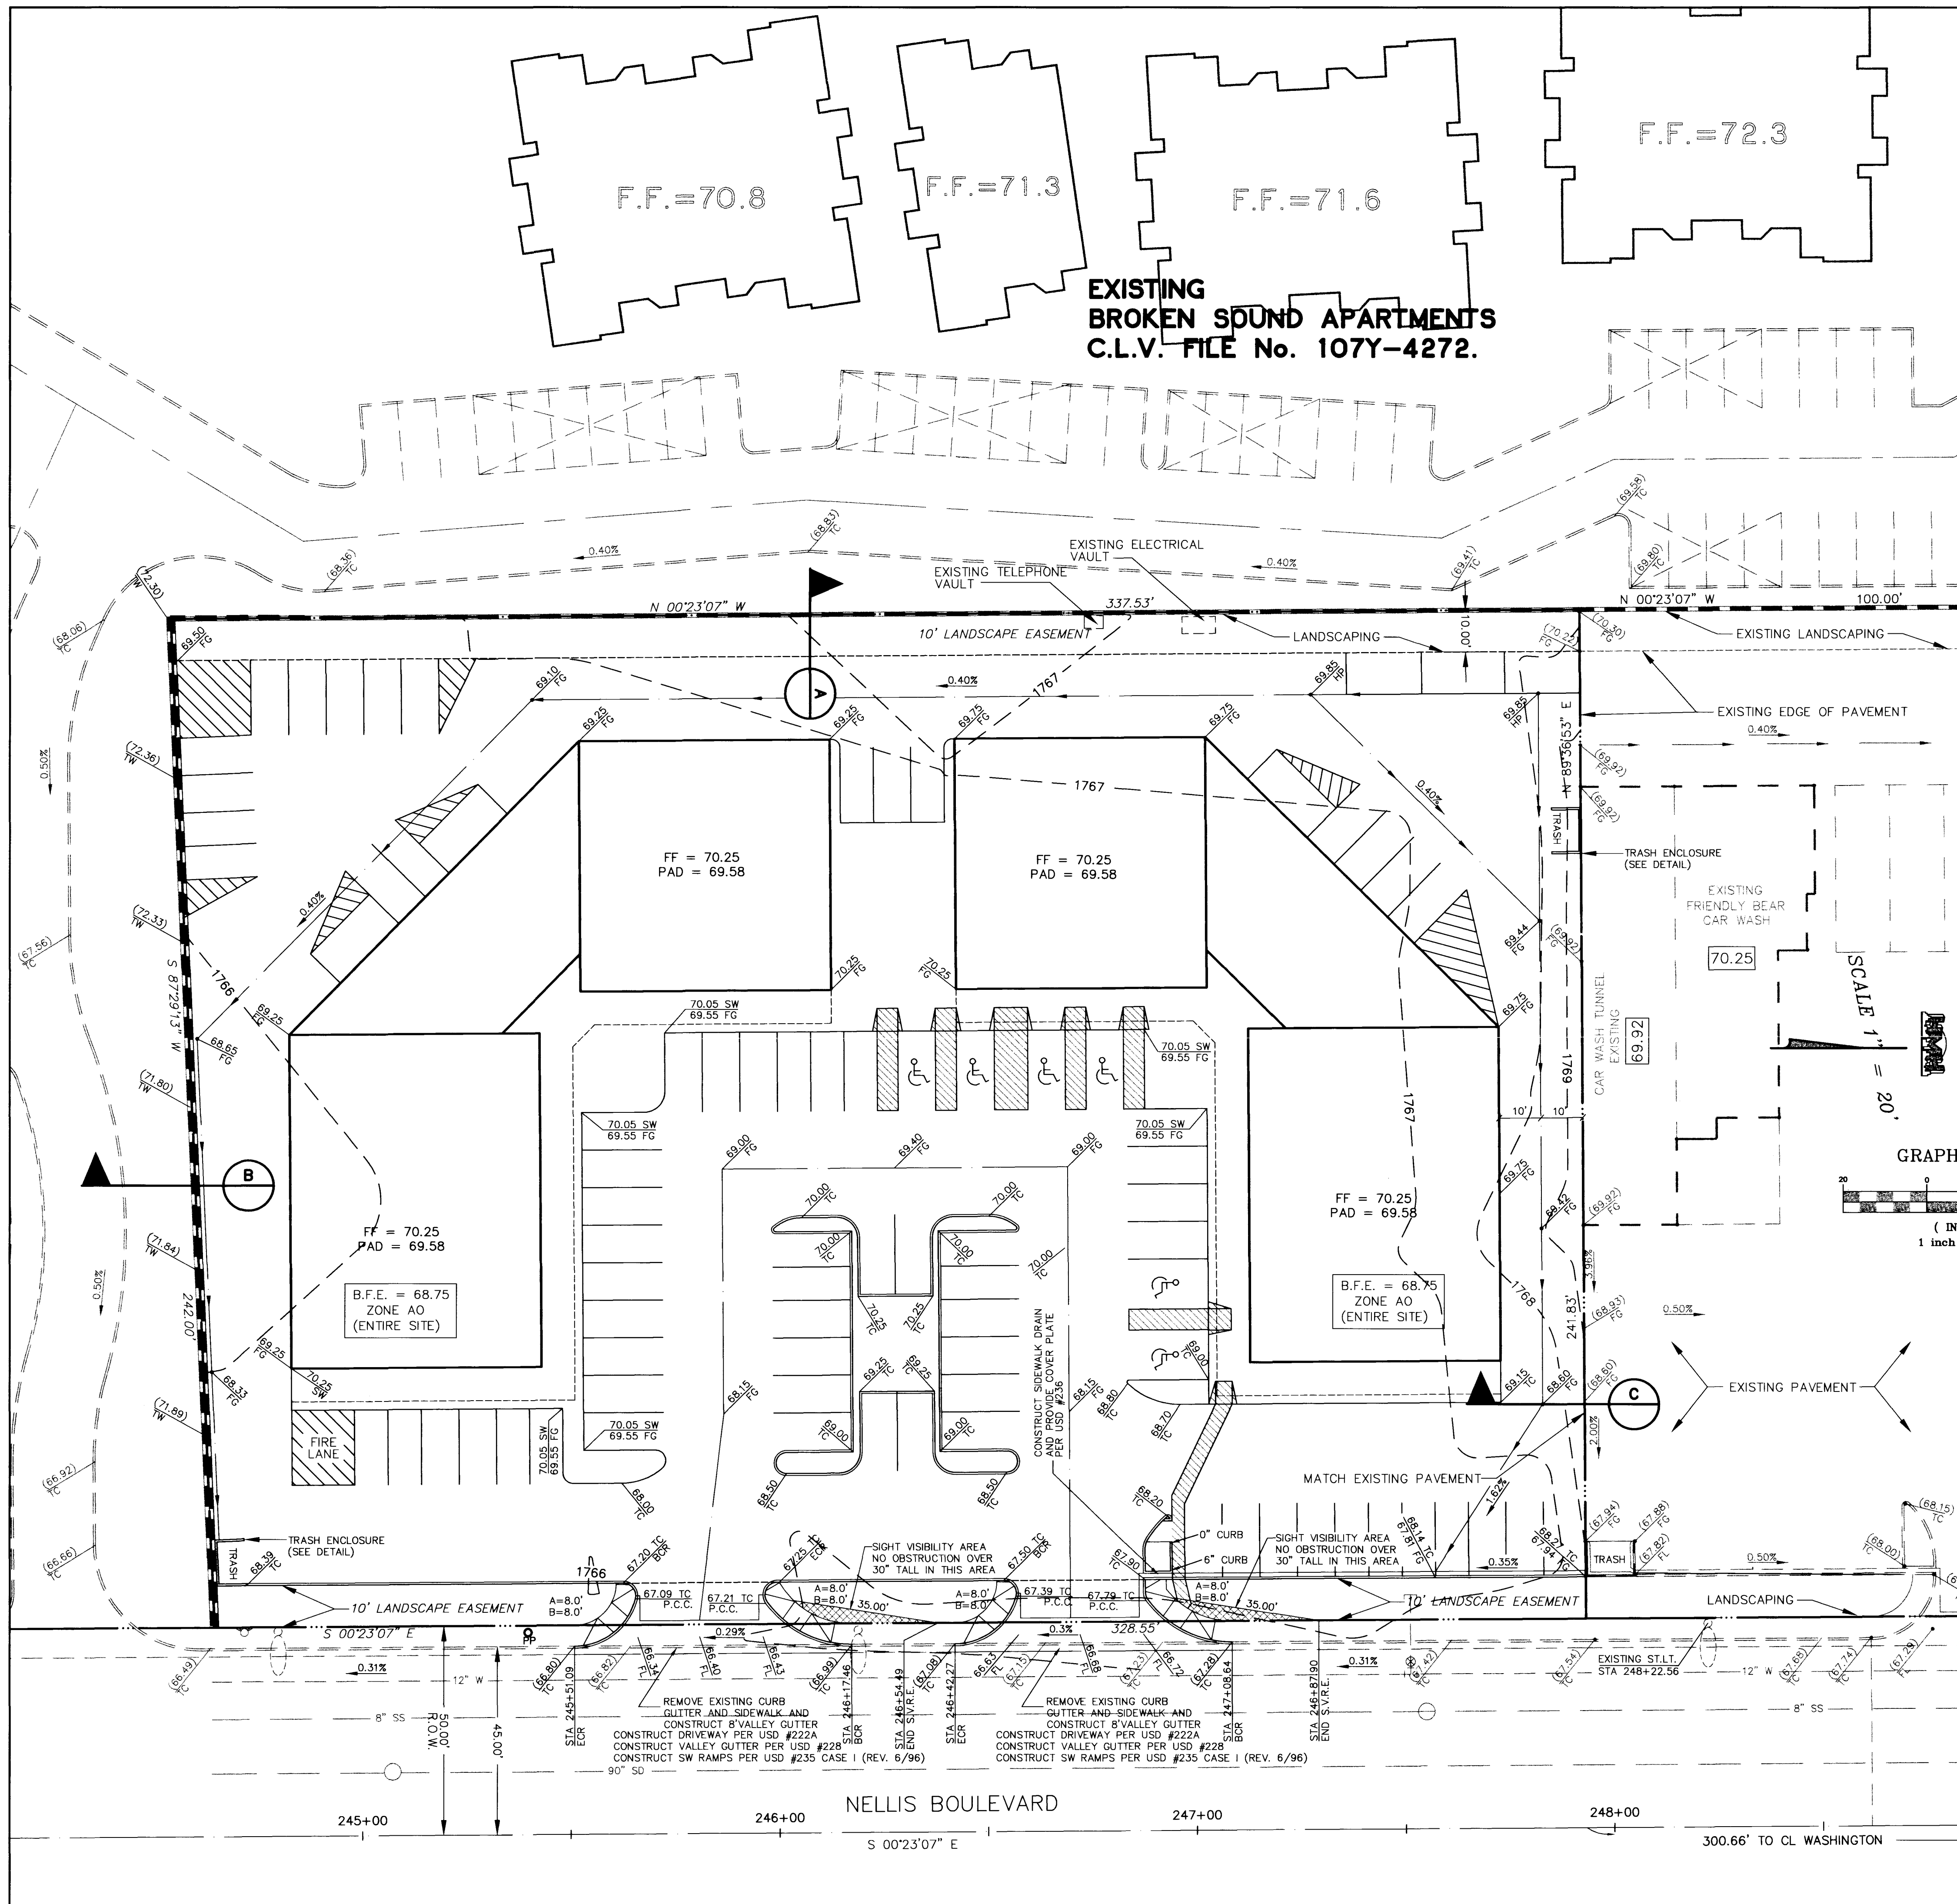

DRAINAGE CERTIFICATION
I CERTIFY THAT THIS GRADING PLAN IS IN CONFORMANCE WITH THE APPROVED DRAINAGE STUDY ON FILE AT THE CITY OF LAS VEGAS FOR THIS PROJECT.
DAVID HUCKLE P.E. 5256 12-10-97
P.E. NO. DATE

