


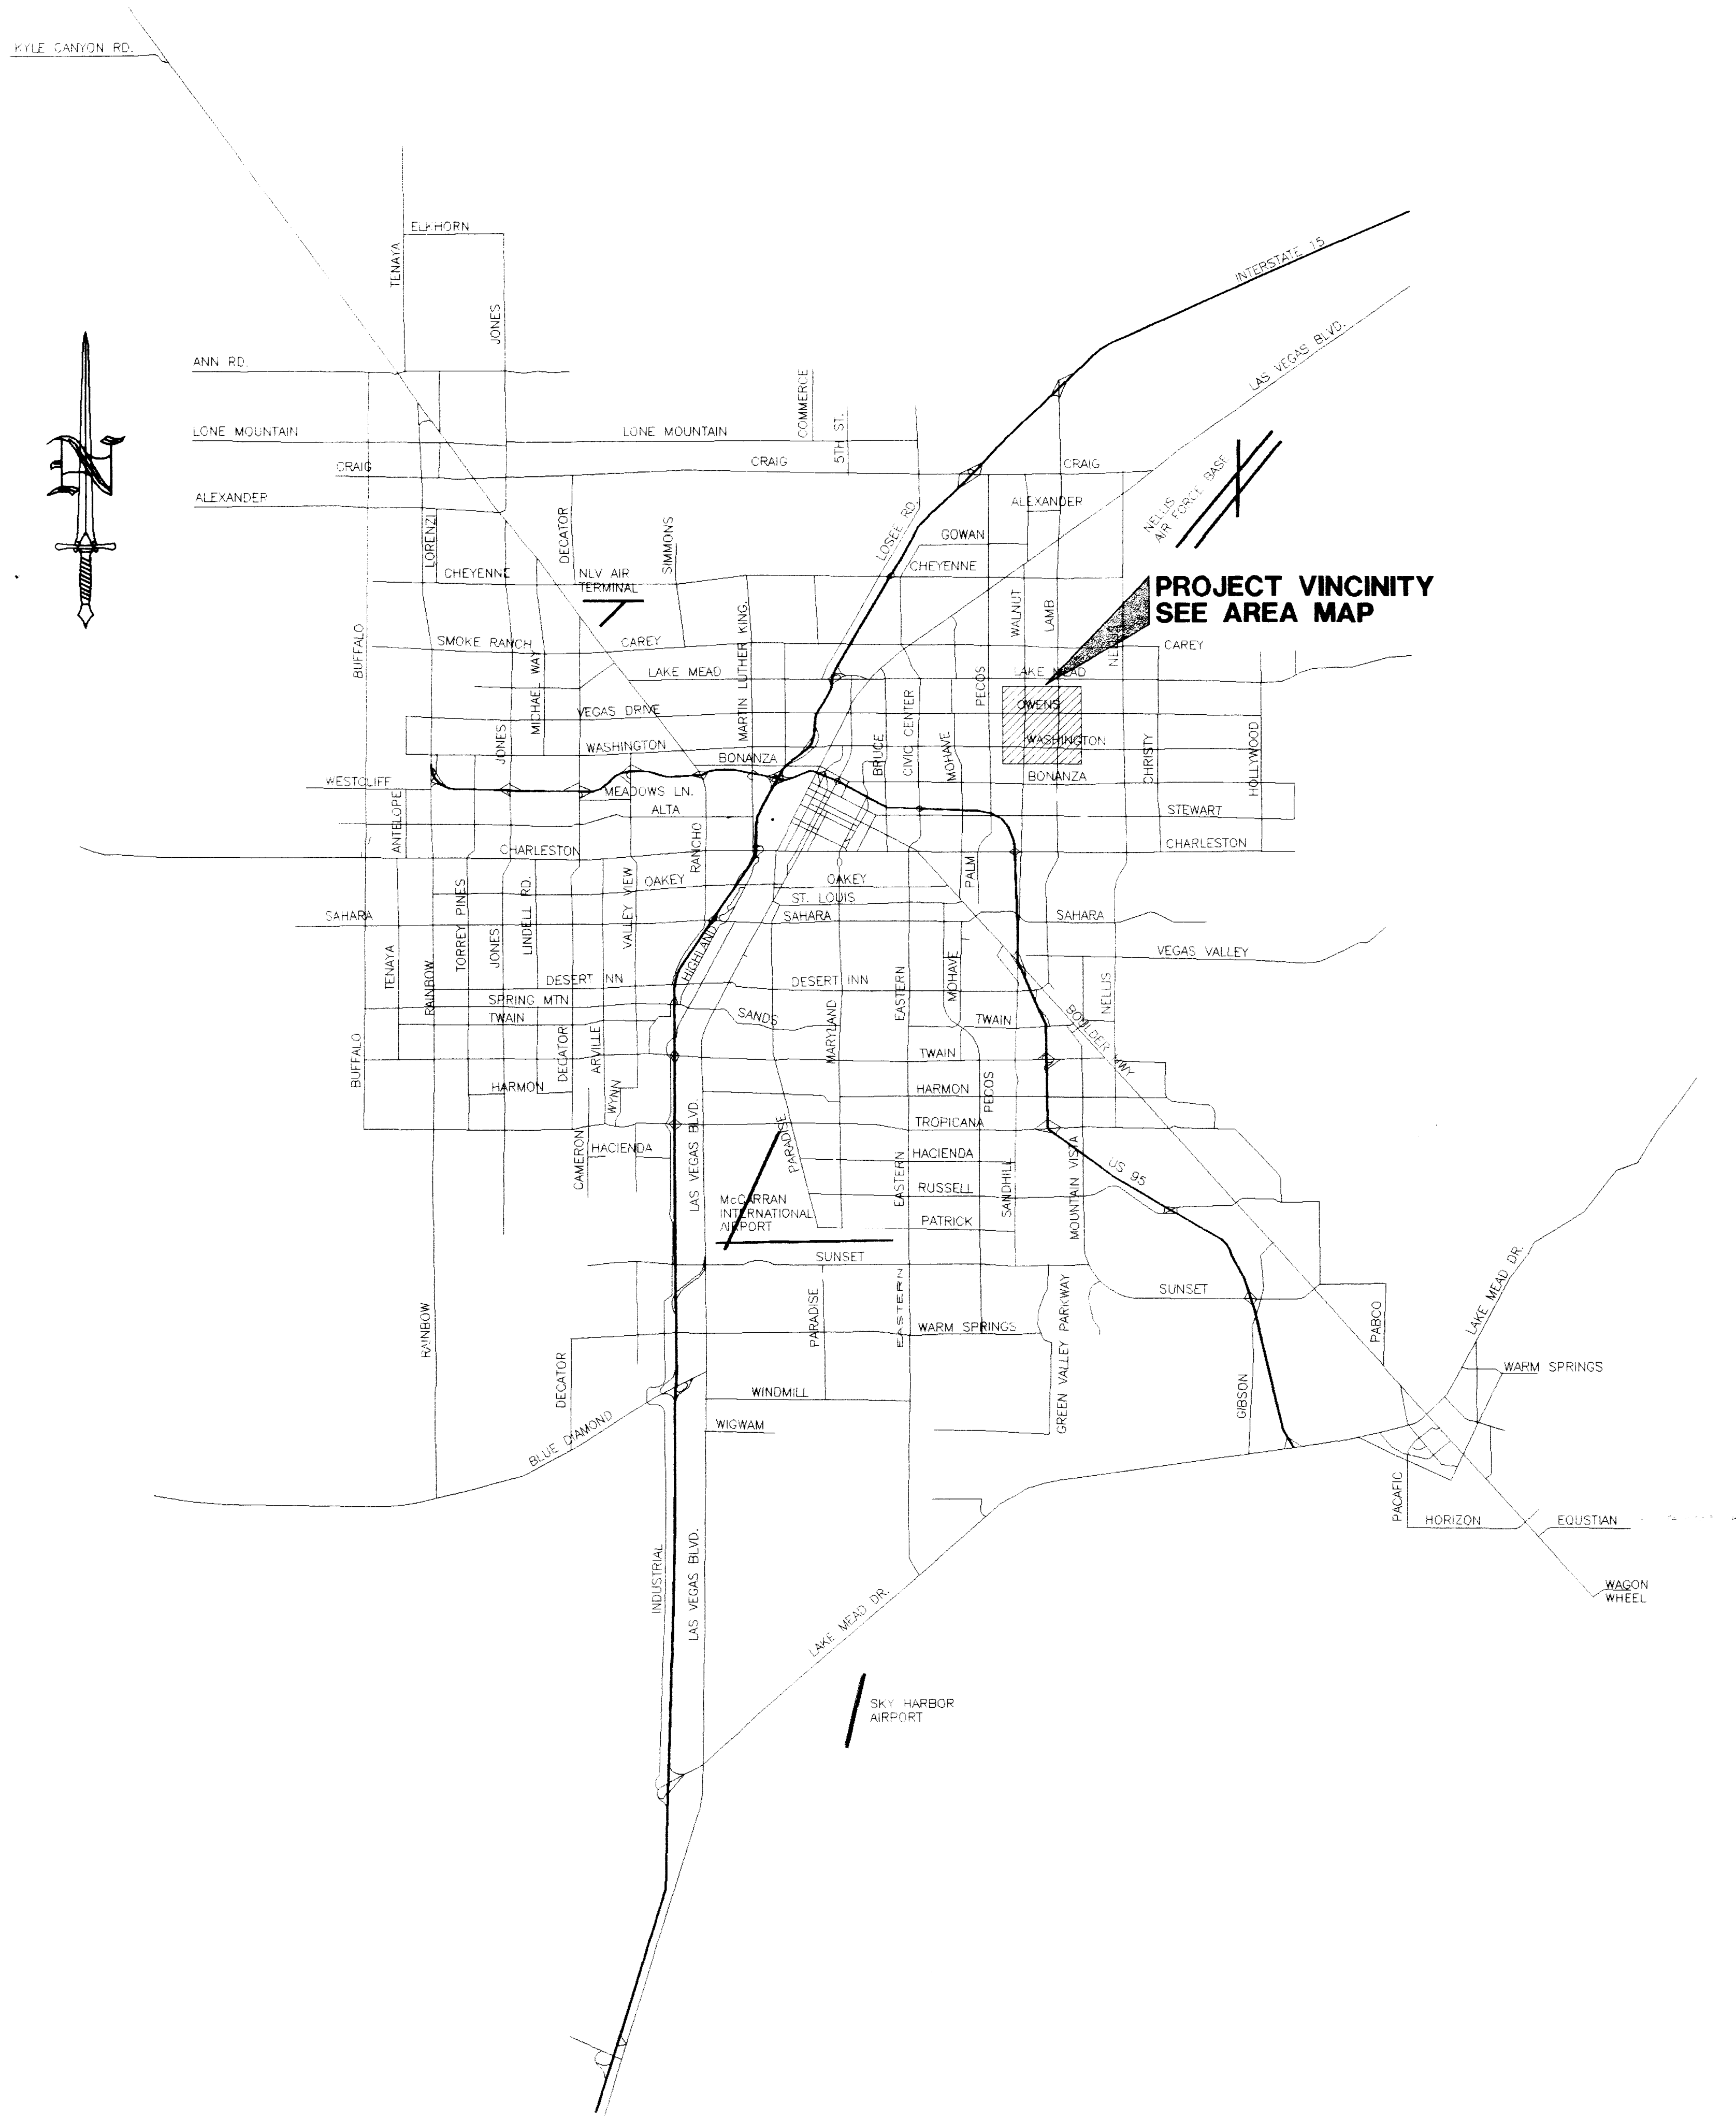

AREA MAP
SCALE: NONE

SHEET INDEX

SHEET #	SHEET	DESCRIPTION
1	C1	COVER SHEET
2	C2	VICINITY MAP
3	C3	GENERAL NOTES
4	C4	QUANTITIES AND SCHEDULES
5	C5	MASTER UTILITY PLAN
6	G1	MASTER GRADING PLAN
7	S1	STREET PLAN AND PROFILE (SANDHILL ROAD)
8	S2	STREET PLAN AND PROFILE (SWISS AVENUE)
9	S3	STREET PLAN AND PROFILE (VILLA CREST COURT) (VILLA INN COURT)
10	S4	STREET PLAN AND PROFILE (COUNTRY GARDEN AVENUE)
11	S5	TYPICAL STREET SECTIONS
12	T1	TRAFFIC SIGNALIZATION PLAN
13	TS1	SIGNAGE, STRIPING AND STREETLIGHTING PLAN
14	SS1	SANITARY SEWER PLAN AND PROFILE (SWISS AVENUE)
15	SS2	SANITARY SEWER PLAN AND PROFILE (VILLA CREST COURT) (VILLA INN COURT)
16	SS3	SANITARY SEWER PLAN AND PROFILE (COUNTRY GARDEN AVENUE)

HELLER DEVELOPMENT COMPANIES

CALIFORNIA • NEVADA
14533 Pershing Boulevard
Northridge, CA 91324 (818) 727-2856

ORION ENGINEERING AND SURVEYING, INC.

3068 E. SUNSET ROAD, SUITE 9
LAS VEGAS, NEVADA 89120
(702) 739-5921 FAX (702) 739-5929

SHEET

VICINITY MAP

TITLE

Washington & Sandhill - Unit 2

DRAWN BY:
RGP

DESIGNED BY:
RGP

CHECKED BY:
MAE

PROJECT NO:
020-8001

05.20.98

05.20.98

05.20.98

N/A

SCALE:

11-1-98

SEAL

CIVIL ENGINEER

11-1-98

1074-4556-2


SHEET

C2

2 OF 16 SHEETS

DRAWING NO.

1074-4556-2

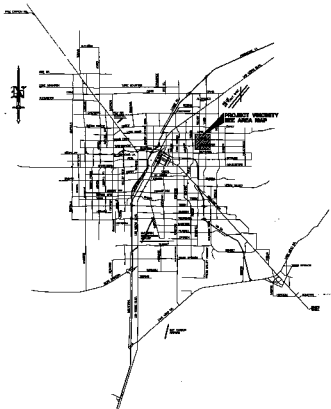

AREA MAP

WHITE AREA

TRACT #	ACRES	DESCRIPTION
1	41	WHITE AREA
2	13	WHITE AREA
3	13	WHITE AREA
4	40	WHITE AREA
5	41	WHITE AREA
6	41	WHITE AREA
7	41	WHITE AREA
100	41	WHITE AREA