


W. COLEMAN/SEA/155-4409-1,2 11-23-94 14 24 36 1995 Driver: T. J. P. (P) 155-4409-1,2 11-23-94 14 24 36 1995 HP DesignJet 650C C:\MAD12\DR\155-4409-1,2 11-23-94 14 24 36 1995

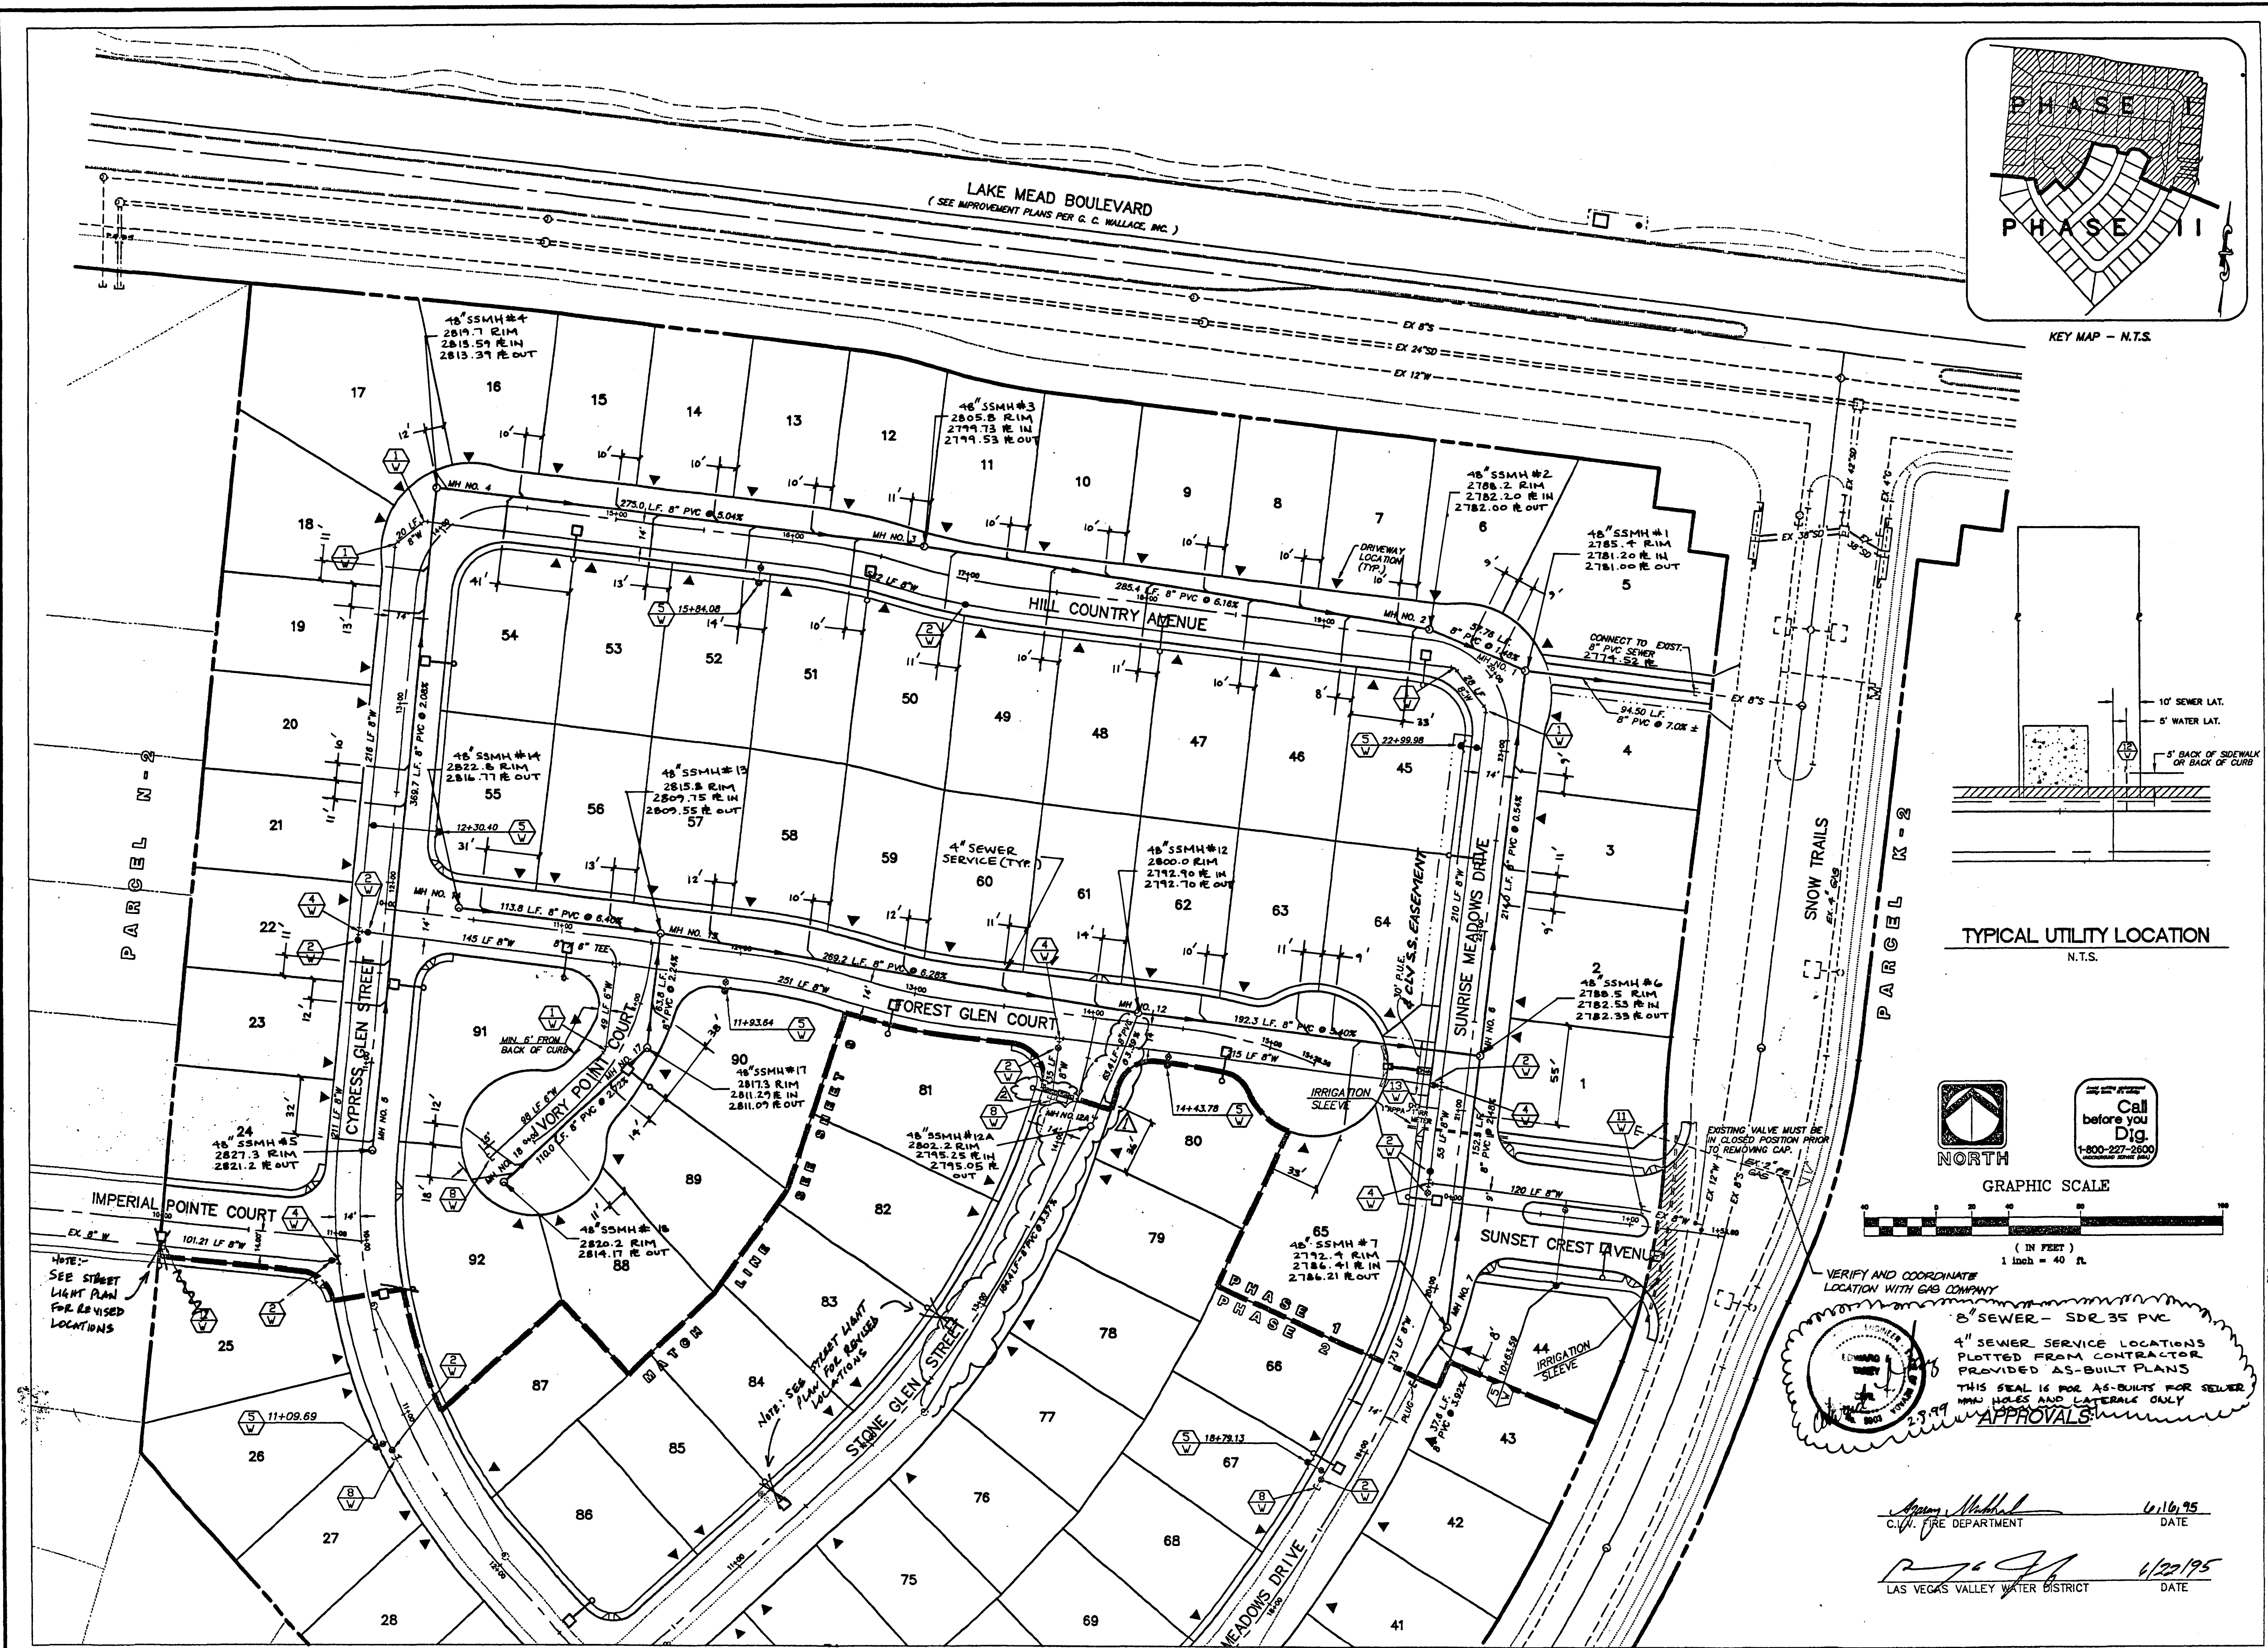

NO.	DATE	DESCRIPTION	REV.	DATE	APPROVAL
1	11/23/94	REVISED SEWER STATION LOCATION PER FIELD AS-BUILT	1	11/23/94	AS
2	1/22/95	ADD MANHOLE NO. 12A	2	1/22/95	AS
3	6/16/95	RELOCATE ST-LT TO DT 8	3	6/16/95	AS

ENGINEER: THE KEITH COMPANIES, NEVADA
PLANNING: CIVIL ENGINEERING, ENVIRONMENTAL SERVICES, LAND SURVEYING, DEVELOPER SERVICES, PUBLIC WORKS, WATER RESOURCES
4055 ROUTE INDUSTRIAL ROAD, LAS VEGAS, NV 89103 (702) 795-8650 FAX (702) 795-8650

COLEMAN HOMES
SUNSET CREST - PARCEL M-2
PHASE I
MASTER UTILITY PLAN
AsBuilt Sewer

SHEET NO.: MU-2
8 OF 17 SHEETS

11-23-94 "AsBuilt" 307Y-4409-1,2

