
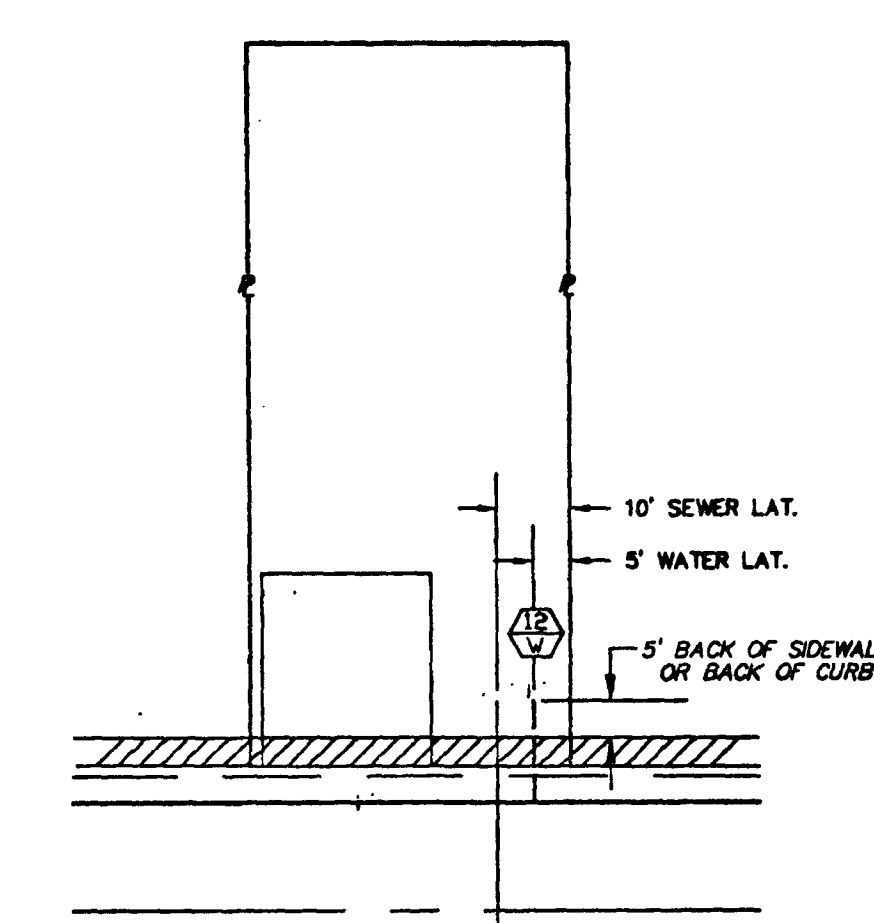
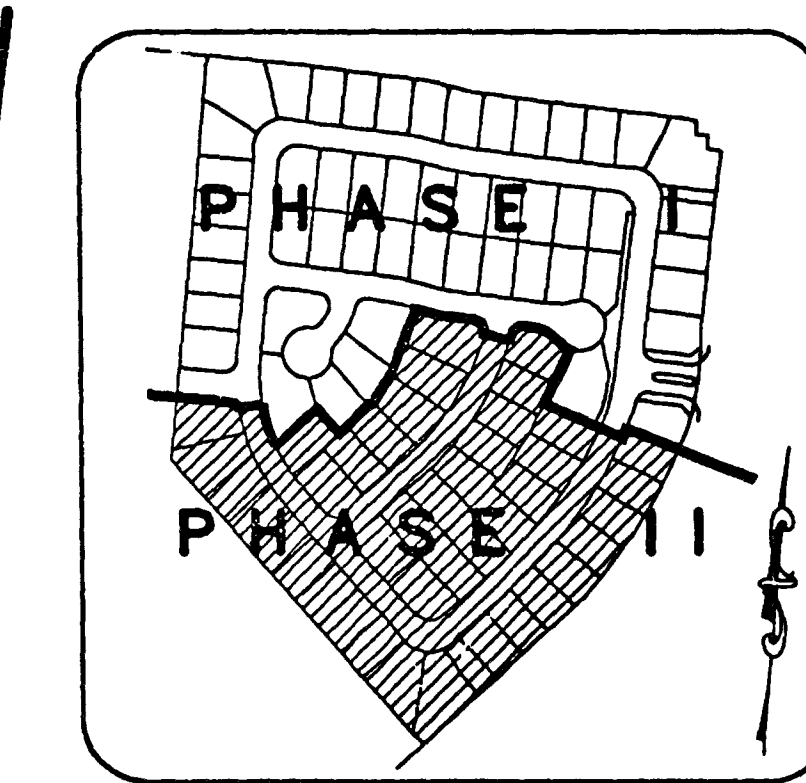


K:\COLEMAN\541\541003 Thu Jun 22 15:11:39 1995 Driver: t:\pdp\standard.cfig pc=4806601
HP DesignJet 650C C:\MCAD\2\DRW\HPGL2\STANDARD.CFG !! HP-BL/2 ADI 4.2 Ver 1.3 by Hewlett-Packard

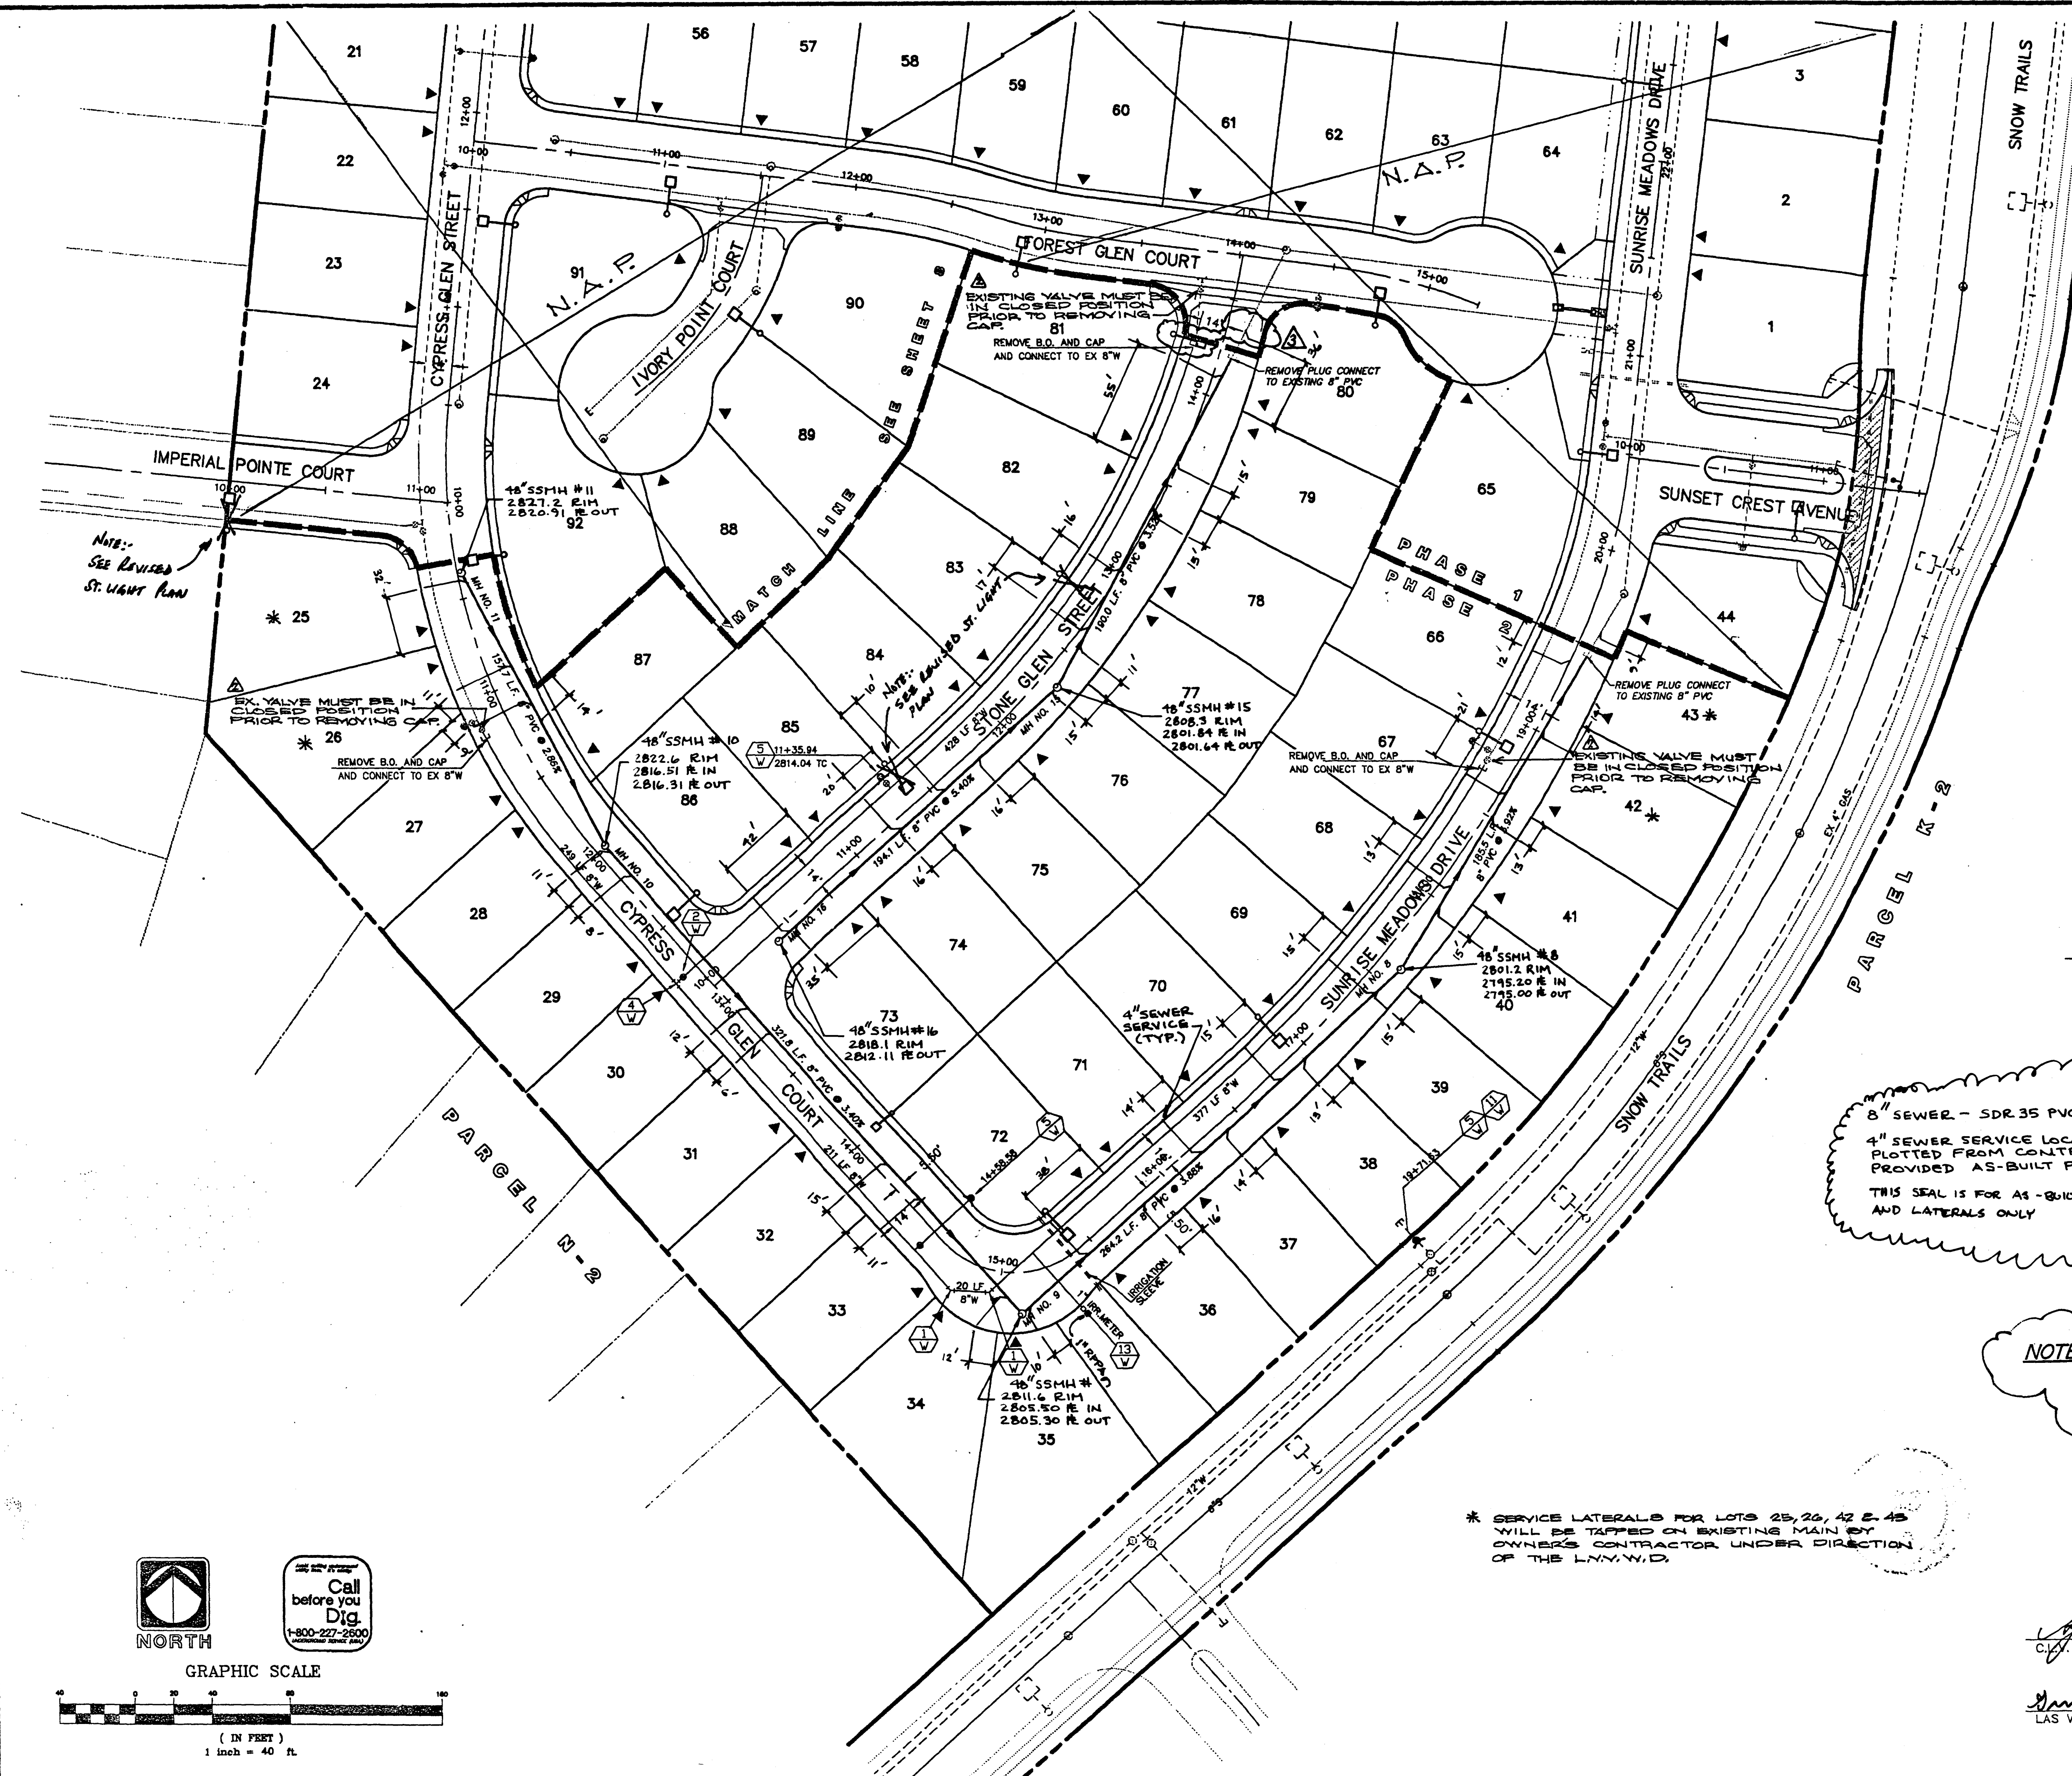

8" SEWER - SDR 35 PVC
4" SEWER SERVICE LOCATIONS
PLOTTED FROM CONTRACTOR
PROVIDED AS-BUILT PLANS.
THIS SEAL IS FOR AS-BUILTS FOR SEWER MAN HOLES
AND LATERALS ONLY

NOTE:
SEE SHEET MU-1 FOR ALL
NOTES AND QUANTITIES.

APPROVALS:

James M. Mohr 1-4-96
CITY FIRE DEPARTMENT DATE
Barney P. Rodwin 3-12-96
LAS VEGAS VALLEY WATER DISTRICT DATE

PLANNING	CIVIL ENGINEERING	LAND SURVEYING	DESIGNER	DATE	REV	DATE	DESCRIPTION	APPROVAL
ENGINEER	THE KEITH COMPANIES, NEVADA	COLEMAN HOMES	SUNSET CREST - PARCEL M-2	MASTER UTILITY PLAN	PHASE II	Asbuilt Sewer		
SHEET NO.: MU-3								9 OF 17 SHEETS

11-23-55 "Asbuilt" 307Y-4409-1,2

