
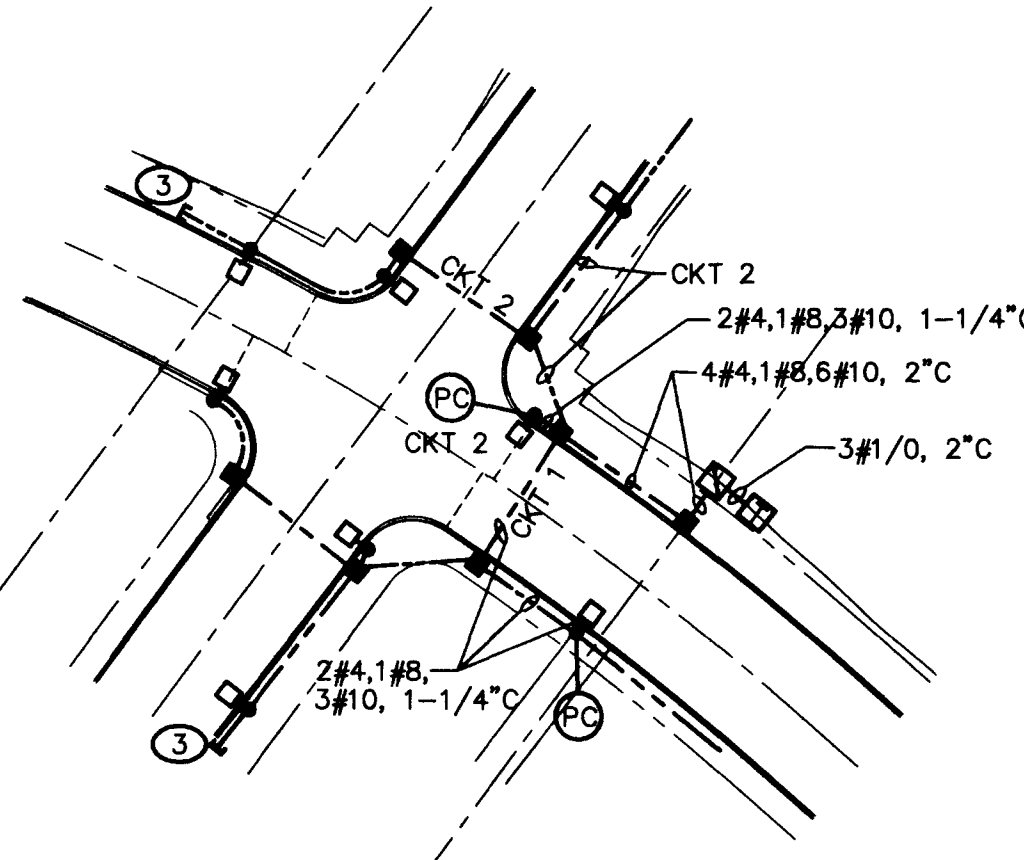


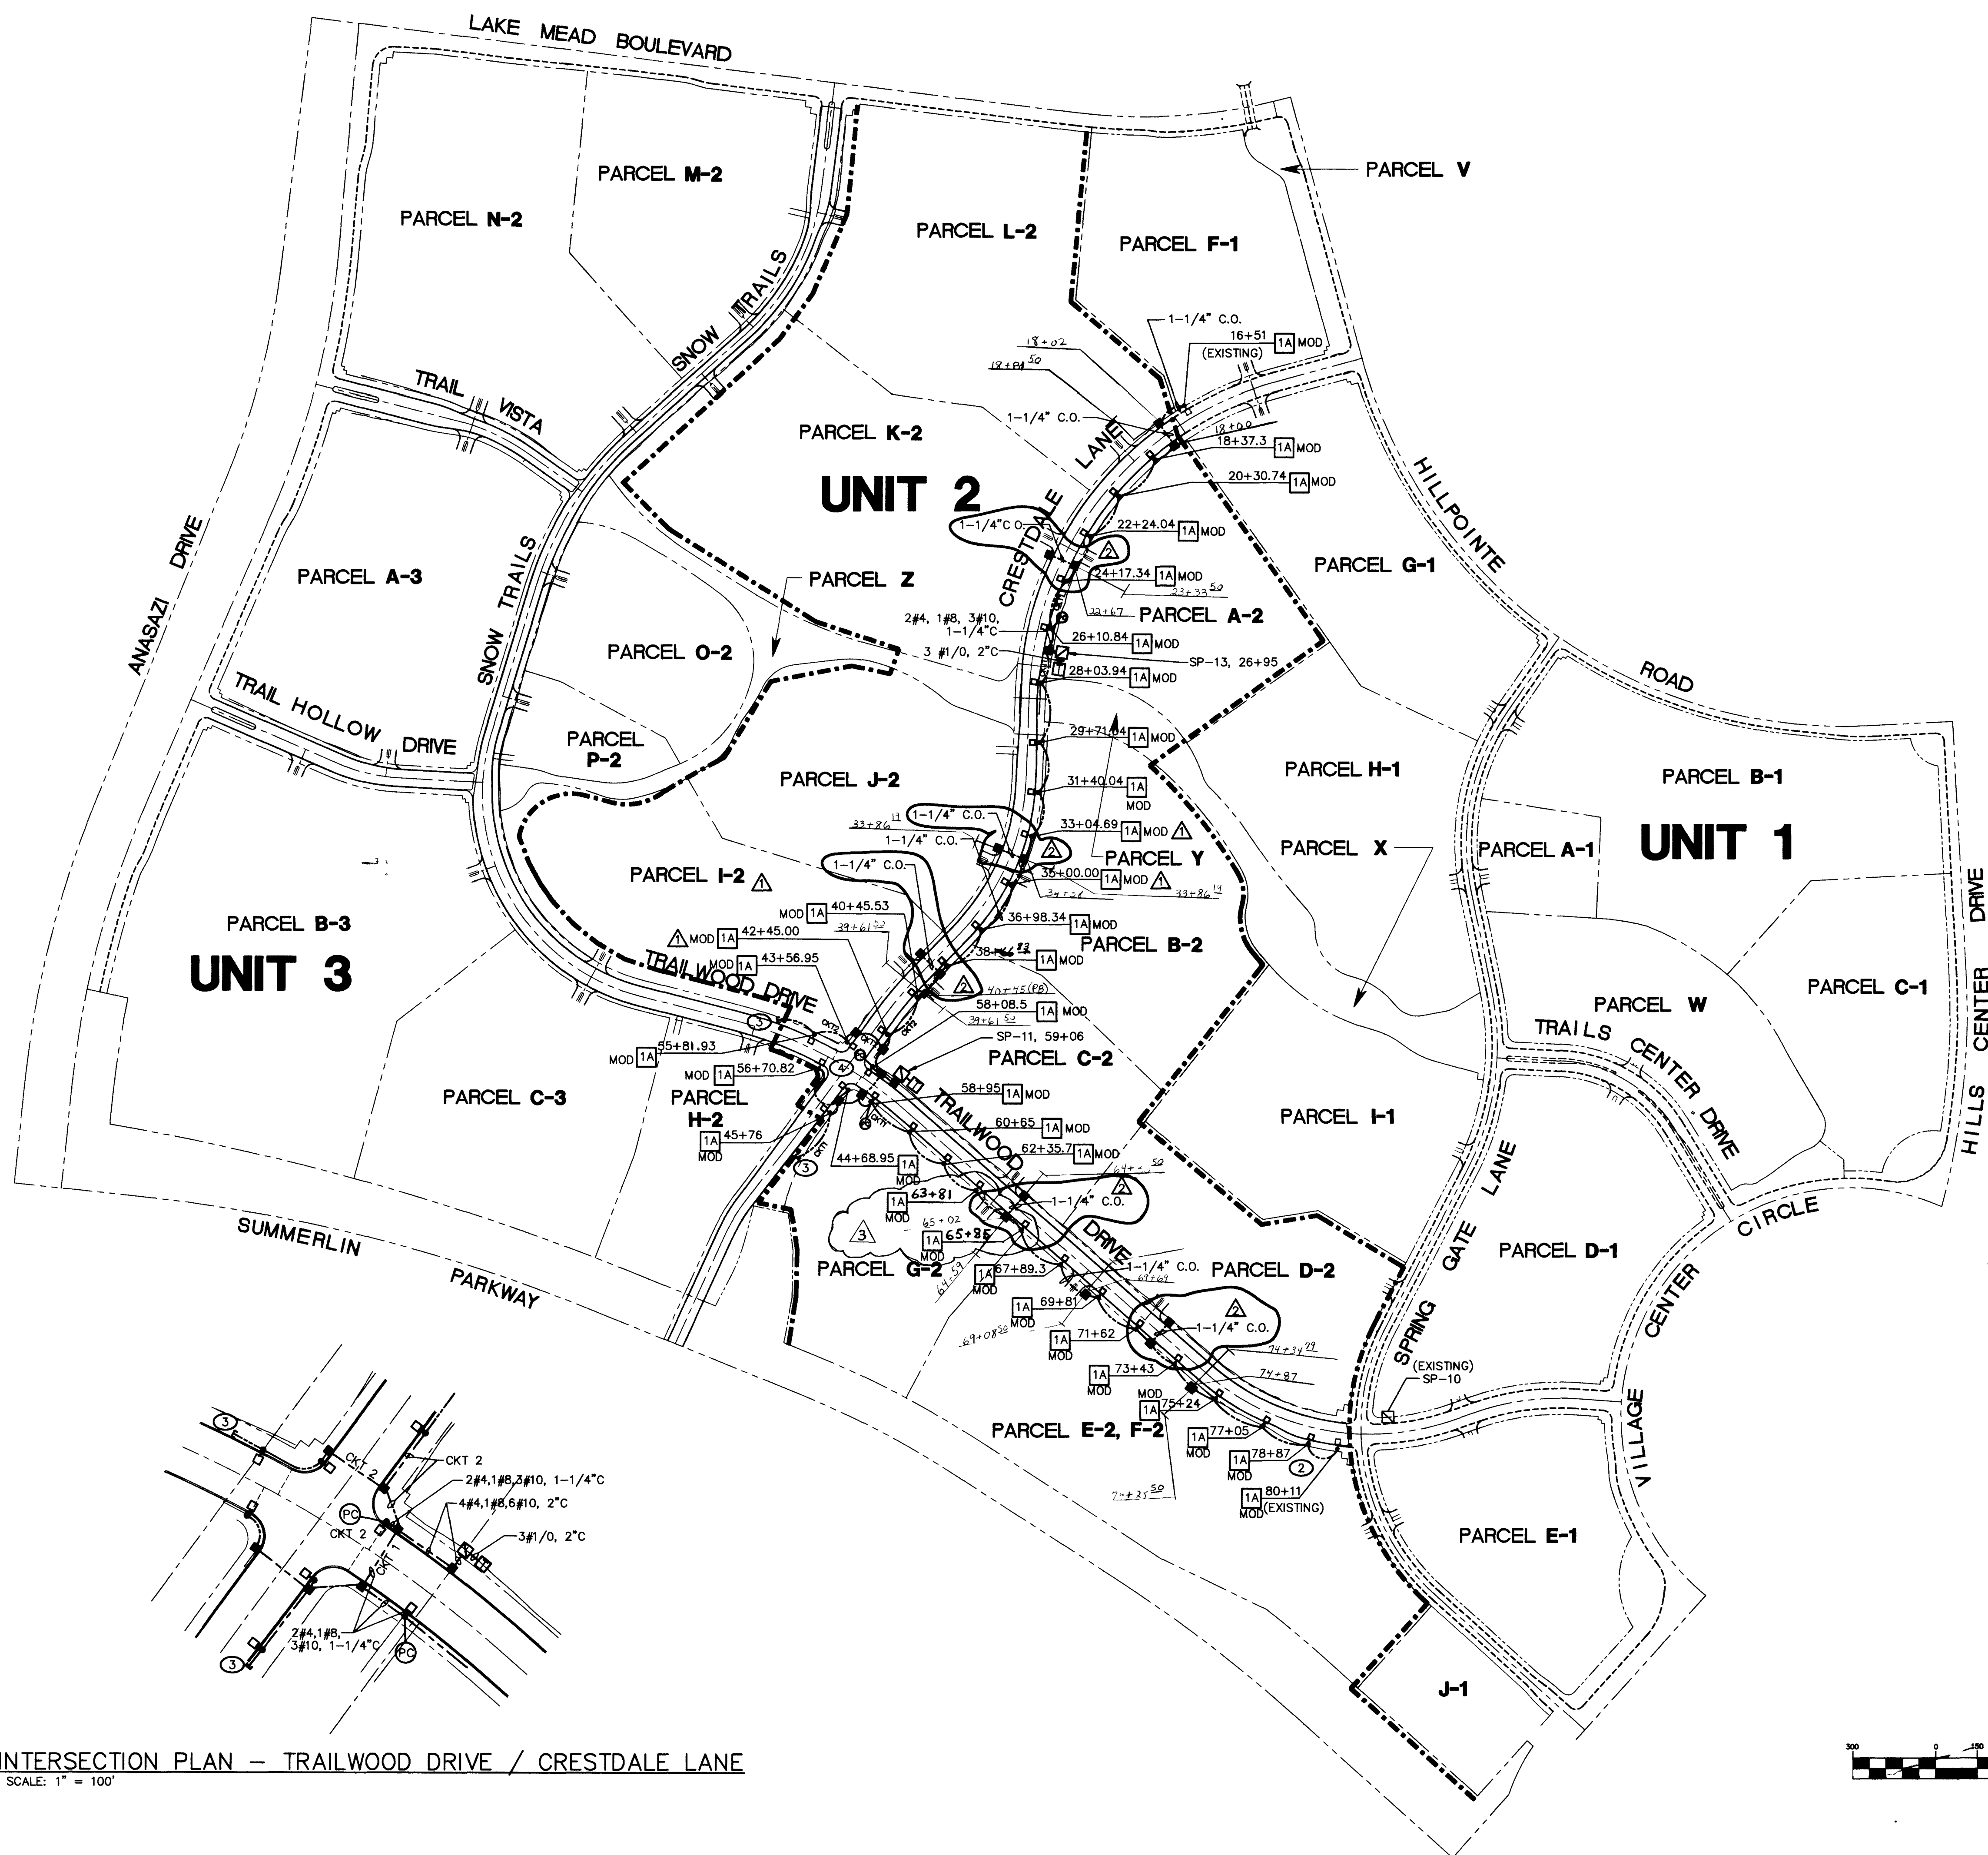

1 INTERSECTION PLAN - TRAILWOOD DRIVE / CRESDALE LANE
SL-1 SCALE: 1" = 100'

LEGEND

- TRANSFORMER
- METERED SERVICE PEDESTAL
- 1-1/4" CONDUIT WITH 2#4, 1#8 UNLESS NOTED OTHERWISE
- STREET LIGHT
- PULLBOX SIZE 3-1/2 UNLESS NOTED OTHERWISE
- CONSTRUCTION NOTE #
- REVISION
- IRRIGATION CONTROLLER
- PHOTOCELL

NOTES:


- ALL STREET LIGHTING AND CONDUIT IS 2#4, 1#8, 1-1/4" C UNLESS NOTED OTHERWISE.
- CONNECT TO EXISTING CIRCUIT. SEE PANEL SCHEDULE.
- STUB OUT CONDUIT FOR FUTURE STREETLIGHTS IN PHASE 3.
- SEE DETAIL 1 FOR CONDUIT AND WIRING IN INTERSECTION.
- FIXTURE TYPE 1A-MOD IS A GARDCO CAT. EH1913-400HPS-240-BRALF WITH CUSTOM HOUSE-SIDE SHIELD.

STREET CLASSIFICATIONS

- CRESDALE LANE NEIGHBORHOOD COLLECTOR LEVEL 2 72' BOC
- TRAILWOOD DRIVE NEIGHBORHOOD COLLECTOR LEVEL 2 72' BOC

APPROVALS

D.C. 9-28-94 CITY ENGINEER DENNIS ANDERSON DATE
9-21-94 SUMMERLIN DESIGN REVIEW COMMITTEE DATE
Curt Lambert 9-16-94 NEVADA POWER COMPANY DATE

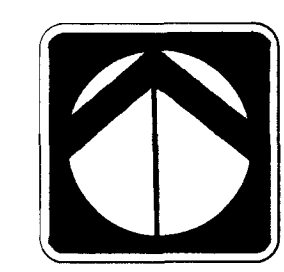

GRAPHIC SCALE
(IN FEET)
1 inch = 300 ft.

REV	DATE	DESCRIPTION
A	8-29-94	FIXTURE RELOCATION
A	8-8-94	ADD PULLBOX AT FUTURE ENTRIES
A	10-14-94	CONTRACTOR A-CALLS
A	12-29-94	PER LETTER DATED 8-16-94-D.C. 1-2

TJKROB CONSULTING ENGINEERS, INC.
1919 S. JONES BLVD. SUITE 8
LAS VEGAS, NEVADA 89102
(702) 871-5821
ELECTRICAL ENGINEERING

SHEET TITLE: **ELECTRICAL SITE PLAN**
PROJECT: **HOWARD HUGHES PROPERTIES SUMMERLIN VILLAGE 7 - THE TRAILS UNIT 2**

JOB NUMBER: 3116/SITE2B
DATE: 5-12-94
DRAWN BY: DSN/BJK
CHECKED BY: TOM KROB
RECOMMENDED:

DATE: 8-31-94
SHEET: **SL-1**
9 OF 48

RECORD DRAWING
RECORD INFORMATION PROVIDED BY FIELD CONTRACTOR

11-2-68 2074-4291-2

