
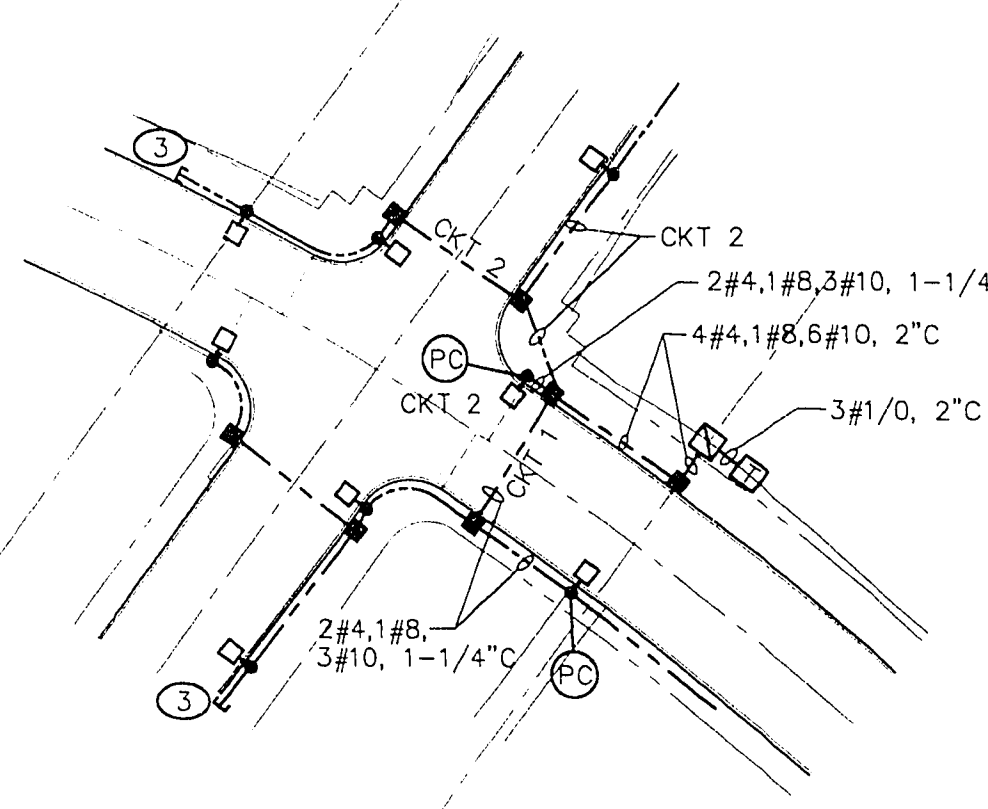


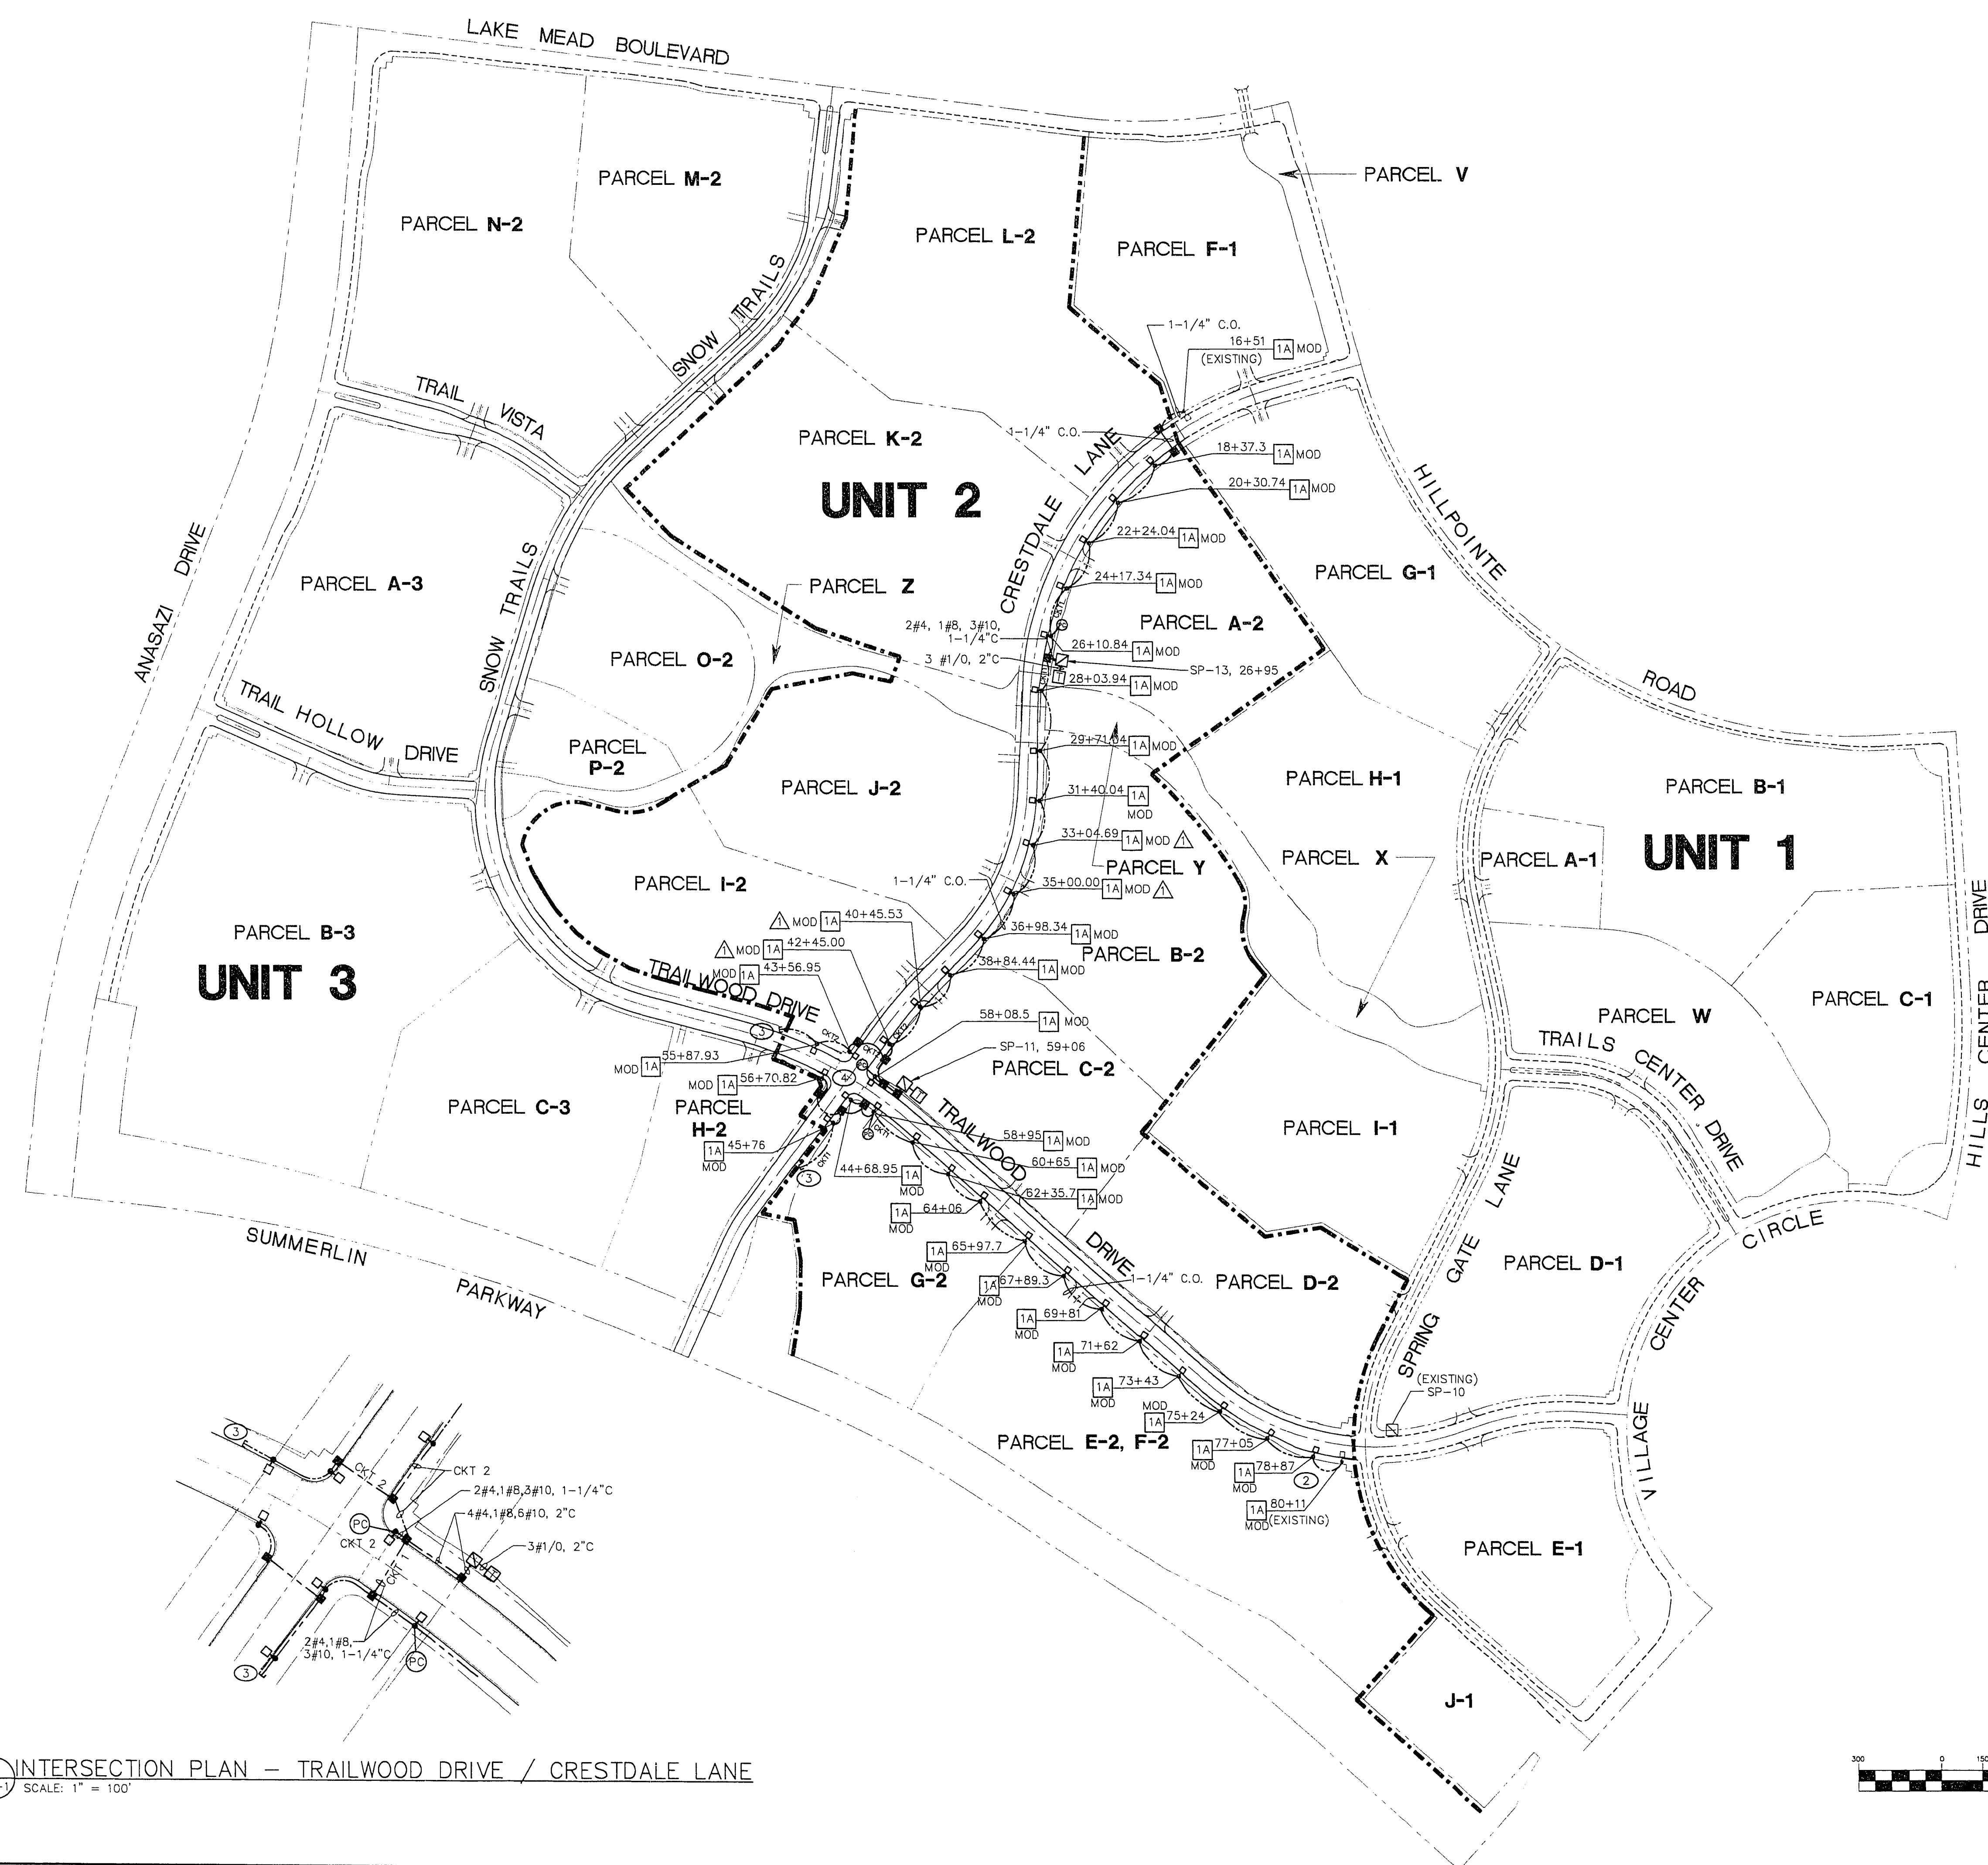

LEGEND

- TRANSFORMER
- METERED SERVICE PEDESTAL
- 1-1/4" CONDUIT WITH 2#4, 1#8 UNLESS NOTED OTHERWISE
- STREET LIGHT
- PULLBOX SIZE 3-1/2 UNLESS NOTED OTHERWISE
- CONSTRUCTION NOTE #
- REVISION
- IRRIGATION CONTROLLER
- PHOTOCELL

NOTES:

- ALL STREET LIGHTING AND CONDUIT IS 2#4, 1#8, 1-1/4" UNLESS NOTED OTHERWISE.
- CONNECT TO EXISTING CIRCUIT. SEE PANEL SCHEDULE.
- STUB OUT CONDUIT FOR FUTURE STREETLIGHTS IN PHASE 3.
- SEE DETAIL 1 FOR CONDUIT AND WIRING IN INTERSECTION.
- FIXTURE TYPE 1A-MOD IS A GARDCO CAT. #H1913-400MH-240-BRALF WITH CUSTOM HOUSE-SIDE SHIELD.

STREET CLASSIFICATIONS


CRESTDALE LANE	NEIGHBORHOOD COLLECTOR LEVEL 2 72' BOC
TRAILWOOD DRIVE	NEIGHBORHOOD COLLECTOR LEVEL 2 72' BOC

APPROVALS

CITY ENGINEER DENNIS ANDERSON 7-19-94
SUMMERLIN DESIGN REVIEW COMMITTEE 7/8/94
NEVADA POWER COMPANY 7/5/94



GRAPHIC SCALE

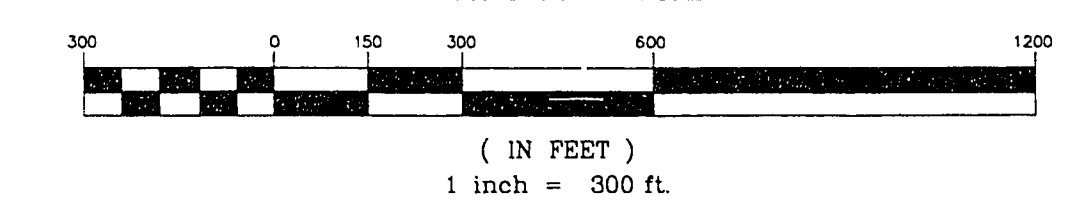

Call before you Dig
1-800-227-2600

REV	DATE	DESCRIPTION
1	6-29-94	FIXTURE RELOCATION
TJKROB CONSULTING ENGINEERS, INC. 1810 S. JONES BLVD. SUITE 8 LAS VEGAS, NEVADA 89102 (702) 871-3821 ELECTRICAL ENGINEERING		
SHEET TITLE: ELECTRICAL SITE PLAN		
PROJECT: HOWARD HUGHES PROPERTIES SUMMERLIN VILLAGE 7 - THE TRAILS UNIT 2		
JOB NUMBER: 3116/SITE2B		
DATE: 5-12-94		
DRAWN BY: DSN/BJK		
CHECKED BY: TOM KROB		
RECOMMENDED:		
DATE: 6/1/94		
SHEET: SL-1		

VOID