

2776
2772
2768
2764
2760
2756
2752
2748
2744
2740
2736

STA 75+00

SFL 2759.03

MATCH LINE
SEE SHEET SW-10

CONSTRUCTION NOTES (SEWER)

1. INSTALL 2 EA. STANDARD 4" SEWER MANHOLE PER CLARK COUNTY SANITATION DISTRICT STANDARD DRAWINGS.

2. INSTALL 490.60 L.F. 8" PVC (SDR-35) SEWER LINE.

CONSTRUCTION NOTES (WATER)

1. INSTALL 1 EA. SET 2-6" PVC AND 4-4" PVC (SDR-35) SLEEVES FOR FUTURE ELECTRICAL OR IRRIGATION PURPOSES.

GENERAL NOTES

1. PIPE LENGTHS SHOWN ARE FROM CENTERLINE OF MANHOLE TO CENTERLINE OF MANHOLE OR MATCHLINE AND ARE BASED ON LENGTHS AT CENTERLINE OF UTILITY (TYPICAL ALL SHEETS).

2. UTILITY LOCATIONS ARE BASED ON STREET CENTERLINE STATIONING.

[Signature] 6/17/94
L.V.V.W.D. DATE

RECORD DRAWING

RECORD INFORMATION PROVIDED BY FIELD CONTRACTOR

RECOMMENDED

PLANNING
ENGINEERING
LANDSCAPE ARCHITECTURE
LAND SURVEYING
CONSTRUCTION

10684
R.P.E.
DATE 6/15/94

GARY BUSBY

THE KEITH COMPANIES
NEVADA
4042 SO. INDUSTRIAL RD. LAS VEGAS, NV 89103 (702) 733-0550

ENGINEER

HOWARD HUGHES PROPERTIES
SUMMERLIN VILLAGE 7 - THE TRAILS - UNIT 2
TRAILWOOD DRIVE
PLAN AND PROFILE
STA 75+00 - STA 80+00

SHEET
SW-11
SHT 36 OF 48

Call before you Dig.
1-800-227-2600
UNDERGROUND SERVICE UTILITIES

75+00 76+00 77+00 78+00 79+00 80+00

201.22 LF 8" PVC SEWER S=0.0265

289.38 LF 8" PVC SEWER S=0.0415

SMH #2
STA 77+00
RIM= 2761.59

SMH #1
STA 79+87.61
RIM= 2750.38

IRR. SLVS.

EX. 8" PVC SEWER


8" SD LATERAL

CONNECT TO EXISTING SAN. SEWER.
CONTRACTOR TO VERIFY LOCATION OF
EXISTING SEWER PRIOR TO CONSTRUCTION.

INV. IN= 2753.70
INV. OUT= 2753.50

INV. IN= 2741.50
INV. OUT= 2741.30

PROFILE SCALE
HORIZONTAL 1" = 20'
VERTICAL 1" = 4'

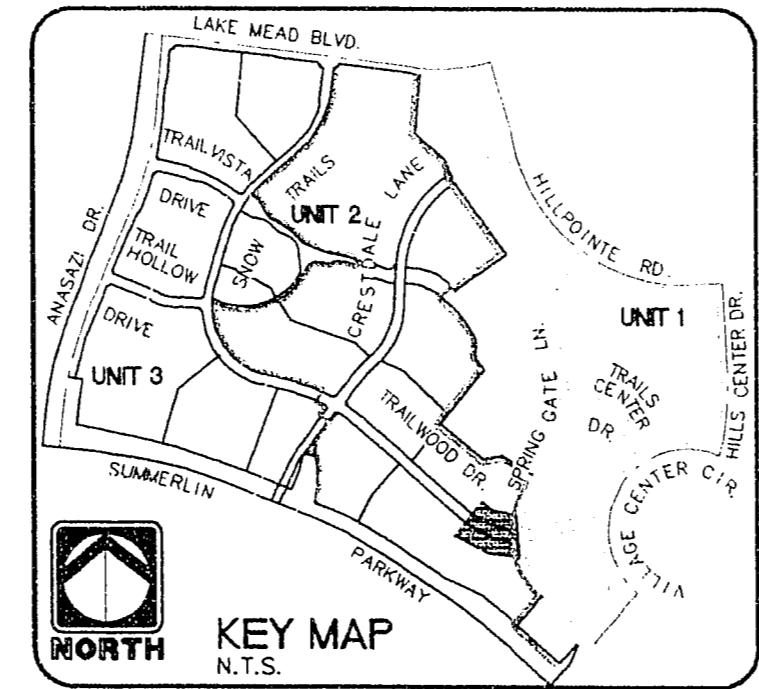

SEE SHEET SW-10
MATCH LINE

PARCEL D-2

PARCEL E-2

TRAILWOOD DRIVE


77+07.04 PRC
OFFSET 50.00 R

77+31.90 PRC
OFFSET 36.00 R

77+57.65 PRC
OFFSET 56.82 R

77+71.45 PRC
OFFSET 39.76 R

78+47.07 PRC
OFFSET 68.00 R

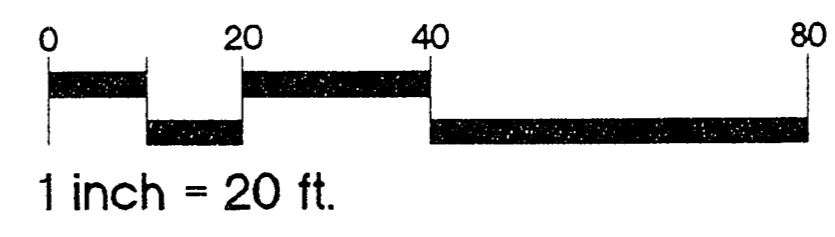

1. DATE: 6/17/94
2. DRAWN BY: [Signature]
3. CHECKED BY: [Signature]
4. APPROVED BY: [Signature]

11-2-94 3074-4271-2