
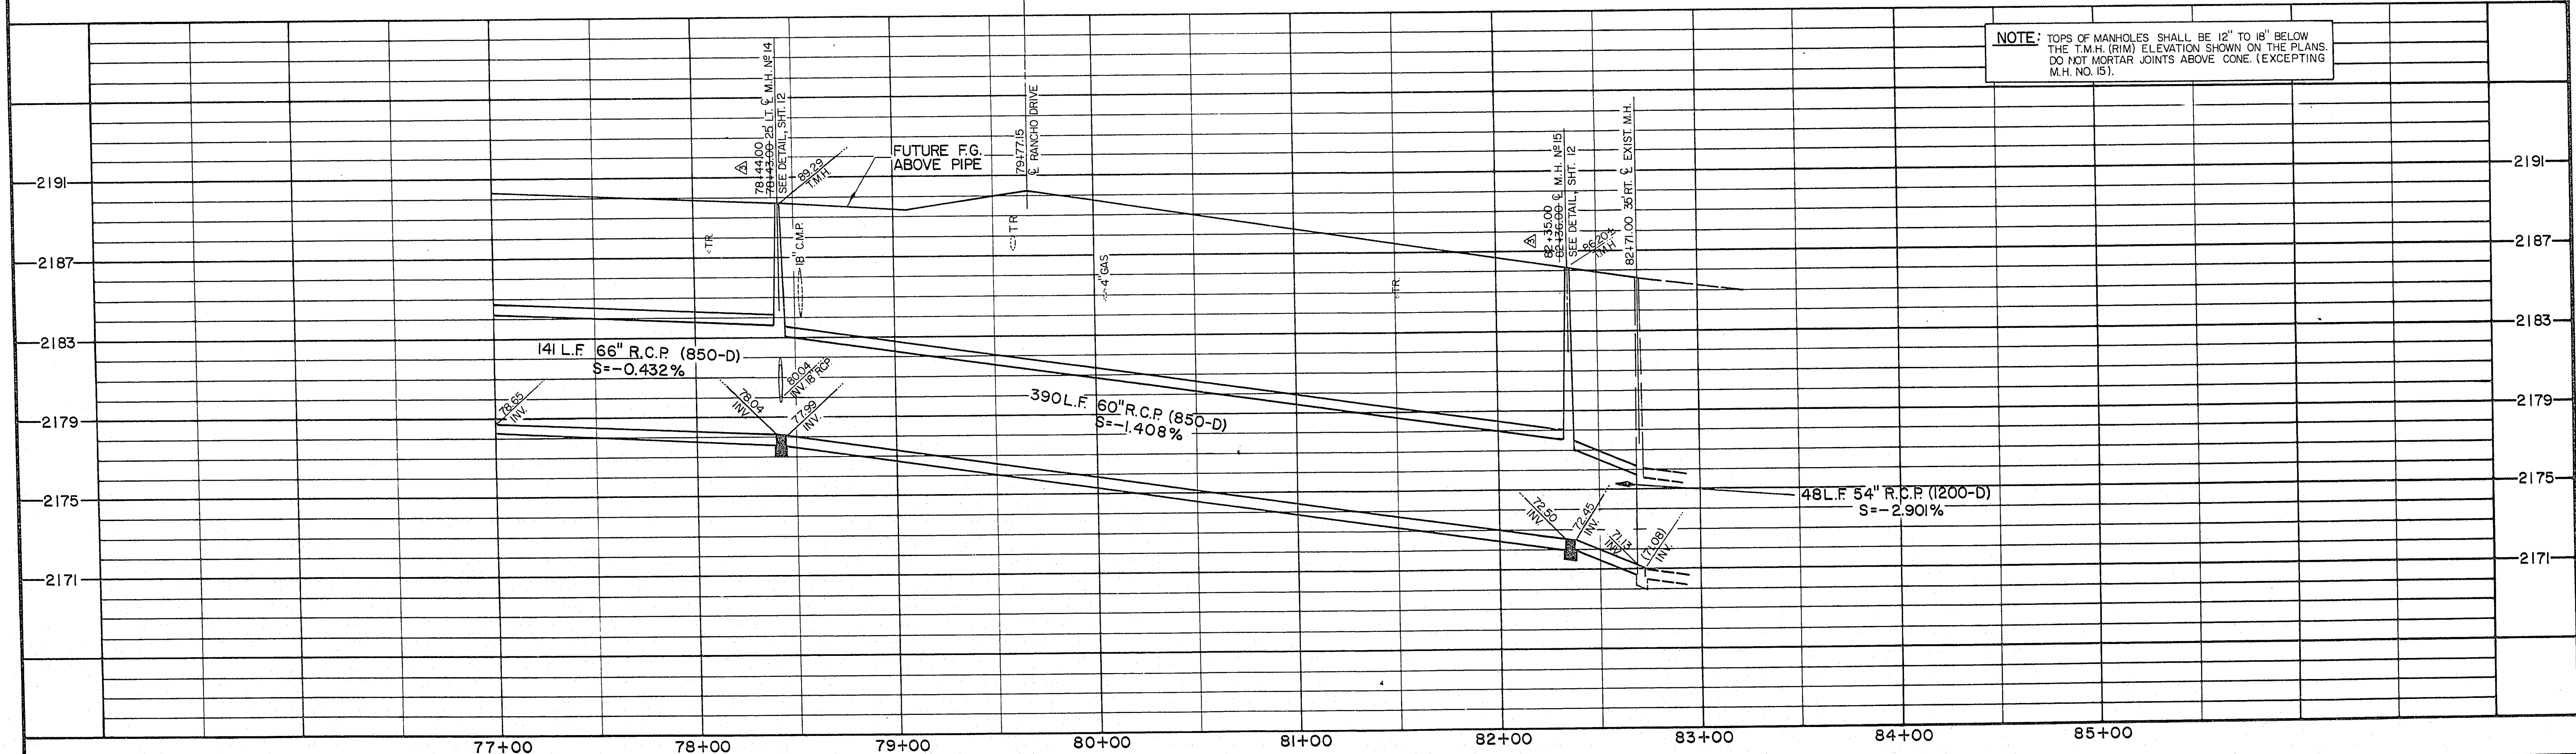


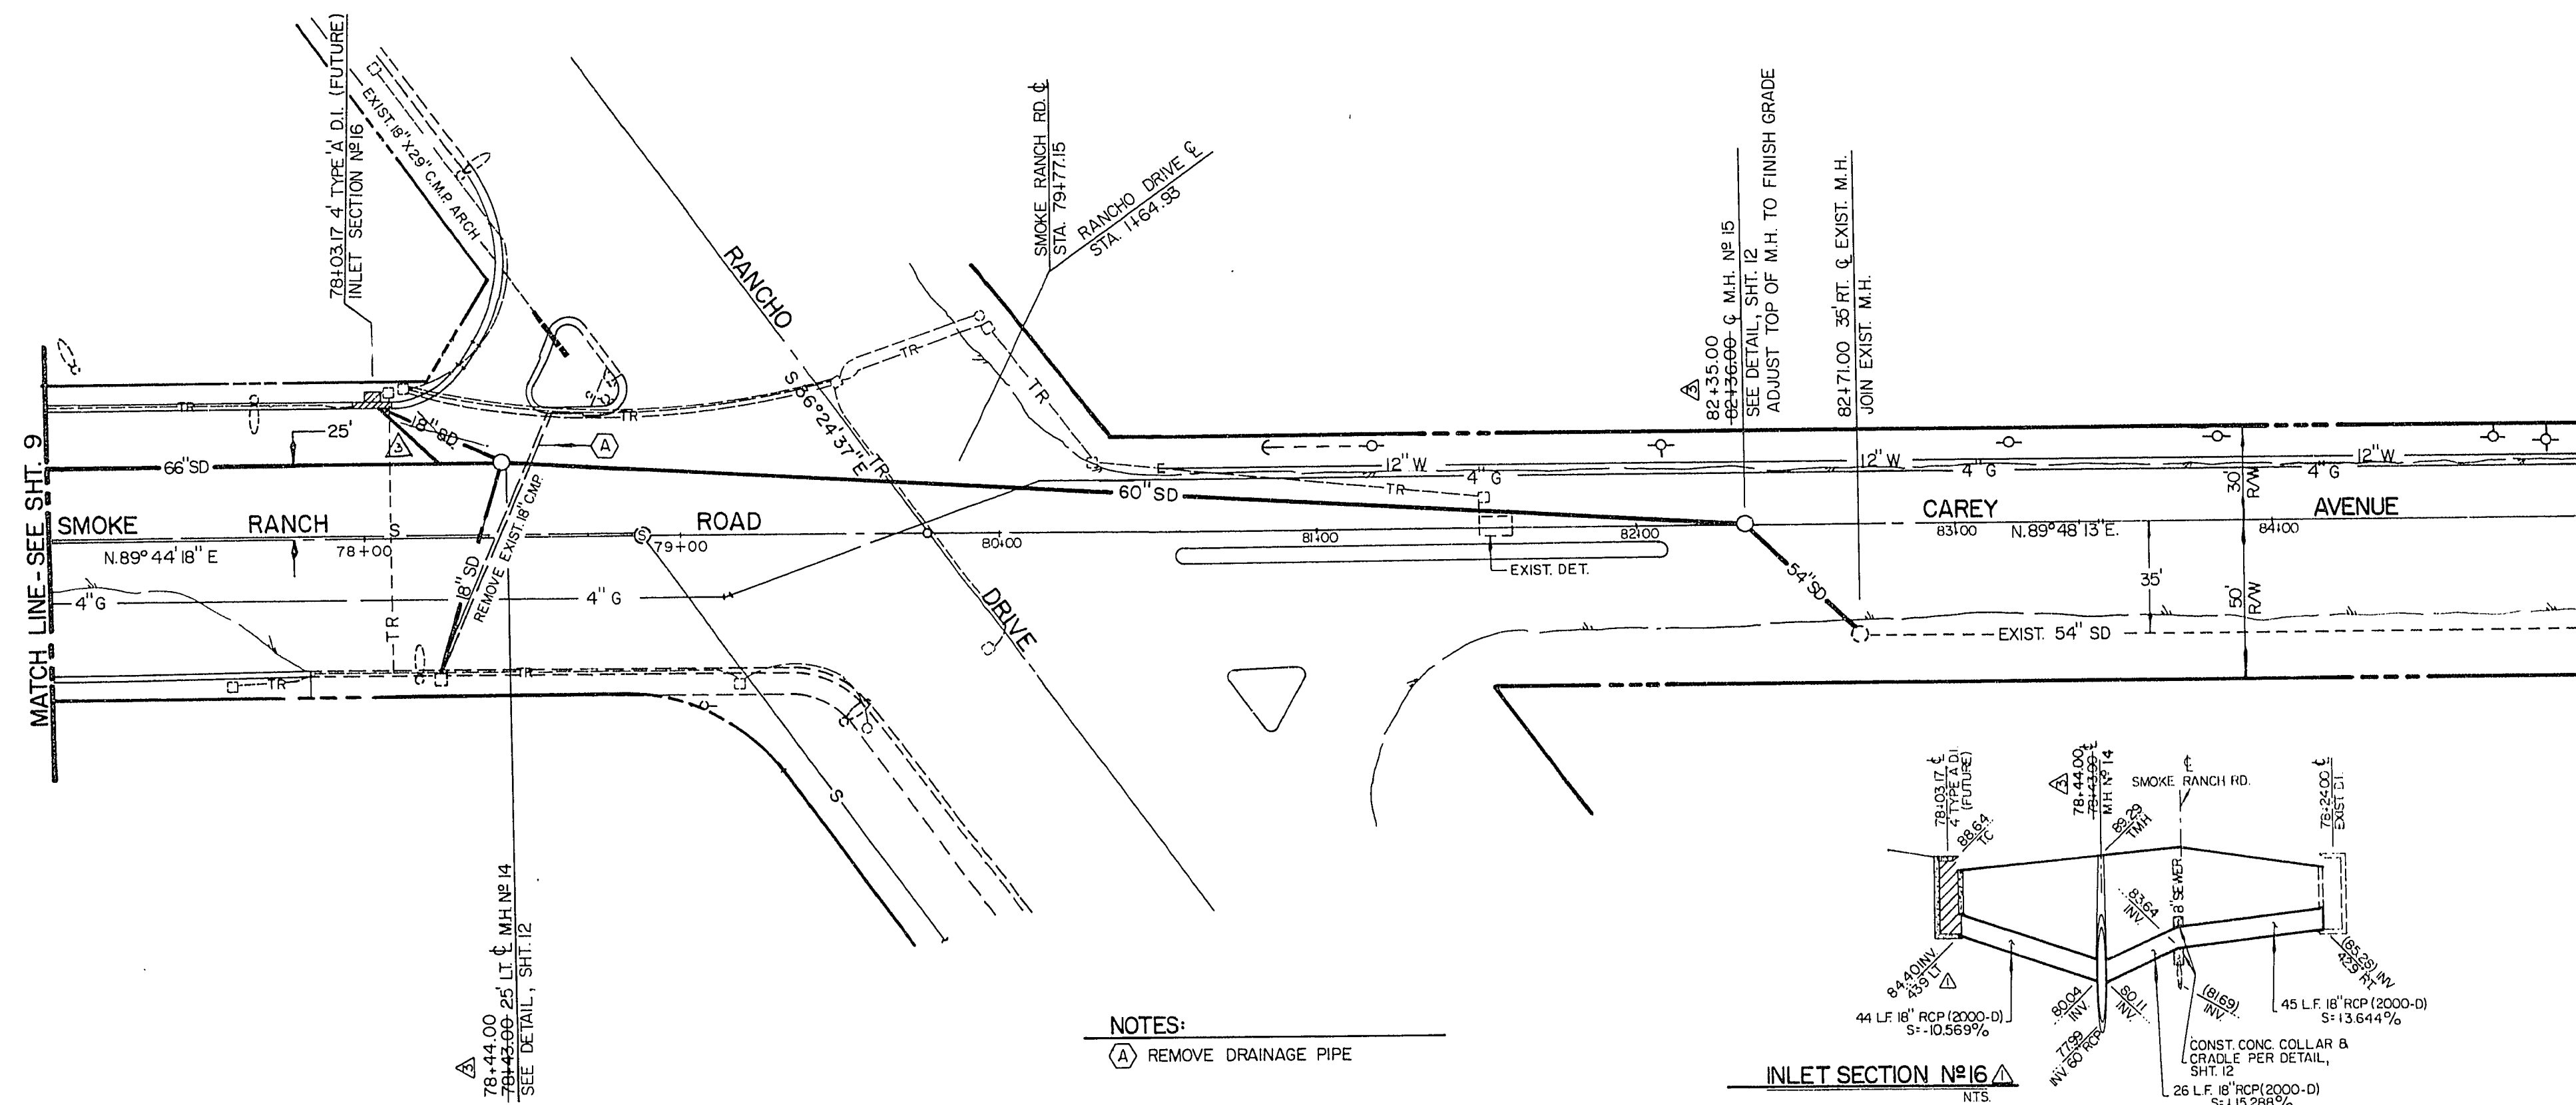

REV. NO.	DATE	DESCRIPTION	APPROVED
1	6/18/87	LOWERED INV. OF 4" D.I. AT STA. 78+03.17 LT.	K.T.L.
2	10/6/88	CHANGED DURING CONSTRUCTION	

DESIGNED BY: W. PENNINGTON, K. LAMBERG	CLARK COUNTY NEVADA DEPARTMENT OF PUBLIC WORKS	SMOKE RANCH ROAD STORM DRAIN PLAN AND PROFILE STA. 77+00 TO STA. 85+00	SCALE: HORIZ.: 1"=40'	DRAWING NO. L-750A
DRAWN BY: J.T.S.			VERT.: 1"=4'	PROJECT NO.: 830524 R
CHECKED BY: William F. Pennington			FIELD BOOK: N° 281, N° 341, N° 595, N° 596	SHT. 10 OF 13