



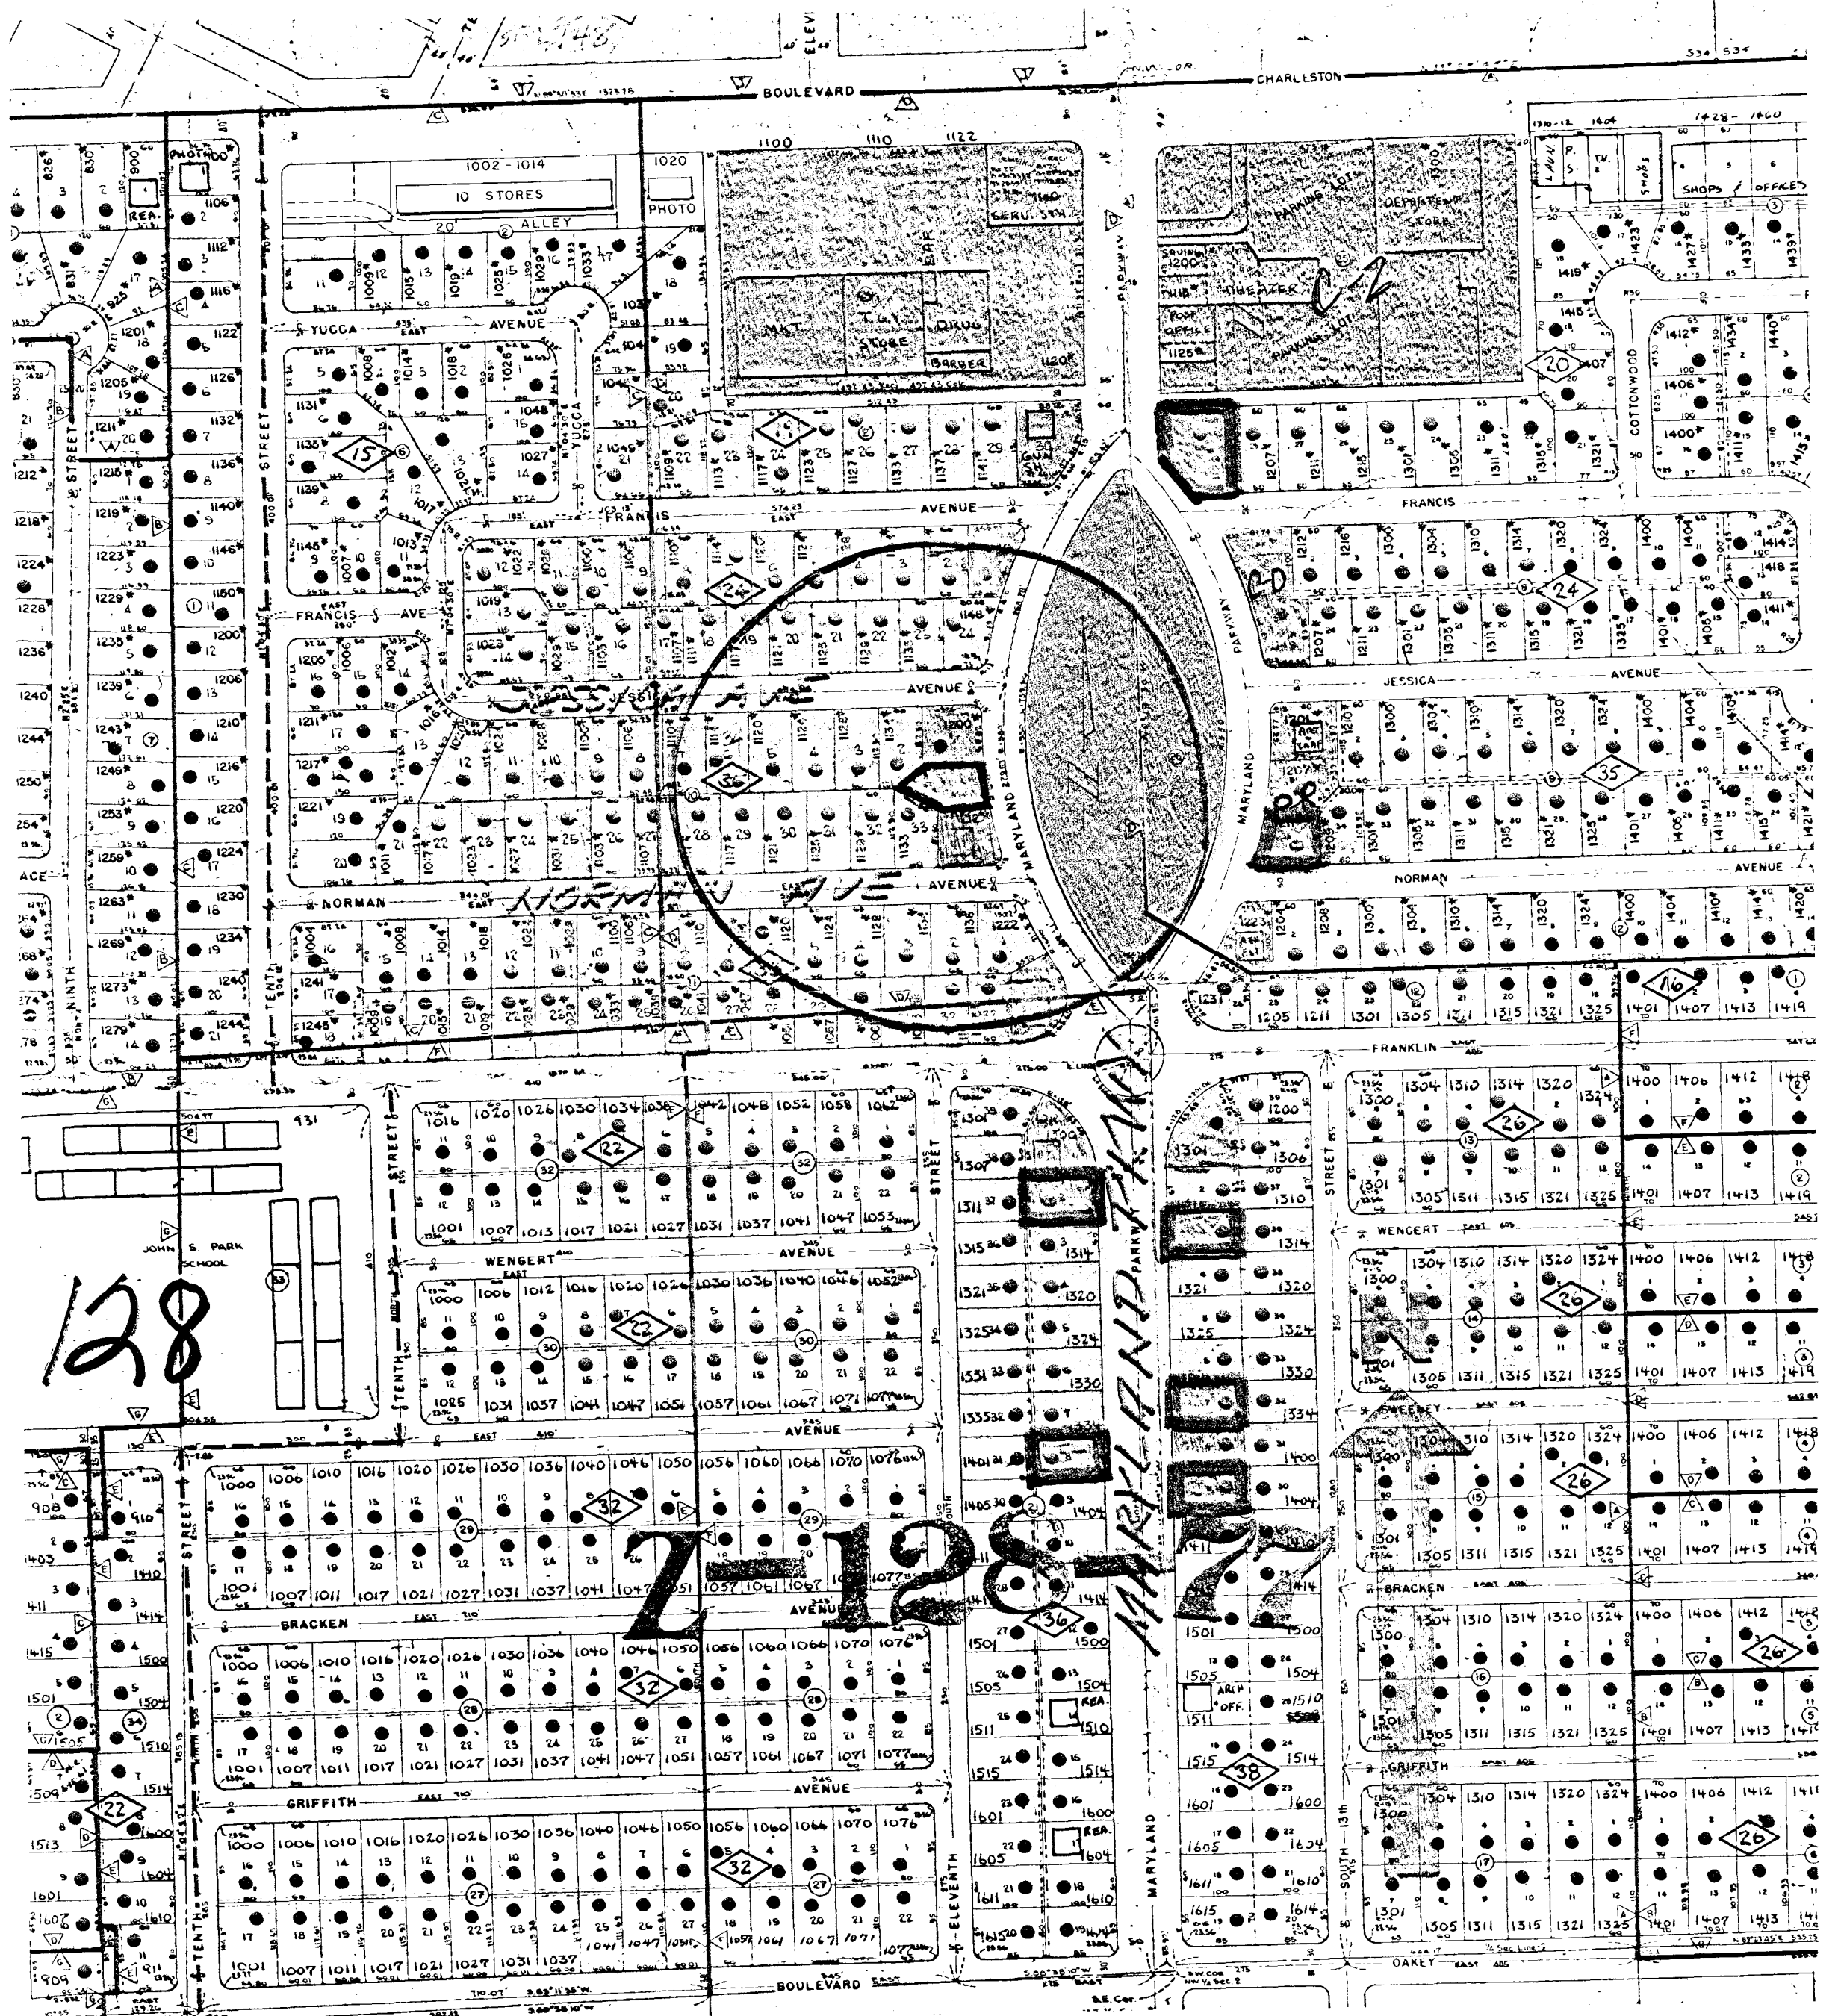



P. 11/22/77
C. 12/1/77

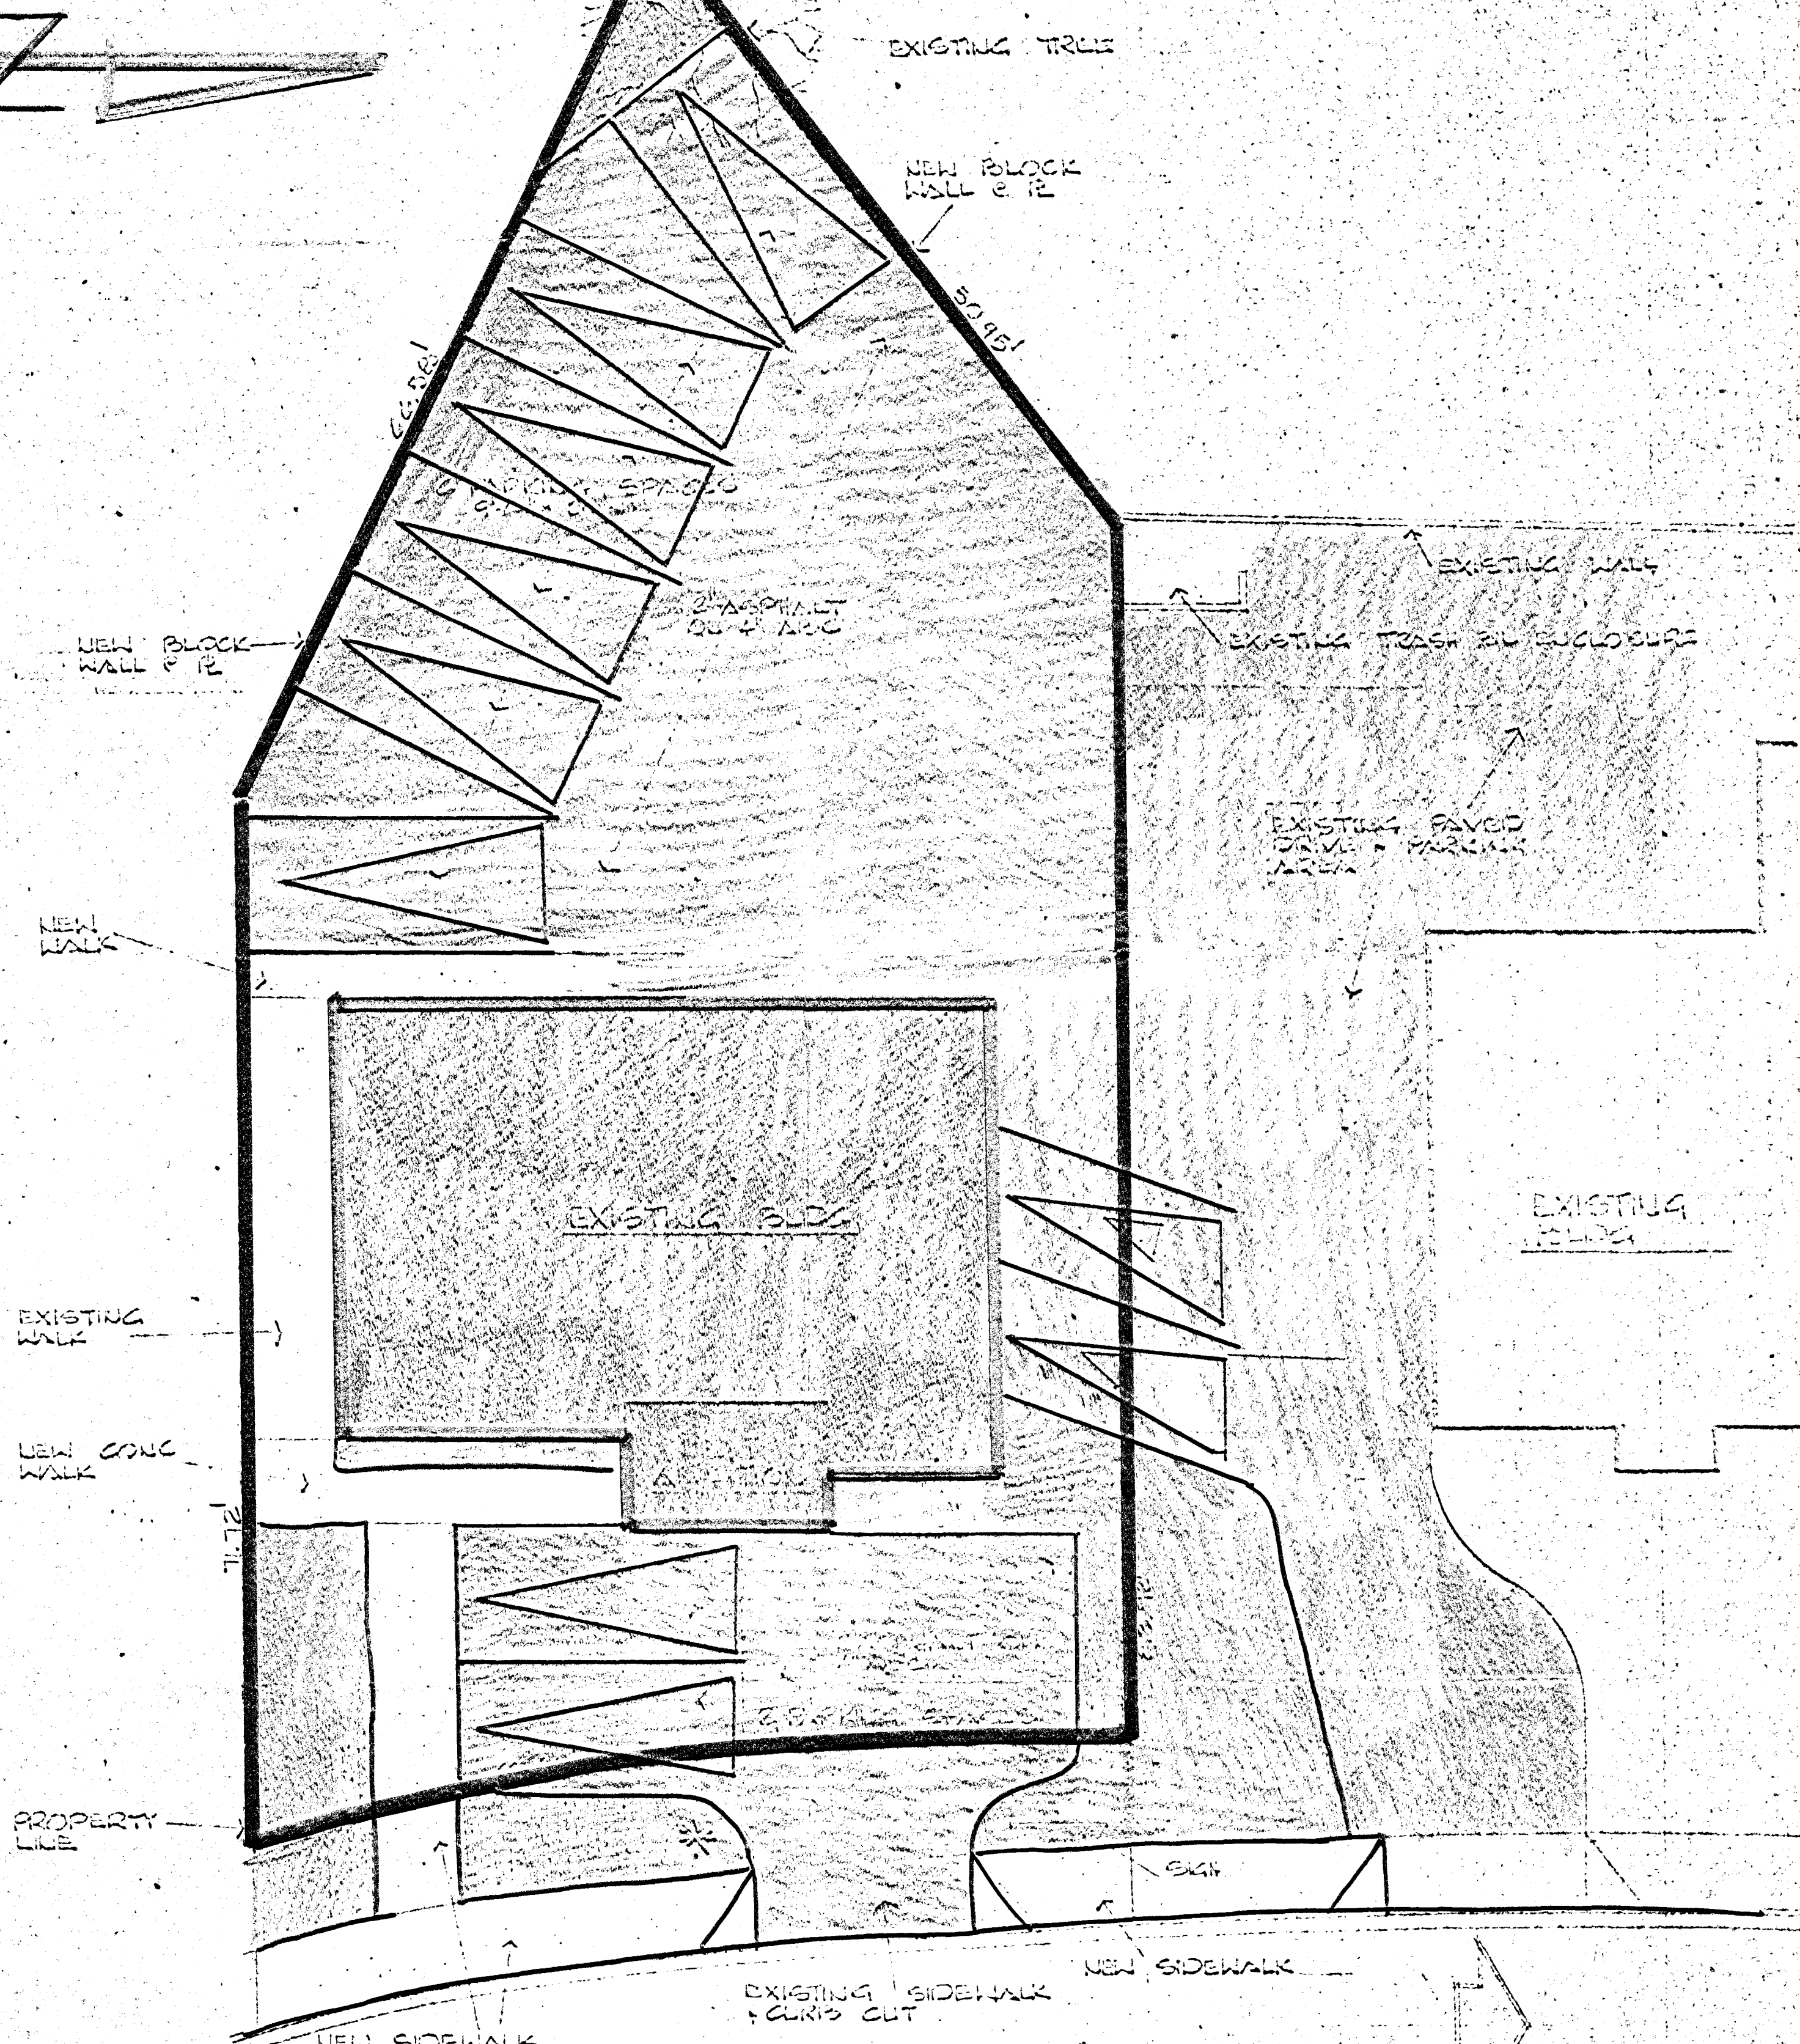

Z-128-17


128

MARYLAND PARKWAY


SITE PLAN
SCALE 1/8" = 1'-0"

NORTH

AVE SITE AVE

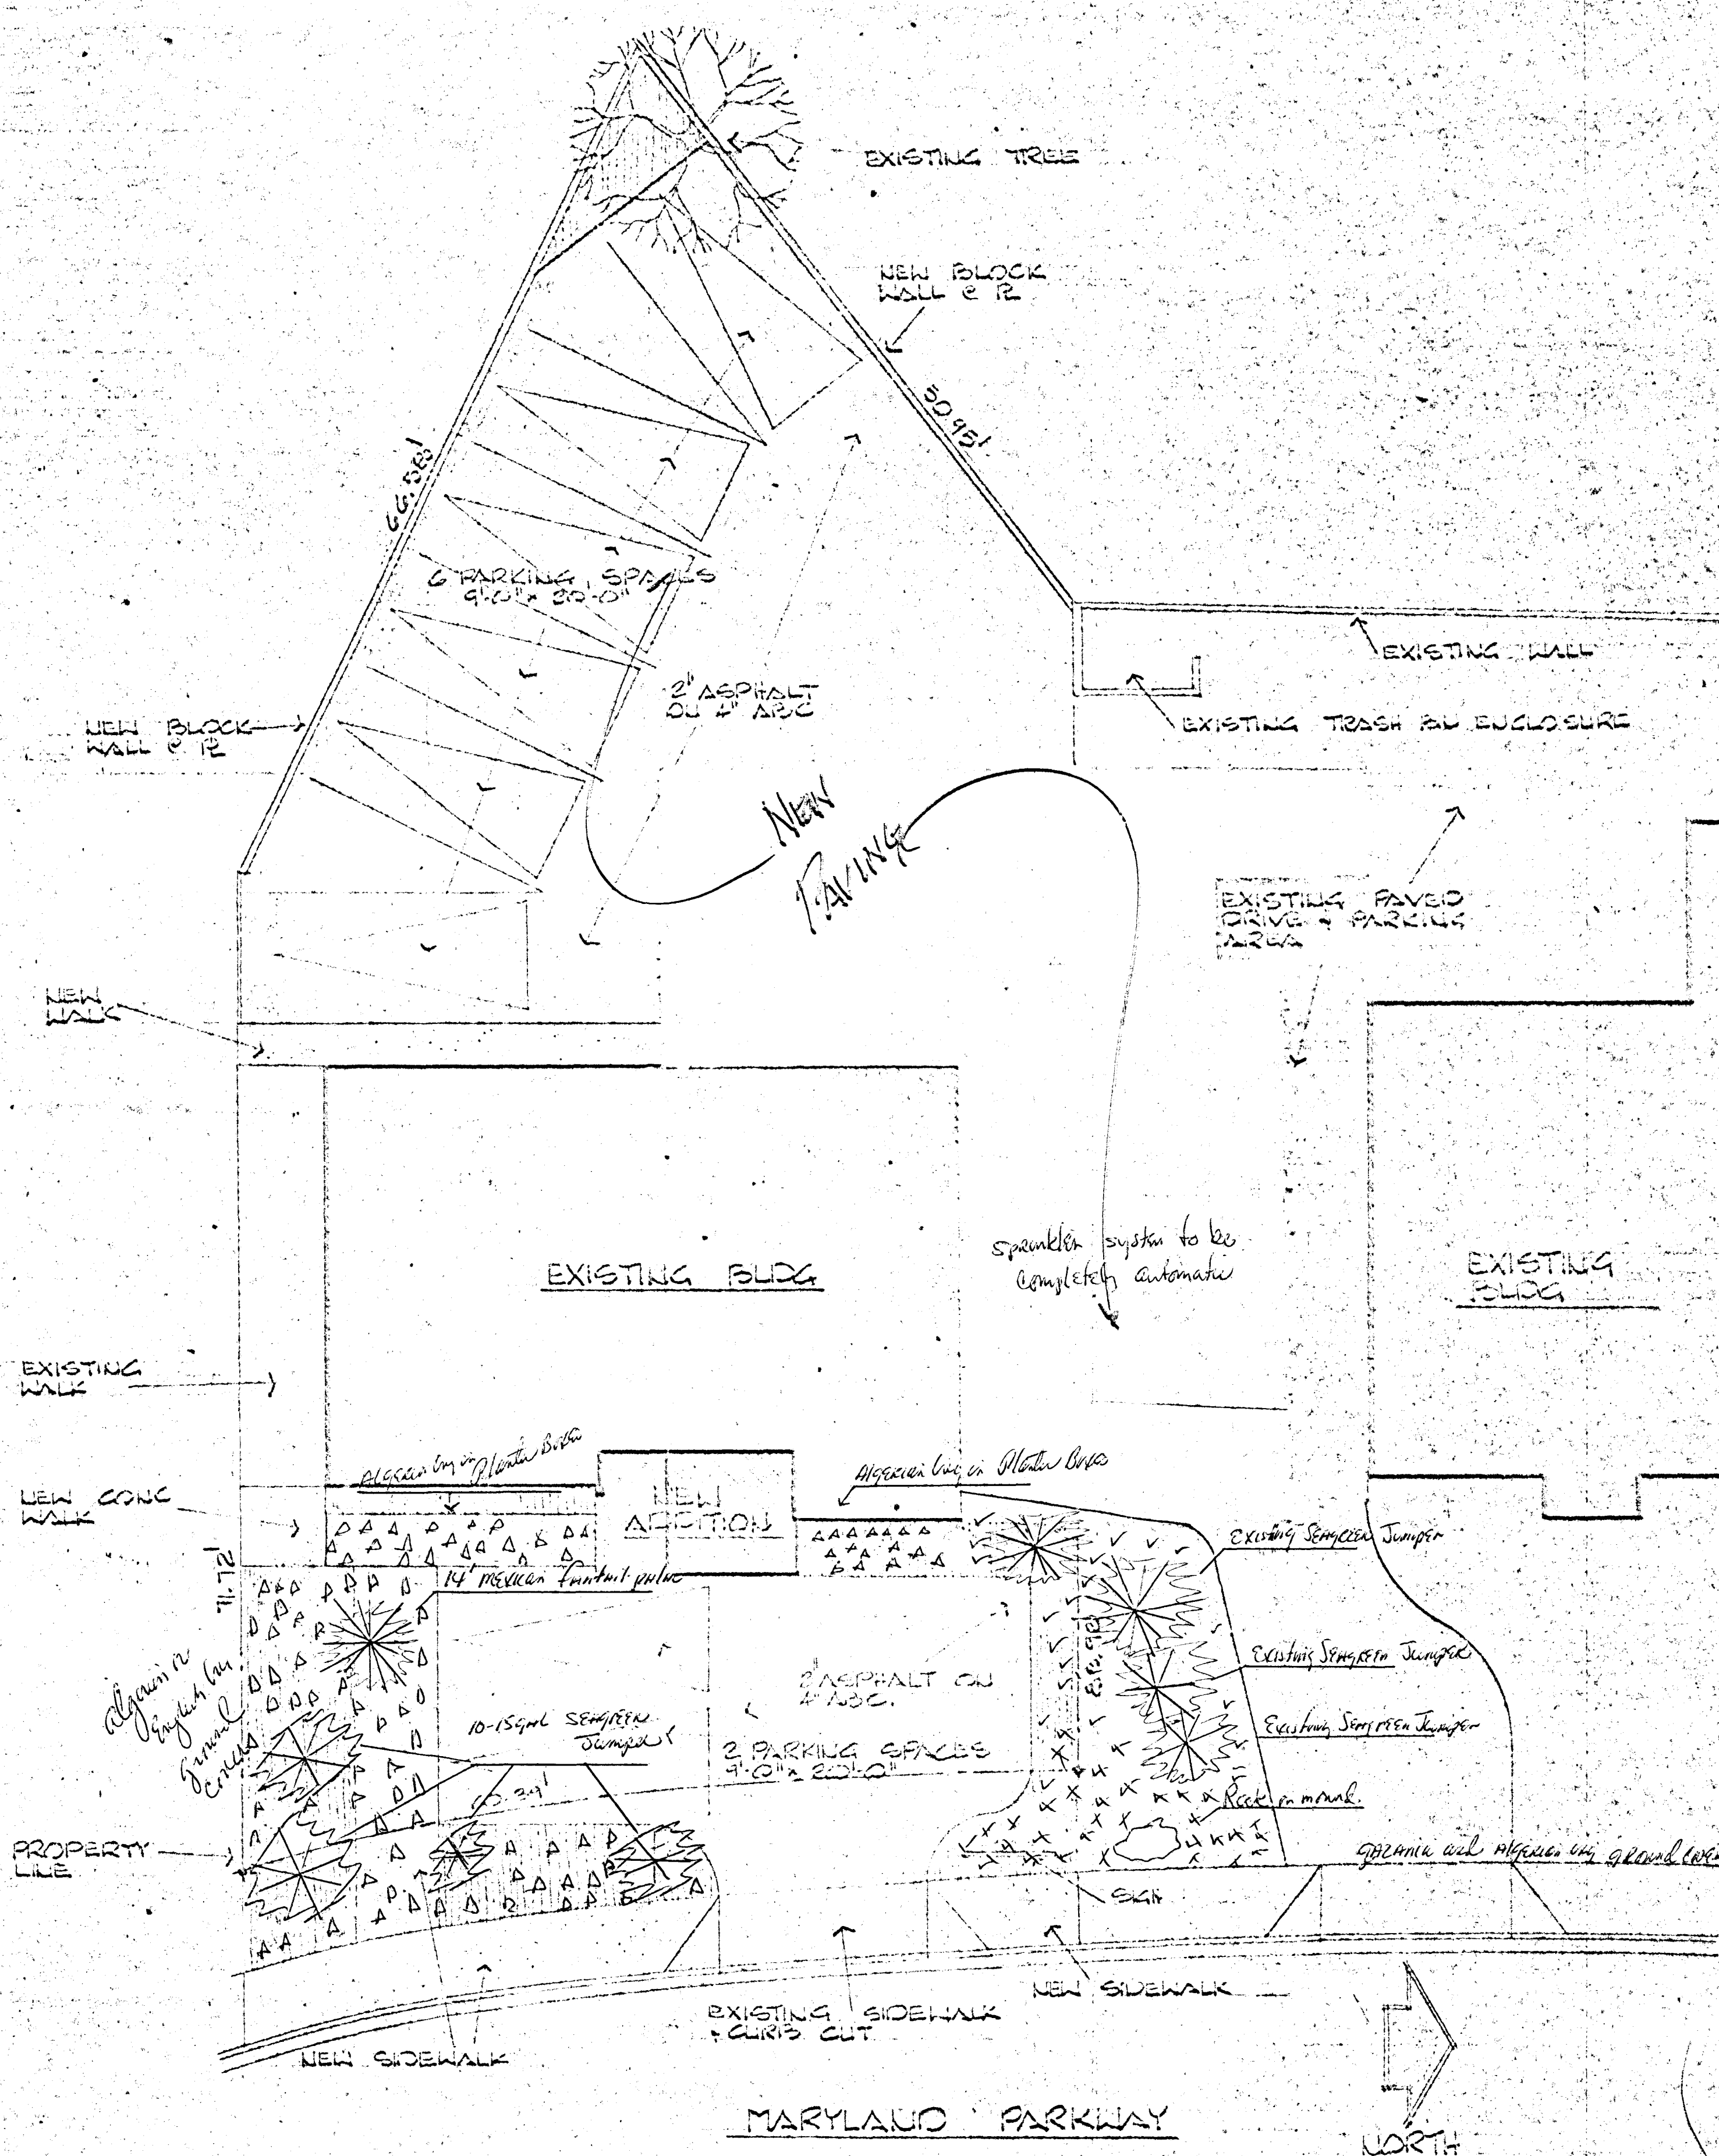

SITE PLAN
SCALE 1/8" = 1'-0"

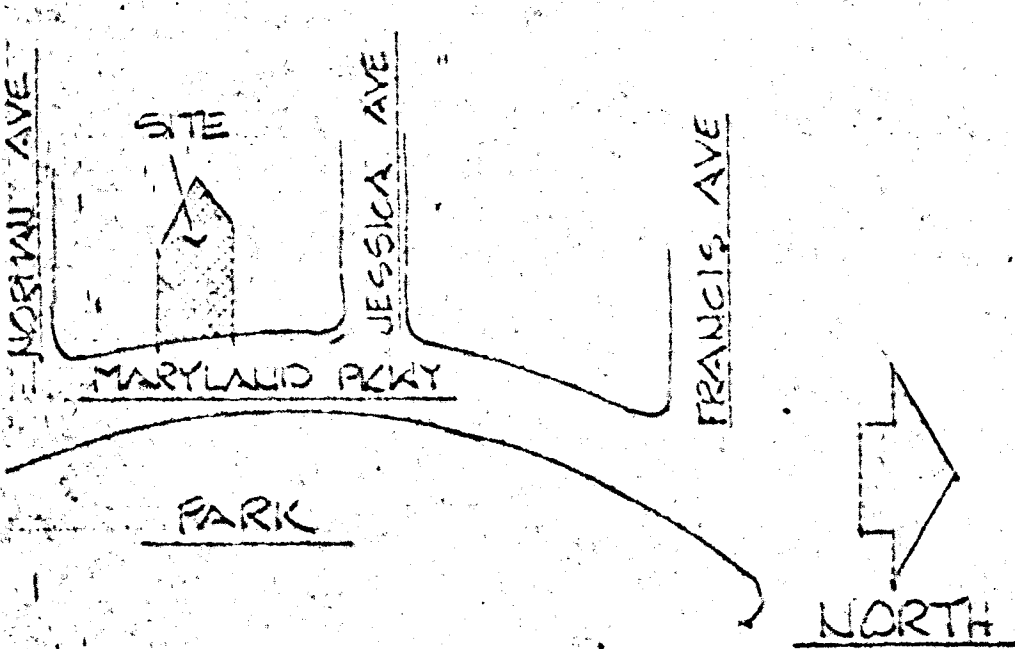

APPROVED LANDSCAPING PLAN
7/29/77
Department of Community Planning & Development

UNDERGROUND SPRINKLING SYSTEM REQUIRED IN ALL LANDSCAPED AREAS

128

LAS VEGAS,		NEVADA
1206 MARYLAND PARKWAY		Z-128-77