
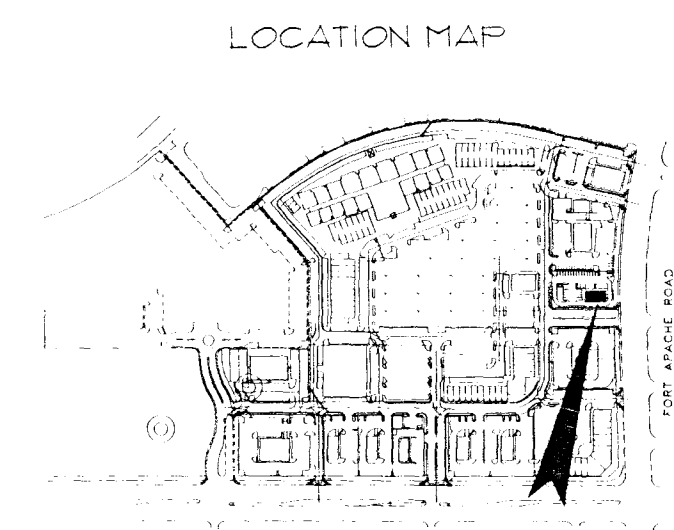


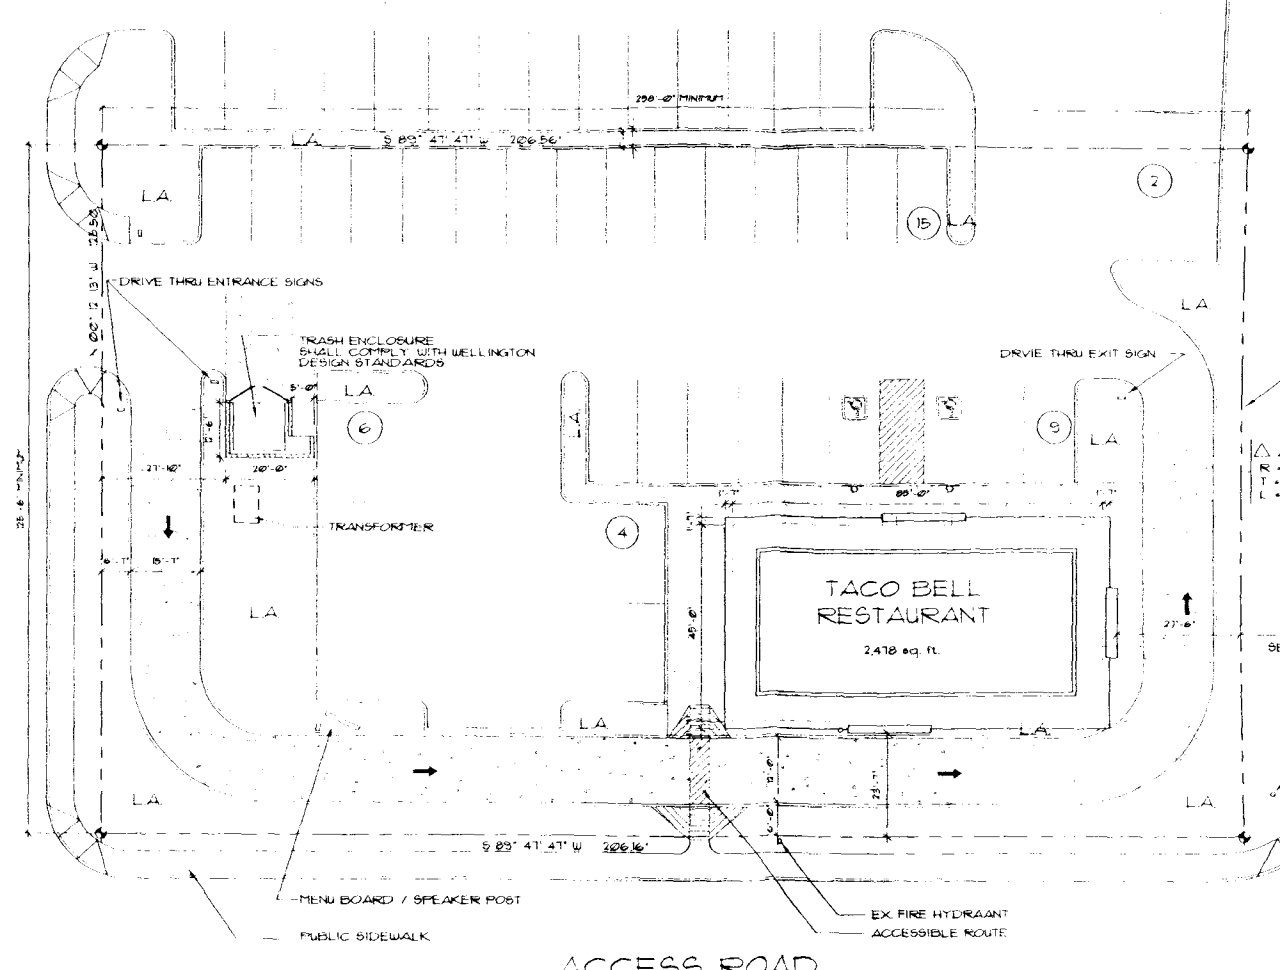

STAFF
Z-139-88(20)
10-23-97 PC

1 ARCHITECTURAL SITE PLAN
 SCALE: 1" = 20'-0"

GENERAL NOTES


LOT IDENTIFICATION: 11
 ASSESSORS PARCEL NUMBER: 16.3-06-B14-002
 LEGAL DESCRIPTION: THE SOUTHEAST CORNER (SE 1/4) OF SECTION 6, TOWNSHIP 21 SOUTH, RANGE 60 EAST, R1M
 PARKING: REQUIRED 25, SUPPLIED 36
 BUILDING TO LOT COVERAGE: 10%
 ARCHITECT'S REGISTRATION NUMBER: NEVADA #313
 EXTERIOR PAVING FINISHES:
 CONCRETE
 ASPHALT
 SIDEWALK

ARCHITECT GRAD GARDICH • AIA
 & ASSOCIATES
 10 COMMERCE CENTER DRIVE
 HENDERSON, NEVADA 89014
 (702) 454-5842 FAX (702) 454-7842


2000 THE MOOH (STRETCH)
TACO BELL
 SALATA & P. APACHE
 LAS VEGAS, NEVADA

ARCHITECTURAL
SITE PLAN


Sheet No. **AS1.01**

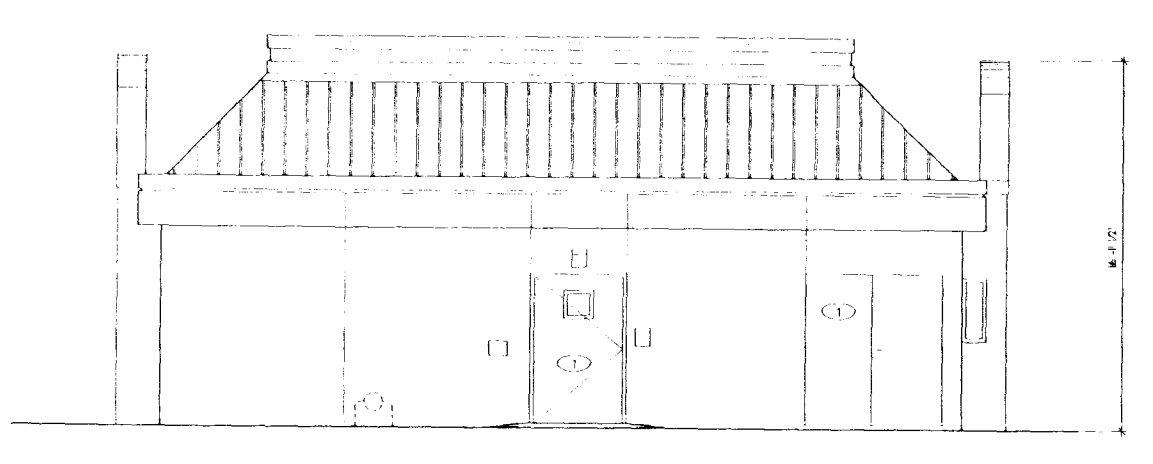


1 EAST ELEVATION
 SCALE: 1/4" = 1'-0"

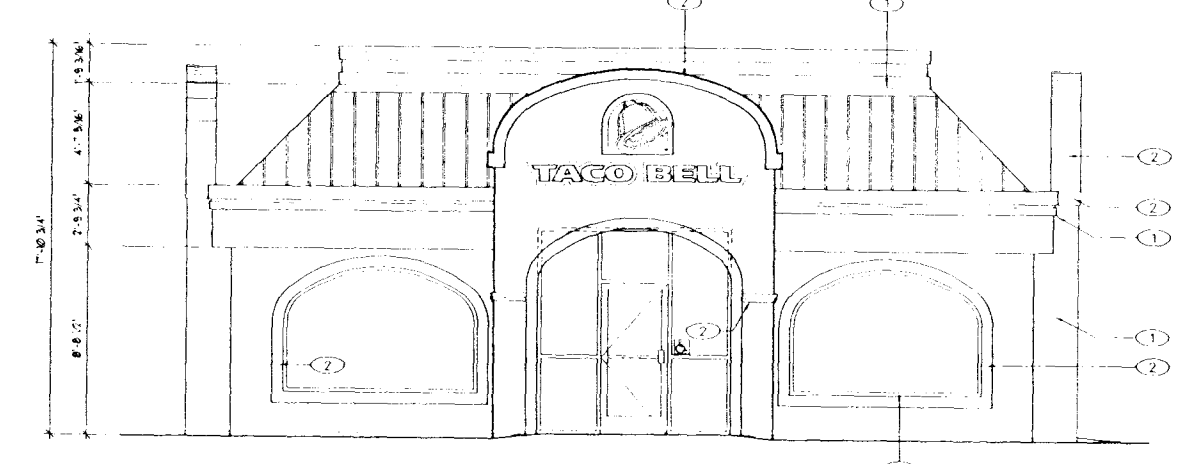

2 WEST ELEVATION
 SCALE: 1/4" = 1'-0"

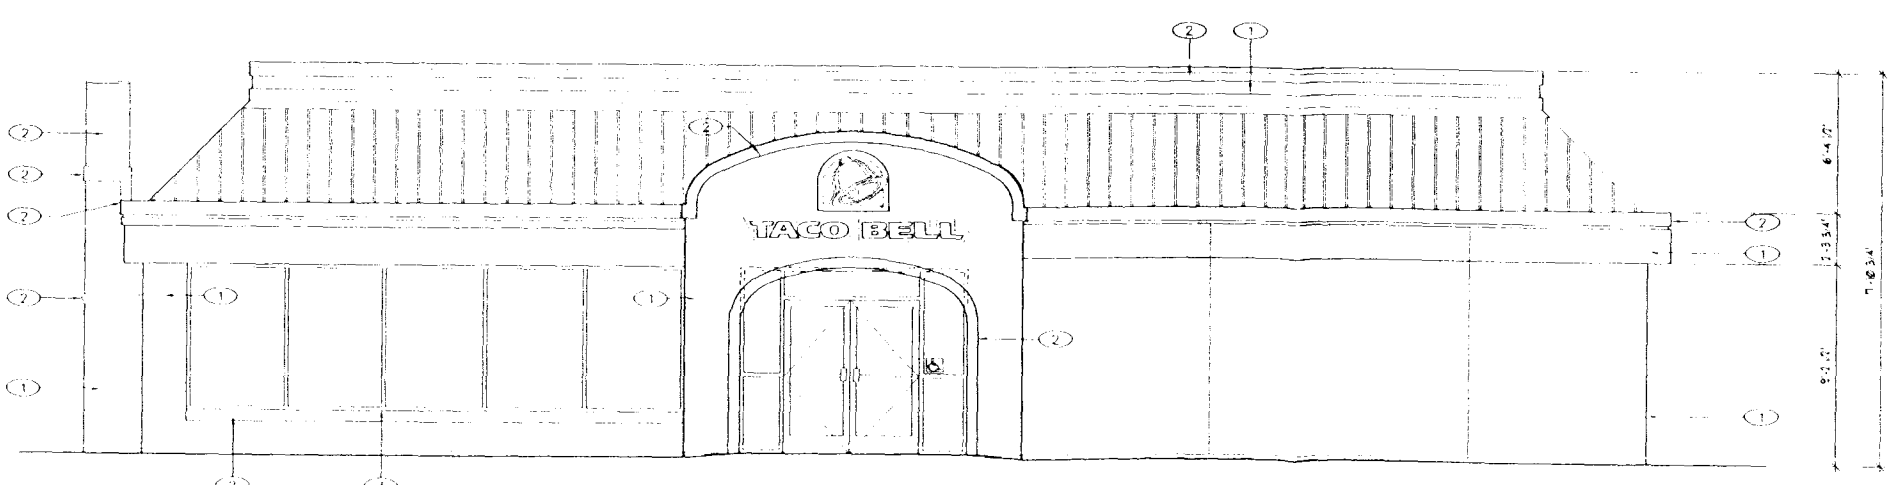

3 SOUTH ELEVATION
 SCALE: 1/4" = 1'-0"

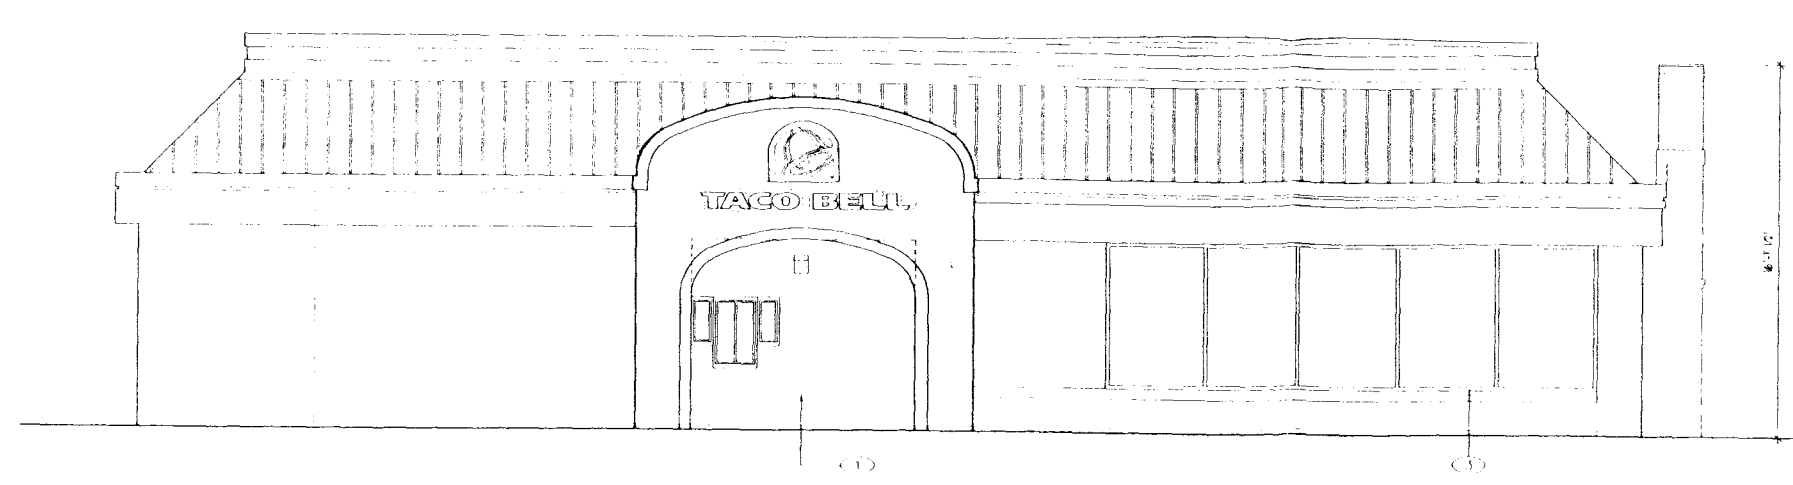

4 NORTH ELEVATION
 SCALE: 1/4" = 1'-0"

EXTERIOR FINISH SCHEDULE

SURFACE	COLOR
DRYVIT	1
PROJECTED BURNBOARDS, PROJECTED BAND	2
FASCIA, FASCIA FLASHING	3
METAL SEAF ROOF	4
PARAPET FLASHING	5
WINDOW FRAMES	6
LIGHT POLES	7
EXPOSED UTILITY PIPES AND CONDUIT	8
METAL DOORS AND FRAMES	9
SHEET METAL FASCIA TRIM	10
GAS METER AND ELECTRICAL SERVICE	11
PANEL SPECIFICATION	
1 SHENKIN WILLIAMS DW2023 - COAST POINT	
2 SHENKIN WILLIAMS DW2022 - LANT DOCK	
3 SHENKIN WILLIAMS DW2111 - BONDELAUX	
4 SHENKIN WILLIAMS DW2058 - IVY WALL	

STAFF
Z-139-88(20)
10-23-97 PC


ARCHITECT GRAD GARDICH • AIA
 & ASSOCIATES
 10 COMMERCE CENTER DRIVE
 HENDERSON, NEVADA 89014
 (702) 454-5842 FAX (702) 454-7842

2000 THE MOOH (STRETCH)
TACO BELL
 SALATA & P. APACHE
 LAS VEGAS, NEVADA

PRELIMINARY
NOT FOR
CONSTRUCTION
 01/27/97

EXTERIOR
ELEVATIONS

Sheet No. **A6.01**

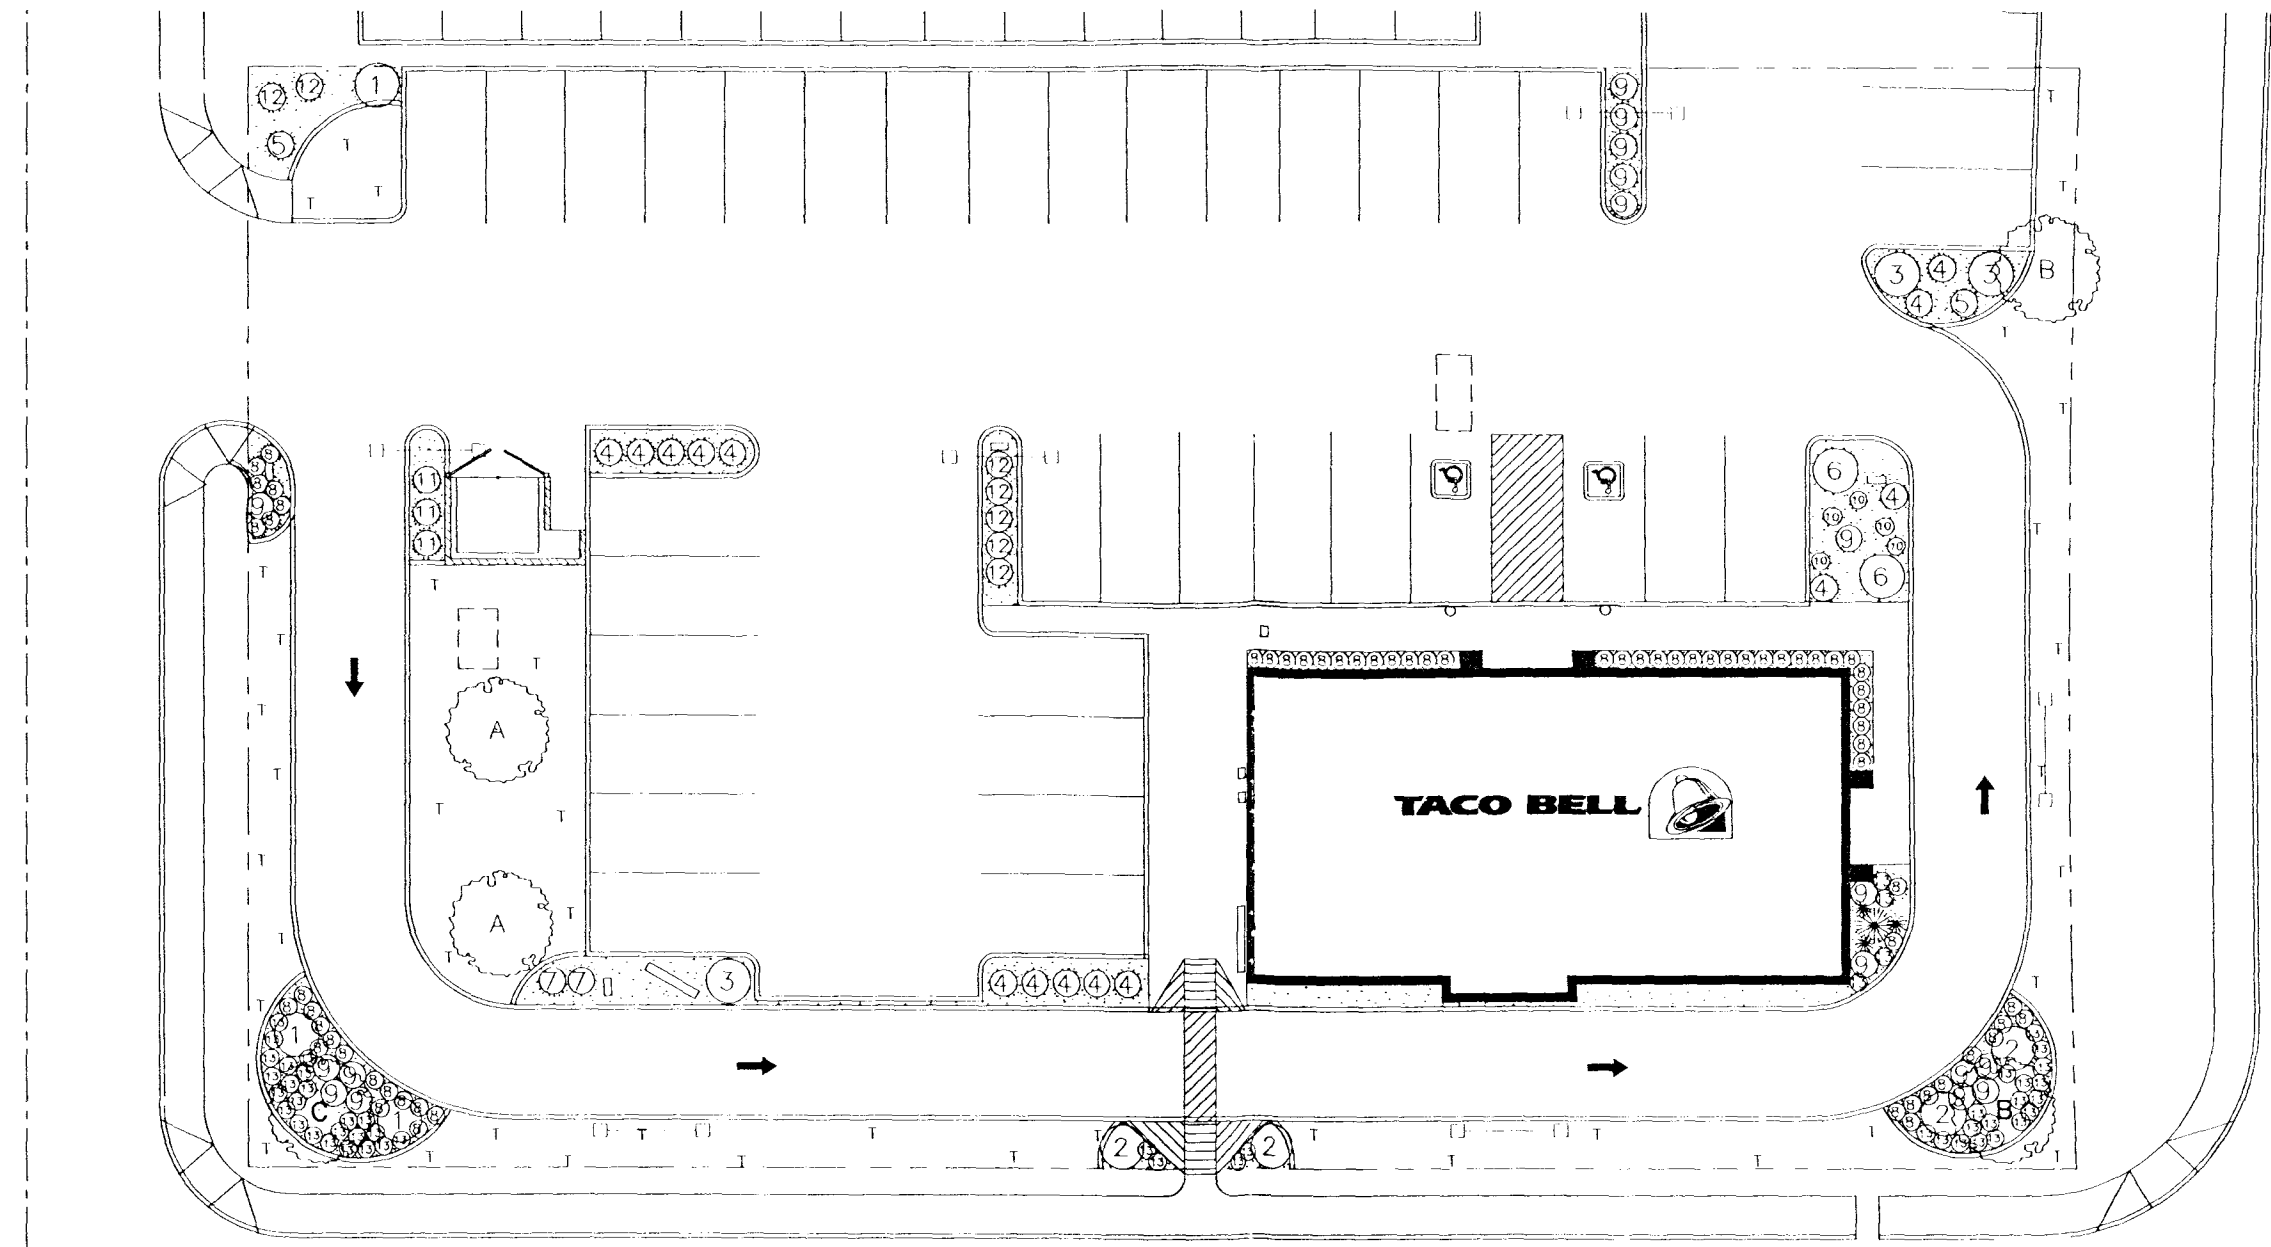

PLANT LEGEND

SYMBOL	BOTANICAL NAME
A	OLEA
B	PROSOPIS juliflora
C	NISSA lutea
D	CHAMBERSIA hindsii

COMMON NAME	SIZE	QUANTITY
Savanna Olive	24" box	2
Chicoan Mesquite	24" box	2
African Sunco	24" box	1
Mediterranean Fan Palm	24" box	1

SYMBOL	BOTANICAL NAME
1	CAESALPINIA gilliesii
2	CAESALPINIA pulcherrima
3	CASSIA artemisioides
4	CONVOLVULUS cheiranthus
5	JUSTICIA spicata
6	LYSTERA pectinatus
7	HEPERALIA pariflora
8	LANTANA camara "RAUATIUM"
9	MULLENBERGIA rigens
10	DEUTERIA berlandieri
11	PHYCANTHA species
12	SALVIA grisea
13	TURBACIA volacea

COMMON NAME	SIZE	QUANTITY
Yellow Bird of Paradise	5 gal	3
Red Bird of Paradise	5 gal	4
Feathery Cassia	5 gal	3
Bush Morning Glory	1 gal	14
Desert Spoon	5 gal	2
Lurysan Daisy	5 gal	2
Red Yucca	5 gal	2
Bush Lantana	5 gal	16
Beer Grass	5 gal	17
Mexican Primrose	1 gal	5
Firethorn	5 gal	3
Texas Red Sage	5 gal	1
Society Garlic	1 gal	50

HARDSCAPE LEGEND

SYMBOL	DESCRIPTION
1/2" MINUS RAIL COLOR TO BE SELECTED BY OWNER	
6" X 4" EXTRUDED CONCRETE MDVSTRIP	

QUANTITIES SHOWN ARE FOR REFERENCE ONLY. IT IS THE CONTRACTOR'S RESPONSIBILITY TO COUNT PLANTS SHOWN ON PLAN.

PLANTING PLAN

SCALE: 1/8"=1'-0"

STAFF
10-23-97 PC
Z-139-88(20)

GENERAL NOTES

- SEE CIVIL DRAWINGS FOR ALL SITE LAYOUT DIMENSIONS, CURBS, UTILITY LINES AND PLANTINGS.
- SEE CIVIL DRAWINGS FOR ALL GRADING AND DRAINAGE.
- SEE CIVIL DRAWINGS FOR ALL UTILITY LINES.
- SEE CIVIL DRAWINGS FOR ALL UTILITY LINES.

ARCHITECT: GERALD GARDACH • AIA
10 COMMERCE CENTER DRIVE
HENDERSON, NEVADA 89011
(702) 454-5842 FAX (702) 454-7842

PROJECT: TACO BELL
10 COMMERCE CENTER DRIVE
HENDERSON, NEVADA 89011
(702) 454-5842 FAX (702) 454-7842

DAN STEVENSON
DESIGN: 10/23/97
SCALE: 1/8"=1'-0"


PLANTING PLAN
10-23-97 PC
Z-139-88(20)

sheet: 101
11.01

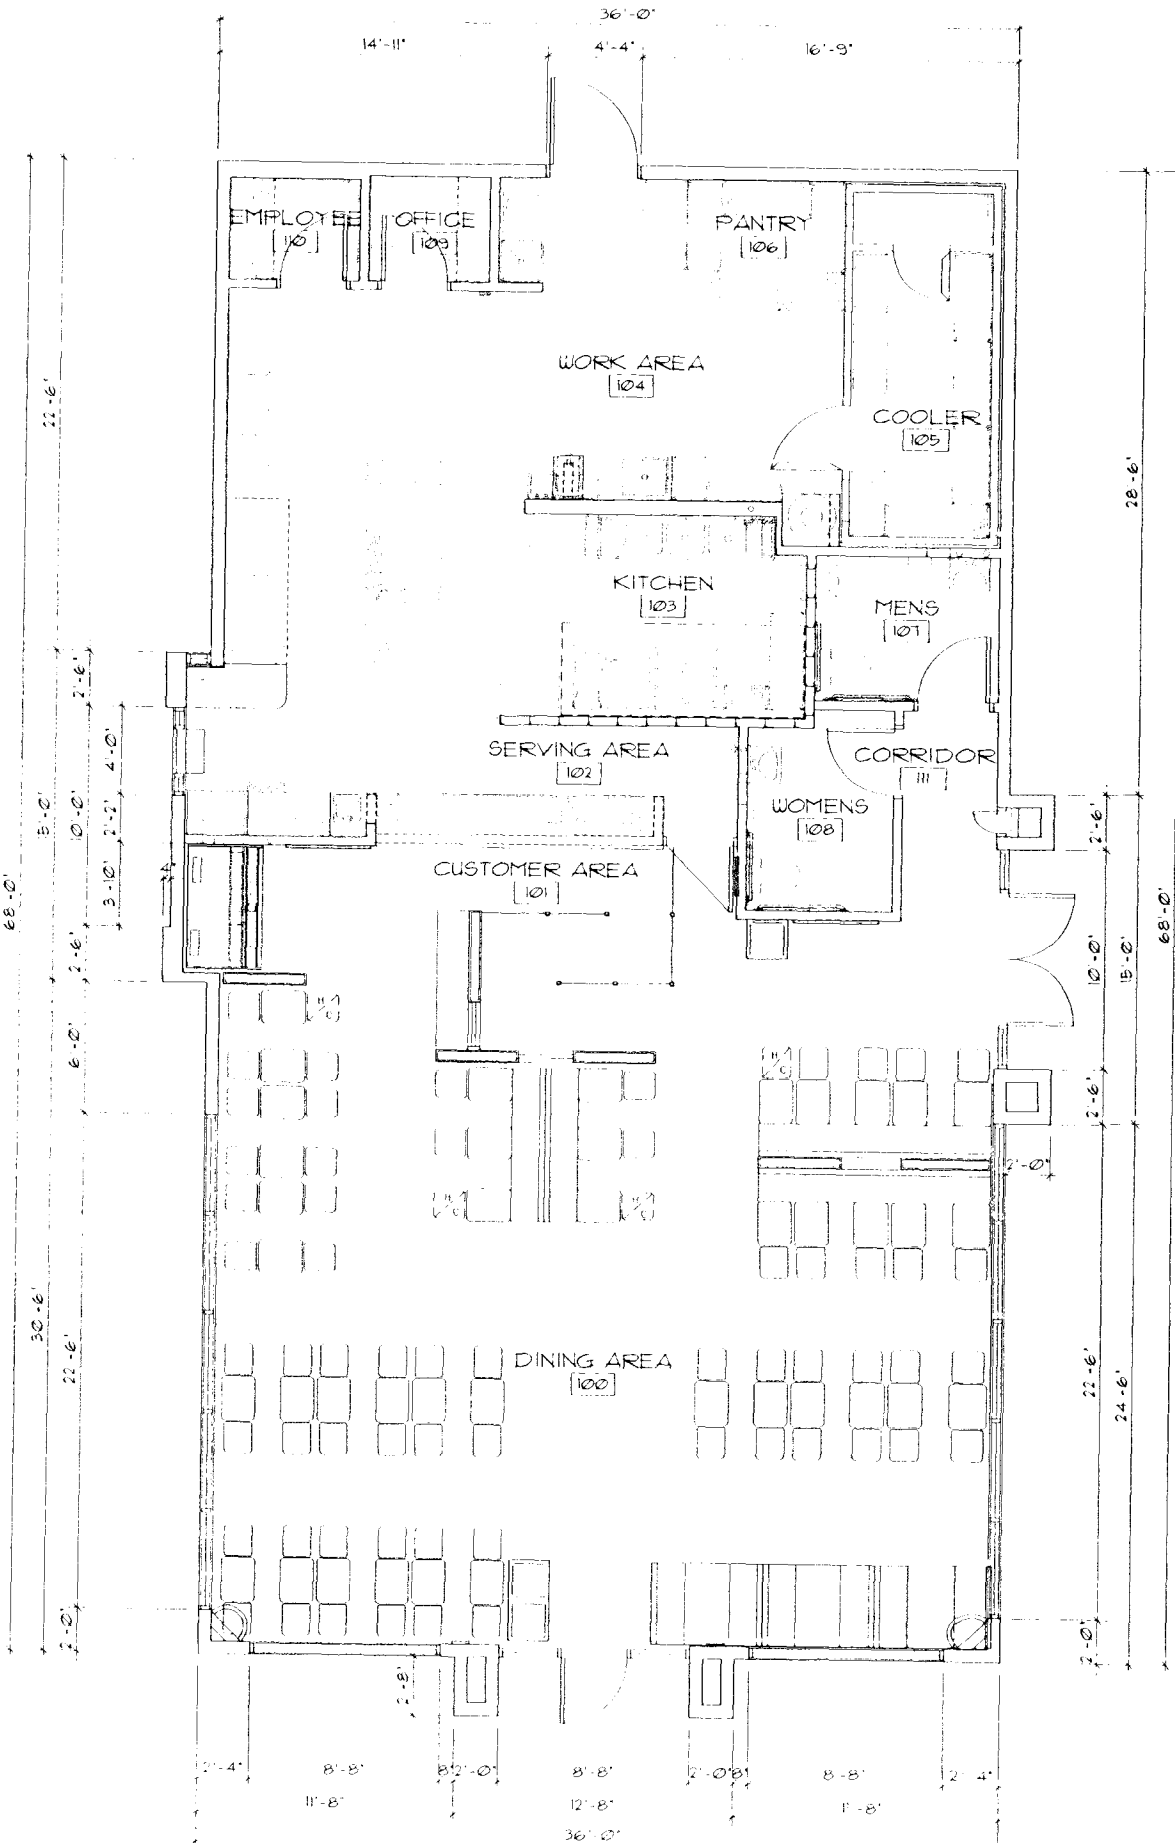

BUILDING AREA:
2,478 SQ. FT.

AREA NO.	AREA NAME	SQ. FT.	USAGE
100	DINING AREA	984 SQ. FT.	ASSEMBLY AREA
101	CUSTOMER AREA	241 SQ. FT.	WAITING AREA
102	SERVING AREA	104 SQ. FT.	ASSEMBLY AREA
103	KITCHEN AREA	246 SQ. FT.	KITCHEN
104	WORK AREA	276 SQ. FT.	KITCHEN
105	COOLER	276 SQ. FT.	STORAGE
106	PANTRY AREA	71 SQ. FT.	STORAGE
107	MENS TOILET	53 SQ. FT.	AUXILIARY
108	WOMENS TOILET	58 SQ. FT.	AUXILIARY
109	OFFICE	26 SQ. FT.	OFFICE
110	EMPLOYEE	27 SQ. FT.	OFFICE
111	CORRIDOR	38 SQ. FT.	CIRCULATION

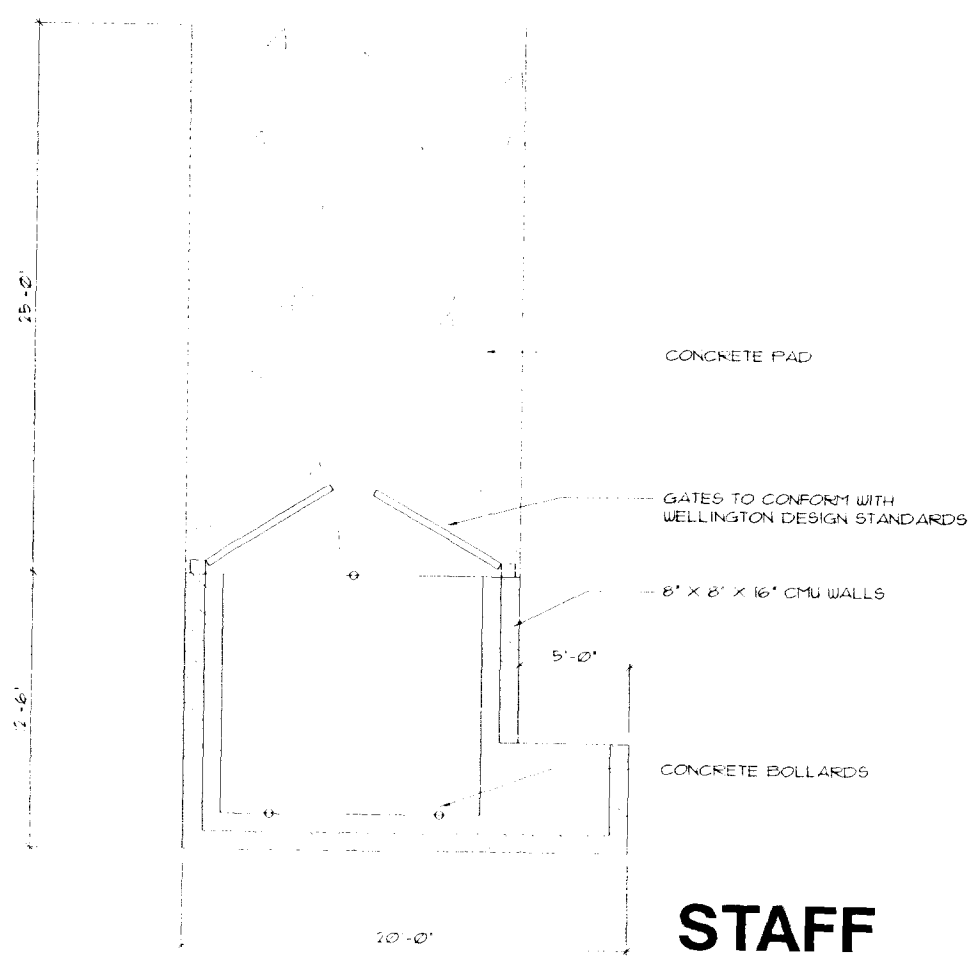

STAFF
Z-139-88(20) 10-23-97 PC

FLOOR PLAN

SCALE: 1/4"=1'-0"



TRASH ENCLOSURE

SCALE: 1/4"=1'-0"




ARCHITECT: GERALD GARDACH • AIA
10 COMMERCE CENTER DRIVE
HENDERSON, NEVADA 89011
(702) 454-5842 FAX (702) 454-7842

PROJECT: TACO BELL
10 COMMERCE CENTER DRIVE
HENDERSON, NEVADA 89011
(702) 454-5842 FAX (702) 454-7842


PRELIMINARY
NOT FOR
CONSTRUCTION
8/27/97

FLOOR PLANS
10-23-97 PC
Z-139-88(20)


sheet: 101
A1.01

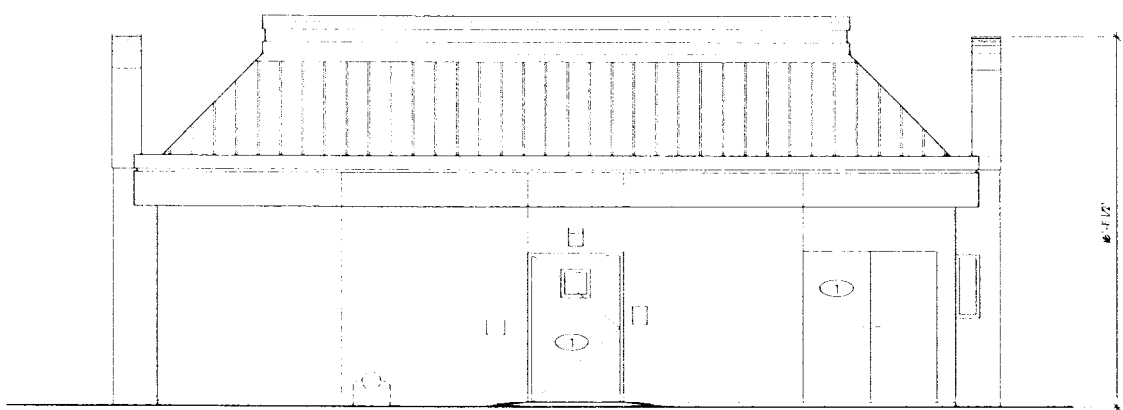


1 EAST ELEVATION
A6.01 SCALE: 1/4" = 1'-0"

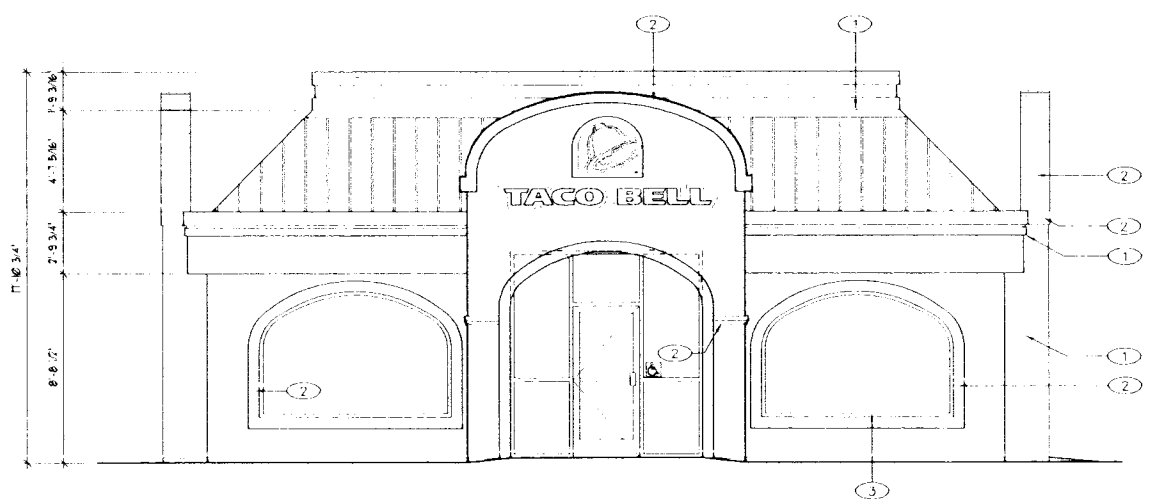

2 WEST ELEVATION
A6.01 SCALE: 1/4" = 1'-0"

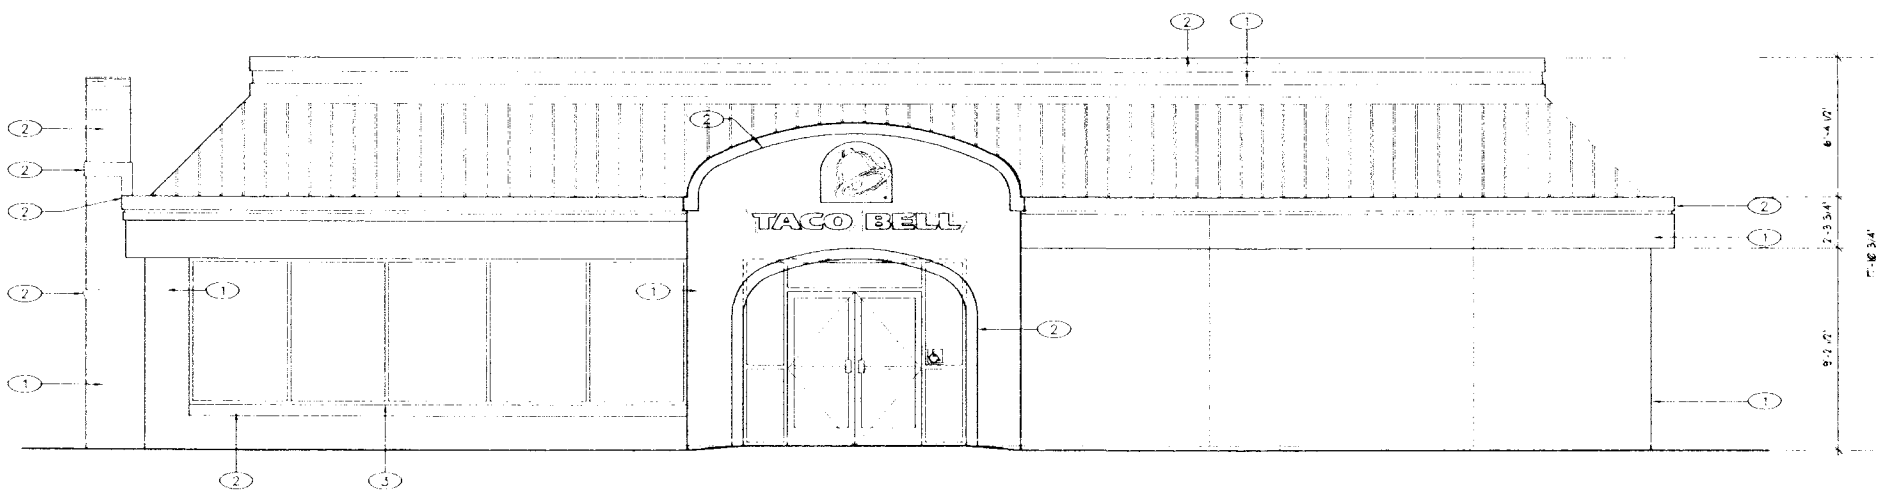

3 SOUTH ELEVATION
A6.01 SCALE: 1/4" = 1'-0"

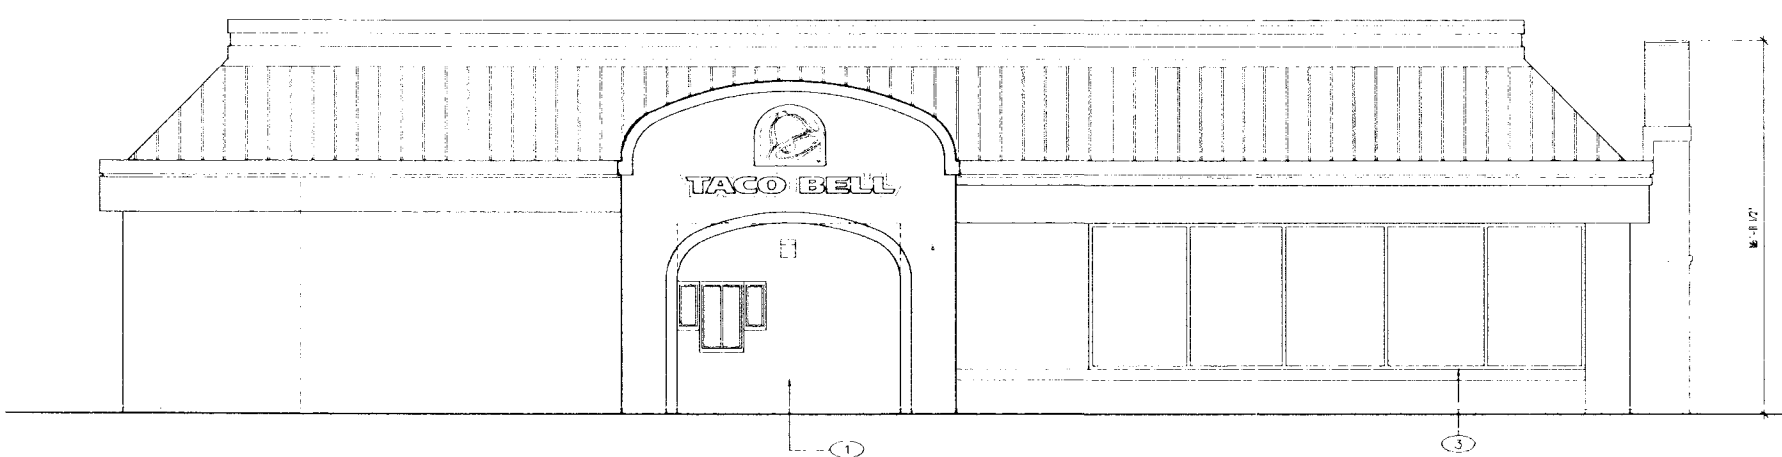

4 NORTH ELEVATION
A6.01 SCALE: 1/4" = 1'-0"

EXTERIOR FINISH SCHEDULE

SURFACE	COLOR
DRYVIT	1
PROJECTED SURROUNDS PROJECTED BAND	1
FASCIA FASCIA FLASHING	1
METAL BEAM ROOF	1
PARAPET FLASHING	1
WINDOW FRAMES	1
LIGHT POLES	1
EXPOSED UTILITY PIPES AND CONDUIT	1
METAL DOORS AND FRAMES	1
SHEET METAL FASCIA TRIM	1
GAS METER AND ELECTRICAL SERVICE	1

PAINT SPECIFICATION

- 1 SHERWIN WILLIAMS
BUD959 - COAST POINT
- 2 SHERWIN WILLIAMS
BUD959 - DRY DOCK
- 3 SHERWIN WILLIAMS
BUD711 - BORDEAUX
- 4 SHERWIN WILLIAMS
BUD758 - IVY WALLCASE



STAFF

3-137-22(10)

OCT 23 1997

PC ADMIN. BZA

LOCATION MAP

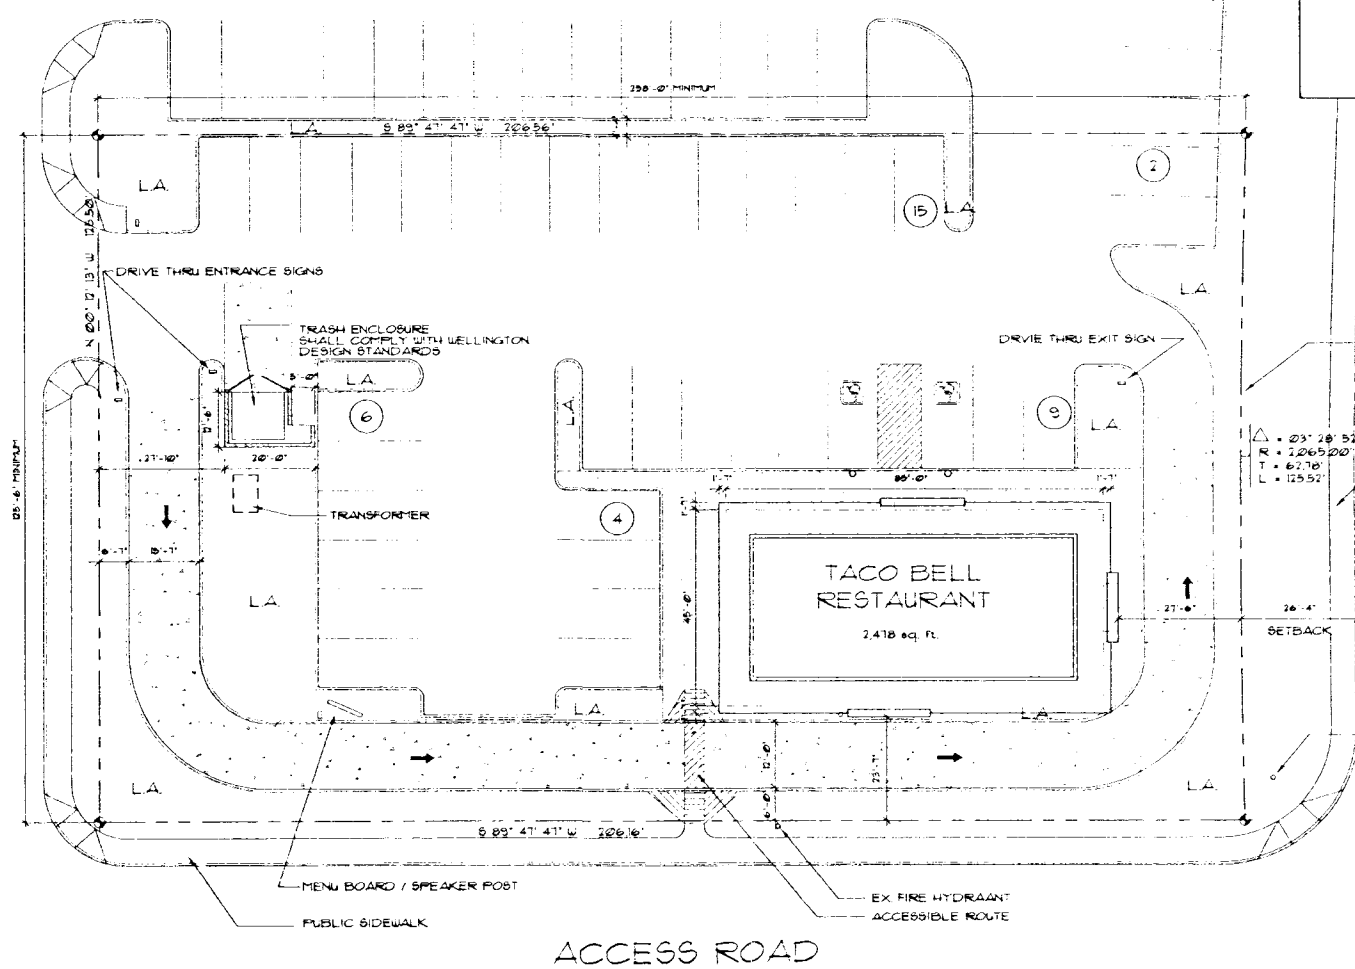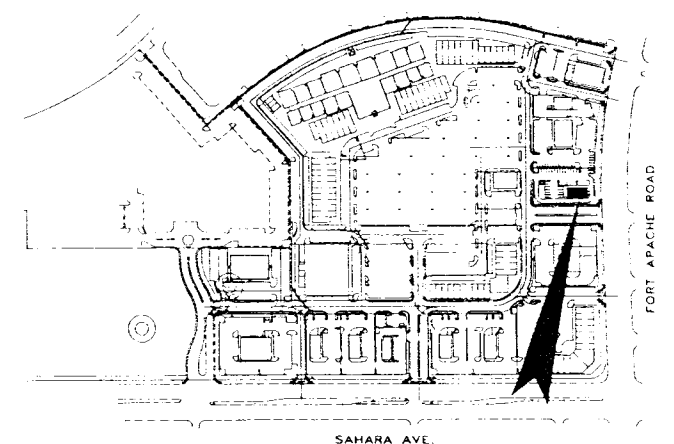

1 ARCHITECTURAL SITE PLAN
AS101 SCALE: 1" = 20'-0"

GENERAL NOTES

- LOT IDENTIFICATION: "J"
ASSESSORS PARCEL NUMBER: 163-26-814-202
LEGAL DESCRIPTION:
THE SOUTHEAST CORNER (SE 1/4) OF SECTION 6,
TOWNSHIP 21 SOUTH, RANGE 60 EAST, MDH.
PARKING:
REQUIRED: 25
SUPPLIED: 36
BUILDING TO LOT COVERAGE: 10%
ARCHITECT'S REGISTRATION NUMBER: NEVADA 1313
EXTERIOR PAVING FINISHES:
CONCRETE
ASPHALT
SIDEWALK

ARCHITECT GERALD GARABICH • AIA
& ASSOCIATES
10 COMMERCE CENTER DRIVE
HENDERSON, NEVADA 89014
(702) 454-5842 FAX (702) 454-7842

PROJECT: 110 M90 STRETCH
TACO BELL
SAHARA & FT. APACHE
LAS VEGAS, NEVADA

PRELIMINARY
FOR
CONSTRUCTION
8/27/97

EXTERIOR
ELEVATIONS

Sheet 0306
Drawn by:
C.C.
Checked by:
C.C.
Project no.:
17-450
Revision:
Sheet no.:
A6.01

ARCHITECT GERALD GARABICH • AIA
& ASSOCIATES
10 COMMERCE CENTER DRIVE
HENDERSON, NEVADA 89014
(702) 454-5842 FAX (702) 454-7842

PROJECT: 110 M90H (STRETCH)
TACO BELL
SAHARA & FT. APACHE
LAS VEGAS, NEVADA

ARCHITECTURAL
SITE PLAN

Sheet 0306
Drawn by:
C.C.
Checked by:
C.C.
Project no.:
17-450
Revision:
Sheet no.:
AS101

PLANT LEGEND

SYMBOL	BOTANICAL NAME	COMMON NAME	SIZE	QUANTITY
A	OLEACEAE	Swanhill Olive	24" box	2
B	PROSOPISTIS chilensis	Chilean Mesquite	24" box	2
C	RHUS luncea	African Sumac	24" box	1
A	CHAMALIDOPSIS humilis	Mediterranean Fan Palm	24" box	1
SYMBOL	BOTANICAL NAME	COMMON NAME	SIZE	QUANTITY
1	CAESALPINIA pulchella	Yellow Bird of Paradise	5 gal	3
2	CAESALPINIA pulchella	Red Bird of Paradise	5 gal	4
3	CASSIA artemisioides	Feathery Cassia	5 gal	3
4	CONVULVULUS coccineus	Bush Morning Glory	1 gal	14
5	DASYLIRION wheeleri	Desert Spoon	5 gal	2
6	EUPHYSIA pectinatus	Euryops Daisy	5 gal	2
7	HEPERALBE pariflora	Red Yucca	5 gal	2
8	LANTANA camara "RADIATION"	Bush Lantana	5 gal	66
9	MULLEBERGIA rigens	Deer Grass	5 gal	17
10	GYNERIUM baccatum	Mexican Primrose	1 gal	5
11	PHYRACANTHA species	Firethorn	5 gal	3
12	SALVIA grisea	Texas Red Sage	5 gal	7
13	TUNBAGHIA violacea	Society Garlic	1 gal	50

T=10' TALL FESCUE SOD


PLANTING PLAN

SCALE: 1/8"=1'-0"

HARDSCAPE LEGEND

SYMBOL DESCRIPTION
 1/2" MINUS ROCK COLOR TO BE SELECTED BY OWNER
 6" X 4" EXTRUDED CONCRETE MOVESTRIP
 QUANTITIES SHOWN ARE FOR REFERENCE ONLY. IT IS THE CONTRACTOR'S RESPONSIBILITY TO COUNT PLANTS SHOWN ON PLAN.

TACO BELL

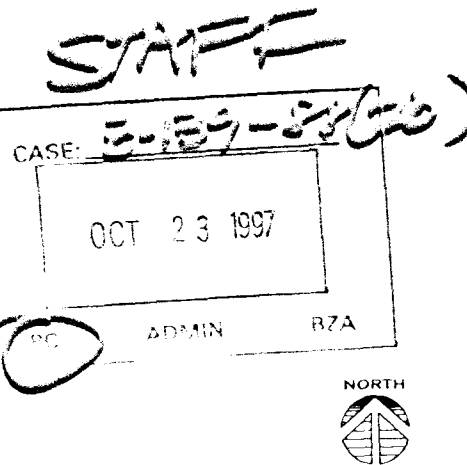

GENERAL NOTES


- SEE CIVIL DRAWINGS FOR ALL SITE LAYOUT DIMENSIONS, CURBS, OUTLETS AND PLANTINGS.
- SEE CIVIL, PLUMBING AND ELECTRICAL DRAWINGS FOR UTILITY LINES.
- SEE CIVIL DRAWINGS FOR ALL GRADING AND DRAINAGE.
- SITE LAYOUT IS TO BE COORDINATED WITH CIVIL DRAWINGS OF EXISTING AND FUTURE UTILITIES. THE ARCHITECT IS TO BE NOTIFIED OF ANY DISCREPANCIES.
- ALL SITE CONC: SHALL RECEIVE REINFORCED PLANE JOINTS @ 10'-0" O.C. AND TOGGLED JOINTS @ 8'-0" O.C.
- ALL CONCRETE WALKS, LANDINGS, ETC. SHALL RECEIVE EXPOSED AGGREGATE FINISH.
- GRADE ALL PLANTED AREAS AWAY FROM BUILDING EX.
- ALL PARKING A/C PAVING, IMPERMEABLE AND CURBS ARE EXISTING UNLESS NOTED OTHERWISE.
- ALL SITE DRAINAGE SHOULD BE COORDINATED WITH ELECTRICAL PLANS. SEE ELECTRICAL DRAWINGS FOR ALL DRAINAGE AND/OR.
- L.A. DETERMINE LANDSCAPE AREA.

ARCHITECT: GERALD GARACH • AIA
 • & ASSOCIATES
 10 COMMERCE CENTER DRIVE
 HENDERSON, NV 89014
 (702) 454-3012 FAX (702) 454-7842

PROJECT TITLE: TACO BELL
 SAHARA & FT. APACHE
 LAS VEGAS, NEVADA

DESIGNER: DAN STEVENSON
 DESIGN SERVICES
 1000 S. RAMPART BLVD., SUITE 100
 LAS VEGAS, NV 89102
 (702) 454-3012 FAX (702) 454-7842



PROJECT NO.: 15-130-80(100)
 SHEET NO.: A1.01
 DATE: 10/23/97

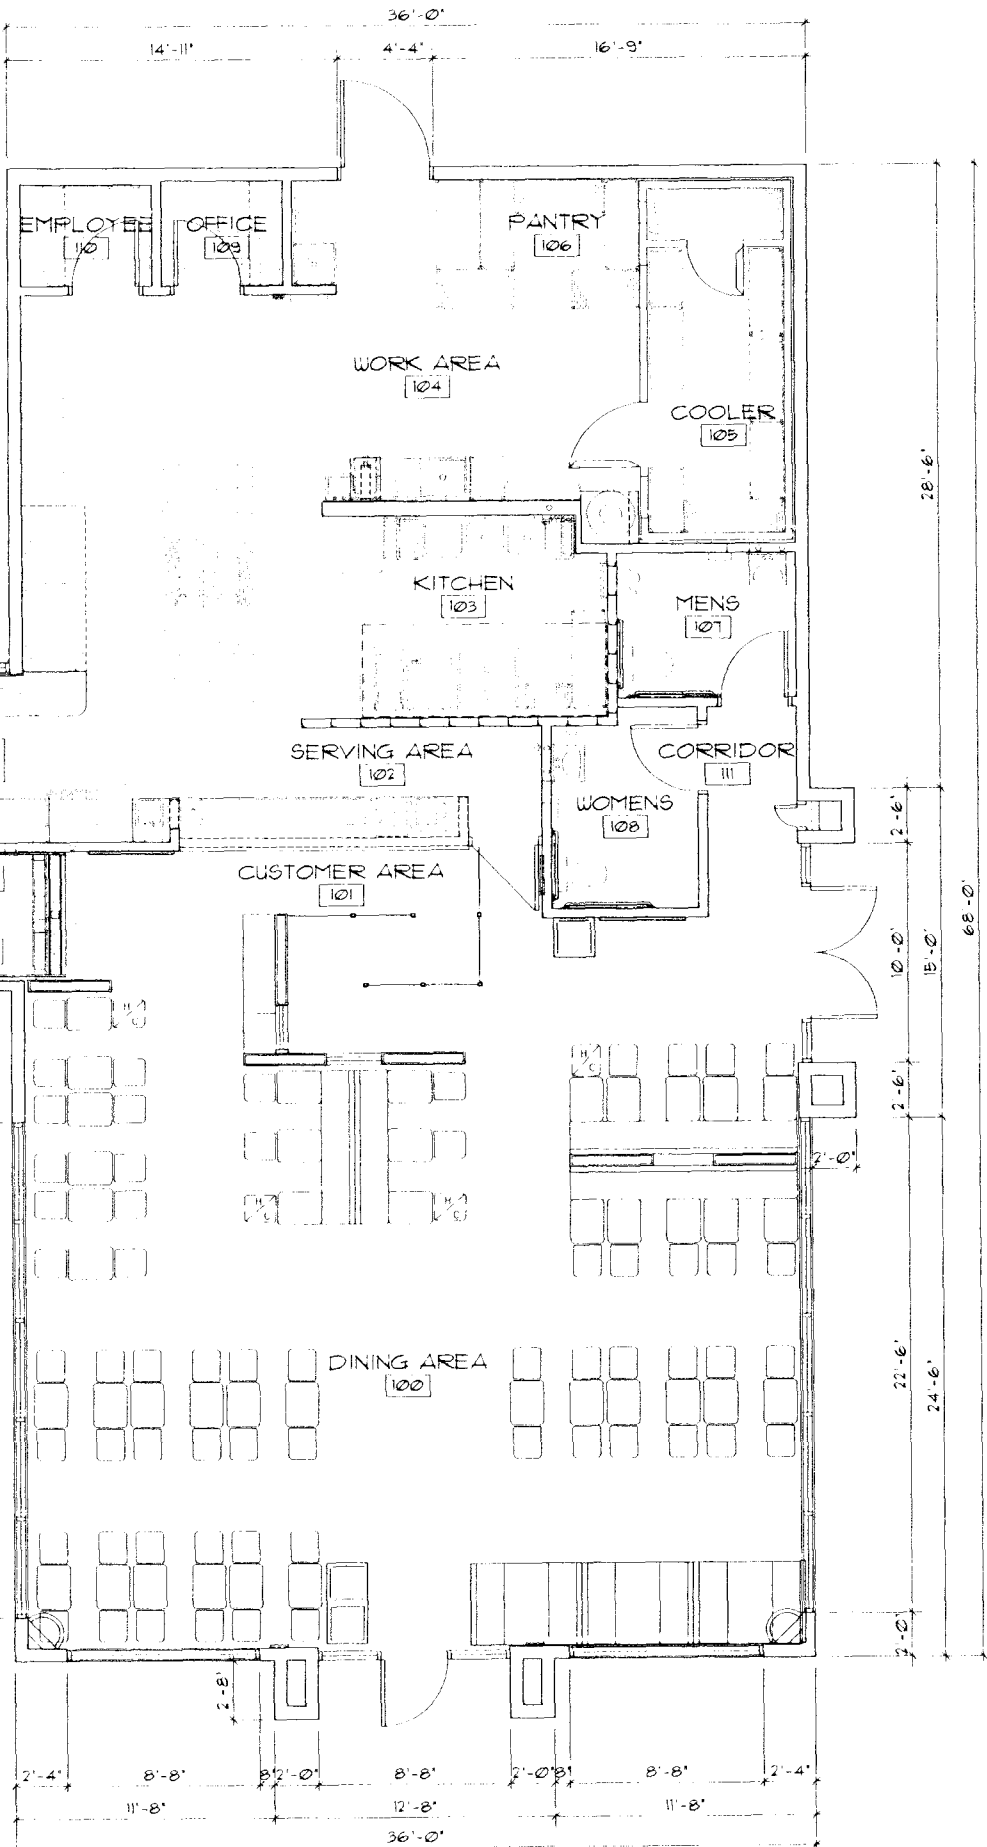

BUILDING AREA:
2,418 SQ. FT.

AREA NO.	AREA NAME	SQ. FT.	USAGE
100	DINING AREA	984 SQ. FT.	ASSEMBLY AREA
101	CUSTOMER AREA	247 SQ. FT.	WAITING AREA
102	SERVING AREA	104 SQ. FT.	ASSEMBLY AREA
103	KITCHEN AREA	248 SQ. FT.	KITCHEN
104	WORK AREA	276 SQ. FT.	KITCHEN
105	COOLER	276 SQ. FT.	STORAGE
106	PANTRY AREA	71 SQ. FT.	STORAGE
107	MEN'S TOILET	53 SQ. FT.	AUXILIARY
108	WOMEN'S TOILET	58 SQ. FT.	AUXILIARY
109	OFFICE	26 SQ. FT.	OFFICE
110	EMPLOYEE	27 SQ. FT.	OFFICE
111	CORRIDOR	38 SQ. FT.	CIRCULATION

STAFF

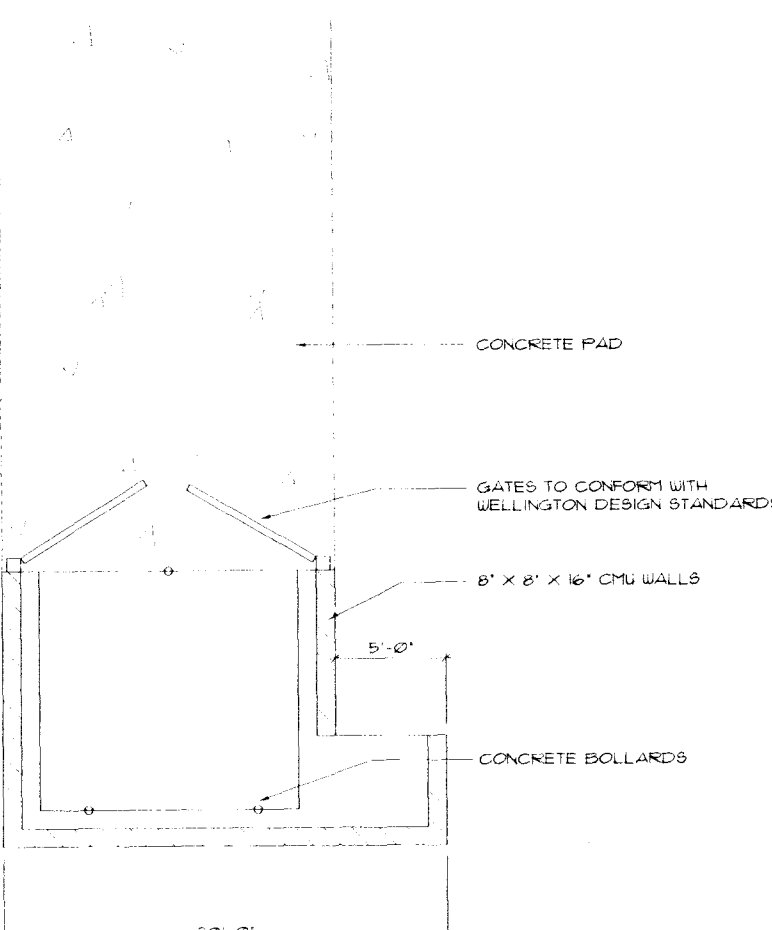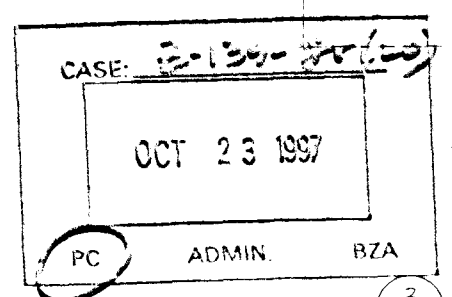

TRASH ENCLOSURE

SCALE: 1/4"=1'-0"

ARCHITECT: GERALD GARACH • AIA
 • & ASSOCIATES
 10 COMMERCE CENTER DRIVE
 HENDERSON, NV 89014
 (702) 454-3012 FAX (702) 454-7842

PROJECT TITLE: TACO BELL
 SAHARA & FT. APACHE
 LAS VEGAS, NEVADA

DESIGNER: DAN STEVENSON
 DESIGN SERVICES
 1000 S. RAMPART BLVD., SUITE 100
 LAS VEGAS, NV 89102
 (702) 454-3012 FAX (702) 454-7842

PROJECT NO.: 15-130-80(100)
 SHEET NO.: A1.01
 DATE: 10/23/97