
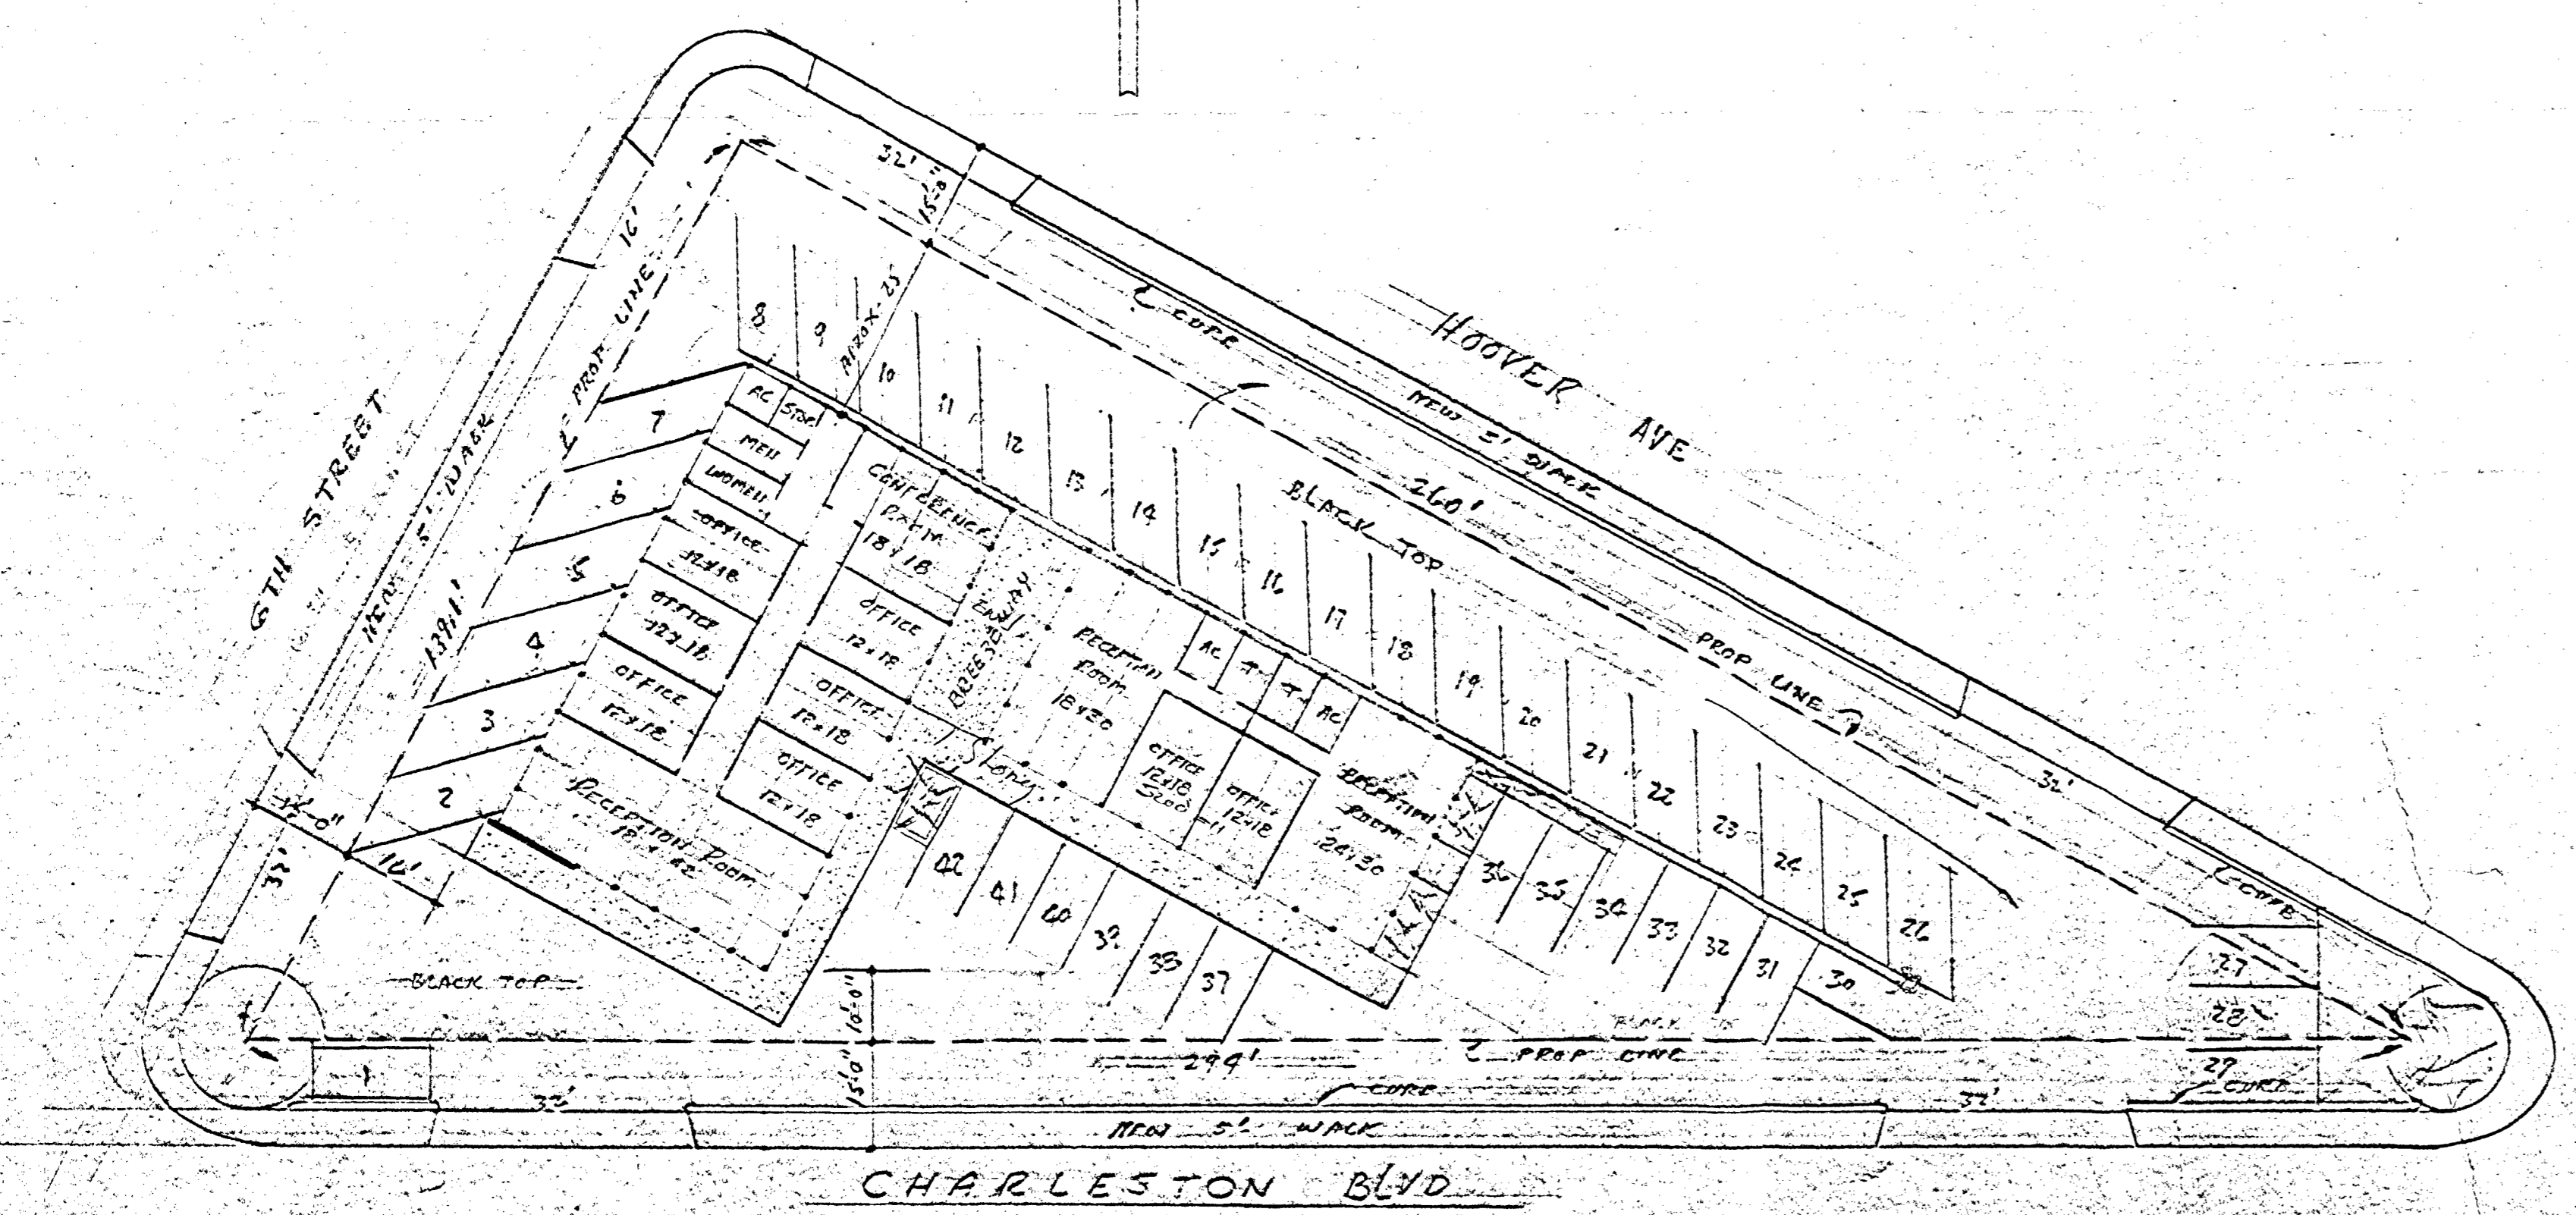


CHARLESTON BLVD  
ELEVATION

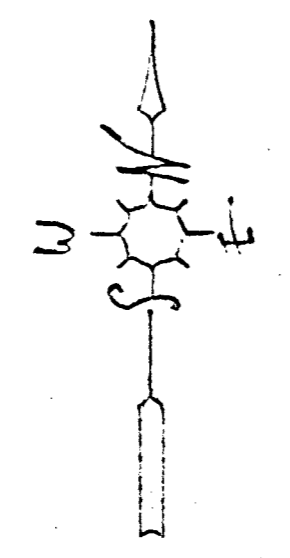

LIST OF DRAWINGS

SHEET 1	PLOT PLAN.
SHEET 2	FOUNDATION PLAN.
SHEET 3	FLOOR PLAN.
SHEET 4	ELEVATIONS.
SHEET 5	ROOF FRAMING PLAN.
SHEET 6	SECTIONS & DETAILS.
SHEET 7	SECTIONS & DETAILS.
SHEET 8	ELECTRICAL DETAILS.
SHEET 9	AIR-CONDITIONING PLAN.
SHEET 10	PLUMBING PLAN.


53

DRAWN FROM SKETCHES & CALCULATIONS  
BY NORMAN T. HILBRECHT  
REG. PROF. ENG. NO. 449

MAY SHEET 1  
OF  
19 SHEETS  
PLOT PLAN

OFFICE BUILDING.

ROUND UP REAL ESTATE  
L.A.S.V.E.G.A.S. N.E.V.  
CHARLESTON BLVD. AT 6TH ST.  
drawn by Don VanCamp designer

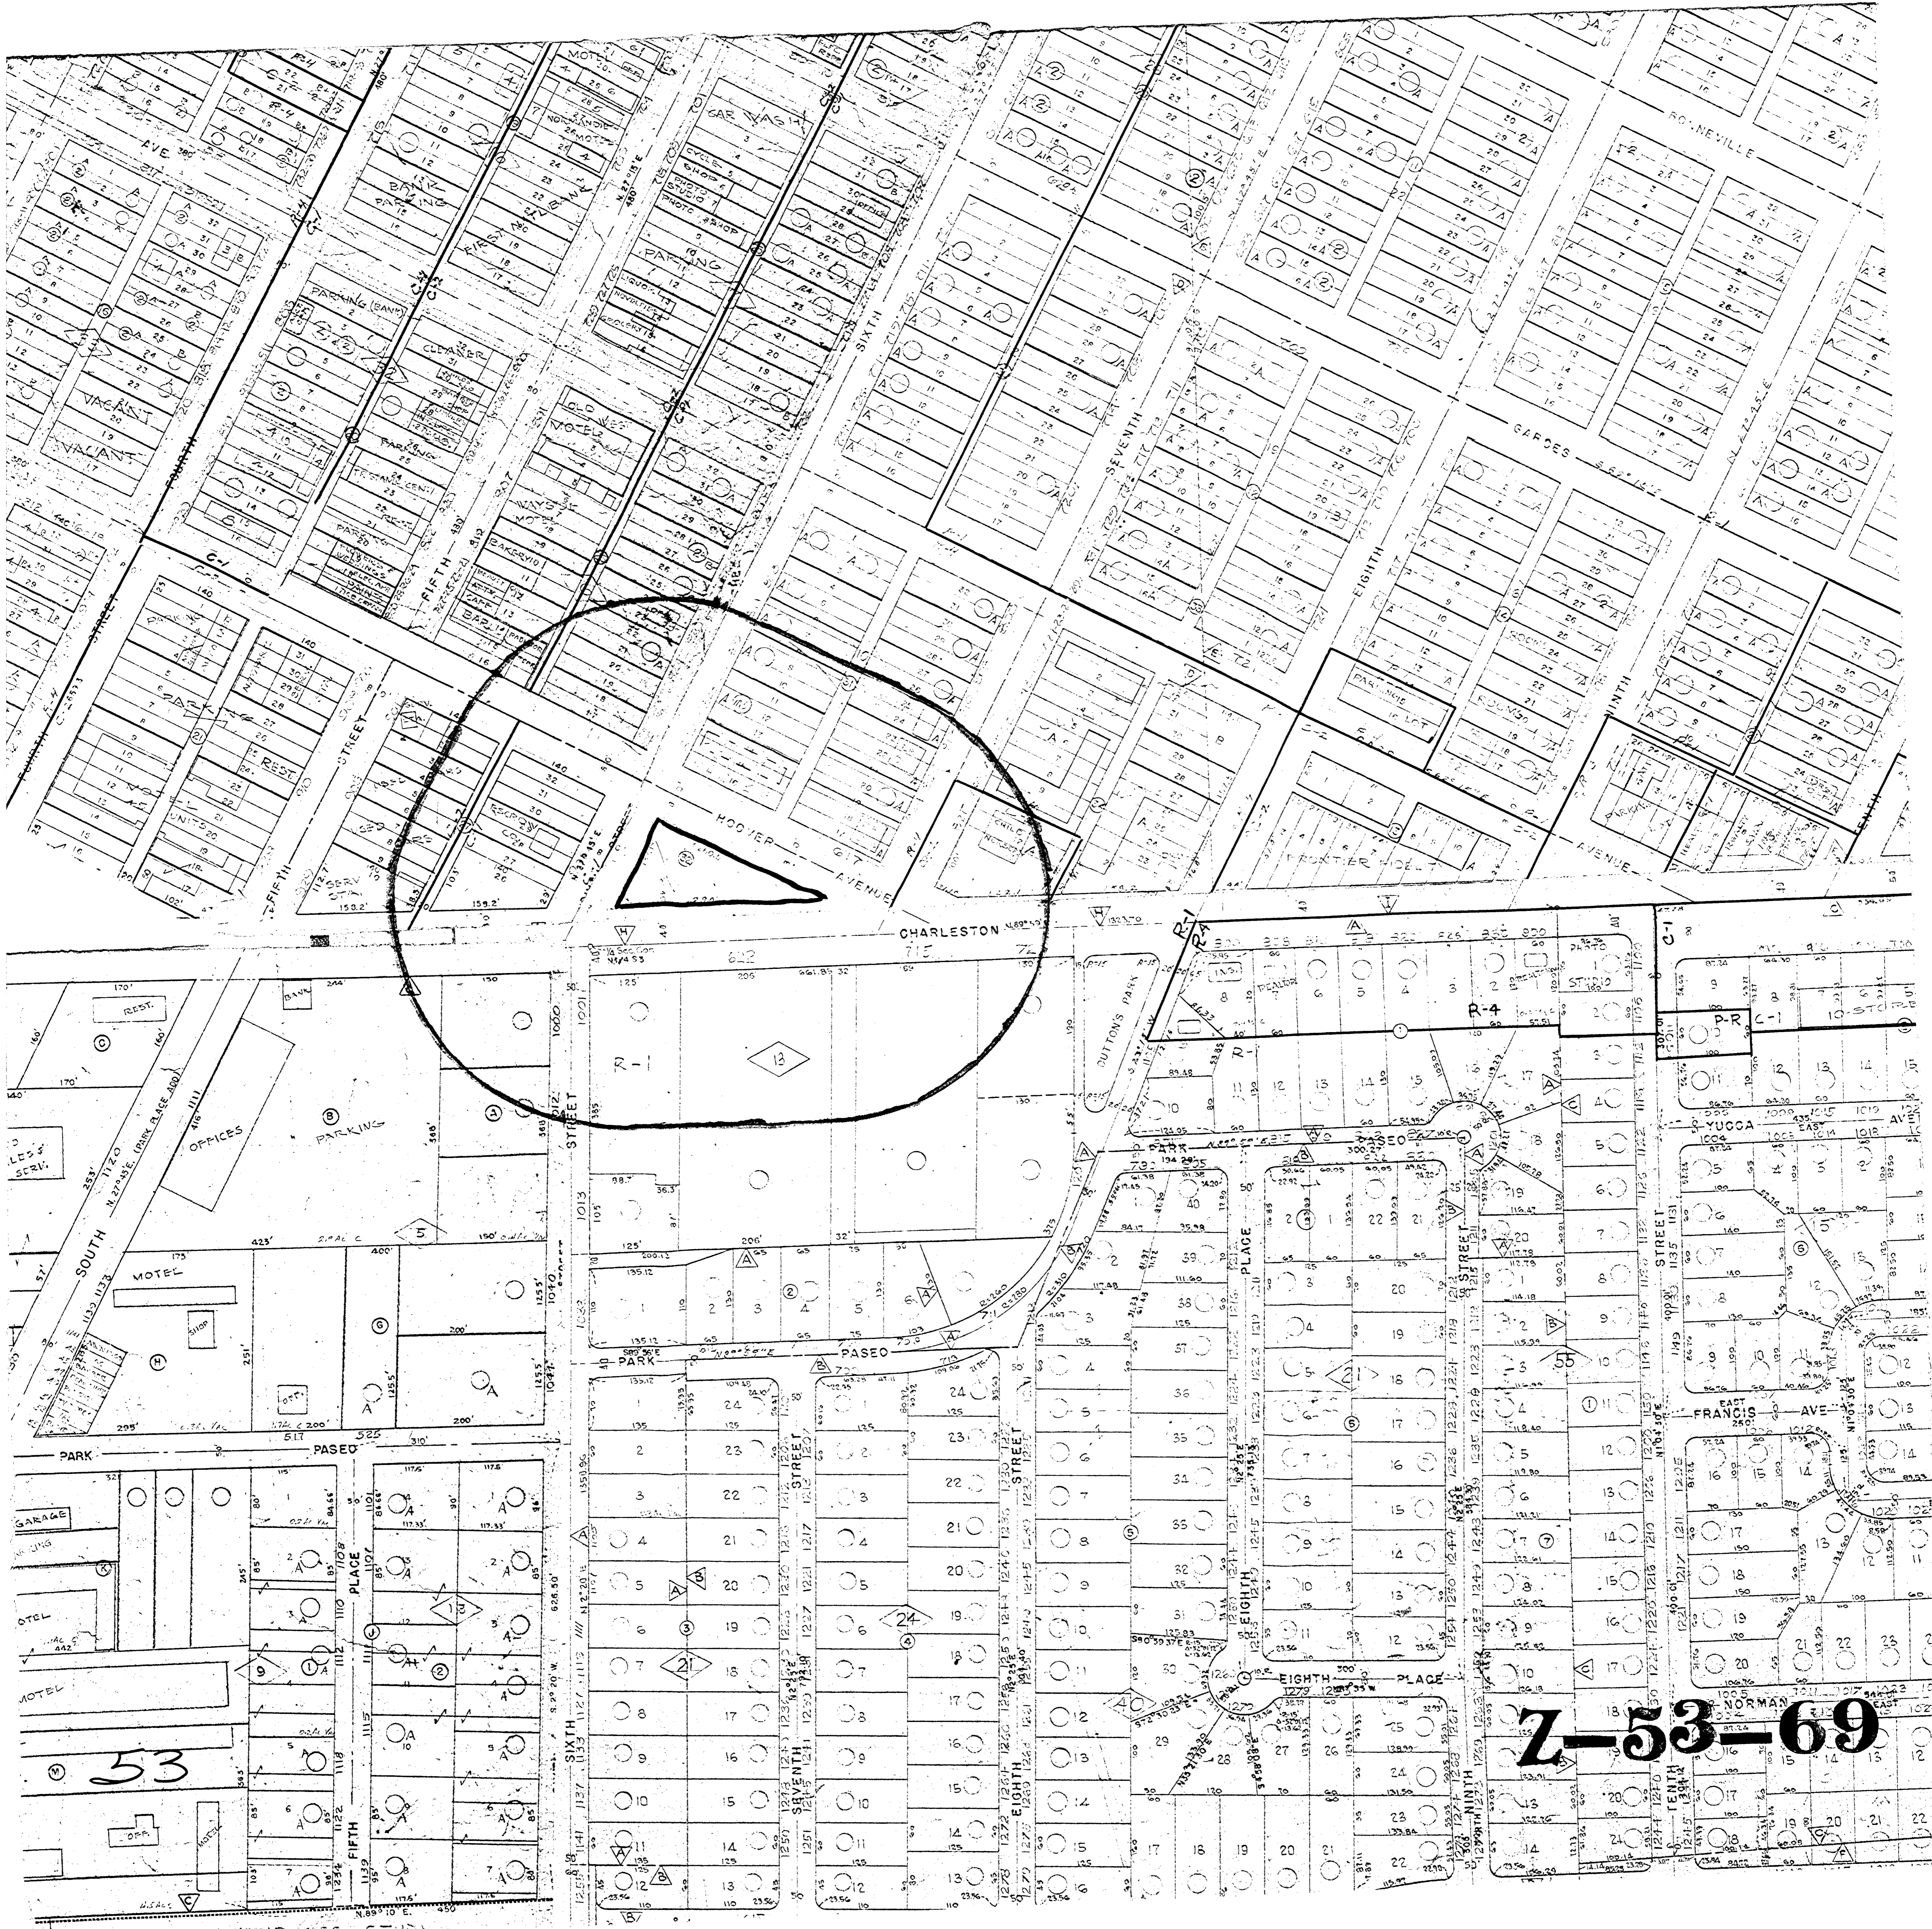

53

Z-53-69