


P:\PROJECTS\105_003_MOONVALLEYPLANS\DWG\105_003_E_SITE.DWG - T000 - 7/11/2007 10:52 AM

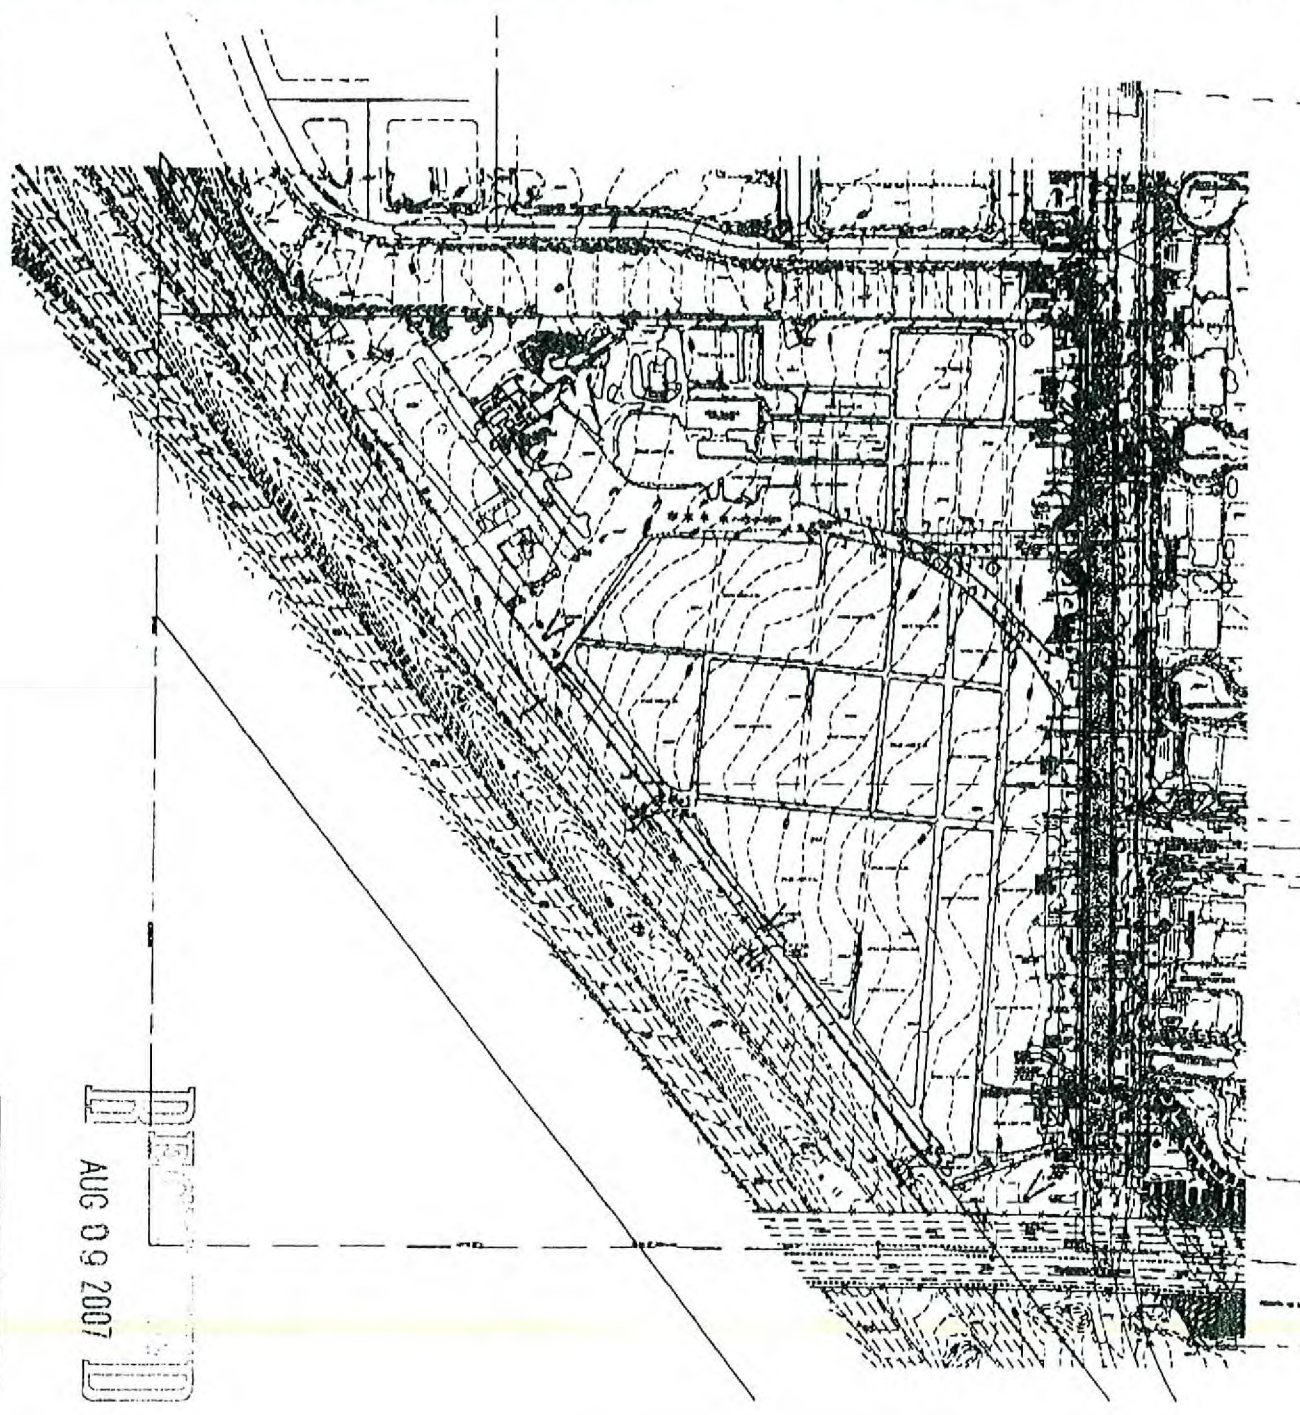

REVISION
AUG 09 2007

SHEET

SITE PLAN



Consulting Civil Engineers, Inc.

351 B. Valley View Bldg. T101 • Las Vegas, NV 89103
(702) 222-0747 • (702) 744-1041 fax

TITLE

MOON VALLEY NURSERIES

DRAWN BY: TN

PROJECT NUMBER: 4106.023

DESIGNED BY: TN

SHEET

CHECKED BY: VR

1

DATE: 7/11/07

OF 1 SHEETS