



1 PLUMBING SITE PLAN
SCALE 1/4" = 1'-0"

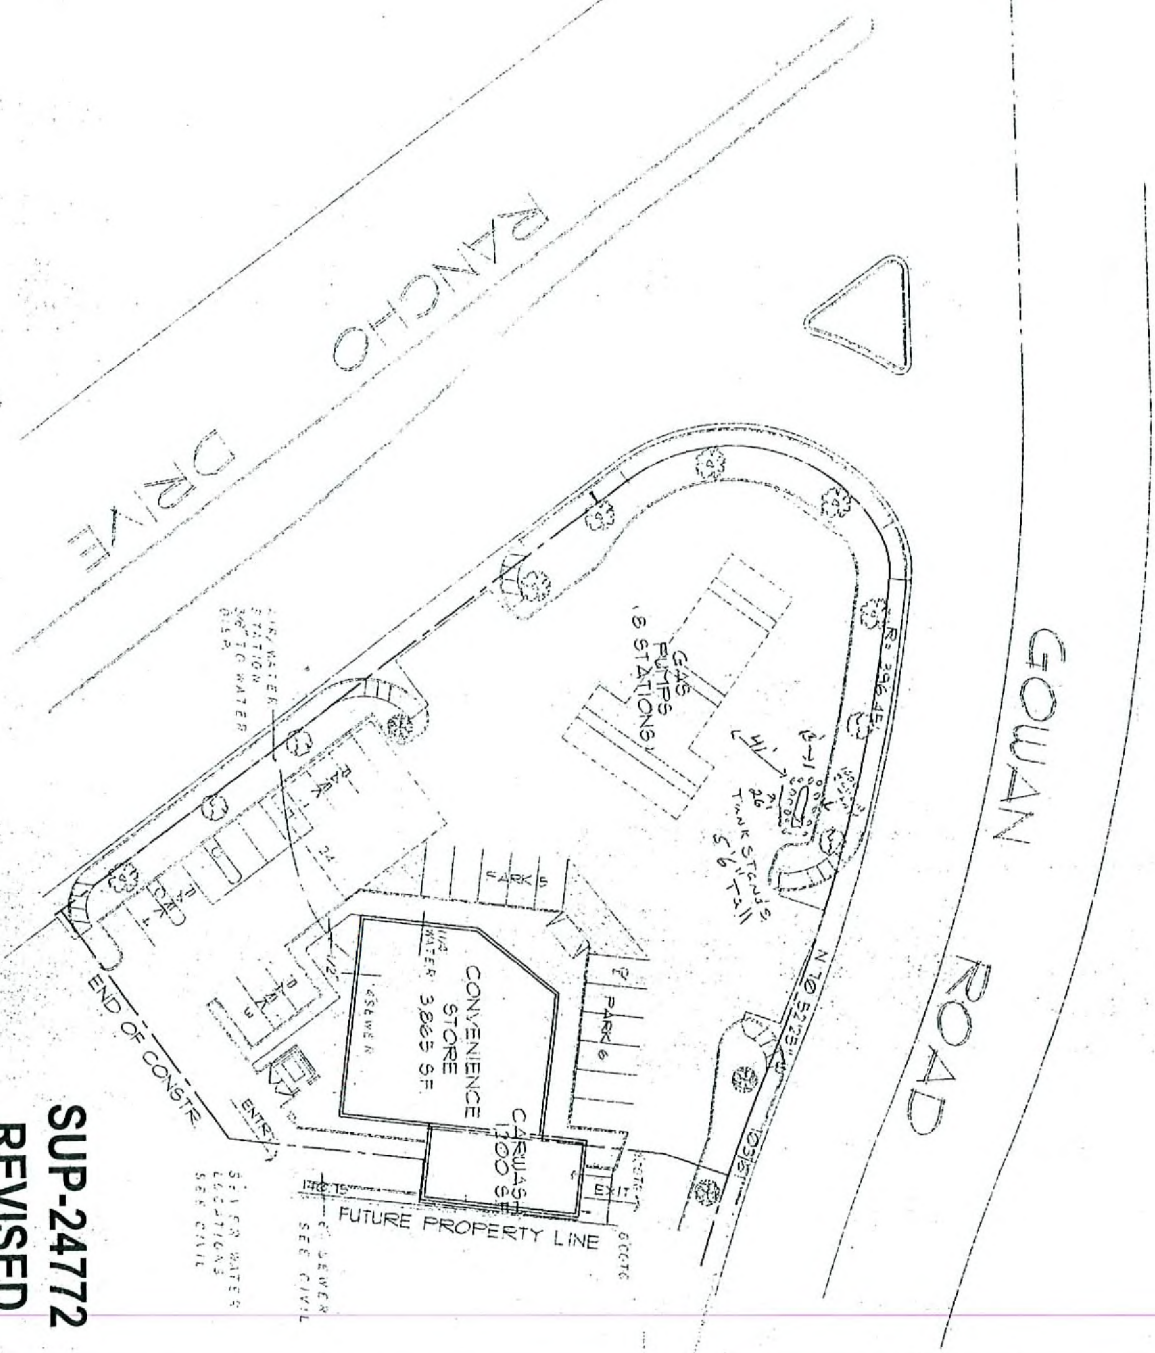

SUP-24772
REVISED
11/08/07 PC

LOCATION

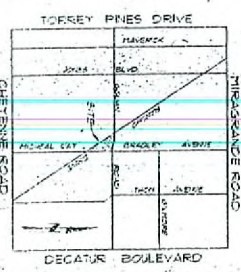

OCT 12 2007

sheet no.	date
P-4	
proj. no.	
drwn. by	
chkd. by	

FUNNY'S II
CONVENIENCE STORE
& CARWASH
FOR: STEVE & ERIN FUNSTON
CLARK COUNTY NEVADA

SAND'S PLUMBERS
SITE PLAN

revisions
▲
▲
▲
▲

DATE PLOTTED: 11/08/07 10:58 AM
SCALE: 1/4" = 1'-0"