



PLANNING & DEVELOPMENT DEPARTMENT

STATEMENT OF FINANCIAL INTEREST

Case Number: **SUP-28293** APN: 162-06-510-003

Name of Property Owner: Mahill LLC

Name of Applicant: Skywaves West

Name of Representative: Marken Telecom Services

To the best of your knowledge, does the Mayor or any member of the City Council or Planning Commission have any financial interest in this or any other property with the property owner, applicant, the property owner or applicant's general or limited partners, or an officer of their corporation or limited liability company?

☐ Yes

☒ No

If yes, please indicate the member of the City Council or Planning Commission who is involved and list the name(s) of the person or persons with whom the City Official holds an interest. Also list the Assessor's Parcel Number if the property in which the interest is held is different from the case parcel.

City Official: _____

Partner(s): _____

APN: _____

Signature of Property Owner: *Mahill LLC*

Print Name: Mahill LLC by Merrill K. Mulsberg

State of Nevada, Clark County
Subscribed and sworn before me

This 23 day of April, 2008

Maria Lino Huber

Notary Public in and for said County and State

Clark, Nevada



NV-LSV124
4221 W CHARLESTON BLVD
LAS VEGAS, NV 89102
PARCEL NUMBER: 162-06-510-003

PROJECT NAME:

NV-LSV124

4221 W CHARLESTON BLVD
LAS VEGAS, NV 89102
JURISDICTION: LAS VEGAS

JO DESIGN & MANAGEMENT
300 WEST VIA DE ARIZOLE
QUEEN CREEK, AZ 85240
OFFICE: 480-877-2880
FAX: 480-877-2881

CLIENT:
CLEANLINE WIRELESS BROADBAND
4000 CAMDEN POST
KIRKLAND, WA. 98033


DESIGN SERVICES:
JO BRUNN & MANAGEMENT
305 W. VA ST. AUSTIN
GUYTON GRIFF, AIA, LEED-AP
CONTACT: JOHN COLLINS
E-MAIL: john@jbrunn.com
PHONE: (408) 677-2000 FAX: (408) 677-2000

R.A. WAGNER, INC., LLP
2077 E. WASH. SPRING ROAD SUITE 200
LAS VEGAS, NV 89120
CONTACT: JAMES BRITAIN, PE
PHONE: (702) 892-2828 FAX: (702) 892-2828

POWER:
NEVADA POWER COMPANY
(702) 867-4000

TELEPHONE:
BROAD
(702) 261-2022

THIS PROPOSED PROJECT IS AN UNOCCUPIED TELECOMMUNICATIONS FACILITY AND IS NOT TO BE ACCESSIBLE BY THE GENERAL PUBLIC. THIS FACILITY IS EXEMPT FROM INSULATED ACCESS REQUIREMENTS PER 490 1100.5.6 LISTED AS AN EXEMPT SPACE.

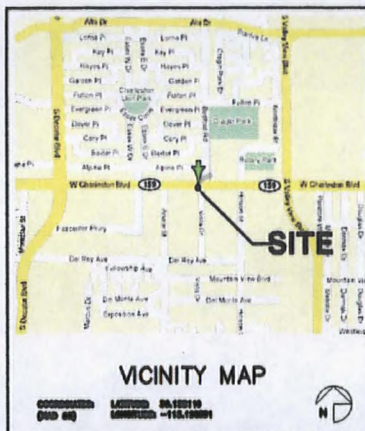

ENDING AT THE CLERKING OFFICE AT 1001 MARY STREET N. MINNEAPOLIS. TURN RIGHT ONTO I-210 W. TAKE EXIT 112A/140 WEST ONTO I-15 N. TAKE EXIT 440/1400A ON. TURN LEFT ON S BROAD AVENUE-300 W. TURN RIGHT ON S VALLEY VIEW. SIGN. TURN LEFT ON W CHALGATION (1001)

SITE NAME	HP-LOV154
SITE ADDRESS	4041 W CHAMBERLIN BLVD LAS VEGAS, NV 89146
APPLICANT	CLARKSON WHEELS INCORPORATED 440 CHAMBERLIN FORT MILLAND, WA 99003
PROPERTY OWNER	CHURCH & DWIGHT PHONE 602-433-1700

- THE INSTALLATION OF NEW OUTSIDE BUS CABINET LOCATED ON A PRE-MANUFACTURED STEEL PLATFORM (DESIGNED BY OTHERS) AT GRID.
- THE EQUIPMENT WILL REQUIRE 100 AMPS AND THE POWER POINT OF FIELD WILL BE DETERMINED ONCE A NEVADA POWER ORDER IS RECEIVED.
- INSTALLATION OF ANTENNAS AND TOW HEADS AND NEIGHBORHOOD HOMES AROUND THE SUBSTATION ARE 1 AND 2ND APTS. WILL ALSO BE INSTALLED.

ADDRESS PANEL NUMBER	100-00-010-000
CURRENT BOARD	LAND COMBUSTION SURVEY (0-1)
BUILDING CLASSIFICATION	—
PROPOSED AREA OF CONSTRUCTION	7'0" x 21' 00" FT.
PROPOSED OCCUPANCY	U-POLE
TYPE OF CONSTRUCTION	IS
POWER SUPPLY	MEXICO POWER
REMARKS	TO 20 POWER POLE AT STREET

SHT NO.	SHEET DESCRIPTION	REV
T-1	TITLE SHEET	2
A-1	SITE PLAN	2
A-2	ENLARGED SITE PLAN, SOUTH ELEVATION	2
A-3	SOUTH ELEV. WEST ELEVATIONS	2

JURISDICTION: CITY OF LAS VEGAS
INTERNATIONAL BUREAU CODE (IBO) 2000 EDITION
WITH NADRA STATE AMENDMENTS
NATIONAL ELECTRIC CODE (NEC) 2000 EDITION
NATIONAL MECHANICAL CODE (NMC) 2000 EDITION
UNIFORM PLUMBING CODE (UPC) 2000 EDITION
UNIFORM FIRE CODE (UFC) 2000 EDITION
ANSI/ASHRAE 90-2007 STANDARDS FOR BROADCAST STRUCTURES
LOCAL CODES AND ORDINANCES
IN THE EVENT OF A CONFLICT, THE MOST RESTRICTIVE CODE

PROPERTY OWNER/LANDLORD	DATE
SOURCE	DATE
GLASSBORO R.F. BINDER	DATE
GLASSBORO WATER COMPANY	DATE
GLASSBORO CONSTRUCTION	DATE
GLASSBORO NATIONAL	DATE

THE SCALD BRANDS VOTING ON OR EACH BRAND ARE FOR A FULL
BOX BRANDS ONLY (11117). IF PLATED BRASS OR LAMIN
PLEASE USE THE BOX SCALE AS THE REFERENCE

SUP-28293
VAR-28296
07/10/08 PC

RECEIVED

MAY 23 2008

SCHEDULE OF REVISIONS			
7	==	==	
8	==	==	
9	==	==	
10	==	==	
11	==	==	
12	04/24/00	SECOND SUBMITAL	
13	04/25/00	SECOND	
14	04/26/00	LOWER COST	
REV	DATE	DESCRIPTION OF CHANGES	
DESIGNED BY	AS	NR	CHECKED BY
SCALE: 8/85 SHEWNA			

ENGINEERING SEAL

ZONING SUBMITTAL ONLY


THE INFORMATION CONTAINED HEREIN IS UNCLASSIFIED EXCEPT WHERE SHOWN OTHERWISE BY INDICATING ANY OTHERWISE.

DRAWING TITLE:


TITLE SHEET

DRAWING SHEET

T-1

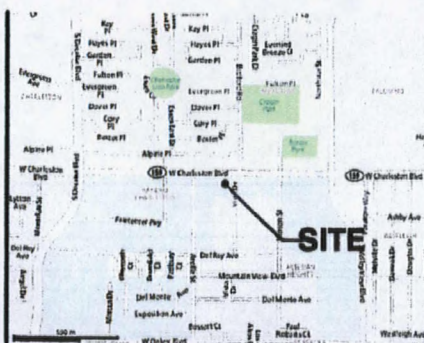

② VICINITY MAP
SCALE: NONE

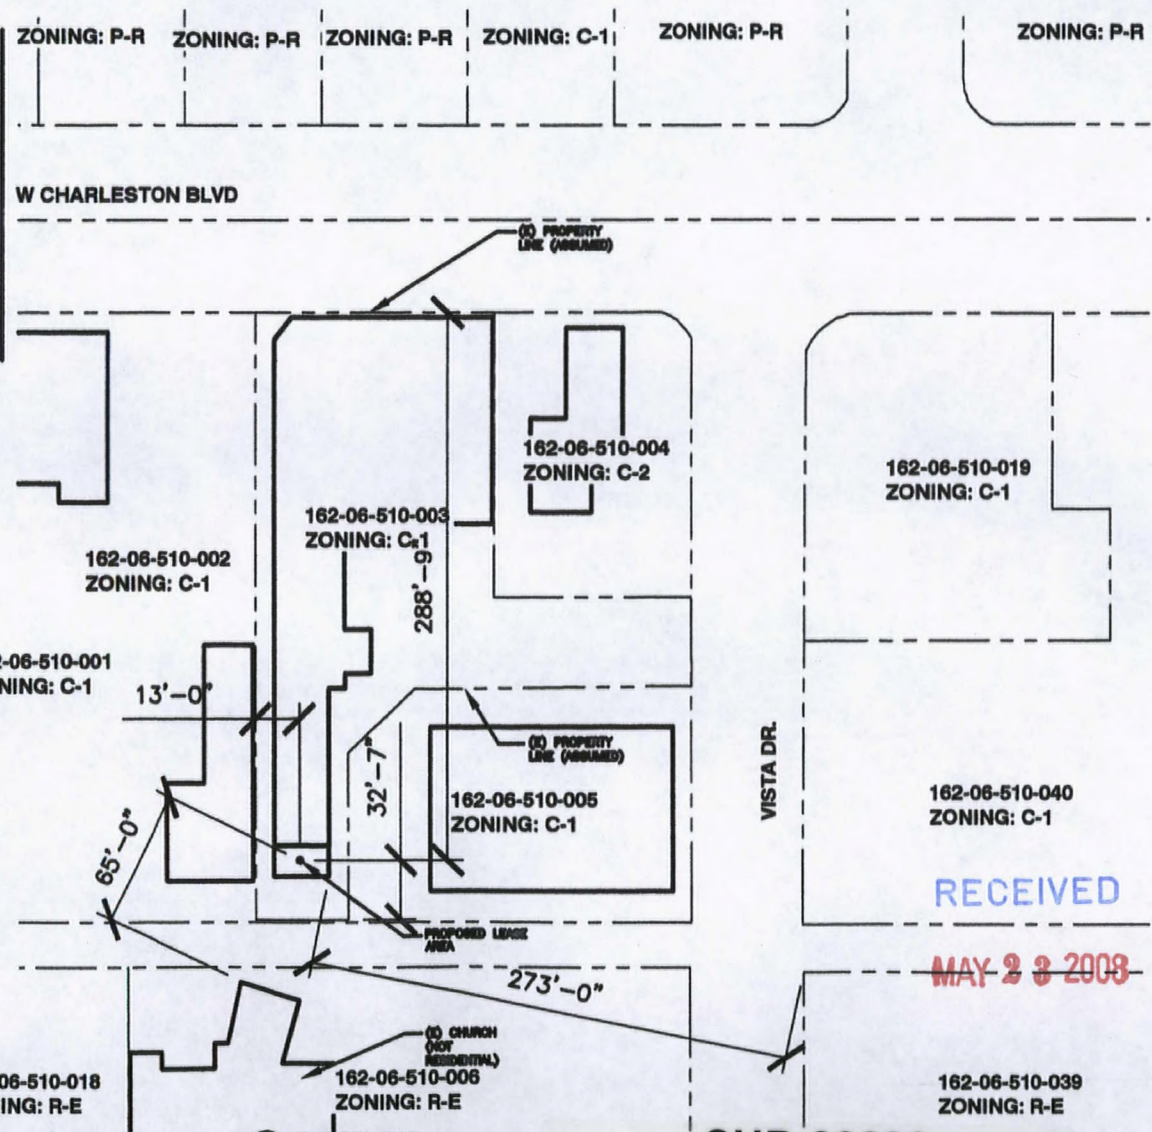

① PARCEL MAP
SCALE: 1/8"=1'-0"

SUP-28293
VAR-28296
07/10/08 PC

clearwire
wireless broadband
8275 PEARL ST. SUITE 200
LAS VEGAS, NV 89120

PROJECT NAME:
NV-LSV124
4321 W CHARLESTON BLVD
LAS VEGAS, NV 89162
JURISDICTION: LAS VEGAS

JO DESIGN &
MANAGEMENT
390 WEST VIA DE ARCOLES
CLARK COUNTY, NV 89540
PHONE: 702-731-8880
FAX: 702-731-8880

SCHEDULE OF REVISIONS	
1	AS SHOWN
2	AS SHOWN
3	AS SHOWN
100	AS SHOWN

ENGINEERING SEAL
ZONING SUBMITTAL ONLY


THIS INFORMATION CONTAINED HEREIN IS THE PROPERTY OF CLEARWIRE. IT IS TO BE USED FOR THE PROJECT AND NOT BE LOANED, REPRODUCED, COPIED, OR IN ANY MANNER DISCLOSED TO ANY OTHER PARTY WITHOUT THE WRITTEN PERMISSION OF CLEARWIRE.

DRAWING TITLE:
OVERALL PARCEL PLAN

DRAWING SHEET:
A-1

RECEIVED

MAY 23 2008

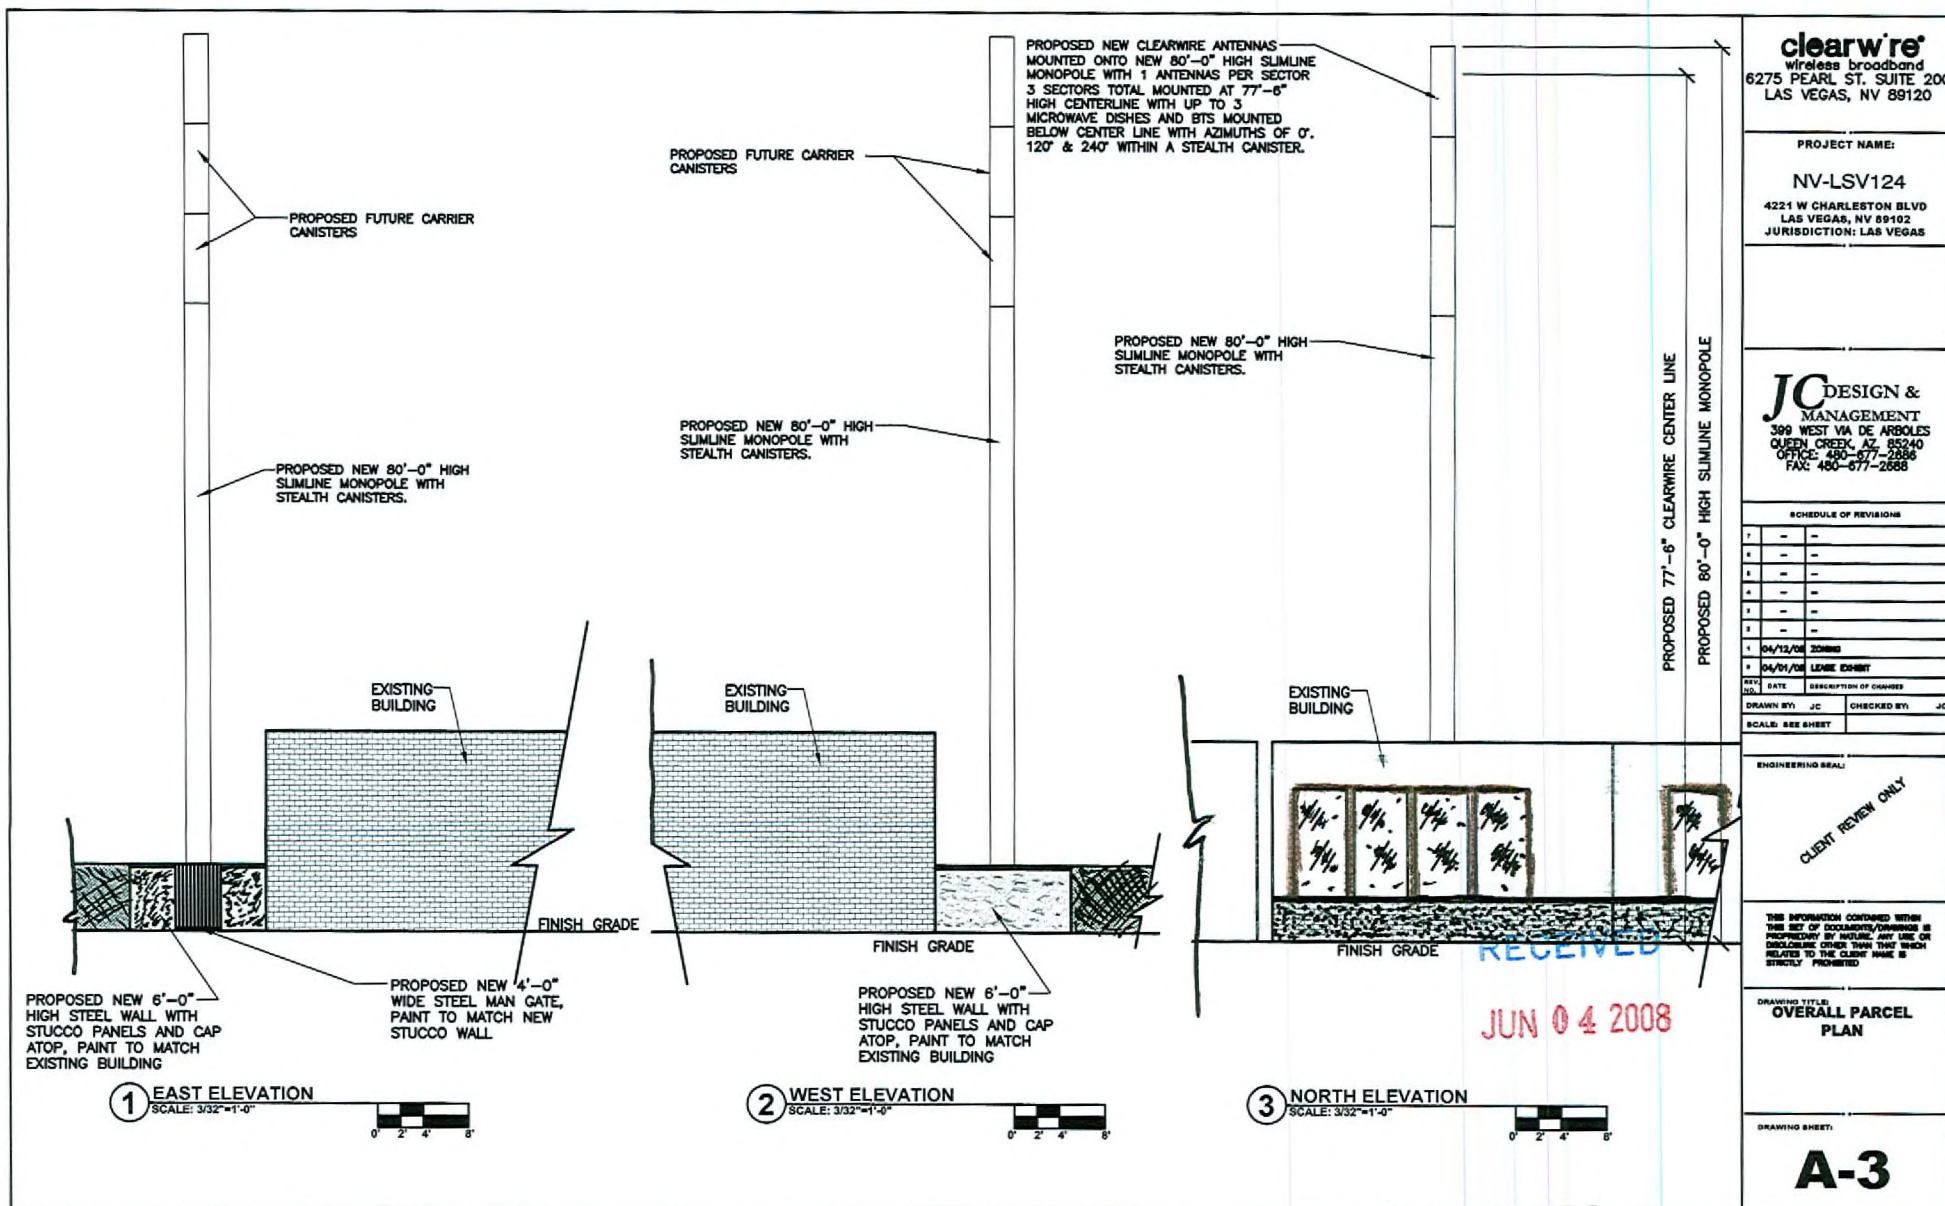

clearw're
wireless broadband
6275 PEARL ST. SUITE 200
LAS VEGAS, NV 89120

PROJECT NAME:

NV-LSV124

4221 W CHARLESTON BLVD
LAS VEGAS, NV 89102
JURISDICTION: LAS VEGAS

JC DESIGN & MANAGEMENT
399 WEST VIA DE ARBOLES
QUEEN CREEK, AZ 85240
OFFICE: 480-677-2886
FAX: 480-677-2888

SCHEDULE OF REVISIONS

NO.	DATE	DESCRIPTION OF CHANGES
1	04/12/08	ISSUED
2	04/12/08	LOOSE EXIST
3	04/12/08	LOOSE EXIST
4	04/12/08	LOOSE EXIST
5	04/12/08	LOOSE EXIST
6	04/12/08	LOOSE EXIST
7	04/12/08	LOOSE EXIST
8	04/12/08	LOOSE EXIST
9	04/12/08	LOOSE EXIST
10	04/12/08	LOOSE EXIST
11	04/12/08	LOOSE EXIST
12	04/12/08	LOOSE EXIST
13	04/12/08	LOOSE EXIST
14	04/12/08	LOOSE EXIST
15	04/12/08	LOOSE EXIST
16	04/12/08	LOOSE EXIST
17	04/12/08	LOOSE EXIST
18	04/12/08	LOOSE EXIST
19	04/12/08	LOOSE EXIST
20	04/12/08	LOOSE EXIST

ENGINEERING SEAL

CLIENT REVIEW ONLY

THIS INFORMATION CONTAINED HEREIN IS THE PROPERTY OF CLEARWIRE. IT IS TO BE USED ONLY FOR THE PROJECT AND SITE SPECIFICALLY IDENTIFIED HEREIN. NO PART OF THIS DOCUMENT IS TO BE REPRODUCED OR TRANSMITTED IN ANY FORM OR BY ANY MEANS, ELECTRONIC OR MECHANICAL, INCLUDING PHOTOCOPYING, RECORDING, OR BY ANY INFORMATION STORAGE AND RETRIEVAL SYSTEM, WITHOUT THE WRITTEN PERMISSION OF CLEARWIRE.


DRAWING TITLE:
OVERALL PARCEL PLAN

DRAWING SHEET:


A-3

SUP-28293
VAR-28296
07/10/08 PC

162-06-510-003

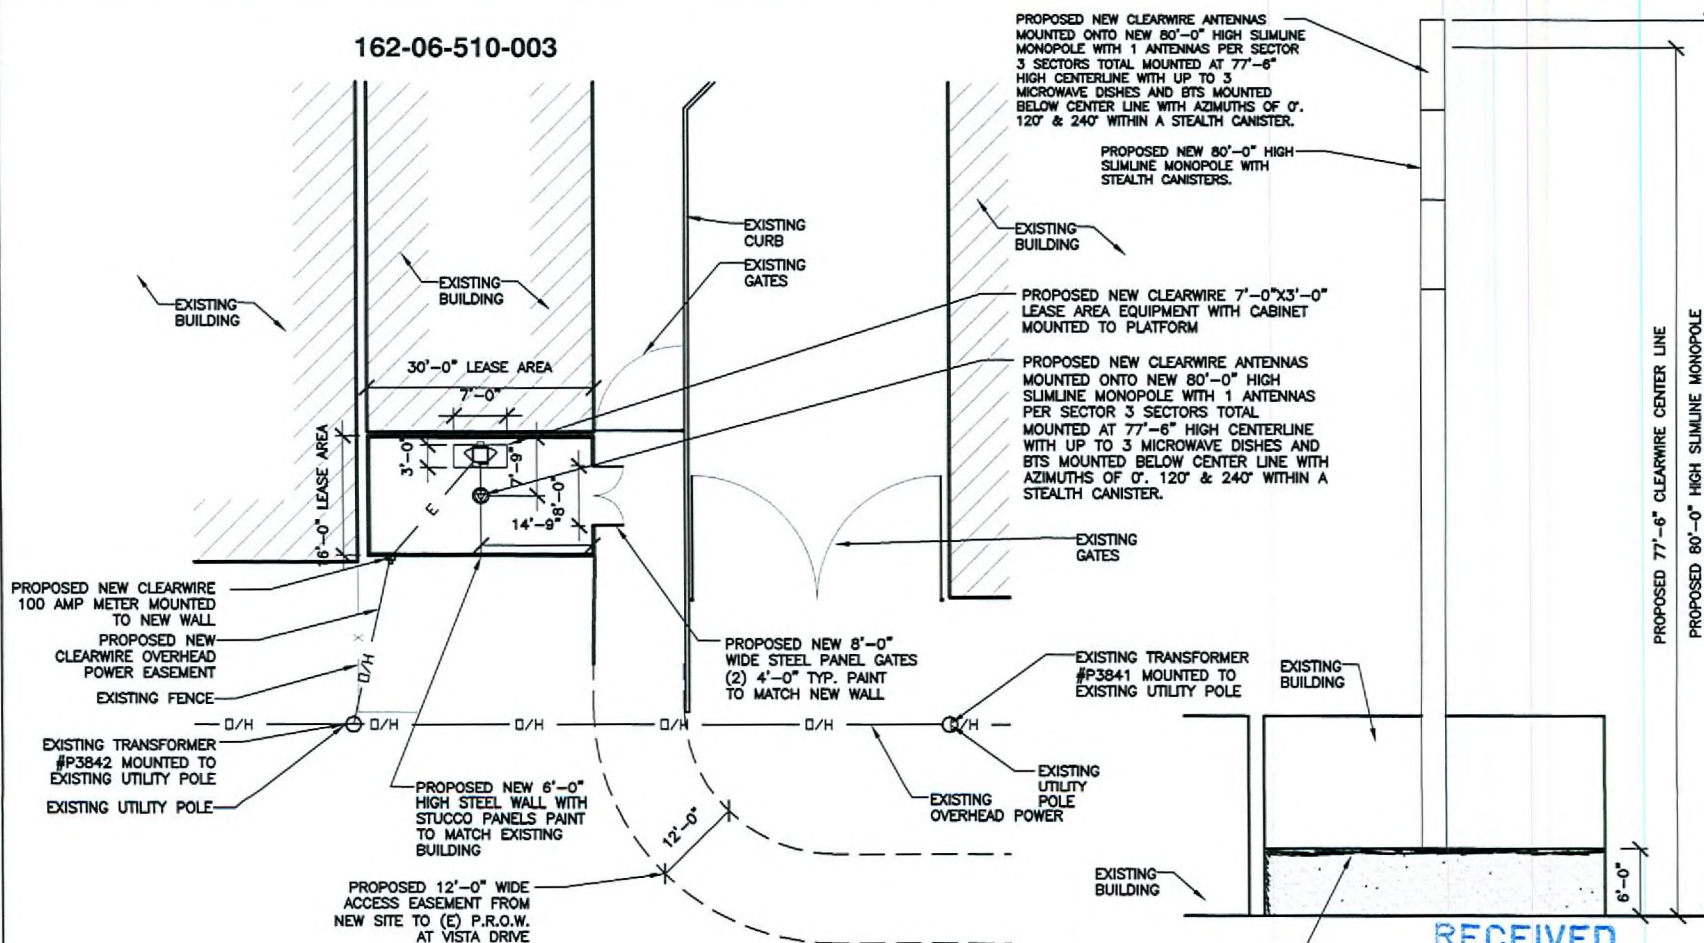

1 LEASE AREA PLAN
SCALE: 1/16"=1'-0"

 

2 ELEVATION
SCALE: 3/32"=1'-0"



clearwire
wireless broadband
6275 PEARL ST. SUITE 200
LAS VEGAS, NV 89120

PROJECT NAME:

NV-LSV124

4221 W CHARLESTON BLVD
LAS VEGAS, NV 89102
JURISDICTION: LAS VEGAS

JC DESIGN & MANAGEMENT
399 WEST VIA DE ARBOLES
QUEEN CREEK, AZ 85240
OFFICE: 480-677-2555
FAX: 480-677-2558

SCHEDULE OF REVISIONS

NO.	DATE	DESCRIPTION
1	04/12/08	ISSUED
2	04/12/08	REVISION
3	04/12/08	REVISION
4	04/12/08	REVISION
5	04/12/08	REVISION
6	04/12/08	REVISION
7	04/12/08	REVISION
8	04/12/08	REVISION
9	04/12/08	REVISION
10	04/12/08	REVISION

REV.	DATE	DESCRIPTION
1	04/12/08	ISSUED
2	04/12/08	REVISION
3	04/12/08	REVISION
4	04/12/08	REVISION
5	04/12/08	REVISION
6	04/12/08	REVISION
7	04/12/08	REVISION
8	04/12/08	REVISION
9	04/12/08	REVISION
10	04/12/08	REVISION

SCALE: SEE SHEET

ENGINEERING SEAL

CLIENT REVIEW ONLY

THIS INFORMATION CONTAINED HEREIN IS THE PROPERTY OF CLEARWIRE. ANY USE OR DISCLOSURE OTHER THAN THAT WHICH RELATES TO THE CLIENT NAME IS STRICTLY PROHIBITED.

DRAWING TITLE

LEASE AREA PLAN, ELEVATION

DRAWING SHEET

A-2

RECEIVED

JUN 04 2008

TRUE NORTH