



PLANNING & DEVELOPMENT DEPARTMENT

STATEMENT OF FINANCIAL INTEREST

Case Number: **SDR-34612** APN: 163-03-101-001
Name of Property Owner: USA GOVERNMENT - BLM -
Name of Applicant: MEDIA FLO - FLO TV, INC.
Name of Representative: Janice Manley

To the best of your knowledge, does the Mayor or any member of the City Council or Planning Commission have any financial interest in this or any other property with the property owner, applicant, the property owner or applicant's general or limited partners, or an officer of their corporation or limited liability company?

☐ Yes

☒ No

If yes, please indicate the member of the City Council or Planning Commission who is involved and list the name(s) of the person or persons with whom the City Official holds an interest. Also list the Assessor's Parcel Number if the property in which the interest is held is different from the case parcel.

City Official: _____


Partner(s): _____

APN: _____

Signature of Property Owner: Janice Manley
Print Name: Janice Manley

Subscribed and sworn before me

This 19 day of June 2009
Eddie Larue

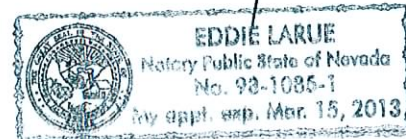

Notary Public in and for said County and State

State of Nevada County of Clark

RECEIVED
JUN 19 2009



5775 MOREHOUSE DRIVE
SAN DIEGO, CALIFORNIA 92121

LAS VEGAS
LAS-006BP

**NEAR INTERSECTION OF BUFFALO AND
CHARLESTON BLVD.
LAS VEGAS, NV 89102**

RECEIVED
MAY 26 2009



**10802 NELLE AVE. NE
ALBUQUERQUE, NM 87111
(505) 250-5700**



3100 WEST RAY ROAD, SUITE 201
CHANDLER, AZ. 85226
TEL (480) 648-1900 FAX (480) 648-1918
ARIZONA • FLORIDA • MARTLAND • NEW YORK • NEW JERSEY
NEW YORK • PENNSYLVANIA • TEXAS • VIRGINIA • WISCONSIN

SCHEDULE OF REVISIONS

DATE		DESCRIPTION OF CHARGES	
09/22/09	100% CD'S (CLIENT COMMENTS)		
04/02/09	100% CD'S (CLIENT COMMENTS)		
01/26/09	100% CD'S		

LAWN BY:	CE
CHECKED BY:	SA
ISS NO:	080205601

SITE INFORMATION

SITE NAME:	LAS VEGAS
SITE NUMBER:	LAC-0068P
SITE ADDRESS:	1000 WEST 20 TH AVENUE, SUITE 201 WASHINGTON, DC 20006
ASSESSORS PARCEL NUMBER:	103-03-19-001
JURISDICTION:	CITY OF LAS VEGAS
SITE COORDINATES:	N 36° 09' 21" E (MAD 83) 3523.71 (MAD 83) 3523.71 (MAD 83)
GROUND ELEVATION:	QUICK TOWER
STRUCTURE TYPE:	QUICK TOWER
STRUCTURE HEIGHT:	318.9' AGL (TOP OF GUYED TOWER)
ANTENNA AND CENTER:	279' AGL
PROPERTY OWNERS ADDRESS:	BUREAU OF LAND MANAGEMENT WASHINGTON, DC 20006
APPLICANT:	FLO TULSA 1100 TULSA BOULEVARD DRIVE SAN DIEGO, CALIFORNIA 92121
AGENT:	JOHN W. WALKER JANICE WALKER 1000 WILLYET AVE ALBUQUERQUE, NM 87111
ENGINEER:	3100 WEST 10 TH AVENUE, SUITE 201

CODE ANALYSIS

BUILDING CODE:	2006 IBC
ELECTRICAL CODE:	2005 NEC
USE GROUP:	U (UTILITY)
CONSTRUCTION TYPE:	III



VICINITY MAP

DIRECTIONS:

DIRECTIONS:
FROM MCCABEN AIRPORT HEAD EAST ON WAYNE NEWTON BLVD, TAKE THE RAMP TOWARD 1/2-1/2 HENDRSON 1/2 CENTRAL CAR RETURN, MERGE ONTO PARADISE RD, MERGE ONTO I-215 W, MERGE ONTO I-15 N VIA EXIT 12A, TAKE THE SARAWA AVE EXIT, TURN LEFT ONTO W SARAWA AVE, TURN RIGHT ONTO S TENAYA WAY, TURN LEFT ONTO DEL RAY AVE, CONTINUE ON DEL RAY AVE UNTIL 1/2-1/2 HENDRSON 1/2 CENTRAL CAR RETURN.

SHEET INDEX

SHEET NO.	SHEET TITLE	DESCRIPTION
T-1	GENERAL CONSTRUCTION NOTES	
A-1	SITE PLAN	
A-2	COMPOUND PLAN	
A-3	EQUIPMENT ROOM PLAN	
A-4	EQUIPMENT ROOM INTERIOR ELEVATION	
A-5	SOUTH ELEVATION (OVERALL)	
A-6	EXISTING BUILDING ELEVATIONS	
A-7	EXISTING BUILDING DETAILS	
C-1	CONSTRUCTION DETAILS	
C-2	RF AND ANTENNA DETAILS	
C-3	RF AND ANTENNA DETAILS	
C-4	WAVE COAM DETAILS (FLUO)	
C-5	EQUIPMENT DETAILS	
C-6	EQUIPMENT DETAILS	
C-7	TRANSMITTER COORDINATE	
C-8	ELECTRONIC SCHEDULE	
C-9	ONE-USE DIAGRAM	
E-1	SYSTEM LAYOUT	
E-2	CONDUIT SCHEDULE	
E-3	POWER AND CONTROL SYSTEM	
E-4	POWER DESIGN	
G-1	GROUNDING PLAN	
G-2	EQUIPMENT ROOM GROUNDING ELEVATION PLAN	
G-3	GROUNDING DETAILS	
G-4	GROUNDING DETAILS	
G-5	GROUNDING DETAILS	

PROJECT DESCRIPTION

1. NEW EQUIPMENT TO BE INSTALLED WITHIN AN EXISTING TELECOMMUNICATIONS SHELTER
2. NEW GENERATOR, HEAT EXCHANGER, AND ISO COL TO BE INSTALLED ON A NEW CONCRETE PAD.
3. NEW ELECTRICAL SERVICE
4. NEW TELEPHONE SERVICE
5. INSTALLATION INCLUDES NEW ANTENNA AND SATELLITE DISHES

SDR-34612

07/09/09 PC

07/09/09 PC




SCHEDULE OF REVISIONS	
NO.	DATE
1	02/20/09
2	04/20/09
3	07/20/09
4	08/20/09
5	09/20/09
6	10/20/09
7	11/20/09
8	12/20/09
9	01/20/10
10	02/20/10
11	03/20/10
12	04/20/10
13	05/20/10
14	06/20/10
15	07/20/10
16	08/20/10
17	09/20/10
18	10/20/10
19	11/20/10
20	12/20/10
21	01/20/11
22	02/20/11
23	03/20/11
24	04/20/11
25	05/20/11
26	06/20/11
27	07/20/11
28	08/20/11
29	09/20/11
30	10/20/11
31	11/20/11
32	12/20/11
33	01/20/12
34	02/20/12
35	03/20/12
36	04/20/12
37	05/20/12
38	06/20/12
39	07/20/12
40	08/20/12
41	09/20/12
42	10/20/12
43	11/20/12
44	12/20/12
45	01/20/13
46	02/20/13
47	03/20/13
48	04/20/13
49	05/20/13
50	06/20/13
51	07/20/13
52	08/20/13
53	09/20/13
54	10/20/13
55	11/20/13
56	12/20/13
57	01/20/14
58	02/20/14
59	03/20/14
60	04/20/14
61	05/20/14
62	06/20/14
63	07/20/14
64	08/20/14
65	09/20/14
66	10/20/14
67	11/20/14
68	12/20/14
69	01/20/15
70	02/20/15
71	03/20/15
72	04/20/15
73	05/20/15
74	06/20/15
75	07/20/15
76	08/20/15
77	09/20/15
78	10/20/15
79	11/20/15
80	12/20/15
81	01/20/16
82	02/20/16
83	03/20/16
84	04/20/16
85	05/20/16
86	06/20/16
87	07/20/16
88	08/20/16
89	09/20/16
90	10/20/16
91	11/20/16
92	12/20/16
93	01/20/17
94	02/20/17
95	03/20/17
96	04/20/17
97	05/20/17
98	06/20/17
99	07/20/17
100	08/20/17
101	09/20/17
102	10/20/17
103	11/20/17
104	12/20/17
105	01/20/18
106	02/20/18
107	03/20/18
108	04/20/18
109	05/20/18
110	06/20/18
111	07/20/18
112	08/20/18
113	09/20/18
114	10/20/18
115	11/20/18
116	12/20/18
117	01/20/19
118	02/20/19
119	03/20/19
120	04/20/19
121	05/20/19
122	06/20/19
123	07/20/19
124	08/20/19
125	09/20/19
126	10/20/19
127	11/20/19
128	12/20/19
129	01/20/20
130	02/20/20
131	03/20/20
132	04/20/20
133	05/20/20
134	06/20/20
135	07/20/20
136	08/20/20
137	09/20/20
138	10/20/20
139	11/20/20
140	12/20/20
141	01/20/21
142	02/20/21
143	03/20/21
144	04/20/21
145	05/20/21
146	06/20/21
147	07/20/21
148	08/20/21
149	09/20/21
150	10/20/21
151	11/20/21
152	12/20/21
153	01/20/22
154	02/20/22
155	03/20/22
156	04/20/22
157	05/20/22
158	06/20/22
159	07/20/22
160	08/20/22
161	09/20/22
162	10/20/22
163	11/20/22
164	12/20/22
165	01/20/23
166	02/20/23
167	03/20/23
168	04/20/23
169	05/20/23
170	06/20/23
171	07/20/23
172	08/20/23
173	09/20/23
174	10/20/23
175	11/20/23
176	12/20/23
177	01/20/24
178	02/20/24
179	03/20/24
180	04/20/24
181	05/20/24
182	06/20/24
183	07/20/24
184	08/20/24
185	09/20/24
186	10/20/24
187	11/20/24
188	12/20/24
189	01/20/25
190	02/20/25
191	03/20/25
192	04/20/25
193	05/20/25
194	06/20/25
195	07/20/25
196	08/20/25
197	09/20/25
198	10/20/25
199	11/20/25
200	12/20/25

SITE PLAN	
DRAWN BY:	CE
CHECKED BY:	SA
JOB NO.	08030007
DRAWING TITLE:	

DRAWING SHEET:
A-1

LAS VEGAS
LAS-0068P
NEAR INTERSECTION OF
BUFFALO AND
CHARLESTON BLVD.
LAS VEGAS, NV 89102

SHEET NO. 3 OF 27

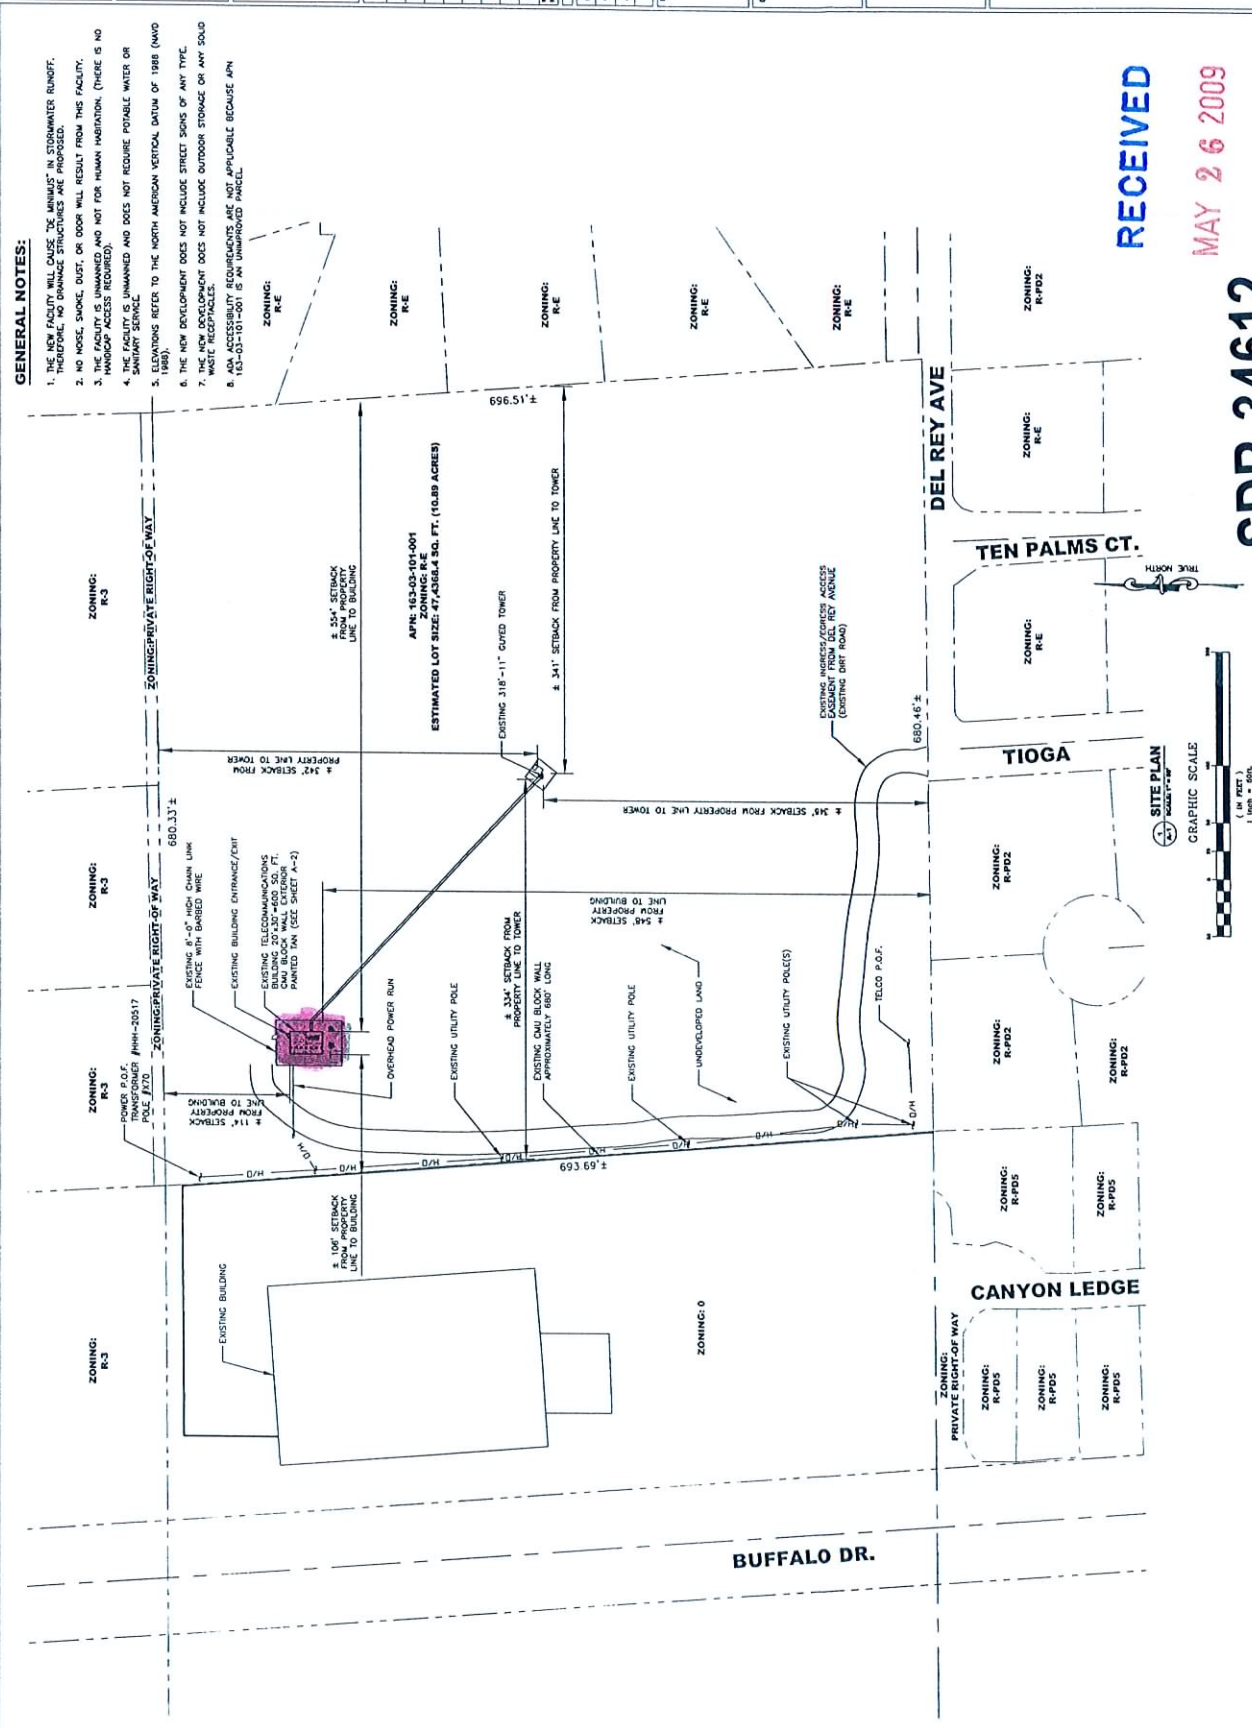

RECEIVED
MAY 26 2009

SDR-34612
07/09/09 PC



live mobile tv
3775 W. GARDEN DRIVE
SUITE 100 CHARLOTTE, NC 28217
PH (858) 651-1642

3100 WEST RAY ROAD, SUITE 201
ALBUQUERQUE, NM 87111
TEL (480) 648-1900 FAX (480) 648-1918
ALBUQUERQUE, NM 87111
(505) 250-3238

3100 WEST RAY ROAD, SUITE 201
ALBUQUERQUE, NM 87111
TEL (480) 648-1900 FAX (480) 648-1918
ALBUQUERQUE, NM 87111
(505) 250-3238

3100 WEST RAY ROAD, SUITE 201
ALBUQUERQUE, NM 87111
TEL (480) 648-1900 FAX (480) 648-1918
ALBUQUERQUE, NM 87111
(505) 250-3238

SCHEDULE OF REVISIONS	
NO.	DESCRIPTION
1	
2	
3	
100	

NO.	DATE	DESCRIPTION
1		
2		
3		
100		

NO.	DATE	DESCRIPTION
1		
2		
3		
100		

NO.	DATE	DESCRIPTION
1		
2		
3		
100		

NO.	DATE	DESCRIPTION
1		
2		
3		
100		

NEAR INTERSECTION OF
BUFFALO AND
CHARLESTON BLVD.
LAS VEGAS, NV 89102



10802 NELLE AVE. NE
ALBUQUERQUE, NM 87111
(505) 250-6389



3100 WEST RAY ROAD, SUITE 201
CHANDLER, AZ. 85226
TEL (480) 648-1900 FAX (480) 648-1918
ARIZONA • FLORIDA • MARYLAND • NEW JERSEY
NEW YORK • PENNSYLVANIA • VIRGINIA

SCHEDULE OF REVISIONS

7				
6				
5				
4				
3				
2	09/2/2009			100% CD'S (CLIENT COMMENTS)
1	04/02/2009			100% CD'S (CLIENT COMMENTS)
				100% CD'S
REV.	DATE			DESCRIPTION OF CHANGES

DRAWING TITLE:
**EQUIPMENT ROOM
INTERIOR
ELEVATION**

DRAWING SHEET

A-4

LAS VEGAS
LAS-0068P
NEAR INTERSECTION OF
BUFFALO AND
CHARLESTON BLVD.
LAS VEGAS, NV 89102


SHEET NO. 6 OF 27

RECEIVED

MAY 26 2009


SDR-34612

07/09/09 PC

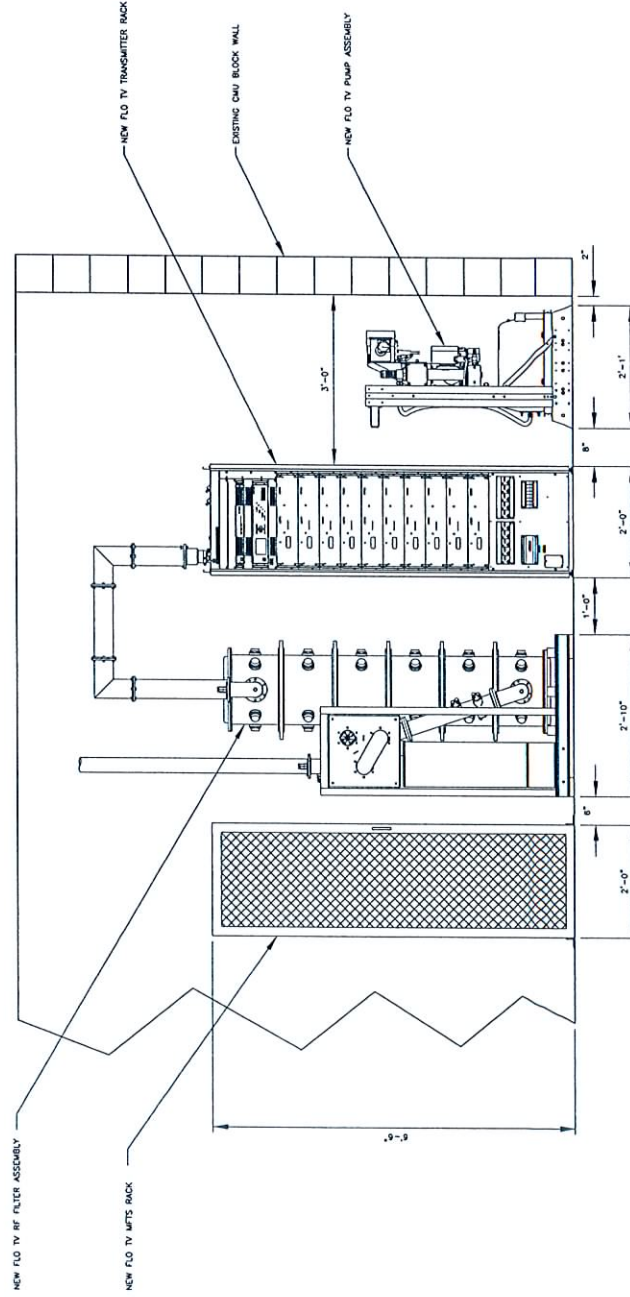

1 EQUIPMENT ROOM INTERIOR ELEVATION
SCALE: 1" = 1'-0"

 GRAPHIC SCALE





CMX
3100 WEST RAY ROAD, SUITE 201
CHANDLER, AZ 85226
TEL (480) 848-1800 FAX (480) 848-1818
WWW.CMX.COM

SCHEDULE OF REVISIONS	
NO.	DATE
1	07/09/09
2	07/09/09
3	07/09/09
100	07/09/09


DRAWING BY: CE
CHECKED BY: SA
JOB NO: 00000001

**SOUTH
ELEVATION
(OVERALL)**

A-5

LAS VEGAS
LAS-006BP
NEAR INTERSECTION OF
BUFFALO AND
CHARLESTON BLVD.
LAS VEGAS, NV 89102

SHEET NO. 7 OF 27

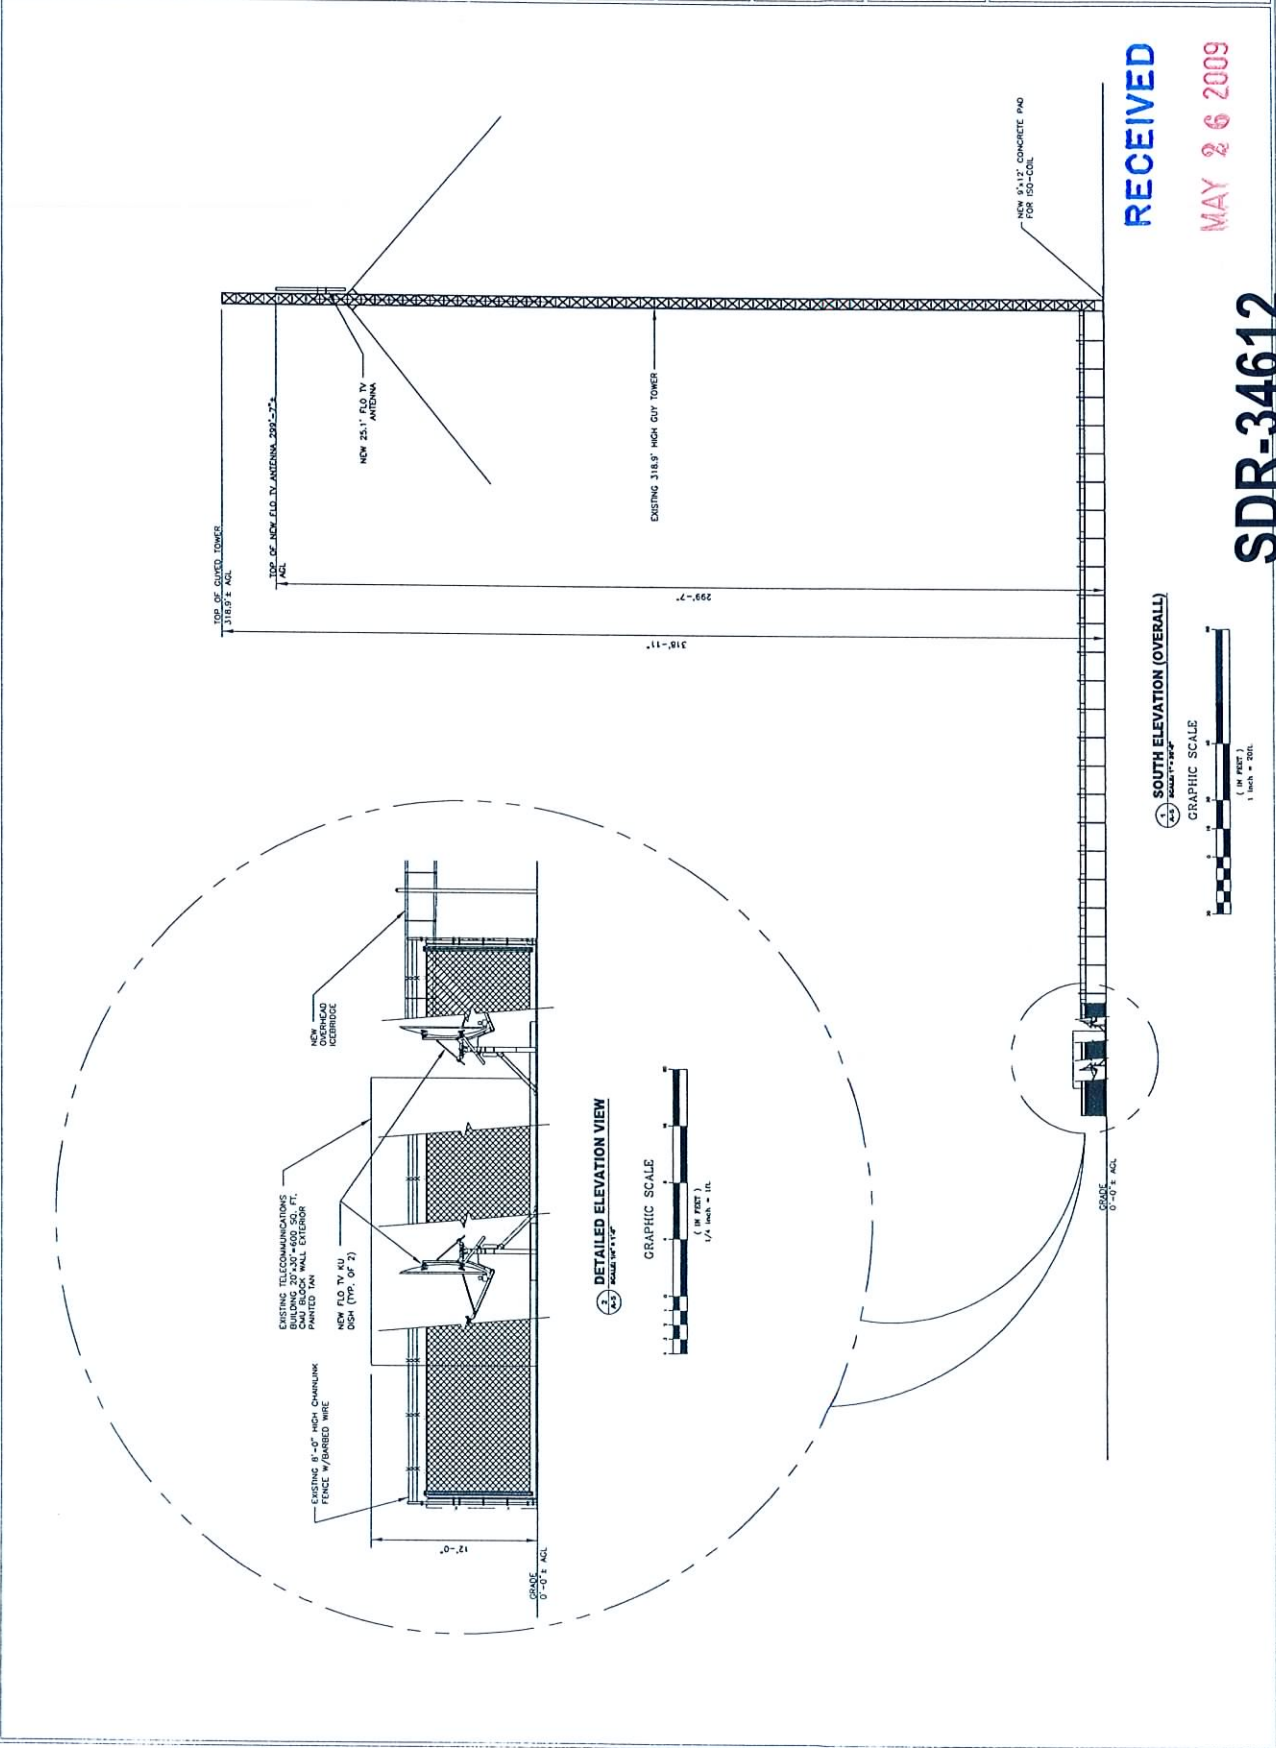



live mobile tv
5775 MOREHOUSE DRIVE
SARASOTA, FL 34231
PH (941) 551-1642



10802 BELLE AVE. NE
ALBUQUERQUE, NM 87111
(505) 255-6399



3100 WEST RAY ROAD, SUITE 201
CHARLOTTE, NC 28205
TEL (704) 366-1111 FAX (704) 366-1818
WWW.CMX.COM

SCHEDULE OF REVISIONS

NO.	DATE	DESCRIPTION OF CHANGE
1		
2		
3		
100		

DRAWN BY: CE

CHECKED BY: SA

JOB NO: 08030501

SHAWING TITLE:


EXISTING
BUILDING
ELEVATIONS

A-6

DRAWING SHEET:


LAS VEGAS
LAS-008BP
NEAR INTERSECTION OF
BUFFALO AND
CHARLESTON BLVD.
LAS VEGAS, NV 89102

SHEET NO. 8 OF 27

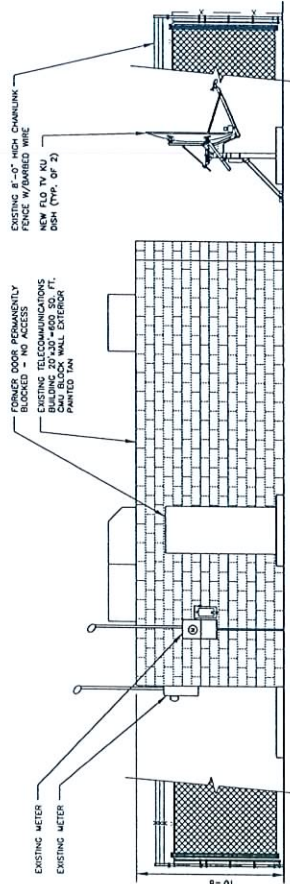



WEST ELEVATION

GRAPHIC SCALE

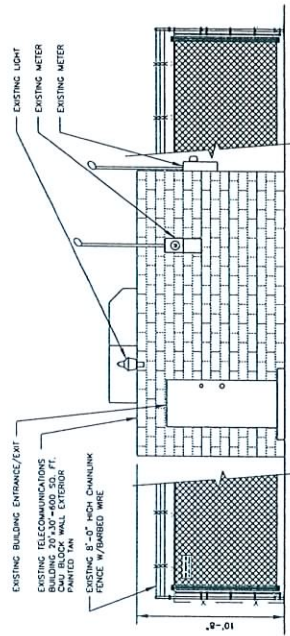



NORTH ELEVATION

 GRAPHIC SCALE

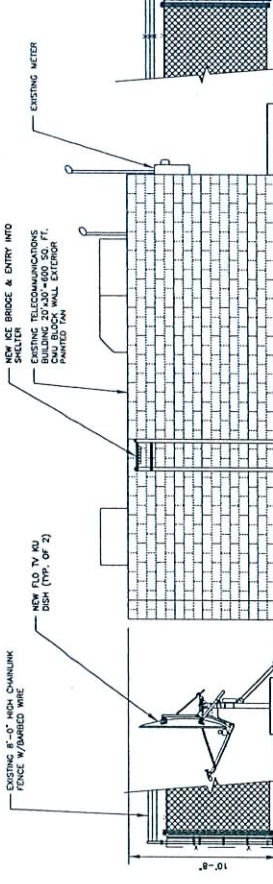


EAST ELEVATION

 GRAPHIC SCALE

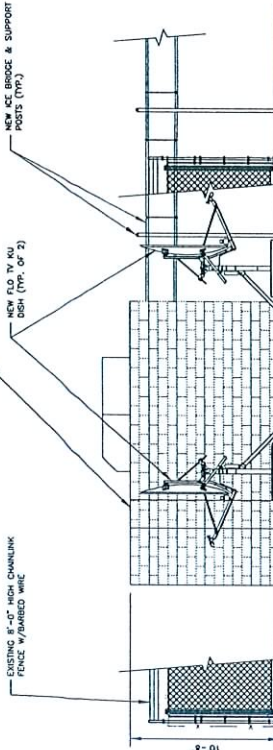

SOUTH ELEVATION

 GRAPHIC SCALE



RECEIVED

MAY 26 2009

SDR-34612

07/09/09 PC