



PLANNING & DEVELOPMENT DEPARTMENT

STATEMENT OF FINANCIAL INTEREST

Case Number: **VAR-35543** APN: _____

Name of Property Owner: Keith Ponstein

Name of Applicant: Keith Ponstein

Name of Representative: Eliecia Montgomery

To the best of your knowledge, does the Mayor or any member of the City Council or Planning Commission have any financial interest in this or any other property with the property owner, applicant, the property owner or applicant's general or limited partners, or an officer of their corporation or limited liability company?

_____ Yes

X No

If yes, please indicate the member of the City Council or Planning Commission who is involved and list the name(s) of the person or persons with whom the City Official holds an interest. Also list the Assessor's Parcel Number if the property in which the interest is held is different from the case parcel.

City Official: _____

Partner(s): _____

APN: _____


Signature of Property Owner: Keith Ponstein Diane Ponstein

Print Name: KEITH PONSTEIN Diane Ponstein

Subscribed and sworn before me

This 10th day of August, 2009

Elizabeth Rodriguez
Notary Public in and for said County and State

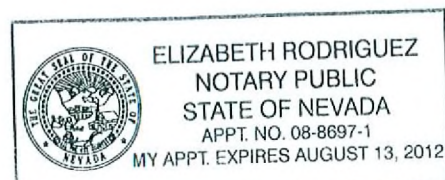

THIS HOUSE WILL BE BUILT BY PROPERTY OWNER, ALLOWED
BY THE CONTRACTOR'S BOARD UNDER PROVISION NRS
624-031, CONTRACTOR'S EXEMPTION NUMBER 4.

KEITH PONSTEIN, 5520 ROCK CREEK LANE, 89130
PROPERTY OWNER/BUILDER RESPONSIBLE FOR THE
CONSTRUCTION OF THIS HOME


Job No: 256-001

Job Name: PONSTEIN RESIDENCE

Proj. Eng: EDM

Revision:

Sheet No: A1 OF 5

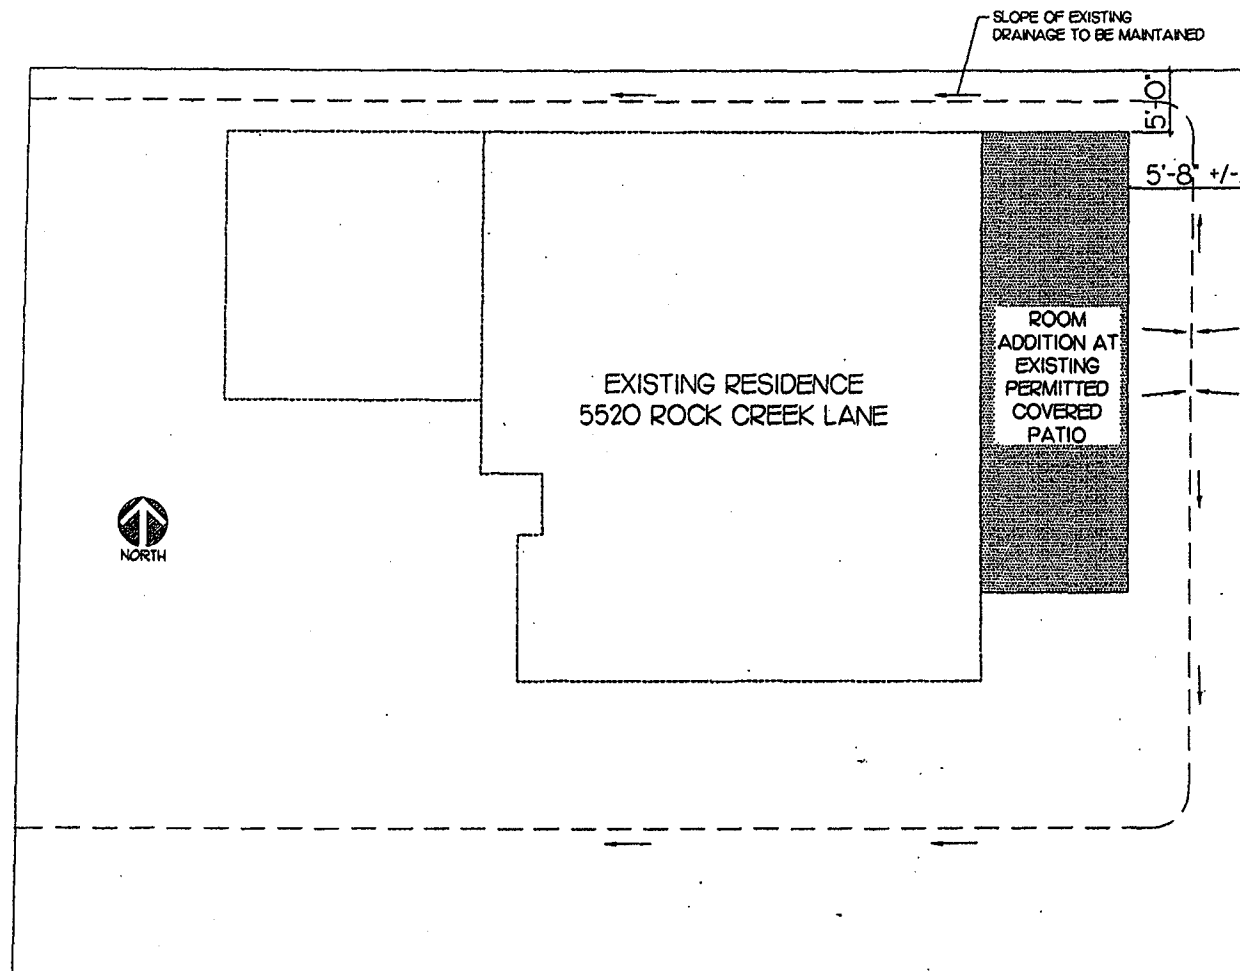

SITE PLAN

SCALE: $\frac{3}{32}$ " = 1'-0"

RECEIVED
AUG 11 2009

VAR-35543
09/24/09 PC

THIS HOUSE WILL BE BUILT BY PROPERTY OWNER, ALLOWED
BY THE CONTRACTOR'S BOARD UNDER PROVISION NRS
624-031, CONTRACTORS EXEMPTION NUMBER 4.

KEITH PONSTEIN, PROPERTY OWNER/BUILDER
RESPONSIBLE FOR THE CONSTRUCTION OF THIS HOME


Job No: 256-001

Job Name: PONSTEIN RESIDENCE

Proj. Eng: EDM

Revision: .

Sheet No: A2 OF 5

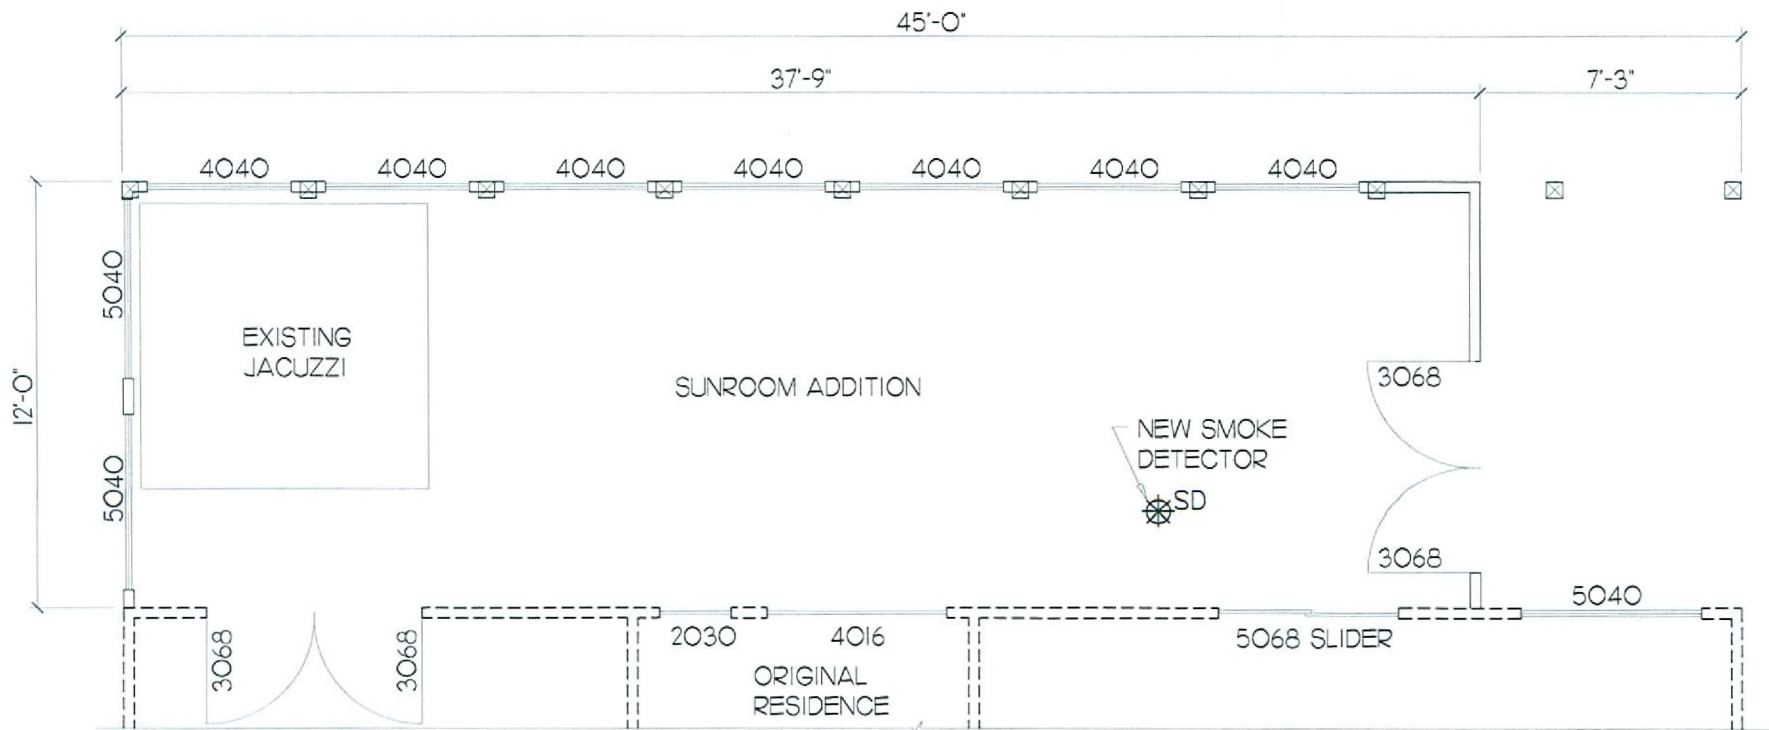

FLOOR PLAN

SCALE: $\frac{3}{16}$ " = 1'-0"

VAR-35543
09/24/09 PC

RECEIVED

AUG 11 2009

THIS HOUSE WILL BE BUILT BY PROPERTY OWNER, ALLOWED
BY THE CONTRACTOR'S BOARD UNDER PROVISION NRS
624-031, CONTRACTORS EXEMPTION NUMBER 4.

KEITH PONSTEIN, PROPERTY OWNER/BUILDER
RESPONSIBLE FOR THE CONSTRUCTION OF THIS HOME


Job No: 256-001

Job Name: PONSTEIN RESIDENCE

Proj. Eng: EDM

Revision: .

Sheet No: A3 OF 5

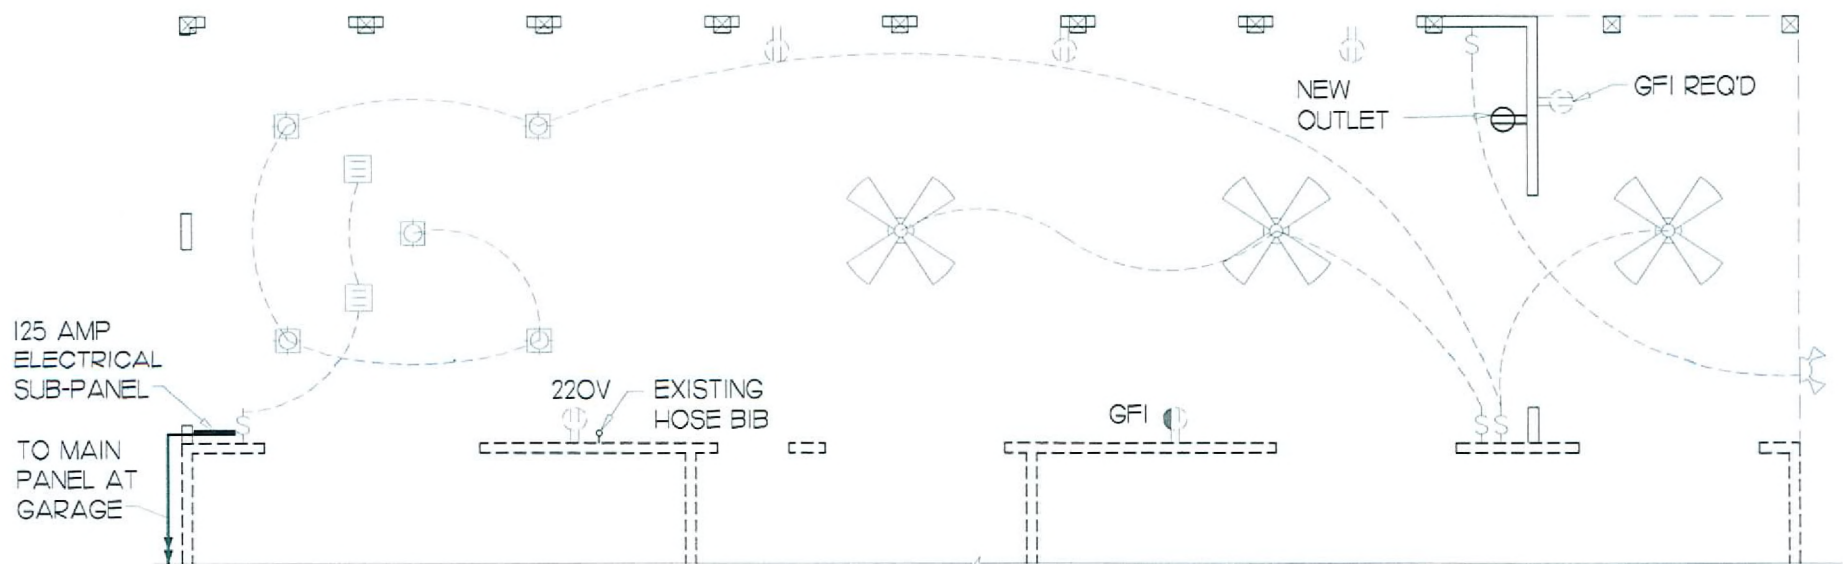

ELECTRICAL PLAN

SCALE: $\frac{3}{16}" = 1'-0"$

VAR-35543
09/24/09 PC

RECEIVED

AUG 11 2009

THIS HOUSE WILL BE BUILT BY PROPERTY OWNER, ALLOWED
BY THE CONTRACTOR'S BOARD UNDER PROVISION NRS
624-031, CONTRACTORS EXEMPTION NUMBER 4.

KEITH PONSTEIN, PROPERTY OWNER/BUILDER
RESPONSIBLE FOR THE CONSTRUCTION OF THIS HOME


Job No: 256-001

Job Name: PONSTEIN RESIDENCE

Proj. Eng: EDM

Revision: .

Sheet No: A4 OF 5

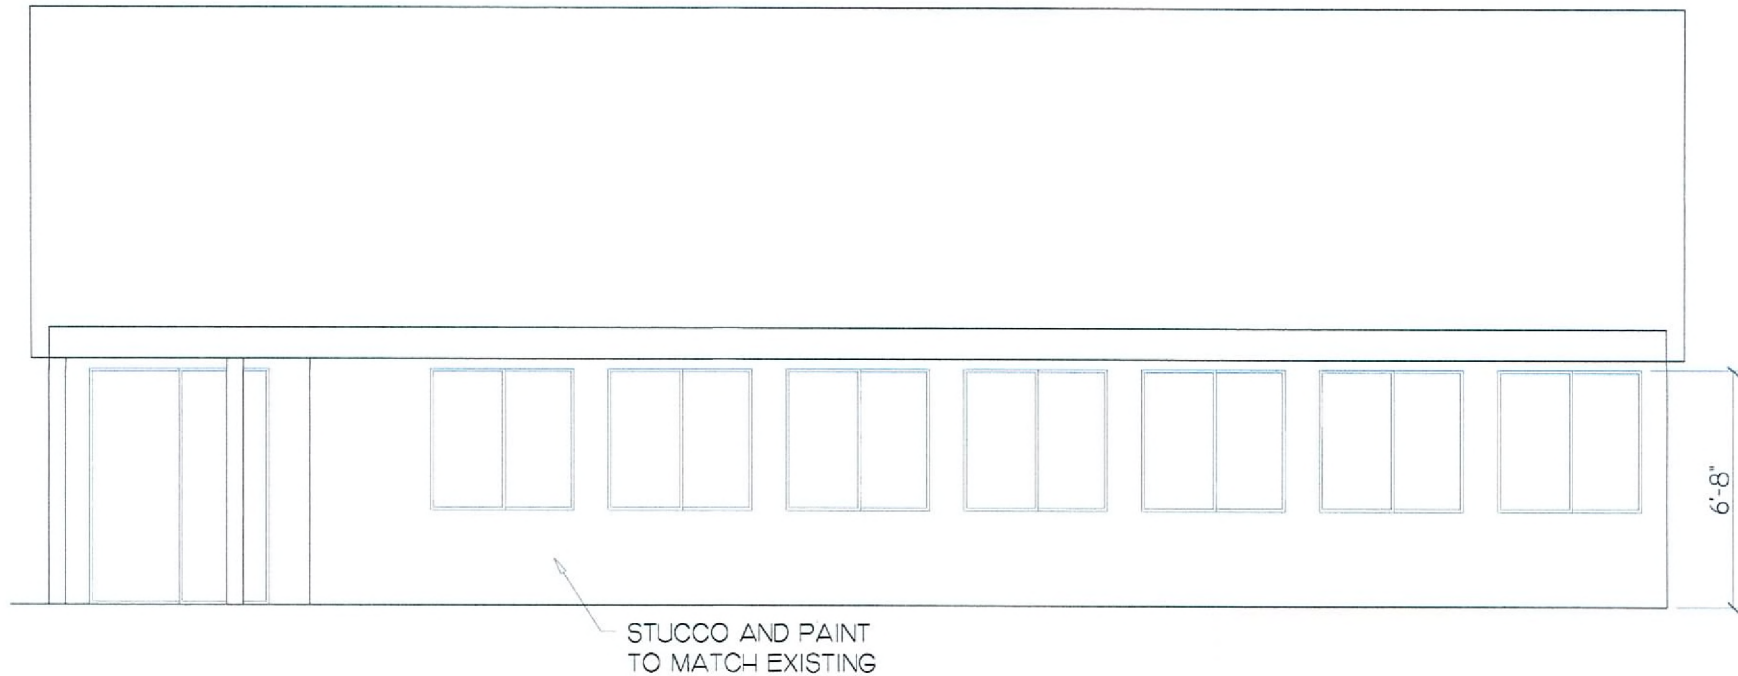

REAR ELEVATION

SCALE: $\frac{3}{16}$ " = 1'-0"

RECEIVED

AUG 11 2009

VAR-35543
09/24/09 PC

THIS HOUSE WILL BE BUILT BY PROPERTY OWNER, ALLOWED
BY THE CONTRACTOR'S BOARD UNDER PROVISION NRS
624-031, CONTRACTORS EXEMPTION NUMBER 4.

KEITH PONSTEIN, PROPERTY OWNER/BUILDER
RESPONSIBLE FOR THE CONSTRUCTION OF THIS HOME


Job No: 256-001

Job Name: PONSTEIN RESIDENCE

Proj. Eng: EDM


Revision: .

Sheet No: A5 OF 5

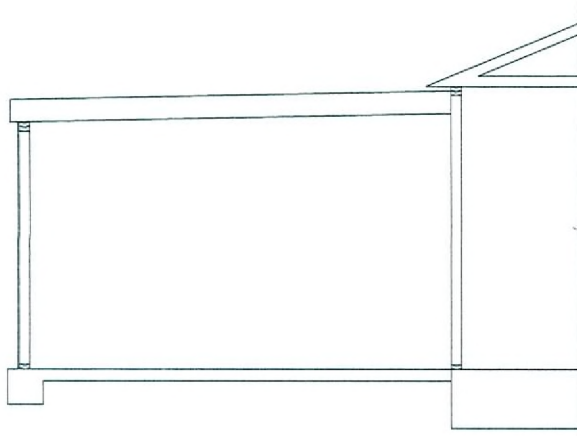

SECTION

SCALE: $\frac{3}{16}" = 1'-0"$

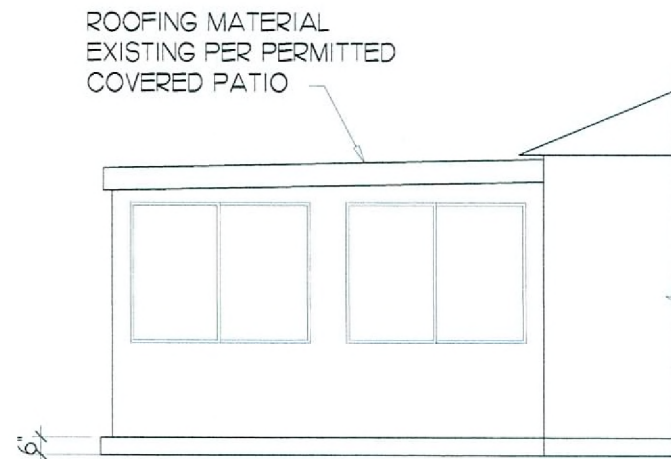

SIDE ELEVATION

SCALE: $\frac{3}{16}" = 1'-0"$

VAR-35543
09/24/09 PC

RECEIVED
AUG 11 2009