



PLANNING & DEVELOPMENT DEPARTMENT

STATEMENT OF FINANCIAL INTEREST

Case Number: **VAR-38114** APN: 138-22-418-011
Name of Property Owner: SEA BREEZE VILLAGE II, LLC
Name of Applicant: Visual Information Systems Co.
Name of Representative: Ed Blend

To the best of your knowledge, does the Mayor or any member of the City Council or Planning Commission have any financial interest in this or any other property with the property owner, applicant, the property owner or applicant's general or limited partners, or an officer of their corporation or limited liability company?

☐ Yes

☒ No

If yes, please indicate the member of the City Council or Planning Commission who is involved and list the name(s) of the person or persons with whom the City Official holds an interest. Also list the Assessor's Parcel Number if the property in which the interest is held is different from the case parcel.

City Official: _____

Partner(s): _____

APN: _____

Signature of Property Owner: _____

Print Name: HASKEL INY

Subscribed and sworn before me

This 9 day of March, 20 10

Trina M. Perales

Notary Public in and for said County and State





PLANNING & DEVELOPMENT DEPARTMENT

APPLICATION / PETITION FORM

Application/Petition For: VARIANCE
Project Address (Location) 7598 Vegas Dr.
Project Name Carl's Jr. Proposed Use _____
Assessor's Parcel #(s) 138-22-418-011 Ward # 4
General Plan: existing ☒ proposed _____ Zoning: existing ☒ proposed _____
Commercial Square Footage _____ Floor Area Ratio _____
Gross Acres .62 Lots/Units 1 Density _____
Additional Information INCIDENTAL SIGNAGE TOWER THAN 5' AND LOGO
GREATER THAN 25% OF SIGN AREA - CARL'S JR. CLEARANCE ARM

PROPERTY OWNER SEA BREEZE VILLAGE II, LLC Contact JENNIFER ROBERTS
Address 1770 N BUFFALO #101 Phone: 702-253-5151 Fax: 702-430-5307
City LAS VEGAS State NV Zip 89128
E-mail Address jr@greatac.com

APPLICANT Visual Information Systems Co. Contact Ed Blend
Address 13580 5th St. Phone: 909-591-4742 Fax: _____
City Chino State CA Zip 91710
E-mail Address _____

REPRESENTATIVE Ed Blend Contact _____
Address 13580 5th St. Phone: 909-287-7373 Fax: _____
City Chino State CA Zip 91710
E-mail Address eblend@nsmc.com

Property Owner Signature* _____

* An authorized agent may sign in lieu of the property owner for Final Maps, Tentative Maps, and Parcel Maps.

Print Name HASKEL INY


Subscribed and sworn before me

This 9 day of March, 20 10.

Trina M. Perales

Notary Public in and for said County and State

Revised 10/27/08

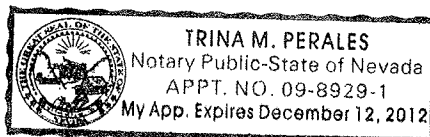

FOR DEPARTMENT USE ONLY

Case #	<u>VAR-38114</u>
Meeting Date:	<u>6/24/2010</u>
Total Fee:	<u>830.00</u>
Date Received:	<u>4/27/2010</u>
Received By:	<u>MREX</u>

*The application will not be deemed complete until the submitted materials have been reviewed by the Planning and Development Department for consistency with applicable sections of the Zoning Ordinance.

C:\depot\Application Packet\Application Form.pdf

A DRIVE-THRU CLEARANCE ARM

[illegible]

BUFFALO DR

NOTE:

ALL NEW SIGNAGE TO CONNECT
TO CLIENT PROVIDED ELECTRICAL
CIRCUITS

CARL'S JR. - Las Vegas, CA. - Site Plan

SCALE: 1/32"=1'

RECEIVED
APR 27 2010

VICINITY MAP

LOGO ARTWORK

YES NO
☐ ☒ WINDOWS READY VECTOR LINE
 DIGITAL ARTWORK OR B&W
 CAMERA READY ARTWORK WILL
 BE REQUIRED PRIOR TO
 FABRICATION

SALESMAN TO PROVIDE ACTUAL COLOR INFORMATION PRIOR TO FABRICATION

YES	NO		
☐	☐		
☐	☐		
☐	☐		
☐	☐		
☐	☐		

FIELD SURVEY REQUIRED FOR:

YES NO

☐ ☒ COLOR MATCHING PURPOSES TO EXISTING BUILDING(S)/SIGNAGE etc.

☐ ☒ MATCHING STONE, BRICK or OTHER BUILDING MATERIALS TO EXISTING

☐ ☒ DETERMINE ACTUAL DIMENSIONS OF EXISTING SIGNAGE FOR REFACE BEFORE FABRICATION

2

2

SIGNAGE LOCATIONS:

HAS CUSTOMER
APPROVED SIGN
LOCATION(S) FOR
INSTALLATION? YES ☒ NO ☐

CUSTOMER APPROVAL:

DRAWINGS	YES ☒	NO ☐
COLORS	YES ☒	NO ☐
TEXT	YES ☒	NO ☐

MISCELLANEOUS:

DEPOSIT REQUIRED YES ☐ NO ☐

SIGNED CONTRACT YES ☐ NO ☐

ORDER LED UNIT YES ☐ NO ☐

THIS IS AN ORIGINAL UNPUBLISHED DRAWING CREATED FOR YOUR PERSONAL USE IN CONNECTION WITH A PROJECT PLANNED FOR YOU BY NSMC. IT IS NOT TO BE SHOWN OUTSIDE YOUR ORGANIZATION NOR USED, REPRODUCED, COPIED OR EXHIBITED IN ANY FASHION UNLESS AUTHORIZED IN WRITING BY AN OFFICER OF NSMC.



National Sign

& MARKETING CORPORATION
DBA Visual Information Systems Co.
13580 5th St., Chino, CA 91710
Tel 909.591.4742 Fax 909.591.9792
e-mail: sales@nsmc.com
NV Lic# 0071619 - Exp. 8/31/10
Class: C-6 Limit: \$950,000.00

Project: Carl's Jr.
Address: 7598 Vegas Dr., Las Vegas, NV
Phone: _____ **Account Mgr.** S. Rosenbloom
Designer: S. Duffy **Scale:** Noted **Date:** 02/16/2010

Client Approval:

Date: _____

**APPROVED &
RELEASED FOR
CONSTRUCTION**

Salesman _____ Date _____

Revisions:

03/17/10 SD: Add measurements and address to plot plan

VAR-38114

06/24/10 PC

Drawing Number

24245
R1



VISCO
ELECTRONIC SIGNS


Scope of Work

- A B C** 42" EMBOSSED ILLUM. "CARL'S JR." CLOUD SIGN
- D** 60" EMBOSSED ILLUM. "CARL'S JR." CLOUD SIGN
- E F** NEW D/F ILLUM. DIRECTIONAL SIGN
- G** NEW D/F ILLUM. MONUMENT SIGN
- H** NEW LED BORDER TUBE LIGHT SYSTEM 277' LIN. FT. APPROX.

Install Only

Manufacturing By Others

- 1** DRIVE-THRU MENU BOARD
- 2** DRIVE-THRU ORDER CONFIRMATION BOARD (Footcage Only)
- 3** INTERIOR 10/11 PANEL MENU BOARD
- 4** INTERIOR MENU BOARD LIGHT BOX COMBO PANEL

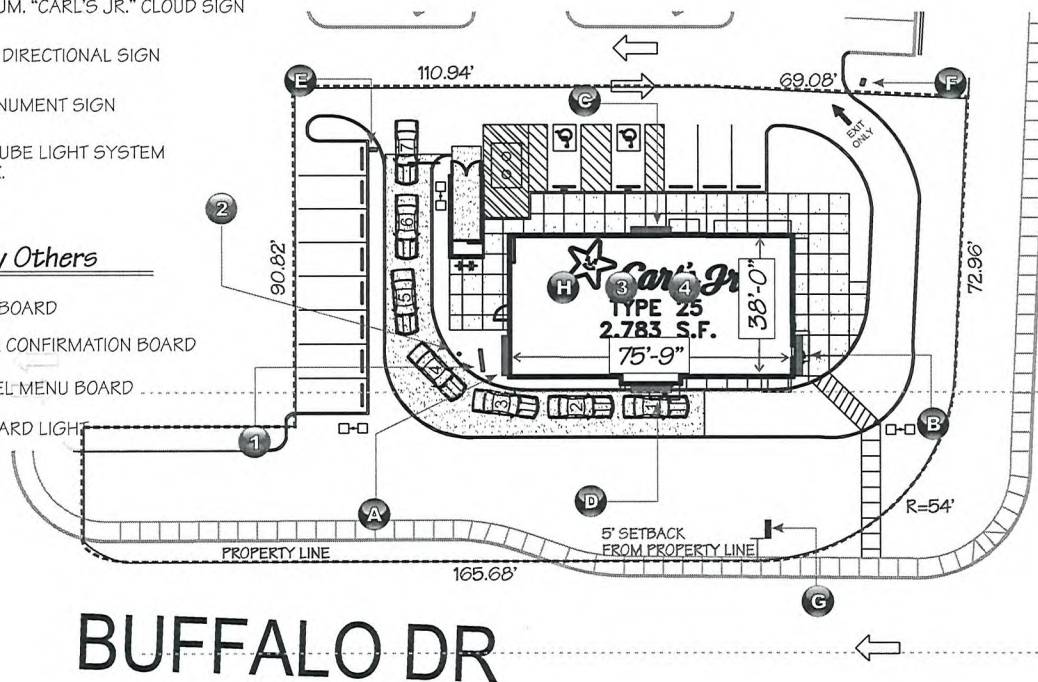

BUFFALO DR

NOTE:


ALL NEW SIGNAGE TO CONNECT TO CLIENT PROVIDED ELECTRICAL CIRCUITS

CARL'S JR. - Las Vegas, CA. - Site Plan

SCALE: 1/32"=1'

VEGAS DR

70' N.V. POWER EASEMENT

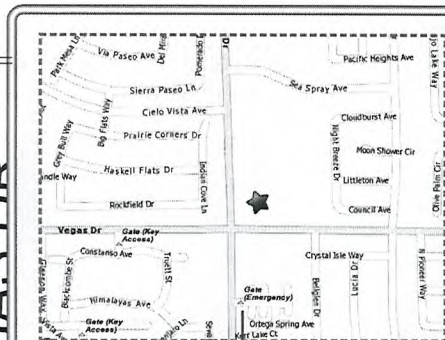

VICINITY MAP

LOGO ARTWORK YES NO ☐ ☒ WINDOWS READY VECTOR LINE DIGITAL ARTWORK OR B&W CAMERA READY ARTWORKS WILL BE REQUIRED PRIOR TO FABRICATION		SALESMAN TO PROVIDE ACTUAL COLOR INFORMATION PRIOR TO FABRICATION YES NO ☐ ☐	
FIELD SURVEY REQUIRED FOR: YES NO ☐ ☒ COLOR MATCHING PURPOSES TO EXISTING BUILDING(S)/SIGNAGE etc. ☐ ☒ MATCHING STONE, BRICK OR OTHER BUILDING MATERIALS TO EXISTING ☐ ☒ DETERMINE ACTUAL DIMENSIONS OF EXISTING SIGNAGE FOR REFACE BEFORE FABRICATION			
SIGNAGE LOCATIONS: HAS CUSTOMER APPROVED SIGN LOCATION(S) FOR INSTALLATION? YES NO ☒ ☐		CUSTOMER APPROVAL: DRAWINGS COLORS YES NO ☒ ☐ ORDER LED UNIT YES NO ☒ ☐	
MISCELLANEOUS: DEPOSIT REQUIRED YES NO ☒ ☐ SIGNED CONTRACT YES NO ☒ ☐		12	



National Sign

& MARKETING CORPORATION
 DBA Visual Information Systems Co.
 13550 5th St., Chino, CA 91710
 Tel 909.591.4742 Fax 909.591.9792
 e-mail: sales@nsmc.com
 NV Lic# 0071619 - Exp. 8/31/10
 Class: C-6 Limit: \$950,000.00

Project: Carl's Jr.
 Address: 7598 Vegas Dr., Las Vegas, NV
 Phone: Account Mgr. S. Rosenbloom
 Designer: S. Duffy Scale: Noted Date: 04/20/2010

Client Approval:

Date:

APPROVED &
RELEASED FOR
CONSTRUCTION

Salesman

Date

Revisions:

Drawing Number

24359


VIDEO
ELECTRONIC SIGNS

RECEIVED
APR 27 2010

VAR-38114
MSP-38116

THIS IS AN ORIGINAL UNPUBLISHED DRAWING CREATED FOR YOUR PERSONAL USE IN CONNECTION WITH A PROJECT PLANNED FOR YOU BY NSMC. IT IS NOT TO BE SHOWN OUTSIDE YOUR ORGANIZATION NOR USED, REPRODUCED, COPIED OR EXHIBITED IN ANY FASHION UNLESS AUTHORIZED IN WRITING BY AN OFFICER OF NSMC.

SEE ENGINEERING FOR FOOTING DETAILS

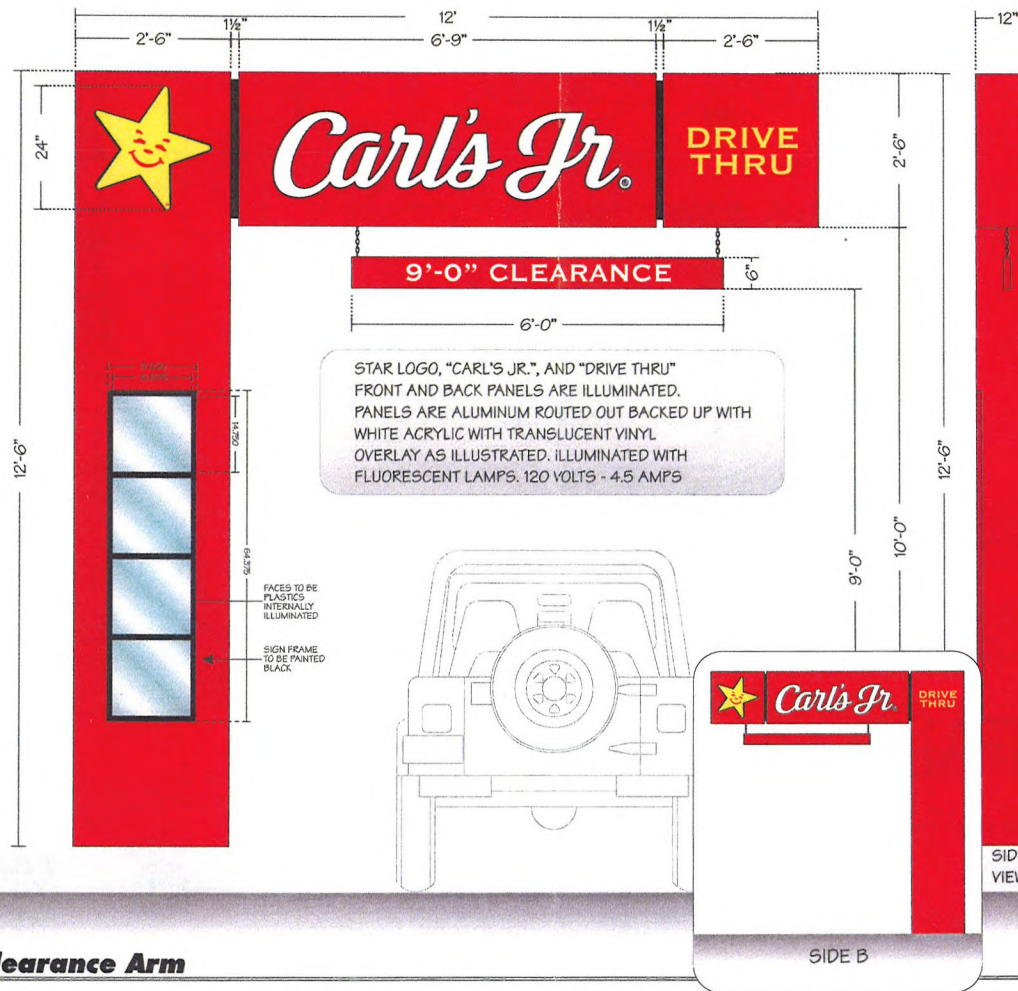

A DRIVE-THRU CLEARANCE ARM

BLACK
RED VINYL 3M-3630-73
YELLOW VINYL 3M-3630-015

RECEIVED
APR 27 2010
VAR-38114
06/24/10 PC

CARL'S JR. - Drive Thru Clearance Arm

SCALE: 1/2" = 1'

THIS IS AN ORIGINAL UNPUBLISHED DRAWING CREATED FOR YOUR PERSONAL USE IN CONNECTION WITH A PROJECT PLANNED FOR YOU BY NSMC. IT IS NOT TO BE SHOWN OUTSIDE YOUR ORGANIZATION NOR USED, REPRODUCED, COPIED OR EXHIBITED IN ANY FASHION UNLESS AUTHORIZED IN WRITING BY AN OFFICER OF NSMC.



**National Sign
& MARKETING CORPORATION**
DBA Visual Information Systems Co.
13580 5th St., Chino, CA 91710
Tel: 909.591.4742 Fax: 909.591.5792
e-mail: sales@nsmc.com
NY Lic # 0071819 - Exp. 8/31/10
Class: C-4 Limit: \$950,000.00

Project: Carl's Jr.
Address: 7598 Vegas Dr., Las Vegas, NV
Phone: _____ Account Mgr. S. Rosenbloom
Designer: S. Duffy Scale: Noted Date: 02/16/2010



Client Approval:
Date: _____

APPROVED &
RELEASED FOR
CONSTRUCTION
Salesman Date

Revisions:
03/17/10 SD: Add measurements and address to plot plan

Drawing Number
24245
R1



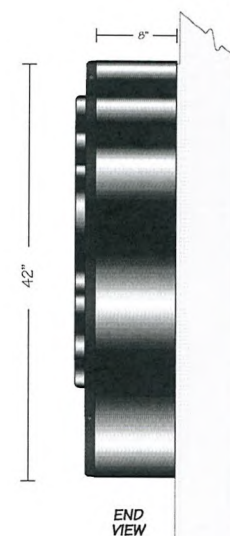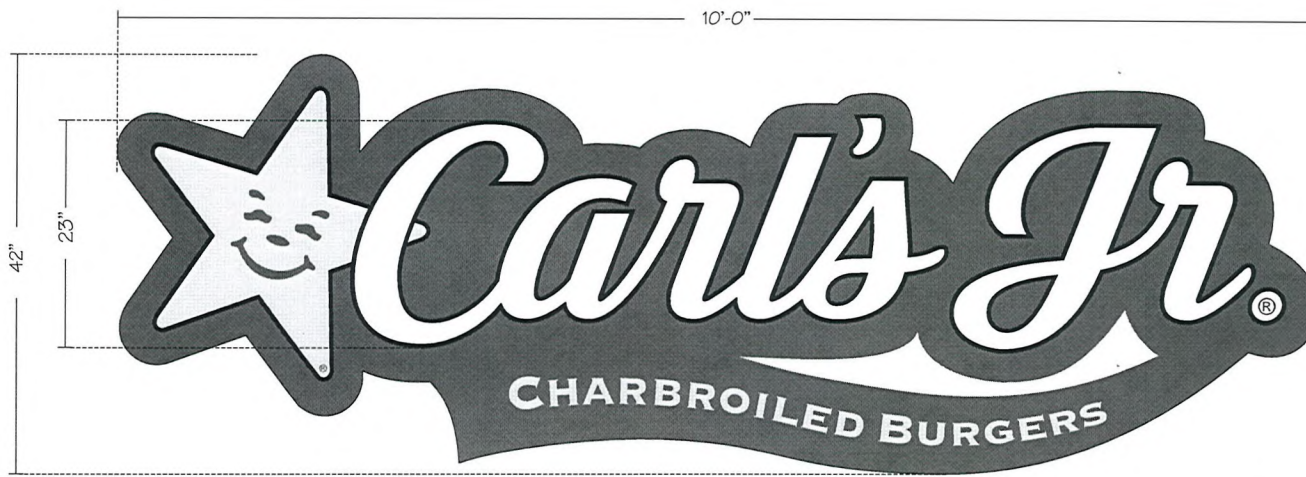

A B C 42" EMBOSSED ILLUM. "CARL'S JR." CLOUD SIGN

35 0

Cloud Sign Specifications:

BODY:
S/F CUSTOM FABRICATED ALUMINUM CABINET
CONSTRUCTED OF .040 WITH .063 ALUMINUM BACKS.



FACES:
CLEAR EMBOSSED PAN FORMED FACES WITH 1-1/2" RETURNS
AND BACK SPRAYED PAINTED DECORATION. COLORS TO
MATCH CORPORATE APPROVED COLORS.

RETURNS:
PAINTED BLACK.

ILLUMINATION:
INTERNAL, H.O. FLUORESCENT LAMPS. 120 VOLTS - 1.5 AMPS

SWITCH:
U.L. APPROVED TOGGLE SWITCH.

ALL WIRING & COMPONENTS TO MEET U.L. STANDARDS

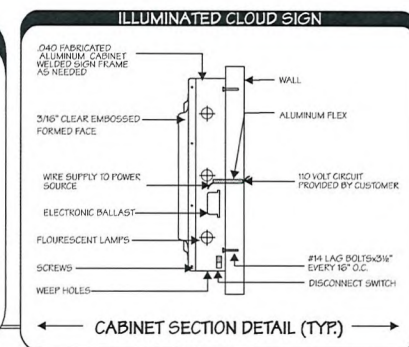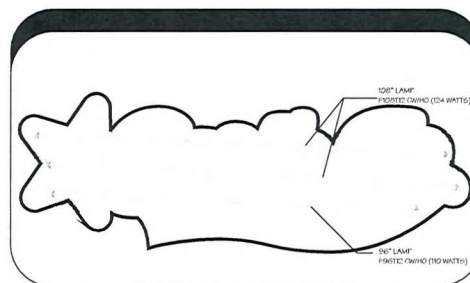

42" EMBOSSED ILLUM. CARL'S JR. CLOUD SIGN

SCALE: 1" = 1'-0"

THIS IS AN ORIGINAL UNPUBLISHED DRAWING CREATED FOR YOUR PERSONAL USE IN CONNECTION WITH A PROJECT PLANNED FOR YOU BY NSMC. IT IS NOT TO BE SHOWN OUTSIDE YOUR ORGANIZATION NOR USED, REPRODUCED, COPIED OR EXHIBITED IN ANY FASHION UNLESS AUTHORIZED IN WRITING BY AN OFFICER OF NSMC.



National Sign & Marketing Corporation

DBA Visual Information Systems Co.
13580 5th St., Chino, CA 91710
Tel 909.591.4742 Fax 909.591.9792
e-mail: sales@nsmc.com
NV Lic# 0071819 - Exp. 3/31/10
Class: C-6 Limit: \$950,000.00

Project: Carl's Jr.
Address: 7598 Vegas Dr., Las Vegas, NV
Phone: Account Mgr. S. Rosenbloom
Designer: S. Duffy Scale: Noted Date: 04/20/2010

Client Approval:
Date:

APPROVED & RELEASED FOR CONSTRUCTION
Salesman Date



Revisions:

Drawing Number
24359



RECEIVED
APR 27 2010

VAR-38114
MSP-38116

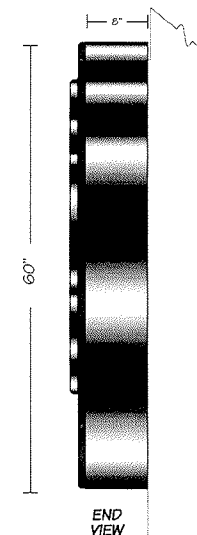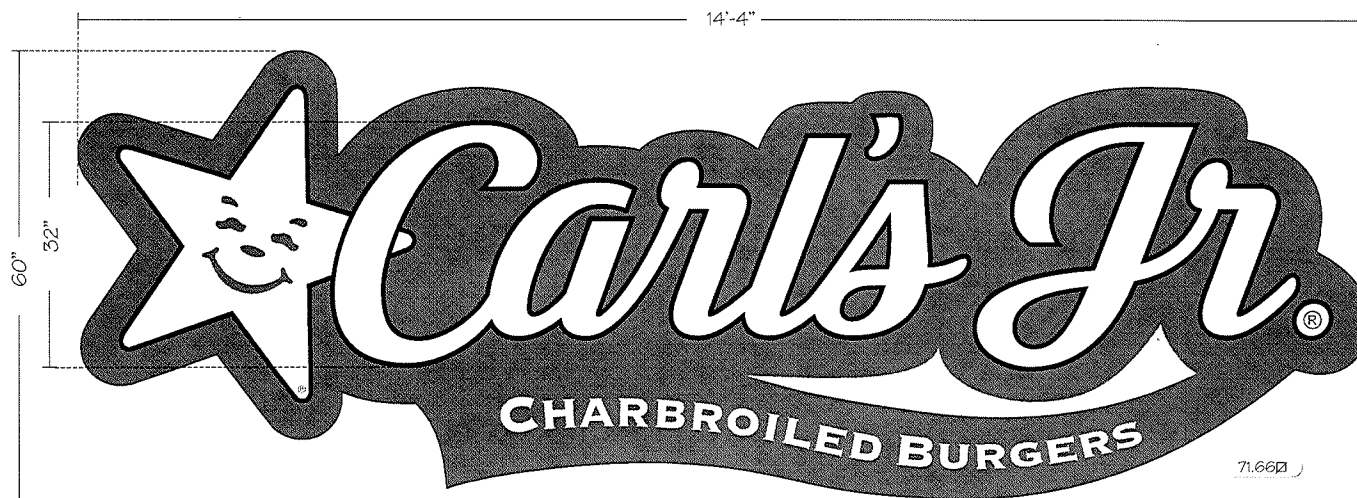

Cloud Sign Specifications:

D 60" EMBOSSED ILLUM. "CARL'S JR." CLOUD SIGN

BODY:

S/F CUSTOM FABRICATED ALUMINUM CABINET
CONSTRUCTED OF .040 WITH .063 ALUMINUM BACKS.

FACES:

CLEAR EMBOSSED PAN FORMED FACES WITH 1-1/2" RETURNS
AND BACK SPRAYED PAINTED DECORATION. COLORS TO
MATCH CORPORATE APPROVED COLORS.

RETURNS:

PAINTED BLACK.

ILLUMINATION:

INTERNAL, H.O. FLUORESCENT LAMPS, 120 VOLTS - 4.5 AMPS

SWITCH:



U.L. APPROVED TOGGLE SWITCH.

ALL WIRING & COMPONENTS TO MEET U.L. STANDARDS



60" EMBOSSED ILLUM. CARL'S JR. CLOUD SIGN

SCALE: 3/4" = 1'-0"

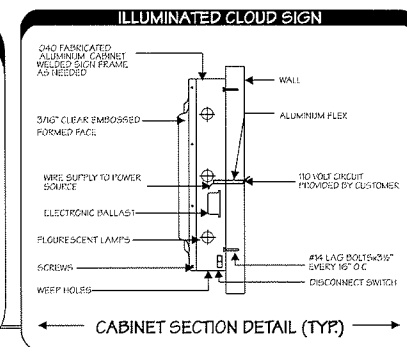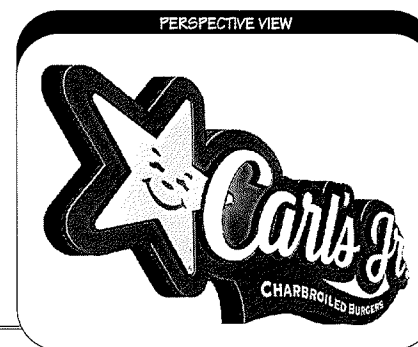

THIS IS AN ORIGINAL UNPUBLISHED DRAWING CREATED FOR YOUR PERSONAL USE IN CONNECTION WITH A PROJECT PLANNED FOR YOU BY NSMC. IT IS NOT TO BE SHOWN OUTSIDE YOUR ORGANIZATION NOR USED, REPRODUCED, COPIED OR EXHIBITED IN ANY FASHION UNLESS AUTHORIZED IN WRITING BY AN OFFICER OF NSMC



National Sign & MARKETING CORPORATION

DBA Visual Information Systems Co.
13580 5th St., Chino, CA 91710
Tel 909.591.4742 Fax 909.591.9792
e-mail: sales@nsmc.com
NV Lic# 0071619 Exp. 3/31/10
Class: C-6 Limit: \$950,000.00

Project: Carl's Jr.
Address: 7596 Vegas Dr., Las Vegas, NV
Phone: _____ Account Mgr. S. Rosenbloom
Designer: S. Duffy Scale: Noted Date: 04/20/2010

Client Approval: _____
Date: _____

APPROVED &
RELEASED FOR
CONSTRUCTION
Salesman _____ Date _____


Revisions: _____

Drawing Number
24359

VIDEO
ELECTRONIC SIGNS

RECEIVED
APR 27 2010

VAR-38114
MSP-38116

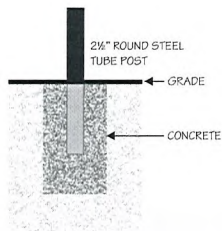

Specifications:

CABINETS: FABRICATED ALUMINUM 9" DEEP, WITH 1 1/2" RETAINERS AND RETURNS PAINTED BLACK.
 FACES: WHITE PLEX/LEXAN WITH FIRST SURFACE APPLIED CUT/REVERSE CUT TRANSLUCENT VINYL GRAPHICS AS ILLUSTRATED.
 POST: 2 1/2" ROUND STEEL TUBE POST PAINTED BLACK.
 ILLUMINATION: INTERNAL T12 CW/HO FLUORESCENT LAMPS, 120 VOLTS - 1.5 AMPS
 SWITCH: TAMPER RESISTANT SWITCH: UL APPROVED 15A-120/277V 'LEVITON' #1101-2L WITH KEYED WATERPROOF COVER.
 ALL COMPONENTS TO BE U.L. APPROVED



SIDE A



SIDE B




END VIEW



SIDE A



SIDE B

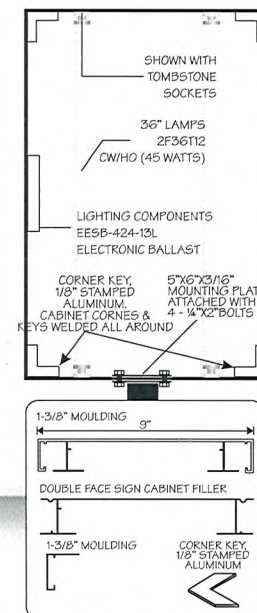

E NEW D/F ILLUM. DIRECTIONAL SIGN

F NEW D/F ILLUM. DIRECTIONAL SIGN

SEE ENGINEERING FOR FOOTING DETAILS

CARL'S JR. - D/F ILLUMINATED DIRECTIONAL SIGNS

SCALE: 1" = 1'-0"

THIS IS AN ORIGINAL UNPUBLISHED DRAWING CREATED FOR YOUR PERSONAL USE IN CONNECTION WITH A PROJECT PLANNED FOR YOU BY NSMC. IT IS NOT TO BE SHOWN OUTSIDE YOUR ORGANIZATION NOR USED, REPRODUCED, COPIED OR EXHIBITED IN ANY FASHION UNLESS AUTHORIZED IN WRITING BY AN OFFICER OF NSMC



National Sign & Marketing Corporation
 DBA Visual Information Systems Co.
 13580 5th St., Chino, CA 91710
 Tel 909.591.4742 Fax 909.591.9792
 e-mail: sales@nsmc.com
 NV Lic# 0071619 Exp. 3/31/10
 Class: C-6 Limit: \$950,000.00

Project: Carl's Jr.
 Address: 7598 Vegas Dr., Las Vegas, NV
 Phone: Account Mgr. S. Rosenbloom
 Designer: S. Duffy Scale: Noted Date: 04/20/2010

Client Approval:
 Date:

APPROVED & RELEASED FOR CONSTRUCTION
 Salesman Date

Revisions:


Drawing Number
24359



RECEIVED
 APR 27 2010

VAR-38114
MSP-38116

"STAR" LOGO TO BE ON
STREET SIDE AT ALL TIMES

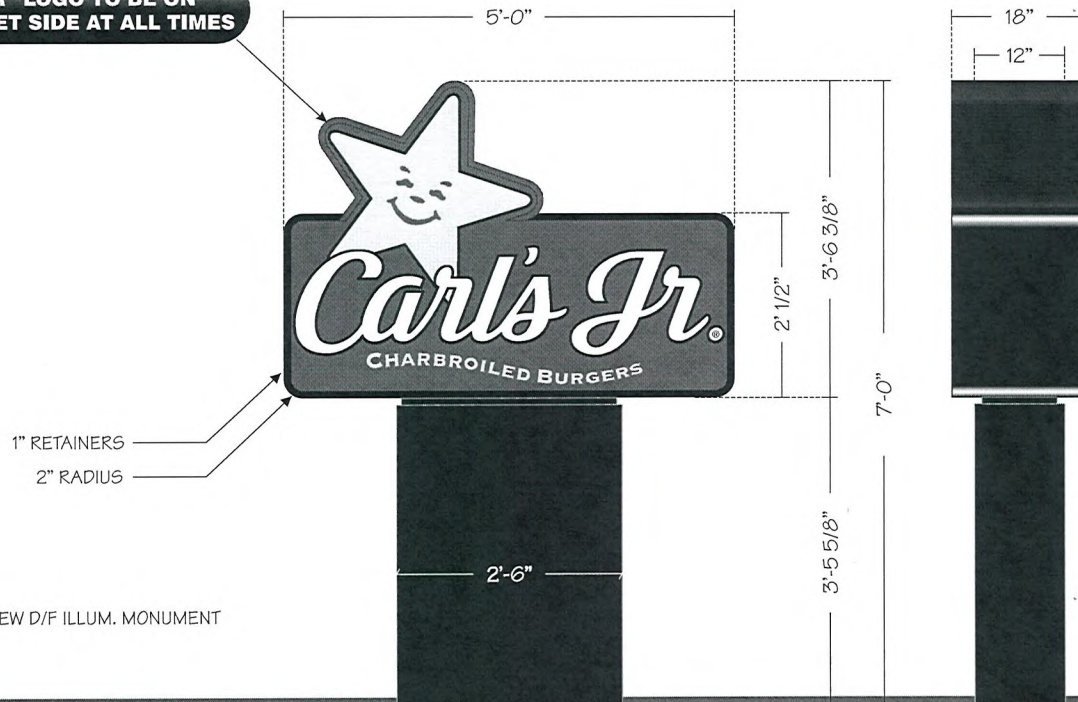

END VIEW

Specifications:

- CABINET: FABRICATED ALUMINUM, 18" DEEP WITH 1" WIDE RETAINERS. "CARL'S JR." CABINET TO BE PAINTED BLACK, PAINT "STAR" CABINET FRAZEE "CHERRY RED" #6355.
- FACES: WHITE LEXAN WITH FIRST SURFACE APPLIED CUT/REVERSE CUT TRANSLUCENT VINYL GRAPHICS AS ILLUSTRATED.
- POLE COVER: FABRICATED ALUMINUM, 12" DEEP WITH TEX-COTE FINISH, PAINTED BLACK FLAT FINISH.
- ILLUMINATION: INTERNAL H.O. FLUORESCENT LAMPS.
- SWITCH: TAMPER RESISTANT SWITCH: UL APPROVED 15A-120/277V 'LEVITON' #1101-2L WITH KEYED WATERPROOF COVER.

ALL WIRING & COMPONENTS TO MEET U.L. STANDARDS



SIDE B

BLACK
RED VINYL 3M-3630-73
YELLOW VINYL 3M-3630-015

NEW D/F ILLUMINATED MONUMENT SIGN

SCALE: 3/4" = 1'-0"

THIS IS AN ORIGINAL UNPUBLISHED DRAWING CREATED FOR YOUR PERSONAL USE IN CONNECTION WITH A PROJECT PLANNED FOR YOU BY NSMC. IT IS NOT TO BE SHOWN OUTSIDE YOUR ORGANIZATION NOR USED, REPRODUCED, COPIED OR EXHIBITED IN ANY FASHION UNLESS AUTHORIZED IN WRITING BY AN OFFICER OF NSMC



National Sign & Marketing Corporation

DBA Visual Information Systems Co.
13580 5th St., Chino, CA 91710
Tel 909.591.4742 Fax 909.591.9792
e-mail: sales@nsmc.com
NV Lic# 0071619 Exp. 8/31/10
Class: C-5 Limit \$950,000.00

Project: Carl's Jr.
Address: 7598 Vegas Dr., Las Vegas, NV
Phone: _____ Account Mgr. S. Rosenbloom
Designer: S. Duffy Scale: Noted Date: 04/20/2010

Client Approval:

Date: _____

APPROVED &
RELEASED FOR
CONSTRUCTION

Salesman _____ Date _____

Revisions:

Drawing Number
24359




RECEIVED
APR 27 2010

VAR-38114
MSP-38116

Specifications:

INSTALL "LED BORDER SYSTEM" RED LED BORDER 3" FROM BOTTOM OF COPING AND TRIM AS SHOWN ON INDIVIDUAL ELEVATION PACKAGES.


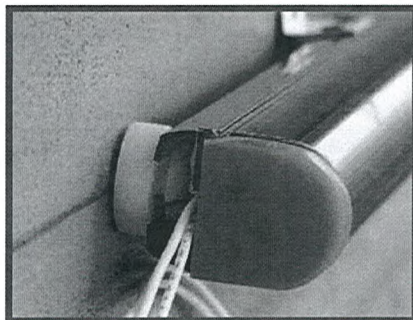


H NEW LED BORDER SYSTEM
277 LIN. FT. APPROX.

Sloan Components Used - UL #E215393

701189-10H-10' RED LED STRIPE
701189-8H-8' RED LED STRIPE
701189-6H-6' RED LED STRIPE
701189-4H-4' RED LED STRIPE
701189-2H-2' RED LED STRIPE
701189-1H-1' RED LED STRIPE
700940-300 WATT TRANSFORMERS
701158-120-10' HOOK-UP WIRE

- BRIGHT, WIDE VIEWING-ANGLE LEDs OFFER INTENSE, UNIFORM GLOW
- HIGH IMPACT, UV STABLE, HYDROCARBON INSENSITIVE, NON-FADING POLYMER TUBES
- 24 VOLT DC POWER SUPPLY POWERS UP TO 3 LEGS OF 30' (9 METERS) EACH, OR 90' (27.4 METERS) TOTAL
- CAN BE CUT-TO-FIT IN THE FIELD AND FACTORY BENT TO AN 8" RADIUS
- CONVENIENT LOCK-TIGHT, WATERPROOF CONNECTORS BETWEEN TUBES
- OPERATING TEMPERATURE: -40°C TO +85°C
- CONFORMS TO UL 48 STANDARDS
- MOUNTING BUTTONS FASTENED TO WALLS:
W/ #12 TEK SCREWS IF INTO PLYWOOD
W/ 1/4" X 1-1/2" METAL ANCHORS IF INTO CONCRETE
- 120 VOLTS - 16 AMPS

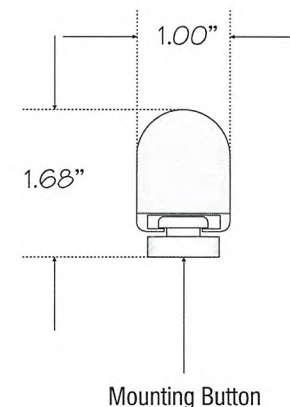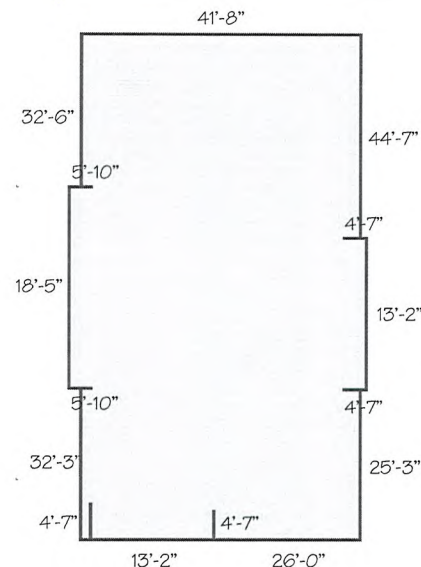

LED BORDER SYSTEM

SCALE: NTS

THIS IS AN ORIGINAL UNPUBLISHED DRAWING CREATED FOR YOUR PERSONAL USE IN CONNECTION WITH A PROJECT PLANNED FOR YOU BY NSMC. IT IS NOT TO BE SHOWN OUTSIDE YOUR ORGANIZATION NOR USED, REPRODUCED, COPIED OR EXHIBITED IN ANY FASHION UNLESS AUTHORIZED IN WRITING BY AN OFFICER OF NSMC.



**National Sign
& Marketing Corporation**
DBA Visual Information Systems Co.
13580 5th St., Chino, CA 91710
Tel 909.591.4142 Fax 909.591.9792
e-mail: sales@nsmc.com
NV Lic# 0071619 - Exp. 8/31/10
Class: C-9 Limit: \$950,000.00

Project: Carl's Jr.
Address: 7598 Vegas Dr., Las Vegas, NV
Phone: _____ Account Mgr. S. Rosenbloom
Designer: S. Duffy Scale: Noted Date: 04/20/2010

Client Approval: _____
Date: _____

APPROVED &
RELEASED FOR
CONSTRUCTION

Salesman _____ Date _____

Revisions:

Drawing Number
24359


VIDEO
ELECTRONIC SIGNS

RECEIVED
APR 27 2010

**VAR-38114
MSP-38116**

Install Only

1 DRIVE-THRU MENU BOARD

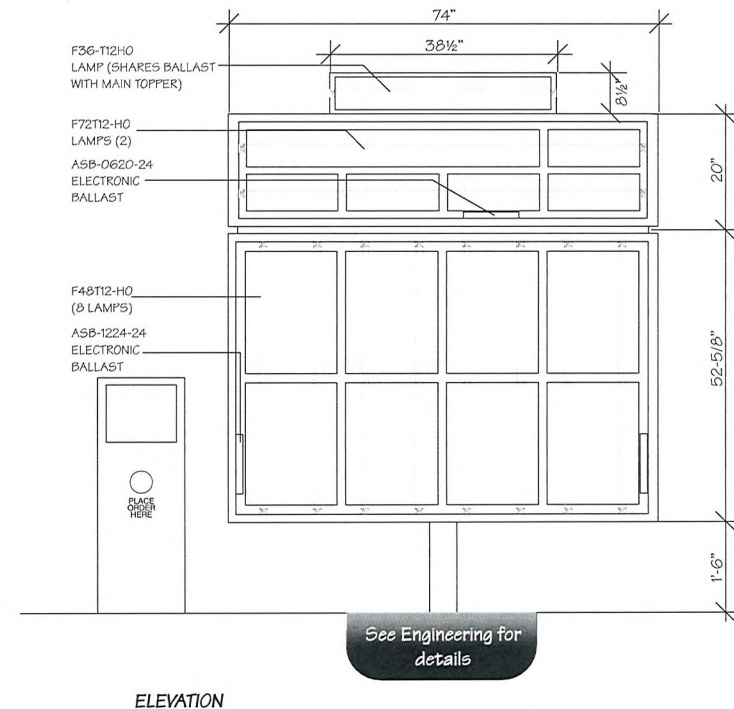


EXTERIOR MENU BOARD

SCALE: NTS

NOTE: ALL WORK TO COMPLY WITH 2005 SNEA & NEVADA ELECTRICAL CODE (NEC)

NOTE:
SEE SIZE OF
EMBEDMENT
SEPARATE
SHEET.

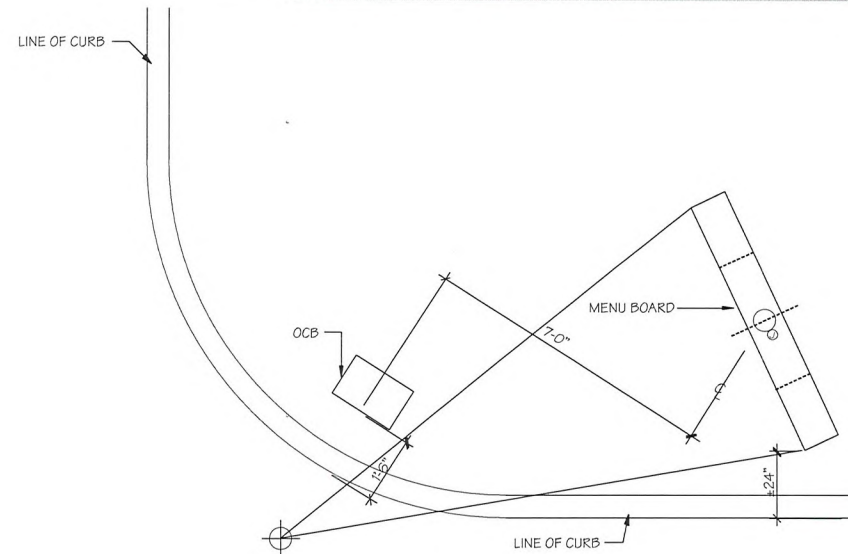

MENU BOARD LAYOUT AT DRIVE THRU

SCALE: NTS

MENU BOARD SPECIFICATIONS

SINGLE FACED ILLUMINATED DRIVE-THRU MENU BOARD CABINET IS OF EXTRUDED ALUMINUM CONSTRUCTION WASHED AND PRIMED WITH ETCHING PRIMER AND PAINTED BLACK.

DOORS ARE TEMPERED GLASS PANELS WITH EXTRUDED ALUMINUM FRAMES MOUNTED ON PIANO HINGES. ALL DOORS TO LOCK WITH A UNIVERSAL KEY.

COPY PANELS ARE WHITE 1/8" ACRYLIC WITH PLASTIC "H" TRACK FOR 20 SLATS.

TRANSLITE PANELS ARE WHITE 1/8" ACRYLIC WITH 1/8" CLEAR OVERLAY.

ELECTRICAL SPECIFICATIONS

ONE (1) 20 AMP BREAKER. TOTAL OF 7 AMPS IN SIGN, 120 VOLT.

THIS IS AN ORIGINAL UNPUBLISHED DRAWING CREATED FOR YOUR PERSONAL USE IN CONNECTION WITH A PROJECT PLANNED FOR YOU BY NSMC. IT IS NOT TO BE SHOWN OUTSIDE YOUR ORGANIZATION NOR USED, REPRODUCED, COPIED OR EXHIBITED IN ANY FASHION UNLESS AUTHORIZED IN WRITING BY AN OFFICER OF NSMC.



**National Sign
& MARKETING CORPORATION**
DBA Visual Information Systems Co.
13550 5th St., Chino, CA 91710
Tel 909.591.4742 Fax 909.591.9792
e-mail: sales@nsmc.com
NV Lic# 0071619 - Exp. 8/31/10
Class: C-6 Limit: \$950,000.00

Project: Carl's Jr.
Address: 7599 Vegas Dr., Las Vegas, NV
Phone: _____ Account Mgr. S. Rosenbloom
Designer: S. Duffy Scale: Noted Date: 04/20/2010

Client Approval: _____
Date: _____

APPROVED &
RELEASED FOR
CONSTRUCTION

Salesman Date

Revisions:

Drawing Number
24359


VIDEO
ELECTRONIC SIGNS

RECEIVED
APR 27 2010

**VAR-38114
MSP-38116**

Install Only

FOOTING TO BE DONE BY NSMC

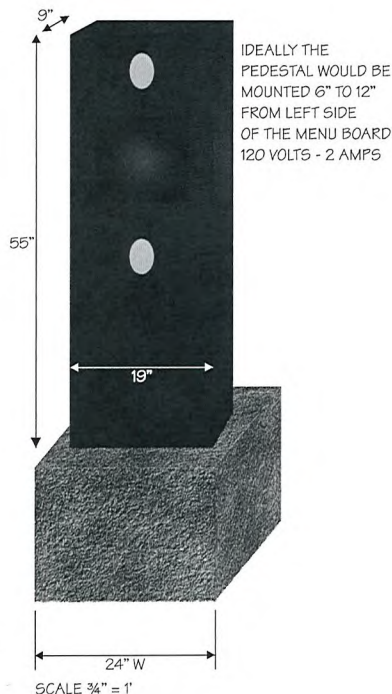





2 ORDER CONFIRMATION BOARD (FOOTING ONLY)

ORDER CONFIRMATION BOARD BUILT BY:
HyperActive Technologies
8 Foster Plaza, 4th Floor
720 Holiday Drive
Pittsburgh, PA 15220
Phone: 412.322.3060 Fax: 412.322.3121

ORDER CONFIRMATION BOARD

SCALE: NTS

SEE ENGINEERING FOR FOOTING DETAILS

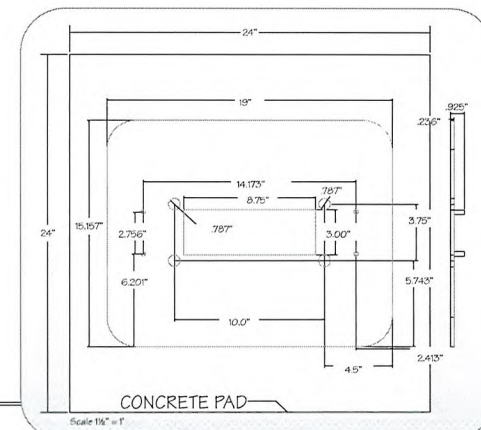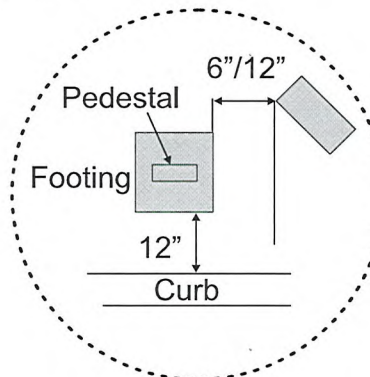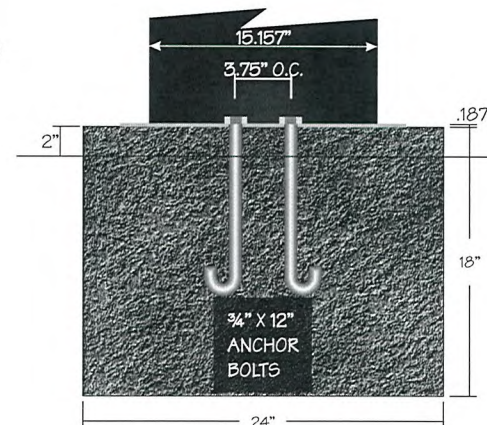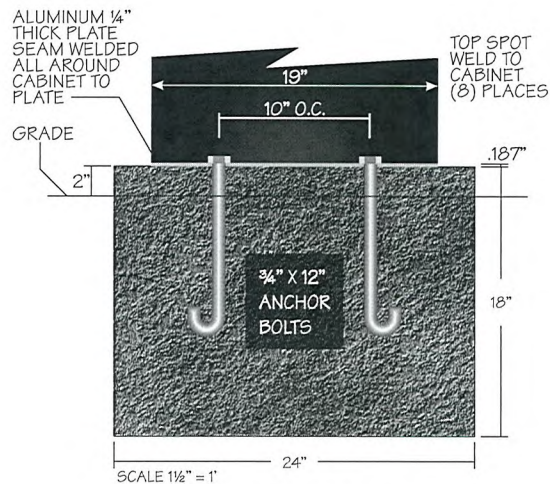

NOTE: ALL WORK TO COMPLY WITH 2005 SNEA & NEVADA ELECTRICAL CODE (NEC)

THIS IS AN ORIGINAL UNPUBLISHED DRAWING CREATED FOR YOUR PERSONAL USE IN CONNECTION WITH A PROJECT PLANNED FOR YOU BY NSMC. IT IS NOT TO BE SHOWN OUTSIDE YOUR ORGANIZATION NOR USED, REPRODUCED, COPIED OR EXHIBITED IN ANY FASHION UNLESS AUTHORIZED IN WRITING BY AN OFFICER OF NSMC



National Sign & Marketing Corporation

DBA Visual Information Systems Co.
13580 5th St., Chino, CA 91710
Tel 909.591.4742 Fax 909.591.9792
e-mail: sales@nsmc.com
NV Lic# 0071619 - Exp. 8/31/10
Class: C-6 Limit: \$950,000.00

Project: Carl's Jr.
Address: 7598 Vegas Dr., Las Vegas, NV
Phone: Account Mgr. S. Rosenbloom
Designer: S. Duffy Scale: Noted Date: 04/20/2010

Client Approval:
Date:

APPROVED & RELEASED FOR CONSTRUCTION
Salesman Date

Revisions:

Drawing Number
24359





APR 27 2010

VAR-38114
MSP-38116

3 INTERIOR MENU BOARD

MENU BOARD BUILT BY:
SIGN RESOURCE
P.O. BOX 549 - MAXWOOD, CA 90270
800-423-4283
323-771-2098
FAX 323-560-7143
WWW.SIGNRESOURCE.NET


INSTALL ONLY

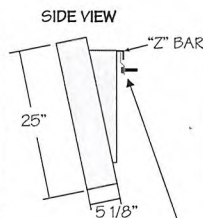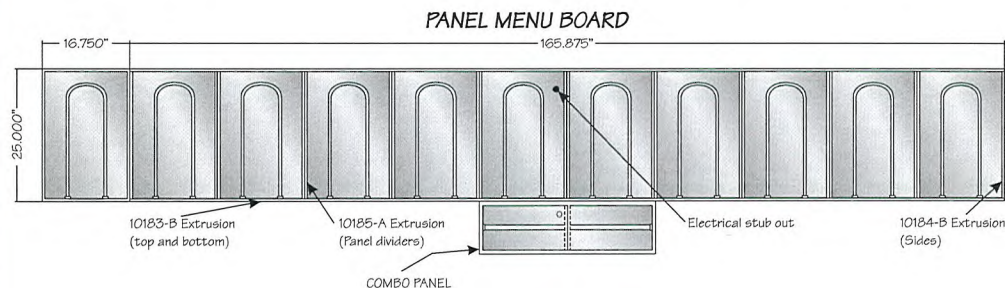

- All aluminum extrusion construction, .0900 thick 6063-T5 alloy.
- All exposed surfaces of cabinets have a 5 step paint process including sanding, chemical degreasing, etching primer, polyurethane undercoat and polyurethane paint.
- All cabinets are manufactured to UL specifications and bear their label.

10" 'Z' (supplied) is mounted to wall. Brackets mounted to rear of cabinet hang menu from 'Z' bar.
#14 Lag Bolts x3" Penetration every 16" O.C. (If dry wall & wood studs)
1/4"X3" Toggle Bolts every 16" O. C. (If tile wall).

- 120 volts, 60 Hz
- 2.37 amps
- Hardware electrical connection by GC
- Replacement lamps: F80 32 T8/741
- Replacement ballasts: Advance REL-4P32-SC
- Provide separate circuit for all signs

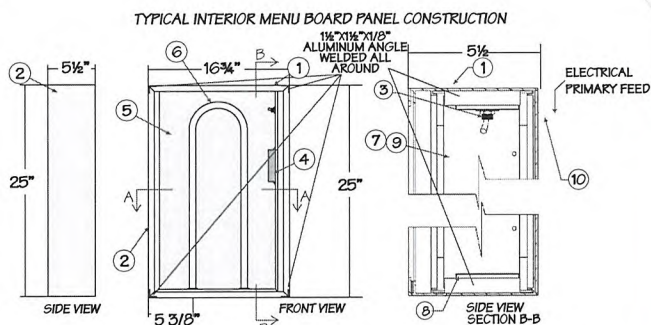

SCALE: NTS

[illegible]

NOTE: ALL WORK TO COMPLY WITH 2005 SNEA & NEVADA ELECTRICAL CODE (NEC)

THIS IS AN ORIGINAL UNPUBLISHED DRAWING CREATED FOR YOUR PERSONAL USE IN CONNECTION WITH A PROJECT PLANNED FOR YOU BY NSMC. IT IS NOT TO BE SHOWN OUTSIDE YOUR ORGANIZATION NOR USED, REPRODUCED, COPIED OR EXHIBITED IN ANY FASHION UNLESS AUTHORIZED IN WRITING BY AN OFFICER OF NSMC.



& MARKETING CORPORATION
DBA Visual Information Systems Co.
13580 5th St., Chino, CA 91710
Tel 909.591.4742 Fax 909.591.9792
e-mail: sales@nsmc.com
NV Lic# 0071619 - Exp. 8/31/10
Class: C-6 Limit: \$950,000.00

Project: Carl's Jr.
Address: 7598 Vegas Dr., Las Vegas, NV
Phone: _____ **Account Mgr.** S. Rosenbloom
Designer: S. Duffy **Scale:** Noted **Date:** 04/20/2010

Date: _____

Salesman	Date
----------	------

24359



ELECTRONIC SIGNS


APR 27 2010

VAR-38114
MSP-38116

Install Only

ALL MANUFACTURING BY OTHERS INSTALL ONLY


4 INTERIOR MENU BOARD LIGHT BOX COMBO PANEL

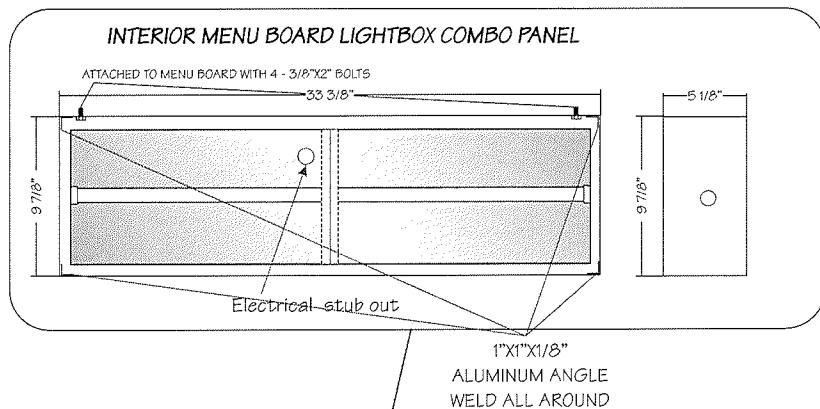

MENU BOARD BUILT BY:
SIGN RESOURCE
P.O. BOX 549 - MAWOOD, CA 90270
909-425-4283
925-771-2099
FAX 925-560-7143
WWW.SIGNRESOURCE.NET

INTERIOR MENU BOARD LIGHTBOX COMBO PANEL

SCALE: NTS

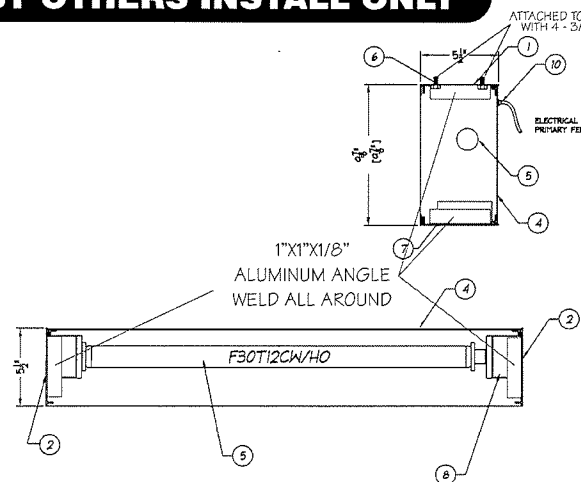

PARTS LIST					
NO	PART #	DESCRIPTION			
1	1000-B	5.50" EXTENSION FRAME TOP & BOTTOM			
2	1000-B	5.50" EXTENSION FRAME FOR SIDE			
3	00500-00000	WEDGE HOOKS 3 TOOLS			
4	0450000006	ALUMINUM STRIP BACKING			
5	0400000009	PSD TO CLAMP FLUORESCENT LAMP			
6	0450000007	ALUMINUM ANGLE 1/2" X 1/2" X 1/2"			
7	0050000000	ALUMINUM ANGLE 1/2" X 1/2" X 1/2"			
8	0450000007	ALUMINUM ANGLE 1/2" X 1/2" X 1/2"			
9	0450000007	ALUMINUM STRIP BACKING			
10	0450000007	ALUMINUM STRIP BACKING			
11	1000-A	VERTICAL DIVIDER INT.			
Voltage 120 AC Grains 11 ONE Current AMP Drawn By JM Date 12-16-68 Description 8 1/2" X 33 3/8" COMBO INTERIOR LIGHTBOX MENUBOARD Draw Size 2.24 SQ FT Design Lead 30 PSF Client CARL'S Jr. Page 1 OF 1 Part Number KCE008 Drawing No. KCE008 Rev.					

Construction:

- All aluminum extrusion construction, .0900 thick 6063-T5 alloy.
- All exposed surfaces of cabinets have a 5 step paint process including sanding, chemical degreasing, etching primer, polyurethane undercoat and polyurethane paint.
- All cabinets are manufactured to UL specifications and bear their label.

Installation:

- This cabinet bolts to the bottom of the Carl's 10/11 panel interior menu, item #00036080. Using 1/4"x1-1/2" bolts into nutserts pre-mounted at bottom of 10/11 menu board by manufacturer.

Electrical:

- 120 volts, 60 hz
- .40 amps
- Hardware electrical connection by GC
- Replacement lamps: F25T12/CW/30
- Replacement ballasts: LC-25/340-H2 (1 each)
- Replacement starter: F5-25
- Provide separate circuit for all signs

NOTE: ALL WORK TO COMPLY WITH 2005 SNEA & NEVADA ELECTRICAL CODE (NEC)

THIS IS AN ORIGINAL UNPUBLISHED DRAWING CREATED FOR YOUR PERSONAL USE IN CONNECTION WITH A PROJECT PLANNED FOR YOU BY NSMC. IT IS NOT TO BE SHOWN OUTSIDE YOUR ORGANIZATION NOR USED, REPRODUCED, COPIED OR EXHIBITED IN ANY FASHION UNLESS AUTHORIZED IN WRITING BY AN OFFICER OF NSMC



**National Sign
& MARKETING CORPORATION**
DBA Visual Information Systems Co.
13580 5th St., Chino, CA 91710
Tel 909.591.4742 Fax 909.591.9792
e-mail: sales@nsmc.com
NV Lic# 0071613 Exp. 8/31/10
Class: C-B Limit \$950,000.00

Project: Carl's Jr.
Address: 7598 Vegas Dr., Las Vegas, NV
Phone: Account Mgr. S. Rosenbloom
Designer: S. Duffy Scale: Noted Date: 04/20/2010

Client Approval:
Date:

APPROVED &
RELEASED FOR
CONSTRUCTION
Salesman Date

Revisions:


Drawing Number
24359

VISEO
ELECTRONIC SIGNS

APR 27 2010

**VAR-38114
MSP-38116**

PROPOSED ELEV.

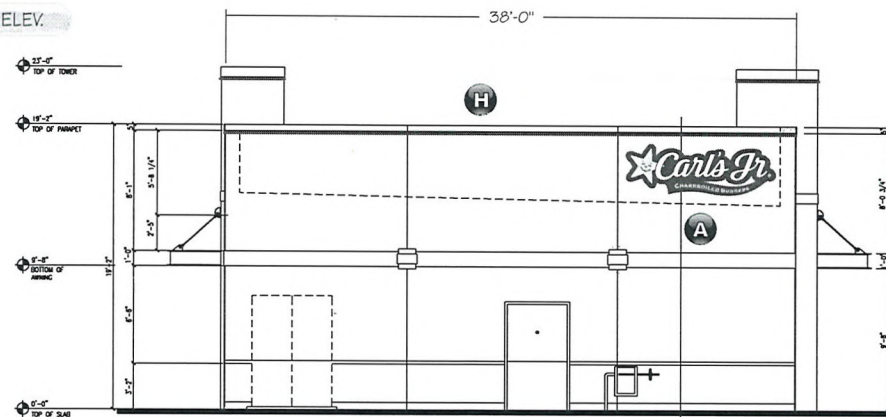

A 42" EMBOSSED ILLUM. "CARL'S JR." CLOUD SIGN

H NEW LED BORDER TUBE LIGHT SYSTEM
52'-1" LIN. FT. APPROX.

North Elevation

SCALE: 1/8"=1'

PROPOSED ELEV.



B 42" EMBOSSED ILLUM. "CARL'S JR." CLOUD SIGN

H NEW LED BORDER TUBE LIGHT SYSTEM
49'-7" LIN. FT. APPROX.

South Elevation

SCALE: 1/8"=1'

THIS IS AN ORIGINAL UNPUBLISHED DRAWING CREATED FOR YOUR PERSONAL USE IN CONNECTION WITH A PROJECT PLANNED FOR YOU BY NSMC. IT IS NOT TO BE SHOWN OUTSIDE YOUR ORGANIZATION NOR USED, REPRODUCED, COPIED OR EXHIBITED IN ANY FASHION UNLESS AUTHORIZED IN WRITING BY AN OFFICER OF NSMC.



**National Sign
& MARKETING CORPORATION**
DBA Visual Information Systems Co.
13580 5th St., Chino, CA 91710
Tel 909.591.4742 Fax 909.591.9792
e-mail: sales@nsmc.com
NV Lic# 0071619 - Exp. 8/31/10
Class: C-6 Limit: \$950,000.00

Project: Carl's Jr.
Address: 7598 Vegas Dr., Las Vegas, NV
Phone: _____ Account Mgr. S. Rosenbloom
Designer: S. Duffy Scale: Noted Date: 04/20/2010

Client Approval: _____
Date: _____

APPROVED &
RELEASED FOR
CONSTRUCTION
Salesman _____ Date _____

Revisions:


Drawing Number
24359

VIDEO
ELECTRONIC SIGNS

APR 27 2010

**VAR-38114
MSP-38116**

PROPOSED ELEV.

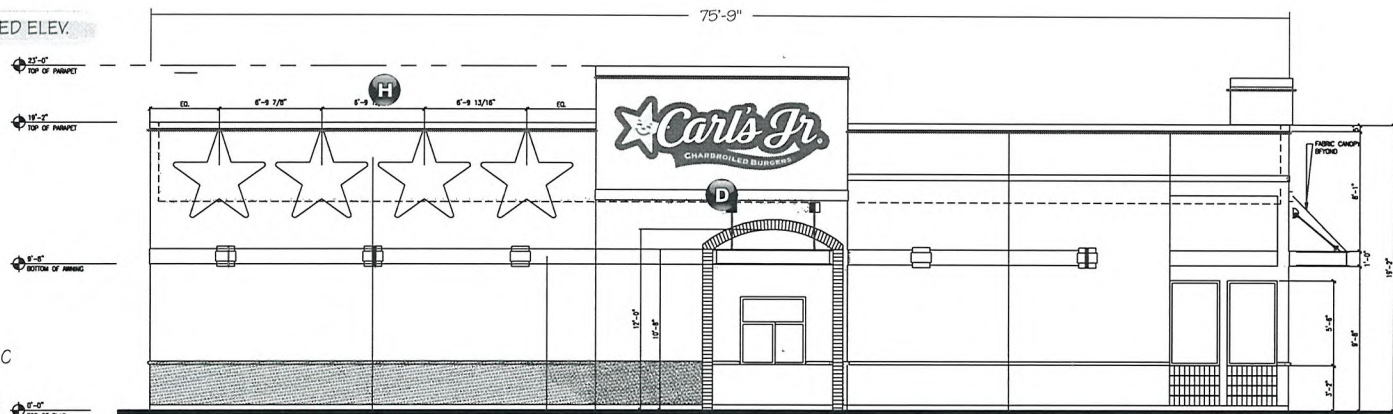

D 60" EMBOSSED ILLUM. "CARL'S JR." CLC

H NEW LED BORDER TUBE LIGHT SYSTEM
87'-9" LIN. FT. APPROX.

West Elevation

SCALE: 1/8"=1'

PROPOSED ELEV.



C 42" EMBOSSED ILLUM. "CARL'S JR." CLOUD SIGN

H NEW LED BORDER TUBE LIGHT SYSTEM
87'-7" LIN. FT. APPROX.

East Elevation

SCALE: 1/8"=1'

THIS IS AN ORIGINAL UNPUBLISHED DRAWING CREATED FOR YOUR PERSONAL USE IN CONNECTION WITH A PROJECT PLANNED FOR YOU BY NSMC. IT IS NOT TO BE SHOWN OUTSIDE YOUR ORGANIZATION NOR USED, REPRODUCED, COPIED OR EXHIBITED IN ANY FASHION UNLESS AUTHORIZED IN WRITING BY AN OFFICER OF NSMC.



National Sign & MARKETING CORPORATION

DBA Visual Information Systems Co.
13580 5th St., Chino, CA 91710
Tel 909.591.4742 Fax 909.591.9792
e-mail: sales@nsmc.com
NV Lic# 0071619 - Exp. 8/31/10
Class: C-6 Limit: \$950,000.00

Project: Carl's Jr.
Address: 7598 Vegas Dr., Las Vegas, NV
Phone: _____ Account Mgr. S. Rosenbloom
Designer: S. Duffy Scale: Noted Date: 04/20/2010

Client Approval:

Date: _____

APPROVED &
RELEASED FOR
CONSTRUCTION

Salesman Date

Revisions:

Drawing Number

24359




ELECTRONIC SIGNS

APR 27 2010

VAR-38114
MSP-38116

National Sign & Marketing Corporation

13580 5th Street • Chino, CA 91710 • Tel: 909.591.4742 • FAX: 909.591.9792 • Toll Free: 877.877.NSMC

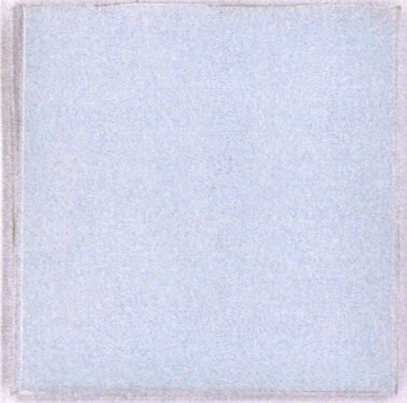


3/16" White Lexan




Cloud Sign Face



Pre-coated aluminum returns

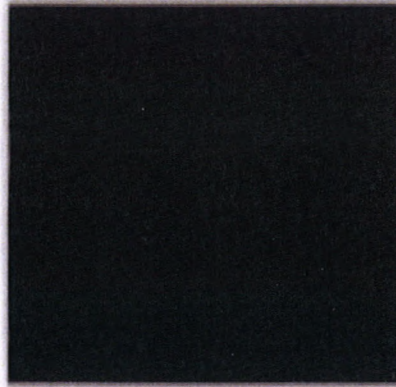


Aluminum painted black

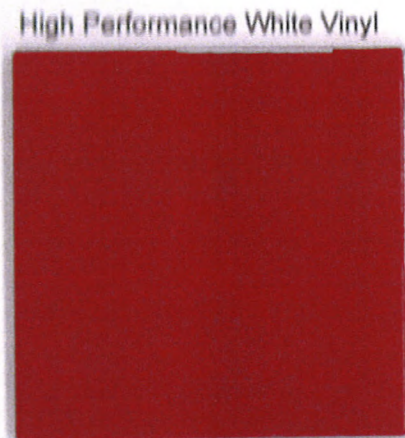


High Performance White Vinyl



3M-3630-73 Red
Translucent Vinyl

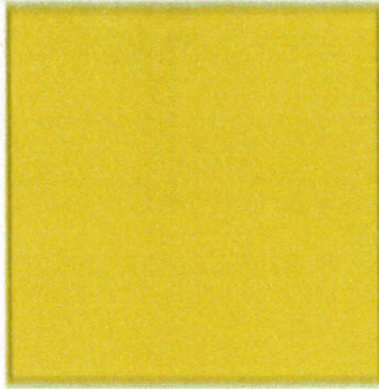

3M-3630-15 Yellow
Translucent Vinyl

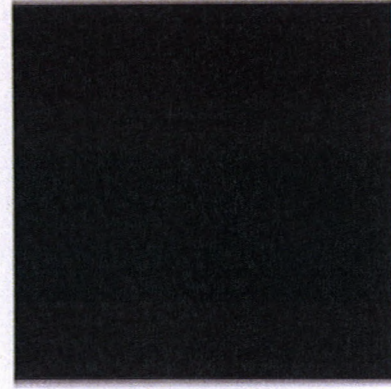

3M-180C-12 High Performance
Black Vinyl



RECEIVED

VAR-38114 APR 27 2010