



IMPROVEMENT PLANS


FOR

SKYE CANYON PHASE 3B, 3C

SHAUMBER ROAD

SKYE CANYON PARK TO IRON MOUNTAIN RD

APN:126-12-101-002
28.3 AC

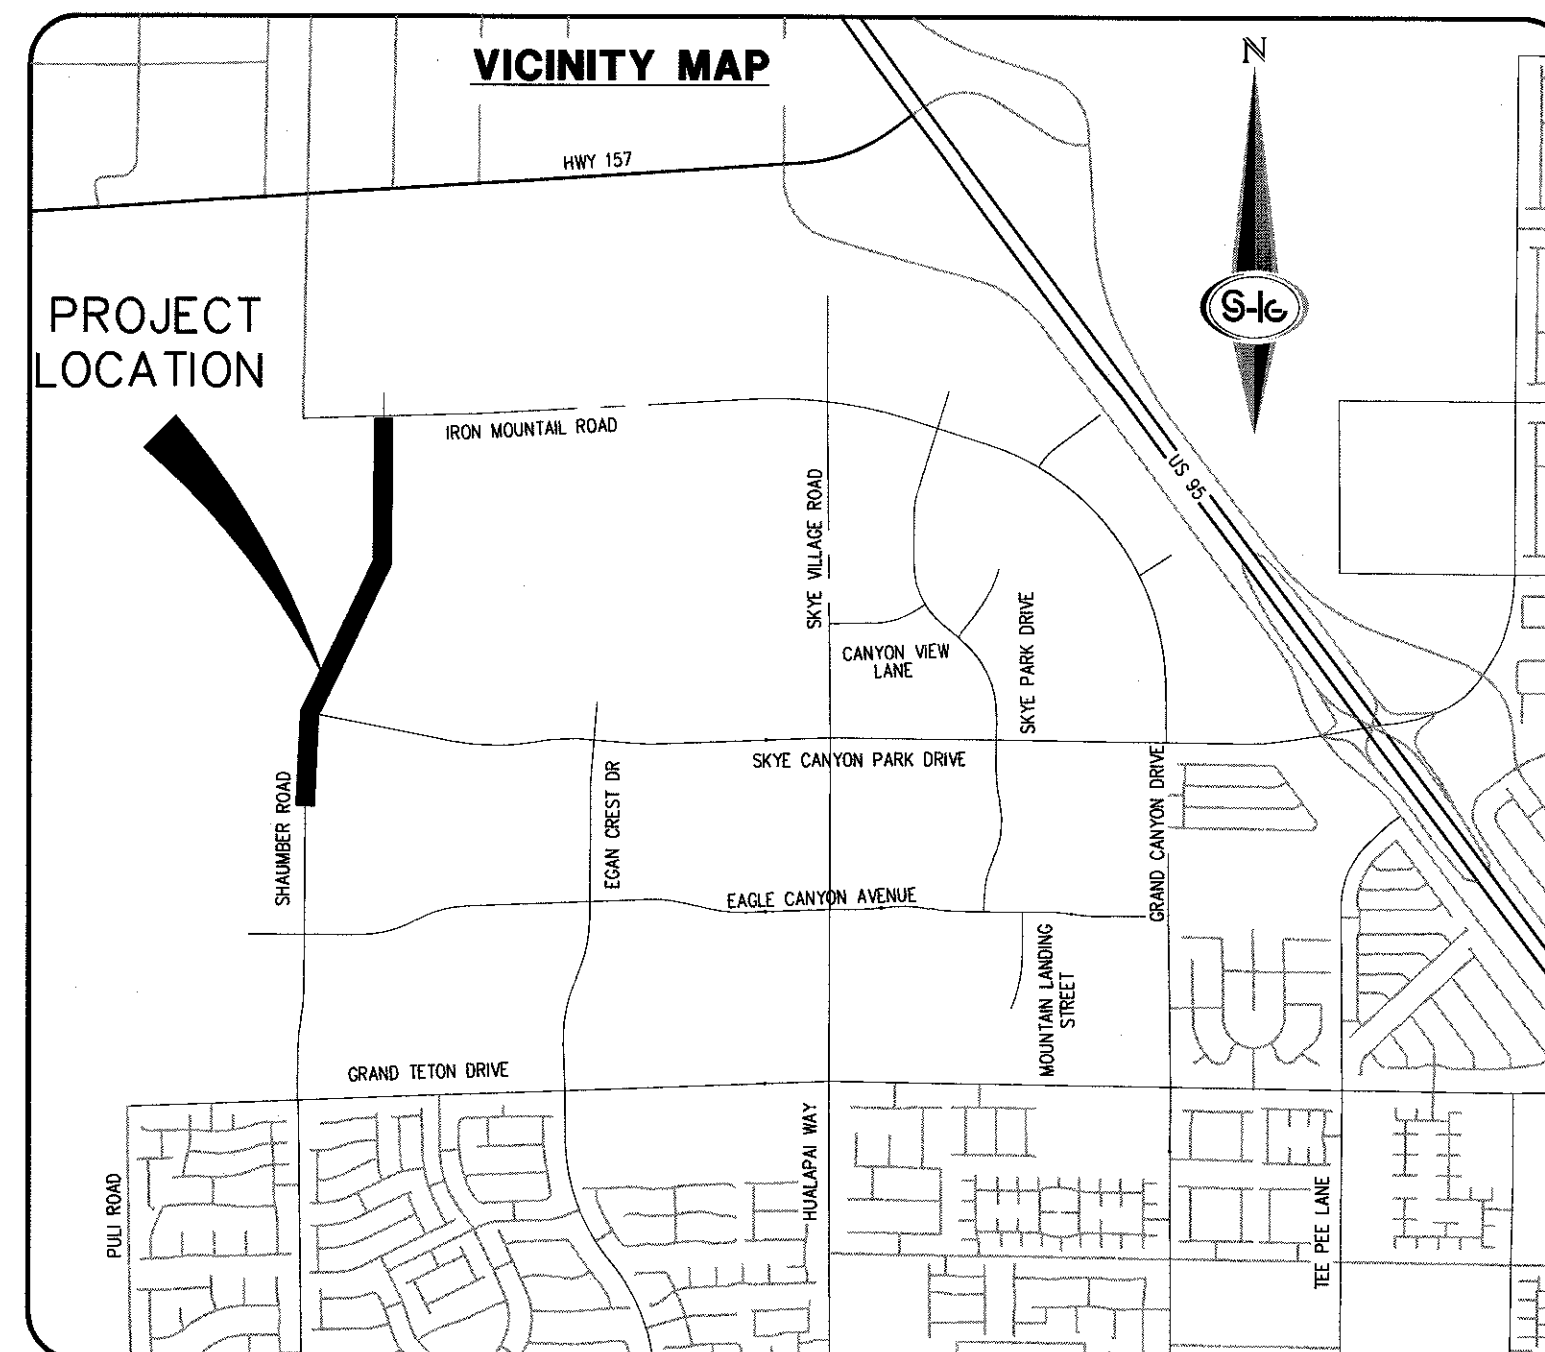

BENCHMARK

MONUMENT ID: USDA (1934) 19
U.S. DEPARTMENT OF AGRICULTURE BRASS DISC AT SOUTHWEST CORNER OF U.S. 95 AND KYLE CANYON ROAD
ELEVATION = 2817.61 FEET, 858.810 METERS
NAVD 88 DATUM
PER THE CITY OF LAS VEGAS BENCHMARK BOOK - 2008 ADJUSTMENT (UPDATED 05/24/2010)

BASIS OF BEARING

NORTH 89°16'30" WEST, BEING THE BEARING OF THE SOUTH LINE OF THE NORTHWEST QUARTER (NW1/4) OF SECTION 7, TOWNSHIP 19 SOUTH, RANGE 60 EAST, M.D.M., CITY OF LAS VEGAS, CLARK COUNTY, NEVADA, AS SHOWN BY MAP THEREOF IN FILE 147, PAGE 71 OF PLATS IN THE CLARK COUNTY RECORDER'S OFFICE, NEVADA.

OWNER


M F LAND LLC
% OLYMPIA COMPANIES LLC
11411 SOUTHERN HIGHLANDS
PARKWAY, SUITE 300
LAS VEGAS, NV 89141

DEVELOPER

NINETY-FIVE MANAGEMENT LLC
% OLYMPIA COMPANIES LLC
11411 SOUTHERN HIGHLANDS
PARKWAY, SUITE 300
LAS VEGAS, NV 89141
PH (702) 220-6565
FX (702) 220-6566

ENGINEER

SLATER HANIFAN GROUP
5740 S. ARVILLE STREET #216
LAS VEGAS, NV 89118
(702) 284-5300

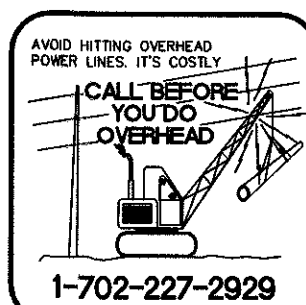

APPROVALS

CITY ENGINEER-ALLEN E. PAVELKA PE #9029 DATE
APPROVAL OF THESE PLANS BY THE CITY ENGINEER IS LIMITED TO THOSE IMPROVEMENTS CONSTRUCTED IN THE DEDICATED OF RIGHT-OF-WAY, AND/OR DEDICATED EASEMENTS. THIS APPROVAL DOES NOT AUTHORIZE CONSTRUCTION OF ANY IMPROVEMENTS THAT DEVIATE FROM ADOPTED STANDARDS AND/OR SPECIFICATIONS EXCEPT THOSE SPECIALLY LISTED UNDER DEVIATIONS FORM STANDARDS. THE ENGINEER SHALL RESOLVE ANY DEVIATION OTHER THAN THOSE LISTED IN DEVIATIONS FROM STANDARDS IN FAVOR OF THE UNIFORM STANDARD DRAWINGS AND SPECIFICATIONS, CLARK COUNTY AREA, NEVADA.

CHRIS KNIGHT DATE
DIRECTOR, BUILDING AND SAFETY
THIS PLAN MEETS THE APPLICABLE STANDARDS OF THE PLANNING DEPARTMENT.

APPROVED FOR CONSTRUCTION

LAS VEGAS VALLEY WATER DISTRICT ENGINEERING SERVICES MANAGER
PROJECT NO. XXXXX DATE
SHEETS:
LVVWD APPROVED FIRE FLOW XXXX GPM AT XX PSI RESIDUAL

APPROVAL BY THE FIRE DEPARTMENT HAVING JURISDICTION IS REQUIRED PRIOR TO OBTAINING FINAL APPROVAL FROM THE LAS VEGAS VALLEY WATER DISTRICT.

LAS VEGAS FIRE AND RESCUE DATE

NV ENERGY DATE

NV ENERGY ACKNOWLEDGES THAT WE HAVE RECEIVED YOUR PLANS AND WILL PROVIDE SERVICE TO ALL ELECTRICAL NEEDS ASSOCIATED WITH THIS PROJECT. NV ENERGY RESERVES THE RIGHT TO ADDRESS ANY EXISTING OR FUTURE CONFLICTS ONCE THE FINAL DESIGN IS COMPLETED. THE NEW SERVICE AND THE RESOLUTION OF ANY CONFLICTS WILL BE ACCOMPLISHED PURSUANT TO THE NEVADA PUBLIC UTILITY COMMISSION'S RULES AND REGULATIONS.

CENTRAL TELEPHONE CO, DBA CENTURYLINK DATE

THE AFFIXED CENTRAL TELEPHONE CO, DBA CENTURYLINK APPROVAL DOES NOT ASSUME OR GUARANTEE LIABILITY FOR KNOWN OR UNKNOWN CONFLICTS WITH EXISTING OR PROPOSED IMPROVEMENTS. RESOLUTION OF ANY CONFLICT WILL BE ACCOMPLISHED PURSUANT TO LOCAL ORDINANCES, NEVADA REVISED STATUTES AND/OR PUBLIC UTILITY COMMISSION RULES AND REGULATIONS.

SOUTHWEST GAS CORPORATION DATE

COX COMMUNICATIONS LAS VEGAS, INC. DATE

INDEX OF DRAWINGS

SHT. NO.	DWG NO.	DESCRIPTION
1	G-01	COVER SHEET
2	G-02	GENERAL NOTES
3	G-03	ABBREVIATIONS, LEGEND, AND QUANTITIES
4	TY-01	ROADWAY SECTIONS
5	PP-01	CONSTRUCTION PLAN - "SR" 22+00 TO "SR" 28+00
6	PP-02	CONSTRUCTION PLAN - "SR" 28+00 TO "SR" 34+50
7	PP-03	CONSTRUCTION PLAN - "SR" 34+50 TO "SR" 40+50
8	PP-04	CONSTRUCTION PLAN - "SR" 40+50 TO "SR" 46+50
9	PP-05	CONSTRUCTION PLAN - "SR" 46+50 TO "SR" 52+50
10	PP-06	CONSTRUCTION PLAN - "SR" 52+50 TO "SR" 58+50
11	PP-07	CONSTRUCTION PLAN - "SR" 58+50 TO "SR" 64+50
12	PP-08	CONSTRUCTION PLAN - "SR" 64+50 TO "SR" 69+50
13	PP-09	CONSTRUCTION PLAN - DB OUTFALL
14	LAT-01	STORM DRAIN LATERALS I
15	LAT-02	STORM DRAIN LATERALS II
16	GR-01	GRADING SHEET I
17	GR-02	GRADING SHEET II
18	GR-03	GRADING SHEET III
19	GR-04	GRADING SHEET IV
20	GR-05	GRADING SHEET V
21	DTL-01	STORM DRAIN DETAILS
22	UTL-01	UTL PLAN & PROFILE - "SR" 22+00 TO "SR" 28+00
23	UTL-02	UTL PLAN & PROFILE - "SR" 28+00 TO "SR" 34+50
24	UTL-03	UTL PLAN & PROFILE - "SR" 34+50 TO "SR" 40+50
25	UTL-04	UTL PLAN & PROFILE - "SR" 40+50 TO "SR" 46+50
26	UTL-05	UTL PLAN & PROFILE - "SR" 46+50 TO "SR" 52+50
27	UTL-06	UTL PLAN & PROFILE - "SR" 52+50 TO "SR" 58+50
28	UTL-07	UTL PLAN & PROFILE - "SR" 58+50 TO "SR" 64+50
29	UTL-08	UTL PLAN & PROFILE - "SR" 64+50 TO "SR" 69+50
30	UTL-09	UTILITY LATERAL I
31	UTL-10	UTILITY LATERAL II
32	UTL-11	UTILITY LATERAL III
33	TR-01	TRAFFIC PLAN I
34	TR-02	TRAFFIC PLAN II
35	TR-03	TRAFFIC PLAN III
36	TR-04	TRAFFIC PLAN IV

SLATER HANIFAN GROUP
a Westwood team
5740 S. ARVILLE STREET #216 LAS VEGAS, NV 89118
PHONE (702) 284-5300 FAX (702) 284-5399

NINETY-FIVE MANAGEMENT LLC

SKYE CANYON PHASE 3B, 3C
SHAUMBER ROAD
COVER SHEET



DATE: 9/8/18


DRAFTER: HF

DESIGNER: HF

CHECKED: DY

PROJECT NO.

OLY1609-000

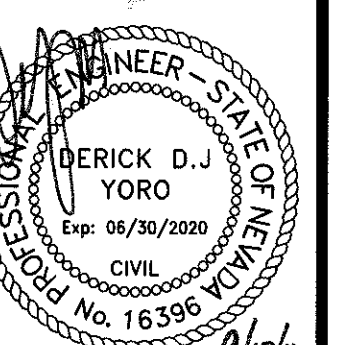

G-01

SHEET 1 OF 36

AND MATERIALS SHALL BE IN ACCORDANCE WITH THE LATEST EDITION OF THE DESIGN AND STANDARDS FOR WASTEWATER COLLECTION SYSTEMS AND THE UNIFORM STANDARD FOR PUBLIC WORKS' CONSTRUCTION OFF-SITE IMPROVEMENTS, CLARK COUNTY AREA, NEVADA, AND THE RESPONSIBILITY OF THE CONTRACTOR TO BE AWARE OF THE CONTENTS OF THE IONS.

CONTRACTOR'S RESPONSIBILITY TO PERFORM CONSTRUCTION AS PER PLANS, ANY ADDITIONS, CHANGES SHALL FIRST MEET WITH THE APPROVAL OF THE CITY ENGINEER.

IN CURBS WHERE SEWER OR GAS LATERALS PASS UNDER THE CURB.

SEWER PIPE SHALL MEET ASTM D-3034 SDR 35 SPECIFICATIONS, INSTALLED WITH SAND FILLED OF TYPE II AGGREGATE BASE.

IN STREETS EIGHTY (80') FOOT R/W AND LARGER SHALL HAVE CONCRETE COLLARS.

AN EIGHTY (80') FOOT R/W WILL REQUIRE RETROFIT IF PAVING DOES NOT CONFORM TO CITY H MANHOLE.

ALL BE USED TO CONNECT SEWER LATERALS TO EXISTING MAIN LINES UP TO TWELVE INCH (12 INCHES) TO FIFTEEN INCH (15") OR LARGER MAINS SHALL REQUIRE SPECIAL PROCEDURES. IN BE USED ON LINES TWELVE INCHES (12") OR ABOVE.

ALL BE PROTECTED IN ACCORDANCE WITH LVWD STANDARDS WHENEVER A SEWER MAIN IS EXCAVATED OR THE SEWER IS LESS THAN EIGHTEEN INCH (18") UNDER A WATER MAIN.

IN INSTALLING SEWER MAINS THAT WILL BE UNDER THE JURISDICTION OF THE CITY OF LAS VEGAS OF NEVADA CLASS "A" CONTRACTORS.

VEGAS WILL NOT ACCEPT ANY SEWER MAINS WHICH HAVE A VERTICAL DEFLECTION OF MORE (0.1) OF A FOOT FROM THE APPROVED CONSTRUCTION PLANS AT ANY LOCATION. SEWER EXCEED THIS TOLERANCE WILL HAVE TO BE REPAIRED OR REMOVED OR REPLACED TO THE CITY ENGINEER PRIOR TO ACCEPTANCE BY THE CITY OF LAS VEGAS.

CURVED SEWER REQUIRES THE USE OF C-900 PIPE WHICH ALLOWS FOR PIPE DEFLECTION AT

1. THE OWNER, SITE DEVELOPER, CONTRACTOR, AND/OR THEIR AUTHORIZED AGENTS SHALL EACH DAY REMOVE ALL SEDIMENT, MUD, CONSTRUCTION DEBRIS, OR OTHER POTENTIAL POLLUTANTS THAT MAY HAVE BEEN ACCUMULATED ON OR NEAR THE CONSTRUCTION SITE. THE OWNER, CONTRACTOR, AND COUNTY AS A RESULT OF CONSTRUCTION ACTIVITIES ASSOCIATED WITH THIS SITE DEVELOPMENT OR CONSTRUCTION PROJECT. SUCH MATERIALS SHALL BE PREVENTED FROM ENTERING THE STORM SEWER SYSTEM.
2. ADDITIONAL CONSTRUCTION SITE DISCHARGE BEST MANAGEMENT PRACTICES MAY BE REQUIRED OF THE OWNER AND HIS OR HER AGENTS DUE TO UNFORESEEN EROSION PROBLEMS IF THE SUBMITTED PLAN DOES NOT MEET THE PERFORMANCE STANDARD IN THE USDOCA AND THE LAS VEGAS VALLEY CONSTRUCTION SITE EROSION CONTROL MANUAL.
3. TEMPORARY OR PERMANENT STABILIZATION PRACTICES WILL BE INSTALLED ON DISTURBED AREAS AS SOON AS PRACTICABLE AND NO LATER THAN 14 DAYS AFTER THE CONSTRUCTION ACTIVITY IN THAT PORTION OF THE SITE HAS TEMPORARILY OR PERMANENTLY CEASED. SOME EXCEPTIONS MAY APPLY; REFER TO THE NEVADA STORMWATER GENERAL PERMIT FOR CONSTRUCTION ACTIVITY NVR100000, SECTION II.A.5.
4. AT A MINIMUM, THE CONTRACTOR OR HIS AGENT SHALL INSPECT ALL DISTURBED AREAS, AREAS USED FOR STORAGE OF MATERIALS AND EQUIPMENT THAT ARE EXPOSED TO PRECIPITATION, VEHICLE ENTRANCE AND EXIT, AND LOADING AND UNLOADING OF MATERIALS. THE CONTRACTOR SHALL UPDATE OR MODIFY THE STORMWATER POLLUTION PREVENTION PLAN AS NECESSARY. SOME EXCEPTIONS TO WEEKLY INSPECTIONS MAY APPLY, SUCH AS SUCH AS QUALITY CONTROL INSPECTIONS. REFER TO THE NEVADA STORMWATER GENERAL PERMIT FOR CONSTRUCTION ACTIVITY NVR 100000, SECTION II.A.12.
5. THE DEVELOPER SHALL BE RESPONSIBLE TO PROVIDE AND INSTALL ALL PERMANENT SIGNS SHOWN ON THE PLANS. STREET NAME SIGNS SHALL CONFORM IN THEIR ENTIRETY TO CLARK COUNTY AREA STANDARDS. ALL OTHER SIGNS SHALL BE STANDARD SIZE UNLESS OTHERWISE SPECIFIED ON THE PLANS. ALL SIGN POSTS SHALL BE INSTALLED IN ACCORDANCE WITH CLARK COUNTY AREA STANDARDS. ALL SIGNS SHALL USE TYPE III SHEETING.

- NO WORK SHALL BEGIN UNTIL THE WATER PLANS HAVE BEEN APPROVED FOR CONSTRUCTION BY THE LVVMD. FOLLOWING WATER PLAN APPROVAL, NOTICE SHALL BE GIVEN TO THE LVVMD COMMUNICATION SUPPORT CENTER (258-7171) TWO (2) WORKING DAYS PRIOR TO THE START OF CONSTRUCTION. FOR FUTURE INSPECTIONS, NOTICE MUST BE GIVEN BY 2:00 P.M. THE BUSINESS DAY PRIOR TO THE REQUESTED LVVMD INSPECTION. **WHEN REQUESTING INSPECTIONS, PLEASE REFER TO THE PROJECT # IDENTIFIED ABOVE.**
- ALL WORK SHALL CONFORM TO LVVMD STANDARD PLATES, DRAWINGS, AND SPECIFICATIONS, AND TO THE 2010 EDITION OF THE UNIFORM DESIGN AND CONSTRUCTION STANDARDS FOR POTABLE WATER SYSTEMS (UDACS). **THE LATEST EDITION OF UDACS SHALL SUPERSEDE ANY CONFLICTS CONTAINED IN THE APPROVED DRAWINGS AND/OR SPECIFICATIONS.**
- ALL WORK, EXCEPT AS MODIFIED BY THESE PLANS OR BY NOTE 2 ABOVE, SHALL BE DONE IN ACCORDANCE WITH THE MOST RECENT DRAFT OR EDITION OF THE UNIFORM SPECIFICATIONS FOR PUBLIC WORKS CONSTRUCTION OFFSITE IMPROVEMENT, CLARK COUNTY AREA.
- A SINGLE PIPE MATERIAL SHALL BE USED THROUGHOUT THE PROJECT UNLESS OTHERWISE APPROVED BY THE LVVMD.
- ALL SERVICE LATERALS TWO (2) INCHES IN DIAMETER AND SMALLER SHALL BE TYPE K COPPER TUBING WITH LVVMD APPROVED SERVICE SADDLES.
- ALL WATER METER BOXES SHALL BE LOCATED OUTSIDE OF DRIVEWAY AREAS.
- ALL VALVES SHALL BE LOCATED OUTSIDE OF DRIVEWAYS, VALLEY AND CURB CUTTERS.
- ALL WATER AND STORM DRAIN OR SANITARY SEWER CROSSINGS SHALL CONFORM TO SECTION 2.22 OF THE 2010 EDITION OF THE UDACS
- ALL WATER FACILITIES SHALL BE FILLED, DISINFECTED, PRESSURE TESTED, FLUSHED, FILLED, AND AN ACCEPTABLE WATER SAMPLE OBTAINED, PRIOR TO CONNECTION TO THE LVVMD DISTRIBUTION SYSTEM.
- THE CONTRACTOR MUST OBTAIN ALL METERS TWO (2) INCHES AND SMALLER FROM LVVMD CENTRAL STORES. TELEPHONE 258-3152 OR 258-3802, TWO (2) WORKING DAYS PRIOR TO METER PICKUP.
- ANY INTERRUPTION OF SERVICE MUST BE PERFORMED IN ACCORDANCE WITH UDACS SECTION 3.14.01, AND APPROVED BY THE LVVMD INSPECTION DIVISION PRIOR TO SHUTDOWN. PROPER WRITTEN NOTIFICATION MUST BE GIVEN TO ALL AFFECTED CUSTOMERS.
- ALL WATER FACILITY CONSTRUCTION MATERIALS USED MUST BE LISTED ON THE LVVMD PRE-APPROVED MATERIALS AND MANUFACTURER'S LISTING FOR NEW FACILITIES, LATEST REVISION, OR SPECIFICALLY APPROVED ON THESE PLANS.
- TELEPHONE "CALL BEFORE YOU DIG" AT "811" OR 1-800-227-2600.
- THE INSTALLATION OF LAS VEGAS VALLEY WATER DISTRICT (LVVMD) MUNICIPAL WATER FACILITIES WITHIN ALL STREETS IS ASSUMED TO BE IN COMPLIANCE WITH THE UNIFORM STANDARDS, INCLUDING THE PLACEMENT OF ASPHALT PAVING STREET SURFACES. ANY REPAIR WORK DONE BY THE LVVMD TO THE MUNICIPAL WATER FACILITIES WILL INCLUDE THE REPAIR OF AN APPROPRIATELY SIZED ASPHALT REPAIR PATCH ON THE STREET SURFACE. ANY DECORATIVE PAVING SURFACE WITHIN THE STREET IS THE RESPONSIBILITY OF THE OWNER'S ASSOCIATION, OR THE INDIVIDUAL PROPERTY OWNERS IF NO OWNER'S ASSOCIATION IS IN EXISTENCE, OR THE AGENCY HAVING JURISDICTION DECORATIVE SURFACE MATERIALS PLACED WITHIN THE TEN FOOT EASEMENT ADJACENT A PUBLIC OF PRIVATE STREET, IF DISTURBED BY THE CONSTRUCTION OF THE WATER FACILITY OR OPERATION OF ITS FACILITIES, WILL BE REPLACED BY LVVMD WITH AN APPROPRIATELY SIZED PLAIN FINISH CONCRETE PATCH. THE LVVMD WILL NOT RESTORE, AND WILL NOT BE RESPONSIBLE FOR THE RESTORATION OF ANY DECORATIVE PAVING SURFACE WITH THE STREET. THE LVVMD WILL NOT ATTEMPT TO MATCH COLOR OR FINISH OF ANY ADJACENT MATERIALS.
- NO LEAD COMPLIANCE NOTE.
TO COMPLY WITH THE FEDERAL SAFE DRINKING WATER ACT, ALL LEAD WORKS BRASS PRODUCTS PROPOSED TO BE RELOCATED, OR INSTALLED AS NEW, MUST BE INSTALLED WITH THE LEAD FREE APPROVED PRODUCT. THE OLD LEADED PRODUCT MAY NOT BE REUSED.

1. ALL WORK SHALL BE DONE IN STRICT ACCORDANCE WITH THE LAS VEGAS FIRE AND RESCUE ADOPTED FIRE CODE ORDINANCE # 6325 FOR HYDRANT SPECIFICATIONS AND HYDRANT INSTALLATION SPECIFICATIONS.
2. ONLY FIRE HYDRANTS THAT ARE ON THE LAS VEGAS VALLEY WATER DISTRICT'S APPROVED PRODUCTS LIST ARE ALLOWED TO BE INSTALLED.
3. A PERMIT IS REQUIRED FROM LAS VEGAS FIRE AND RESCUE FOR THE INSTALLATION OF ON-SITE WATER LINES AND FIRE HYDRANTS. THE PERMIT AND CONTRACTORS MATERIAL TEST CERTIFICATE FOR UNDERGROUND PIPING FORM SHALL BE OBTAINED FROM THE FIRE PROTECTION ENGINEER BEFORE COMMENCEMENT OF WORK. [FC § 105.7.12]
4. ON ANY RESIDENTIAL OR COMMERCIAL INSTALLATIONS, FIRE HYDRANTS SHALL BE INSTALLED AND FIRE APPARATUS ACCESS ROADS SHALL BE MAINTAINED BEFORE COMMENCEMENT OF ANY COMBUSTIBLE CONSTRUCTION. ALL FIRE HYDRANTS SHALL BE IN GOOD WORKING ORDER AND SHALL BE CAPABLE OF DELIVERING THE REQUIRED FIRE FLOW. [FC § 3310, § 3312]
5. TO IDENTIFY THE FIRE HYDRANT LOCATIONS, THE CONTRACTOR SHALL PLACE A BLUE REFLECTIVE MARKER AT THE CENTER LINE OF THE STREET ADJACENT TO THE FIRE HYDRANTS. [FC § 507.5.7.3]
6. ALL UNDERGROUND INSPECTIONS, PRESSURE AND FLUSH VERIFICATIONS OF ALL FIRE HYDRANTS AND FIRE LINES, SHALL BE CONDUCTED BEFORE COVERING THE LINES. CENTER LOADING IS ACCEPTABLE FOR THE HYDRO TESTS WITH PRIOR FIRE PREVENTION APPROVAL. [FC § 106.3]
7. ALL ON-SITE UNDERGROUND WATER MAINS AND MATERIALS SHALL BE U.S. LISTED, A.W.W.A. APPROVED AND SHALL BE RATED FOR THE APPROPRIATE WORKING PRESSURE. [FC § 507.2.1, NFPA 24]
8. PAINTING OF CURBS, FIRE HYDRANTS, PADS, PROTECTION OF FIRE HYDRANTS FROM PHYSICAL DAMAGE, AND ALL OTHER WORK NECESSARY PER PLANS SHALL BE COMPLETED BEFORE APPROVAL BY LAS VEGAS FIRE AND RESCUE, FIRE PREVENTION DIVISION. [FC § 507]
9. PRIVATE HYDRANTS SHALL BE PAINTED RED. [FC § 507.5.7.1]
10. PRIOR TO THE FINAL OCCUPANCY, A FIRE FLOW TEST SHALL BE WITNESSED BY LAS VEGAS FIRE AND RESCUE, FIRE PREVENTION DIVISION TO VERIFY AVAILABILITY OF THE REQUIRED FIRE FLOW. [FC § 507]
11. FIRE HYDRANT SPACING SHALL BE AS FOLLOWS: [FC § C102]
 - RESIDENTIAL - 500 FT UNSPRINKLERED; 600 FT SPRINKLERED.
 - COMMERCIAL - 300 FT UNSPRINKLERED; 400 FT SPRINKLERED.

1. ALL CONSTRUCTION SIGNING, BARRICADING, AND TRAFFIC DELINEATION SHALL CONFORM TO THE "MANUAL OF UNIFORM TRAFFIC CONTROL DEVICES", LATEST EDITION.
2. THE STREET SIGN CONTRACTOR SHALL OBTAIN STREET NAMES AND BLOCK NUMBERING FROM THE PLANNING DEPARTMENT PRIOR TO CONSTRUCTION.
3. BEFORE ANY WORK IS STARTED IN THE RIGHT-OF-WAY, THE CONTRACTOR SHALL INSTALL ALL ADVANCE WARNING SIGNS FOR THE CONSTRUCTION ZONE. THE CONTRACTOR SHALL INSTALL TEMPORARY STOP SIGNS AT ALL NEW STREET ENCROACHMENTS INTO EXISTING CITY STREETS WHERE WARRANTED IMMEDIATELY AFTER FIRST GRADING WORK IS ACCOMPLISHED, AND SHALL MAINTAIN SAID SIGNS UNTIL PERMANENT SIGNS ARE INSTALLED.
4. WHEN A DESIGNATED "SUGGESTED ROUTE TO SCHOOL" IS ENCROACHED UPON BY A CONSTRUCTION WORK ZONE AND PUBLIC WORKS STAFF IDENTIFIES A NEED FOR STUDENTS TO BE ASSIGNED IN THE SAFE CROSSING THROUGH THE CONSTRUCTION WORK ZONE, THE CONTRACTOR SHALL BE REQUIRED TO PROVIDE A QUALIFIED "CROSSING GUARD". THE GUARD SHALL BE PRESENT FOR THE FULL DURATION OF TIME THAT CHILDREN ARE LIKELY TO BE PRESENT.
5. IF THE IMPROVEMENTS NECESSITATE THE OBLITERATION, TEMPORARY OBSTRUCTION, TEMPORARY REMOVAL OR RELOCATION OF ANY EXISTING TRAFFIC PAVEMENT MARKING, SUCH PAVEMENT MARKING SHALL BE RESTORED OR REPLACED WITH LIKE MATERIALS TO THE SATISFACTION OF THE CITY TRAFFIC ENGINEER.
6. THE CONTRACTOR SHALL BE RESPONSIBLE FOR PROVIDING AND INSTALLING ALL PERMANENT SIGNS SHOWN ON THE PLANS. ALL NEW TRAFFIC SIGNS SHALL BE FABRICATED WITH DIAMOND GRADE PIV CLASS 6 REFRACTIVE SHEET METAL. THERE SHALL BE NO TRAFFIC SIGNS EXCEPT STOP SIGNS, SPEED LIMIT AND SCHOOL SPEED LIMIT SIGNS. SHALL HAVE 3M SERIES 1160 OR APPROVED EQUIVALENT ANTI-GRAFFITI PROTECTIVE OVERLAY FILM; SCHOOL ZONE SIGNS SHALL HAVE 3M SERIES 1150 ANTI-GRAFFITI PROTECTIVE OVERLAY FILM. STREET NAME SIGNS SHALL CONFORM IN THEIR ENTIRETY TO CURRENT CITY STANDARDS. ALL OTHER TRAFFIC SIGNS SHALL BE STANDARD SIZE UNLESS OTHERWISE SPECIFIED ON THE PLANS. ALL SIGN POSTS SHALL BE INSTALLED IN ACCORDANCE WITH THE CURRENT CITY STANDARDS.

1. ALL CONSTRUCTION AND MATERIALS SHALL BE IN ACCORDANCE WITH THE "UNIFORM STANDARD SPECIFICATIONS FOR PUBLIC WORKS CONSTRUCTION OFF-SITE IMPROVEMENTS, CLARK COUNTY AREA NEVADA", LATEST EDITION; THE "UNIFORM STANDARD DRAWINGS FOR PUBLIC WORKS CONSTRUCTION, CLARK COUNTY AREA NEVADA", LATEST REVISED EDITION; THE "SUMMERLIN IMPROVEMENT STANDARDS" FOR WORK IN THE SUMMERLIN AREA; AND OTHER APPLICABLE APPROVED STANDARDS ISSUED BY THE CONTROLLING AGENCY, THE UNIFORM BUILDING CODE; AND ALL LOCAL CITY CODES AND ORDINANCES APPLICABLE, EXCEPT AS NOTED ON THIS SHEET AS "DEVIATIONS FROM STANDARDS".
2. THE EXISTENCE AND LOCATION OF ANY OVERHEAD OR UNDERGROUND UTILITY LINES, PIPES, OR STRUCTURES SHOWN ON THESE PLANS ARE OBTAINED BY A RESEARCH OF THE AVAILABLE RECORDS. EXISTING UTILITIES AS SHOWN FROM CLV PLANS LIBRARY ARE APPROXIMATE AND FOR RECORD PURPOSES. EXISTING UTILITIES ARE LOCATED ON PLANS ONLY FOR THE CONVENIENCE OF THE CONTRACTOR. EXISTING UTILITY SERVICE LATERALS MAY NOT BE SHOWN ON THE PLANS. THE CONTRACTOR SHALL, AT HIS OWN EXPENSE, LOCATE ALL UNDERGROUND AND OVERHEAD INTERFERENCES WHICH MAY AFFECT HIS OPERATION DURING CONSTRUCTION AND SHALL TAKE ALL NECESSARY PRECAUTIONS TO AVOID DAMAGE TO SAME. THE CONTRACTOR SHALL USE EXTREME CAUTION WHEN WORKING ON OVERHEAD UTILITIES AND SHALL TAKE ALL NECESSARY PRECAUTIONS TO PROTECT ALL PERSONNEL AND EQUIPMENT, AND SHALL BE RESPONSIBLE FOR ALL COST AND LIABILITY IN CONNECTION THEREWITH.
3. THE CONTRACTOR SHALL TAKE ALL PRECAUTIONARY MEASURES NECESSARY TO PROTECT EXISTING UTILITY LINES, STRUCTURES AND STREET IMPROVEMENTS WHICH ARE TO REMAIN IN PLACE, FROM DAMAGE, AND ALL SUCH IMPROVEMENTS OR STRUCTURES DAMAGED BY THE CONTRACTOR'S OPERATIONS SHALL BE REPAIRED OR REPLACED SATISFACTORY TO THE CITY ENGINEER AND OWNING UTILITY COMPANY AT THE EXPENSE OF THE CONTRACTOR.
4. ALL CONSTRUCTION SHALL AS BE SHOWN ON THESE PLANS, ANY REVISIONS SHALL HAVE THE PRIOR WRITTEN APPROVAL OF THE CITY ENGINEER.
5. TYPE V CEMENT SHALL BE USED IN ALL OFF-SITE CONCRETE WORK. CONCRETE TO BE 3000 P.S.I. MINIMUM @ 28 DAYS. MIX DESIGNS TO BE APPROVED BY THE CITY, PRIOR TO THE USE ON THE PROJECT.
6. PERMITS ARE REQUIRED FOR ANY WORK IN THE PUBLIC RIGHT-OF-WAY. THE CONTRACTOR SHALL SECURE ALL PERMITS AND INSPECTIONS REQUIRED FOR THIS CONSTRUCTION.
7. EXPANSION JOINTS REQUIRED, MAXIMUM EVERY 300' IN EXTRUDED-TYPE CURB.
8. AC PAVEMENT TO BE ONE-HALF INCH (1/2") ABOVE UP OF ALL GUTTERS AFTER COMPACTION, EXCEPT AT SIDEWALK RAMPS AND CROSS GUTTERS.
9. CURB AND GUTTER FOUND TO BE UNACCEPTABLE TO THE CITY OF LAS VEGAS SHALL BE REMOVED AND REPLACED PER STANDARD DRAWING 216.
10. SIDEWALK RAMPS SHALL BE CONSTRUCTED IN EACH QUADRANT OF AN INTERSECTION PER STANDARD DRAWING 235. EXACT LOCATION OF RAMPS MAY BE ADJUSTED IN THE FIELD BY A CITY INSPECTOR.
11. CONTRACTOR SHALL PROVIDE ALL NECESSARY HORIZONTAL AND VERTICAL TRANSITIONS BETWEEN NEW CONSTRUCTION AND EXISTING STRUCTURES TO PROVIDE FOR PROPER DRAINAGE AND FOR INGRESS AND EGRESS TO NEW CONSTRUCTION. THE EXTENT OF THE

4. ALL STREET LIGHTING INSTALLATIONS SHALL BE IN ACCORDANCE WITH THE STREET LIGHTING PLANS, THE "UNIFORM STANDARD SPECIFICATIONS FOR PUBLIC WORKS CONSTRUCTION OFF-SITE IMPROVEMENTS, CLARK COUNTY AREA, NEVADA", LATEST REVISION, AND THE "UNIFORM STANDARD DRAWINGS FOR PUBLIC WORKS CONSTRUCTION OFF-SITE IMPROVEMENTS, CLARK COUNTY AREA, NEVADA", LATEST REVISION, AND ANY ADOPTED SPECIAL AREA STANDARDS.
5. NO DEVIATION OF STREET LIGHT, PULL BOX, CONDUITS (E/C) LOCATIONS SHALL BE PERMITTED WITHOUT WRITTEN APPROVAL OF TRAFFIC ENGINEERING AND THE CITY ENGINEER.
6. ALL EXISTING STREET LIGHTING SHALL REMAIN OPERATIONAL DURING CONSTRUCTION.
7. ALL STREET LIGHTING CONDUITS STUD SHALL HAVE AT LEAST ONE GREEN #8 THW WIRE INSTALLED, AS TRACER WIRE. WHEN TEMPTU CONDUITS ARE COMPLETELY INSTALLED, THE THW SHALL HAVE MINIMUM OF 2 MINIMUM INCHES THW WIRE. WHEN ENDS STOPPED OR SAFE OFF PRIOR TO FINAL CONNECTION.
8. ANY STRUCTURE SUCH AS BLOCK WALLS, CHAIN LINK FENCES, RETAINING WALLS, ETC., SHALL LEAVE A MINIMUM CLEARANCE IN ACCORDANCE WITH THE USD NO. 320A.
9. AS-BUILT DRAWINGS SHALL BE SUPPLIED TO THE TEF0 PRIOR TO ANY PRE-FINAL INSPECTION. THE AS-BUILT DRAWING NEEDS TO BE STAMPED AS-BUILT AND SIGNED BY THE PREPARER.
10. THE SERVICE POINT SHALL BE COORDINATED WITH NV ENERGY COMPANY, AND WHEREVER POSSIBLE, BE LOCATED NEAR THE CITY OF LAS VEGAS TO ACQUIRE SERVICE POINT FROM THE CITY OF LAS VEGAS.
11. IT SHALL BE ASSUMED THAT IN THE ABSENCE OF AN EXISTING WORKABLE CIRCUIT TO ATTACH TO, ALL INSTALLATIONS SHALL REQUIRE A NEW SERVICE FOR OPERATION OF THE CIRCUIT.
12. WHEREVER THERE IS AN OVERHEAD UTILITY THAT MAY CONFLICT WITH THE INSTALLATION OF STREET LIGHTING CIRCUITS AND/OR POLES, THESE CONFLICTS MUST BE RESOLVED BETWEEN THE DEVELOPER AND THE UTILITIES COMPANY AT NO CHARGE TO THE CITY OF LAS VEGAS, BEFORE STREET LIGHT BASIS ARE INSTALLED.
13. THE CONTRACTOR SHALL FURNISH COMPLETE SET OF SERVICE TRANSFORMERS AND CONTROL SYSTEMS IF REQUIRED ON PLANS.
14. THE DEVELOPER/OWNER WILL BE REQUIRED TO SUPPLY POWER TO ALL NEW PUBLIC STREET LIGHTS INSTALLED UNDER THIS DESIGN PRIOR TO BOND RELEASE OR PROJECT COMPLETION. THE DEVELOPER/OWNER WILL BE RESPONSIBLE FOR ALL ITEMS ASSOCIATED WITH THE INSTALLATION, CONSTRUCTION, ENERGIZING, MAINTENANCE AND OPERATIONAL COSTS OF THE STREET LIGHTS. THE DEVELOPER/OWNER SHALL BE REQUIRED TO PLAN FOR ALL NEW SERVICE REQUIREMENTS. THE TRANSFER OF OWNERSHIP FROM THE DEVELOPER/OWNER TO THE CITY OF LAS VEGAS FOR ALL NEW PUBLIC STREET LIGHTS/ AND/OR SERVICE/S INSTALLED UNDER THIS PLAN DESIGN SHALL BE COMPLETED PRIOR TO THE PROJECT COMPLETION. ALL MAINTENANCE AND OPERATIONAL TRANSFERS WITH THE CITY OF LAS VEGAS TRAFFIC ENGINEERING DEPARTMENT (TEF0) AT (702) 229-6331.

NY ENERGY, CENTRAL TELEPHONE CO, DBA CENTURY LINK TELEPHONE, AND SOUTHWEST GAS SHOWN FOR INFORMATIONAL PURPOSES ONLY. REFERENCE NV ENERGY, CENTRAL TELEPHONE CO, DBA CENTURY LINK TELEPHONE, AND SOUTHWEST GAS DRAWINGS FOR CONSTRUCTION DETAILS. CONTRACTOR TO COORDINATE WITH UTILITIES FOR REMOVAL, INSTALLATION, OR RELOCATION OF FACILITIES.

ALL EXISTING UTILITY LOCATIONS SHOWN HEREON ARE APPROXIMATE ONLY. IT SHALL BE THE CONTRACTORS RESPONSIBILITY TO DETERMINE THE VERTICAL AND HORIZONTAL LOCATION OF ALL EXISTING UTILITIES. UNDERGROUND UTILITIES PRIOR TO COMMENCING CONSTRUCTION. NO REPRESENTATION IS MADE THAT ALL UTILITIES ARE SHOWN HEREON. THE ENGINEER ASSUMES NO RESPONSIBILITY FOR UTILITIES NOT SHOWN IN THEIR OWNERS RECORDS. THE CONTRACTOR SHALL BE RESPONSIBLE FOR VERIFYING THE LOCATION OF ALL UTILITIES THROUGHOUT THE PROJECT AREA. THE CONTRACTOR SHALL EXERCISE EXTREME CARE WHERE EXCAVATING AND GRADING THE SUBBASE IN THE VICINITY OF UTILITIES TO AVOID DAMAGE TO THE LATTER.

ALL EXISTING UTILITIES SHALL BE PROTECTED IN PLACE UNLESS OTHERWISE NOTED.

**E CANYON PHASE 3BC
SHAUMBER ROAD
GENERAL NOTES**

[illegible]

SHEET 2 OF 36

A:\017002-000 SKYE CANYON PHASE 3B 3B 3\DWG\IMPROV-3B-1\DWG\1609-000-00-00.DWG 9/8/2018 3:58 PM Ben Rivers

ABBREVIATIONS			
ABUT	ABUTMENT	GND	GROUND
AC	ALUMINUM CAP/ASPHALTIC CONCRETE	H	HEIGHT
AEP	AUTHORIZATION TO ENTER PROPERTY	HGL	HYDRAULIC GRADE LINE
AP	ANGLE POINT	HORIZ	HORIZONTAL
APN	ASSESSORS PARCEL NUMBER	HWY	HIGHWAY
AVE	AVENUE	INV	INVERT
BC	BEGIN CURVE/BRASS CAP/BACK OF CURB	ITS	INTELLIGENT TRANSPORTATION SYSTEM
BCR	BEGIN CURB RETURN	JT	JOINT
BLVD	BOULEVARD	LF	LINEAR (LINEAL) FEET
BM	BENCHMARK	LIP	LIP OF GUTTER
BOT	BOTTOM	LT	LEFT
BRG	BEARING	LUM	LUMINAIRE
BSW	BACK OF SIDEWALK	LWWD	LAS VEGAS VALLEY WATER DISTRICT
BVCE	BEGIN VERTICAL CURVE ELEVATION	MAX	MAXIMUM
BVCS	BEGIN VERTICAL CURVE STATION	MH	MANHOLE
CATV	UNDERGROUND CABLE TV	MIN	MINIMUM
CG	CURB AND GUTTER	MLCP	MULTI-LAYERED COMPOSITE PIPE
CCSD	DESIGN AND CONSTRUCTION STANDARDS FOR WASTEWATER COLLECTION SYSTEMS	MOD	MODIFY/MODIFIED
CKT	CIRCUIT	MON	MONUMENT
CLR	CLEAR/CLEARANCE	MPH	MILES PER HOUR
CLBM	CITY OF LAS VEGAS BENCHMARK	N	NORTH
CLV	CITY OF LAS VEGAS	NDOT	NEVADA DEPARTMENT OF TRANSPORTATION
CMU	CONCRETE MASONRY UNIT	NVE	NV ENERGY
CONC	CONCRETE	NTS	NOT TO SCALE
C/L	CENTERLINE	OC	ON CENTER
COB	CENTER OF BOLLARD	OHP	OVERHEAD POWER LINE
COL	COLUMN	PAT	PATENT
CONST	CONSTRUCT/CONSTRUCTION	PB	PULL BOX
COORD	COORDINATE	PB	PLANTMIX BITUMINOUS SURFACE
COR	CORNER	PC	POINT OF CURVE, PHOTO CELL
CY	CUBIC YARD(S)	PCC	POINT OF COMPOUND CURVE
Δ	DELTA	PD	PONDING DEPTH
DB	DIRECT BURY	PE	PROJECT ENGINEER/POLYETHYLENE
DBL	DOUBLE	PED	PEDESTRIAN
DI	DROP INLET	PG	PROFILE GRADE (FO ON CONTROL LINE)
DIA	DIAMETER	PGL	PROFILE GRADE LINE
DIST	DISTANCE	PH	POTHOLE
DR	DRIVE	PI	POINT OF INTERSECTION
DW	DRIVEWAY	PKWY	PARKWAY
DWG	DRAWING	PL	PROPERTY LINE
ECR	END CURB RETURN	PLM	PAVEMENT MARKING FILM
E	EAST	PGB	POINT OF BEGINNING
EA	EACH	POC	POINT ON CURVE
ESMT	EASEMENT	POE	POINT OF ENDING
ECR	END CURB RETURN	POT	POINT ON TANGENT
EL	ELECTRICAL	PP	POWER POLE
ELEV/EL	ELEVATION	PPCBR	PORTABLE PRECAST CONCRETE BARRIER RAIL
EP/EOP	EDGE OF PAVEMENT	PPM	POLYUREA PAVEMENT MARKINGS
EQ	EQUAL	PR	PROPOSED
EST	ESTIMATED	PROP	PROPOSED
EVC	END VERTICAL CURVE	PRC	POINT OF REVERSE CURVE
EX/EXIST	EXISTING	PRVC	POINT REVERSE VERTICAL CURVE
EXP	EXPANSION JOINT	PSI	POUNDS PER SQUARE INCH
EW	EACH WAY	PT	POINT OF TANGENCY
FC	FACE OF CURB	PV	POINT OF VERTICAL INTERSECTION
FG	FINISH GRADE	PVMT	PAVEMENT
FH	FIRE HYDRANT	R	RADIUS
FL	FLOW LINE	RCB	REINFORCED CONCRETE BOX
FO	FIBER OPTIC	RCP	REINFORCED CONCRETE PIPE
FS	FINISH SURFACE	RD	ROAD
FT	FOOT/FEET	RWDY	ROADWAY
FTG	FOOTING	REC	RECTANGULAR
FW	FACE OF WALL	REINF	REINFORCED
FYA	FLASHING YELLOW ARROW	REQD	REQUIRED
G	GAS	RND	ROUND
GA	GAUGE	RIP	RADIUS POINT
GB	GRADE BREAK	RPM	RAISED PAVEMENT MARKERS
		R/W	RIGHT-OF-WAY
		RT	RIGHT
		S	SOUTH
		SCH	SCHEDULE
		SD	STORM DRAIN
		SDMH	STORM DRAIN MANHOLE
		SDMH	SECTION
		SF	SQUARE FOOT/FEET
		SHLDR	SHOULDER
		SHT	SHEET
		SIM	SIMILAR
		SP	SERVICE POINT
		SPA	SPACING
		SQ	SQUARE
		SS	SANITARY SEWER
		SSMH	SANITARY SEWER MANHOLE
		STA	STATION
		STD	STANDARD
		ST	STEEL
		STL	STREET LIGHT
		STRUCT	STRUCTURE
		NO	SIDEWALK
		SNBORS	SOUTHERN NEVADA BUILDING OFFICIALS
		SW	REGIONAL STANDARDS
		T	SOUTHWEST GAS
		TWG	TELEPHONE/TOP
		TAN	TANGENT
		TC	TOP OF CURB
		TEMP	TEMPORARY
		TF	TOP OF FOOTING
		TG	TOP OF GRATE
		TMH	TOP OF MANHOLE
		TRANS	TRANSITION STRUCTURE
		THW	TOP OF HEADWALL
		TRW	TOP OF RETAINING WALL
		TW	TOP OF WALL
		TS	TRAFFIC SIGNAL
		TYP	TYPICAL
		UDACS	UNIFORM DESIGN AND CONSTRUCTION STANDARDS
		USDOCA	FOR WATER DISTRIBUTION SYSTEMS
		UT	UNDERGROUND TELEPHONE
		VAR	UNIFORM STD. DRAWINGS FOR PUBLIC WORKS
		VC	CONSTRUCTION OFF-SITE IMPROVEMENTS
		VERT	CLARK COUNTY AREA, NEVADA
		VG	UNDERGROUND TELEPHONE
		W	VARIABLE/VARIES
		WY	VERTICAL CURVE
		WT	VALLEY GUTTER
		XING	WEST
			WAY
			WEIGHT
			CROSSING


ALIGNMENT ABBREVIATIONS

"ECD"	EGAN CREST DRIVE
"IMR"	(SKYE CANYON PARK DRIVE TO EAGLE CANYON DRIVE)
"SCP"	IRON MOUNTAIN ROAD
	(SKYE VILLAGE ROAD TO SHAUMBER ROAD)
"SR"	SKYE CANYON PARK DRIVE
	(SKYE VILLAGE ROAD TO SHAUMBER ROAD)
"SVR"	SHAUMBER ROAD
	(SKYE CANYON PARK DRIVE TO IRON MOUNTAIN ROAD)
	SKYE VILLAGE ROAD

LEGEND			
---	TEL 5-4"	---	EXISTING TELEPHONE CABLE
---	12" SS	---	EXISTING SANITARY SEWER LINE
---	12" W	---	EXISTING WATER LINE
---	18" SD	---	EXISTING STORM DRAIN LINE
---	ELE UG 1-4"	---	EXISTING UNDERGROUND ELECTRICAL LINE
---	OHP	---	EXISTING OVERHEAD POWER LINE
---	OHP/TEL	---	EXISTING OVERHEAD POWER AND TELEPHONE LINE
---	4" PE GAS	---	EXISTING GAS LINE
---	CATV	---	EXISTING CABLE TELEVISION LINE
---		---	EXISTING CURB & GUTTER
---		---	EXISTING RIGHT-OF-WAY LINE
---		---	EXISTING COMMON ELEMENT LINE
---	X-X-X	---	EXISTING CHAIN-LINK FENCE
---	SL	---	EXISTING STREET LIGHT CONDUIT
---		---	EXISTING MANHOLE OR VAULT
---		---	EXISTING VALVE (GAS OR WATER)
---		---	EXISTING FIRE HYDRANT
---		---	EXISTING POWER OR TELEPHONE POLE
---		---	EXISTING PADMOUNTED SERVICE PEDESTAL
---		---	EXISTING NV ENERGY TRANSFORMER
---		---	EXISTING SWING GATE
---		---	EXISTING STREET LIGHT
---		---	EXISTING ON-SITE LIGHT
---		---	STREET CENTERLINE
---		---	EASEMENT LINE
---		---	AEP
---		---	PROPOSED SIGN
---		---	CONCRETE SURFACE
---		---	PLANTMIX BITUMINOUS SURFACE
---		---	FLOWLINE
---		---	SAWCUT LINE
---		---	CONTOUR LINE
---		---	ELEVATION
---		---	FUTURE ELEVATION
---		---	STORM DRAIN MANHOLE
---		---	SANITARY SEWER MANHOLE
---		---	100 WATT STREET LIGHT
---		---	250 WATT STREET LIGHT
---		---	FAST ITS CONDUIT
---		---	FAST P30 PULLBOX
---		---	FAST TYPE 200 SPLICE VAULT

QUANTITIES		PRIVATE	PUBLIC
DRAINAGE			
DESCRIPTION			
1	DROP INLET 10' TYPE CM2	EA	-
2	DROP INLET 17.5' TYPE CM2	EA	-
3	DROP INLET 20' TYPE CM2	EA	-
4	STRUCTURAL DROP INLET	EA	-
5	60" TYPE III MANHOLE	EA	-
6	48" TYPE II MANHOLE	EA	-
7	NDOT TYPE 4 MANHOLE	EA	-
8	BEEHIVE INLET	EA	-
9	18" RCP	LF	-
10	24" RCP	LF	-
11	30" RCP	LF	-
12	36" RCP	LF	-
13	42" RCP	LF	-
14	54" RCP	LF	-
15	60" RCP	LF	-
16	72" RCP	LF	-
17	76"x48" HERCP	LF	-
18	PRECAST 6'X6' RCB	LF	-
19	PRECAST 8'X5' RCB	LF	-
20	PRECAST 8'X7' RCA	LF	-
21	PRECAST 10'X9' RCA	LF	-
22	STRUCTURAL HEADWALL	EA	-
23	NDOT TYPE II HEADWALL	EA	-
24	18" END SECTION	EA	-
25	24" END SECTION	EA	-
26	30" END SECTION	EA	-
27	36" END SECTION	EA	-
28	42" END SECTION	EA	-
29	54" END SECTION	EA	-
30	RIPRAP	CY	-
31			
SEWER SYSTEM			
1	10" SDR35 PVC SEWER PIPE	LF	-
2	8" SDR35 PVC SEWER PIPE	LF	-
3	STANDARD 48" SEWER MANHOLE	EA	-
4	8" SEWER PIPE CAP	EA	-
5			
WATER SYSTEM			
1	FIRE HYDRANT ASSEMBLY W/6" GATE VALVE PER UDACS PLATE NO. 40	EA	-
2	12" C-900 PVC WATER PIPE (CLASS 150)	LF	-
3	12" DIP WATER PIPE	LF	-
4	6" C-900 PVC WATER PIPE (CLASS 150)	LF	-
5	8" C-900 PVC WATER PIPE (CLASS 150)	LF	-
6	12" GATE VALVE WITH VALVE BOX PER UDACS PLATE NO. 30 & 39	EA	-
7	8" GATE VALVE WITH VALVE BOX PER UDACS PLATE NO. 30 & 39	EA	-
8	6" GATE VALVE WITH VALVE BOX PER UDACS PLATE NO. 30 & 39	EA	-
9	12" X 12" TEE PER UDACS PLATE NO. 31	EA	-
10	12" X 8" TEE PER UDACS PLATE NO. 31	EA	-
11	12" X 6" TEE PER UDACS PLATE NO. 31	EA	-
12	12" 11.25 DEGREE BEND PER UDACS PLATE NO. 31	EA	-
13	12" 22.5 DEGREE BEND PER UDACS PLATE NO. 31	EA	-
14	12" 45 DEGREE BEND PER UDACS PLATE NO. 31	EA	-
15	12" CAP AND 2" BLOW-OFF ASSEMBLY W/CAP PER UDACS PLATE NO. 36	EA	-
16	8" CAP AND 2" BLOW-OFF ASSEMBLY W/CAP PER UDACS PLATE NO. 36	EA	-
17			
18			
STREET IMPROVEMENTS			
1	2" A.C. PAVEMENT W/ 4" TYPE II OVER 4" TYPE I AGGREGATE BASE	SY	-
2	STANDARD 18" TYPE "L" ISLAND CURB & GUTTER W/6" TYPE I AGGREGATE BASE	LF	-
3	STANDARD 8" TYPE "A" ISLAND CURB W/6" TYPE I AGGREGATE BASE	LF	-
4	STANDARD 30" TYPE "ROLL" CURB & GUTTER W/6" TYPE I AGGREGATE BASE	LF	-
5	4" WIDE CONCRETE SIDEWALK W/4" TYPE II AGGREGATE BASE	SF	-
6	COMMON ELEMENT LANDSCAPING	SF	-
7	2" ALUMINUM CAP STAMPED MONUMENT PER CCAUSD DWG 242	EA	-
8	SIDEWALK RAMPS PER CCAUSD NO. 235	EA	-
9			
TRAFFIC SIGNALS			
1	30" STOP SIGN WITH POST (R1-1)	EA	-
2	9" STREET NAME SIGN (D-3, BROWN W/ WHITE LETTERS)(6 POLES X 2 PER POLE=12)	EA	-
3	BLUE COLORED REFLECTIVE RAISED PAVEMENT MARKER	EA	-
4	CROSSWALK MARKINGS	LF	-
5			
6			
7			
DRY UTILITIES			
1	100W H.P.S. LUMINAIRE STREET LIGHT W/DECORATIVE POLE	EA	-
2	1-1/4" PVC STREET LIGHT CONDUIT WITH (2) #4 AND (1) #8 CONDUCTORS	LF	-
3	NO. 3-1/2 PULL BOX W/METAL COVER	EA	-
4	150 AMP SERVICE PEDESTAL (IRR)	EA	-
5	200 AMP SERVICE PEDESTAL (STLT)	EA	-
6			
7			

NINETY-FIVE MANAGEMENT LLC
SKYE CANYON PHASE 3BC
SHAUMBER ROAD
ABBREVIATIONS, LEGEND, AND QUANTITIES

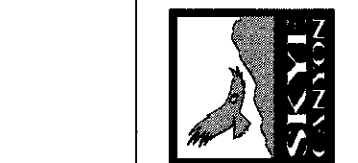

DATE: 9/8/18
DRAFTER: ##
DESIGNER: ##
CHECKED: ##
PROJECT NO.
OLY1609-000
G-03
SHEET 3 OF 36

SLATER
HANIFAN
GROUP
a Westwood team
5740 S. ARVILLE STREET #216, LAS VEGAS, NV 89118
PHONE (702) 284-5300 FAX (702) 284-5309

[illegible]

NINETY-FIVE MANAGEMENT LLC

**SKYE CANYON PHASE 3BC
SHAUMBER ROAD
ROADWAY SECTIONS**



DATE: 9/8/18


DRAFTER: HF

DESIGNER: HF

CHECKED: DY


PROJECT NO.

OLY1609-000

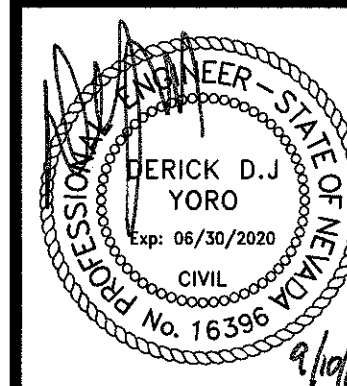


TY-01

SHEET 4 OF 36

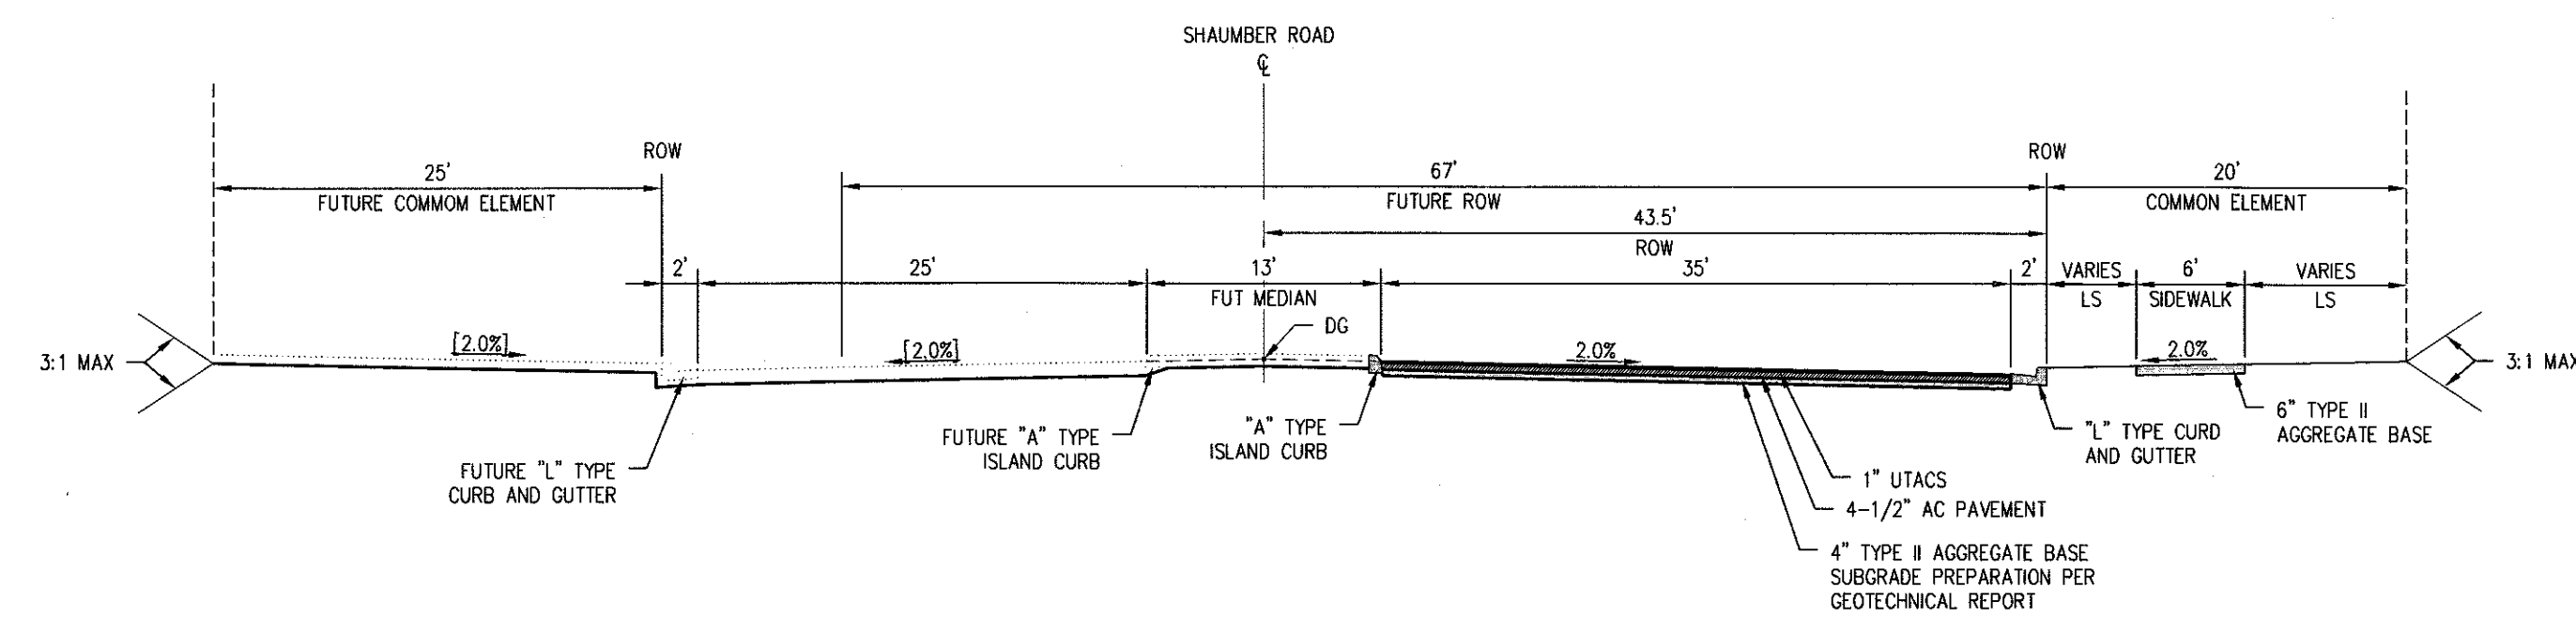


NOTE:
FINAL PAVEMENT SURFACE SHALL BE 1/2" ABOVE LIP OF GUTTER.
PAVEMENT SHALL BE FLUSH WITH LIP OF GUTTER AT SIDEWALK RAMPS.

SHAUMBER STREET (RIGHT TURN)
NOT TO SCALE

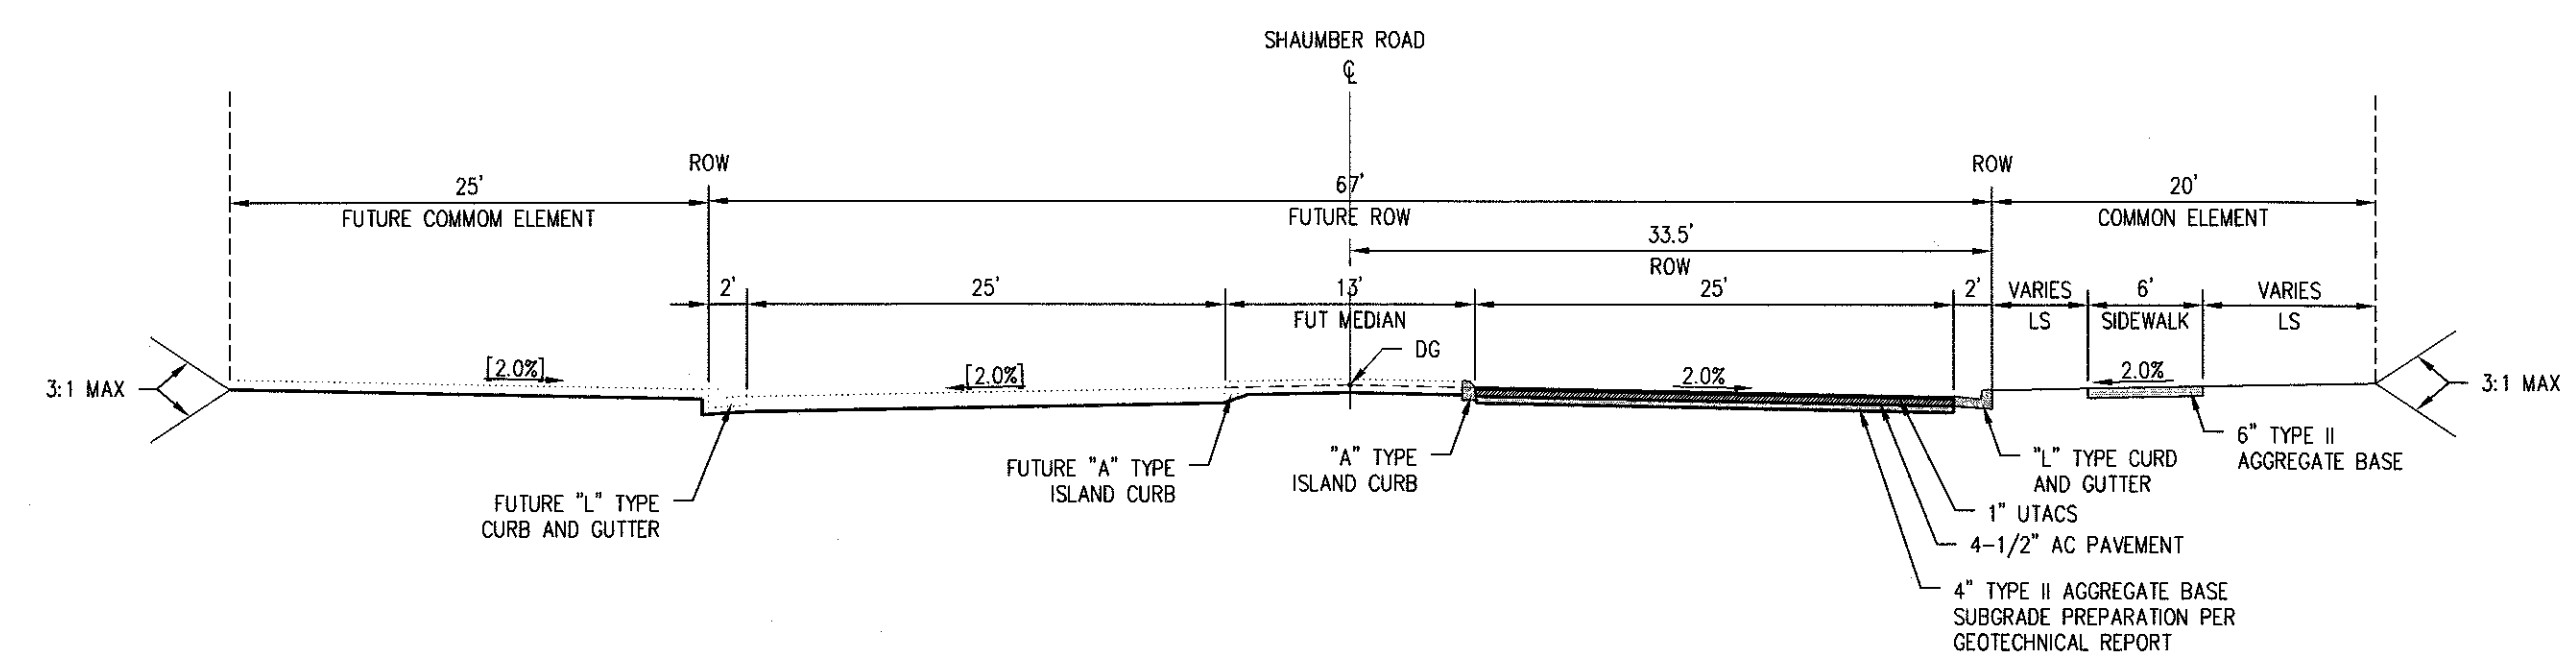


NOTE:
FINAL PAVEMENT SURFACE SHALL BE 1/2" ABOVE LIP OF GUTTER.
PAVEMENT SHALL BE FLUSH WITH LIP OF GUTTER AT SIDEWALK RAMPS.



SHAUMBER ROAD (SKYE CANYON TO IRON MOUNTAIN)
NOT TO SCALE

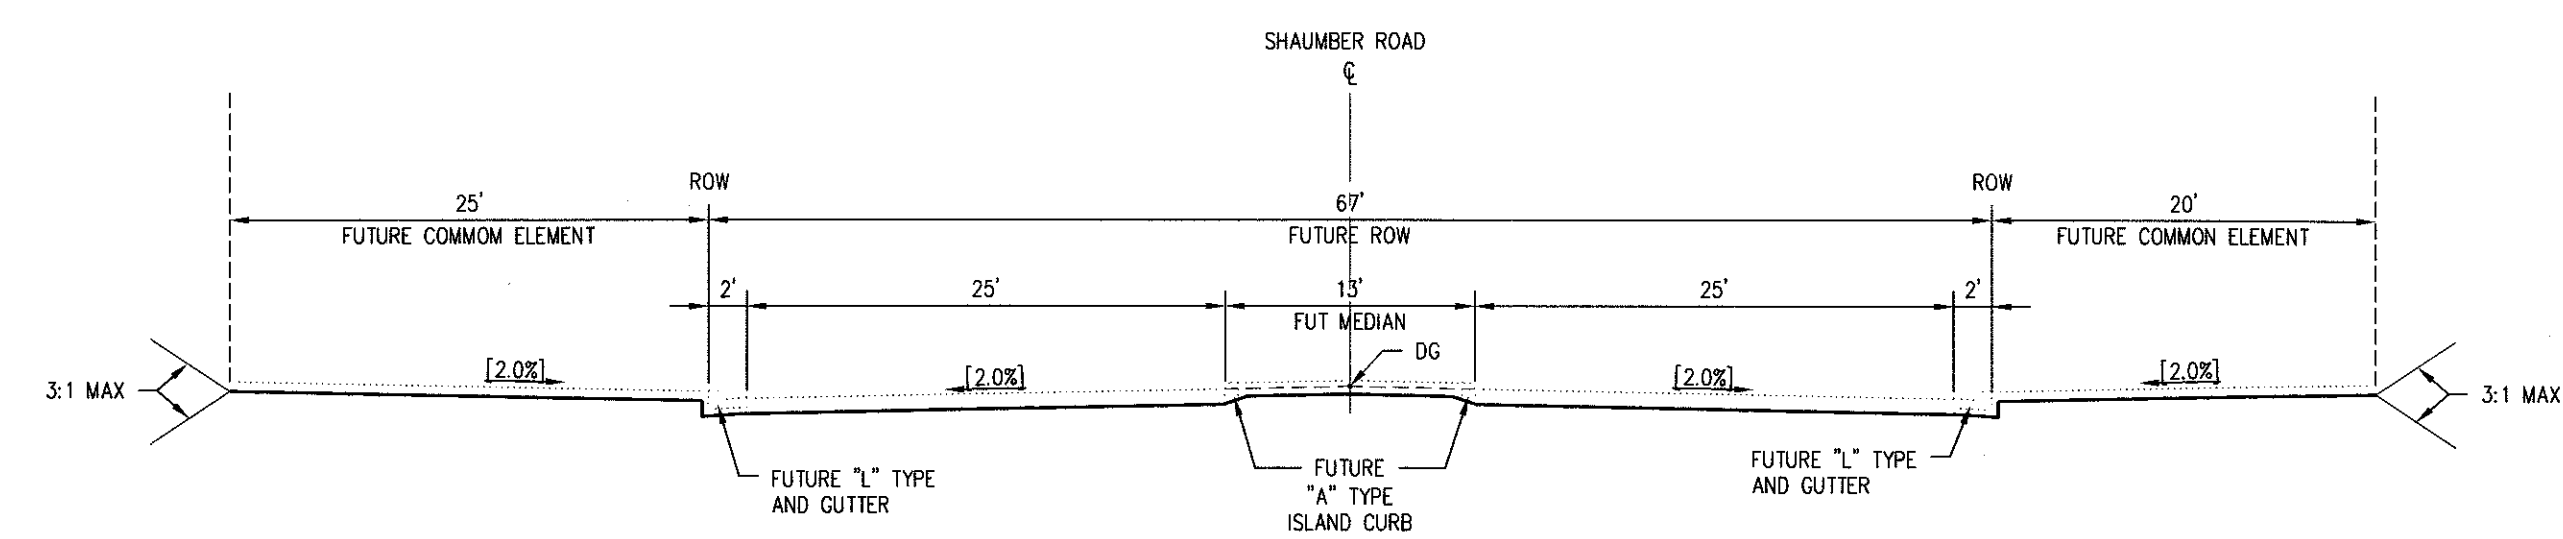

SHAUMBER ROAD (EAGLE CANYON AVENUE TO SKYE CANYON)
NOT TO SCALE

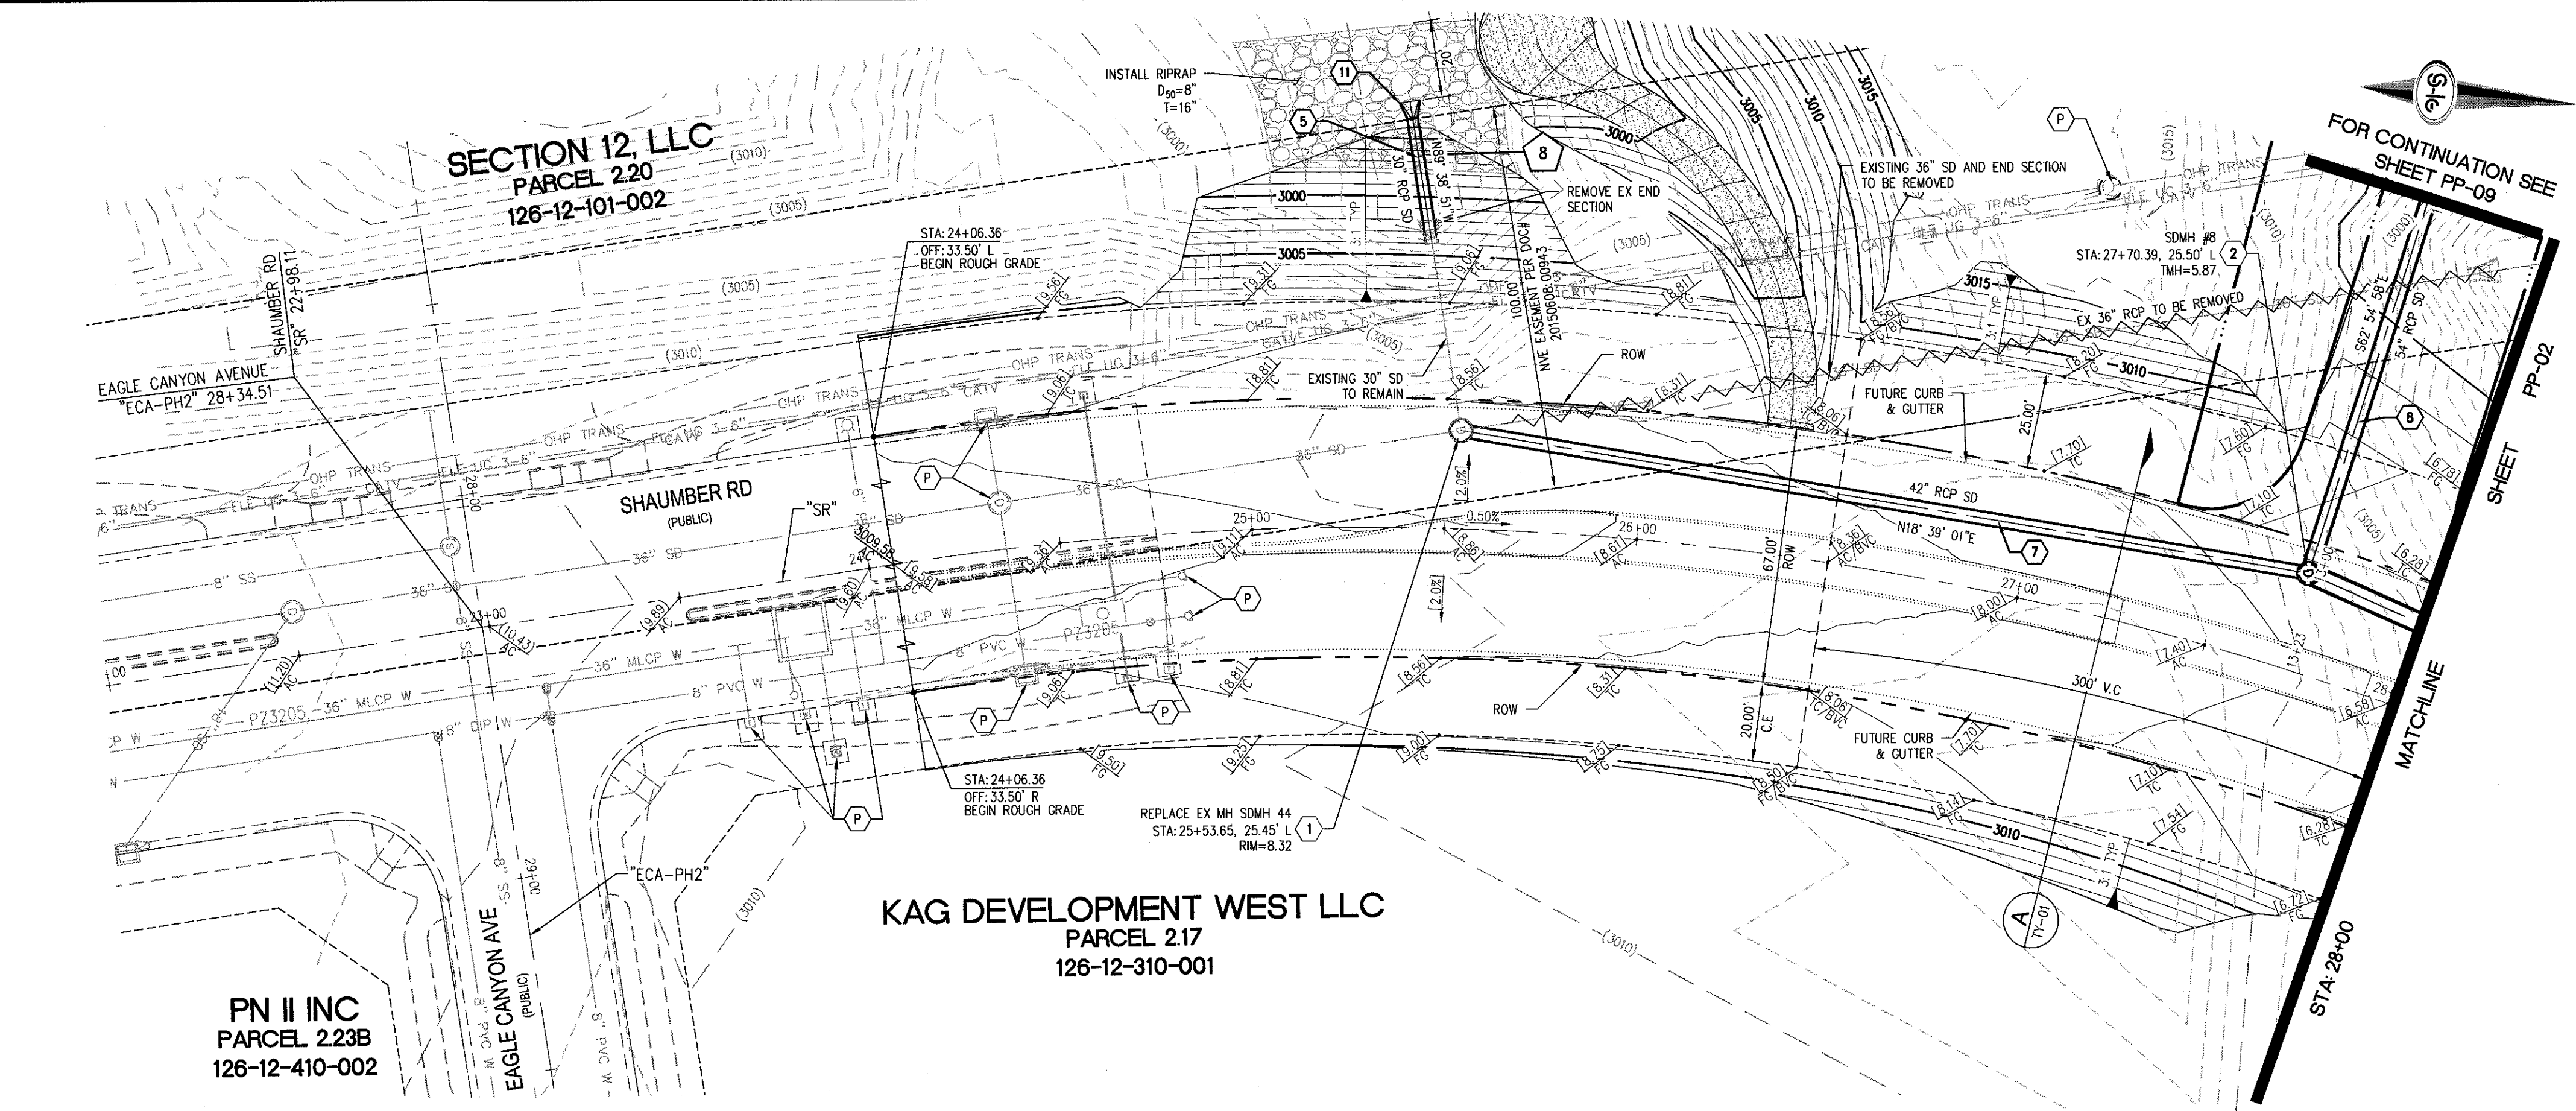

SEE SKYE CANYON PHASE 2 SHAUMBER ROAD IMPROVEMENTS PLANS (#H64088) FOR CONTINUATION

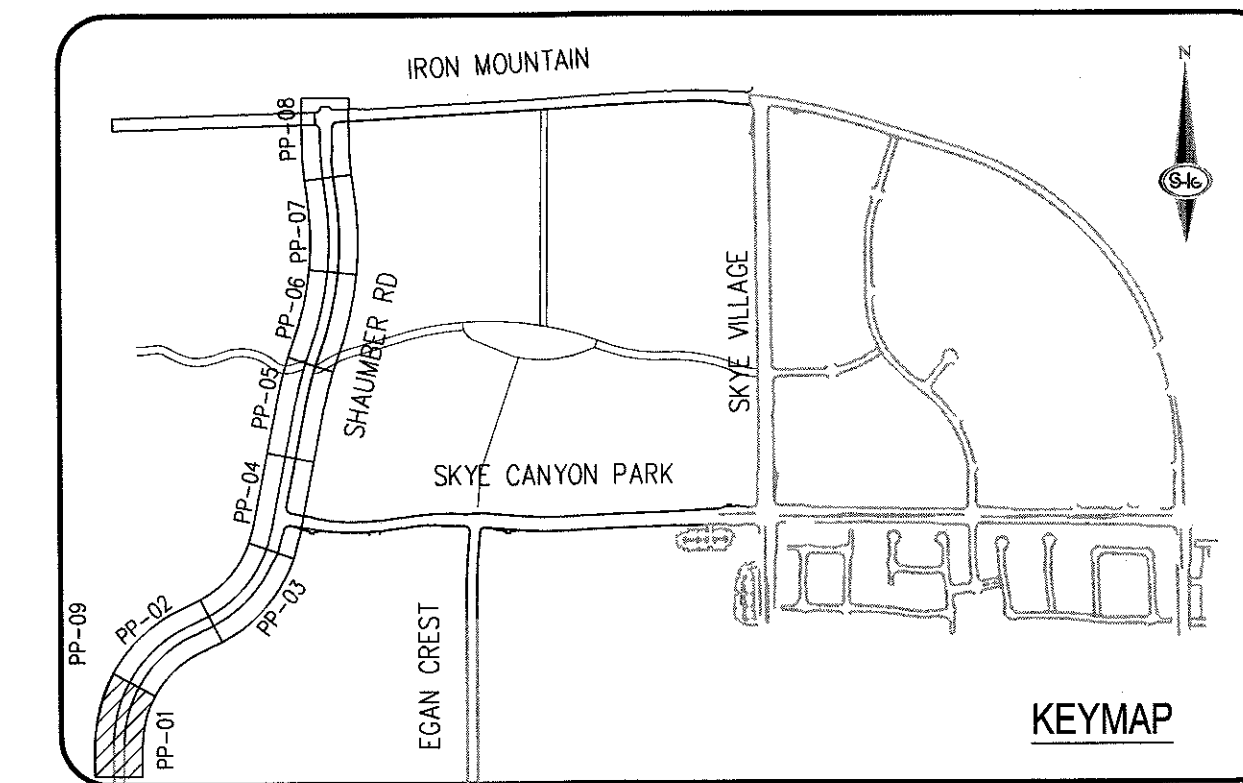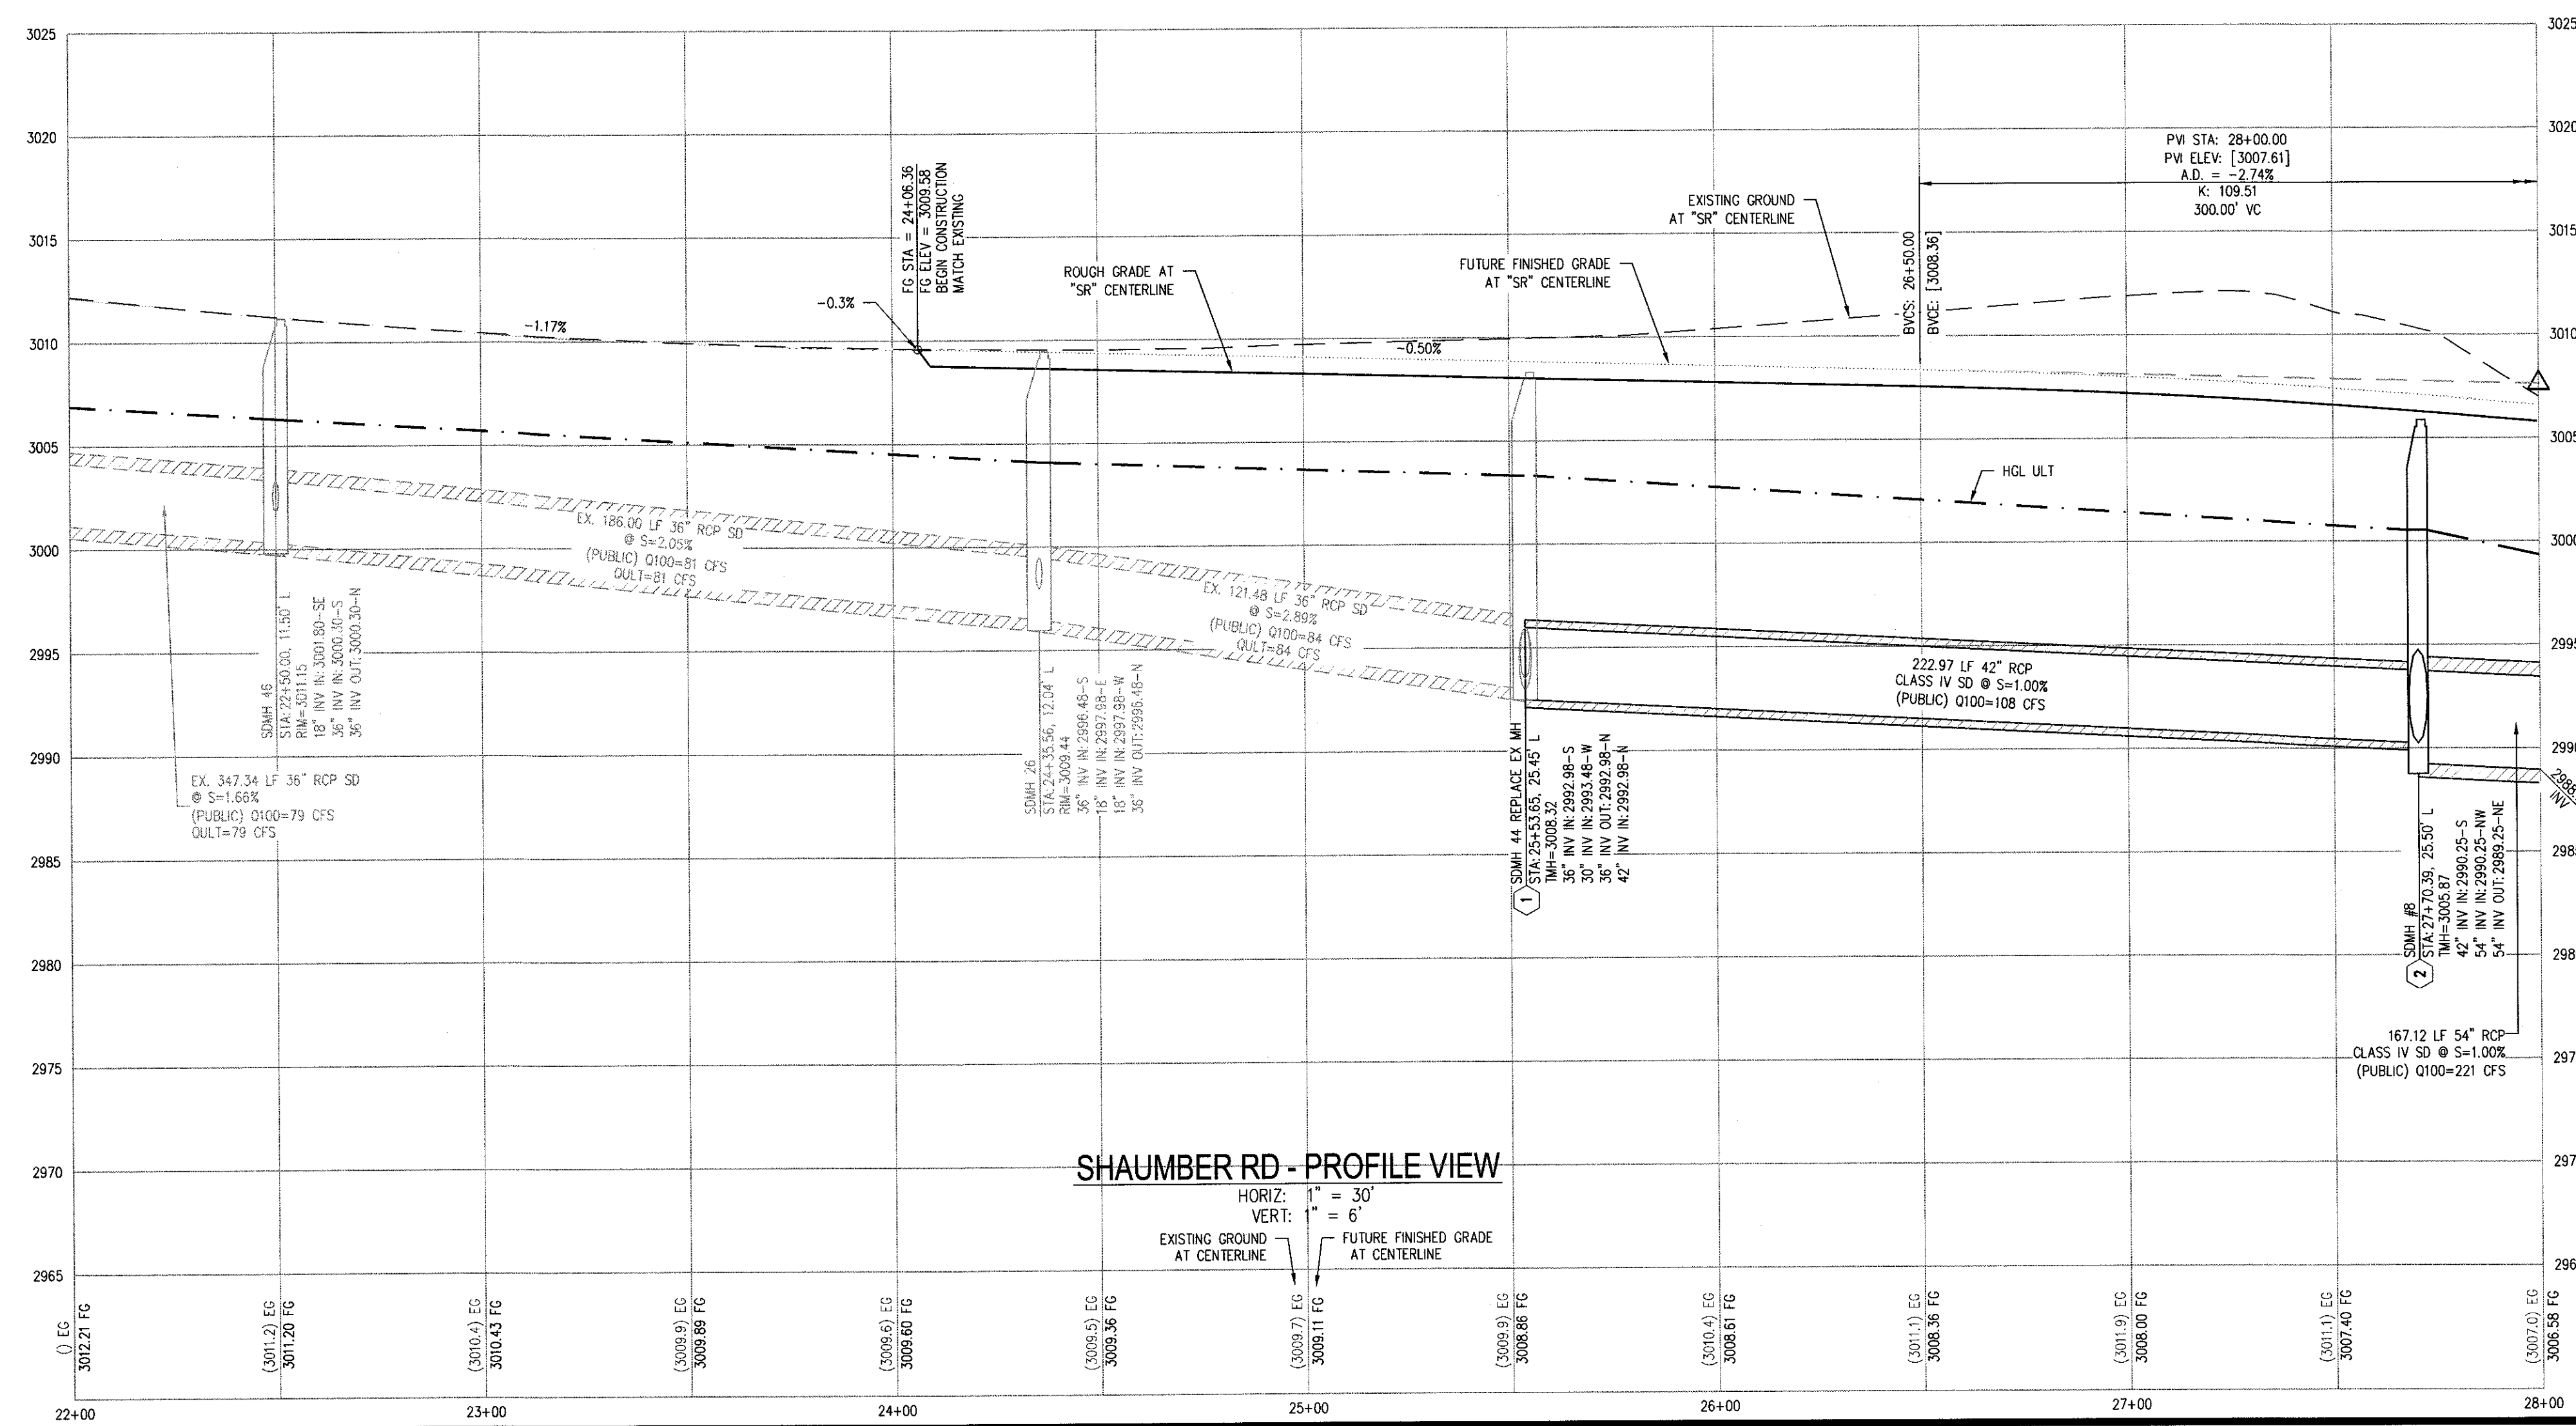

CONSTRUCTION NOTES	
1	CONSTRUCT 1" UTACS OVER 4.5" PBS OVER 4" TYPE II AGGREGATE BASE (SEE TY SHEETS)
2	CONSTRUCT 1" UTACS OVER 5.5" PBS OVER 6" TYPE II AGGREGATE BASE (SEE TY SHEETS)
3	CONSTRUCT "A" TYPE ISLAND CURB (USDOCA STD. DWG. NO. 219)
4	CONSTRUCT "L" TYPE CURB AND GUTTER (USDOCA STD. DWG. NO. 216)
5	CONSTRUCT SIDEWALK RAMP (CASE 1) WITH TACTILE WARNING PANEL (USDOCA STD. DWG. NO. 235)
6	CONSTRUCT BUS TURN-OUT (USDOCA STD. DWG. NO. 234.1)
7	CONSTRUCT CONCRETE SIDEWALK (USDOCA STD. DWG. 234)
8	PROTECT IN PLACE (VERIFY LOCATION AND ELEVATION OF EX. IMPROVEMENT)

STORM DRAIN NOTES	
1	CONSTRUCT 48" TYPE II-SD MANHOLE (USDOCA STD. DWG. NO. 405.2)
2	CONSTRUCT 60" TYPE III MANHOLE (USDOCA STD. DWG. NO. 406.1)
3	INSTALL 18" RCP (USDOCA STD. DWG. NO. 503.2)
4	INSTALL 24" RCP (USDOCA STD. DWG. NO. 503.2)
5	INSTALL 30" RCP (USDOCA STD. DWG. NO. 503.2)
6	INSTALL 36" RCP (USDOCA STD. DWG. NO. 503.2)
7	INSTALL 42" RCP (USDOCA STD. DWG. NO. 503.2)
8	INSTALL 54" RCP (USDOCA STD. DWG. NO. 503.2)
9	INSTALL 60" RCP (USDOCA STD. DWG. NO. 503.2)
10	INSTALL 72" RCP (USDOCA STD. DWG. NO. 503.2)
11	INSTALL 30" RCP END SECTION (NDOT STD. PLAN R-2.3.1)
12	INSTALL 36" RCP END SECTION (NDOT STD. PLAN R-2.3.1)
13	INSTALL 42" RCP END SECTION (NDOT STD. PLAN R-2.3.1)
14	INSTALL 72" RCP END SECTION (NDOT STD. PLAN R-2.3.1)
15	CONSTRUCT TYPE "CM2" DROP INLET. SIZE PER PLAN (USDOCA STD. DWG. NO. 412.1 & 421)
16	STRUCTURAL MANHOLE
17	CONSTRUCT CONCRETE COLLAR (SEE DETAIL 3/DTL-01)
18	CONSTRUCT INTERIOR BRICK AND MORTAR PLUG SEE DETAIL 2/DTL-01
19	INSTALL 24" RCP END SECTION (NDOT STD. PLAN R-2.3.1)
20	INSTALL 54" RCP END SECTION (NDOT STD. PLAN R-2.3.1)
21	INSTALL 66" RCP END SECTION (NDOT STD. PLAN R-2.3.1) W/1" SACRIFICIAL CONCRETE PER STRUCTURAL DWGS

NOTES

- ALL RCP SHALL BE CLASS III UNLESS OTHERWISE SHOWN.
- ALL PIPE LENGTHS ARE MEASURED ALONG PIPE CENTERLINE TO CENTER OF MANHOLE OR INSIDE EDGE OF DI OR RCP/RC.
- ALL DROP INLETS SHALL INCLUDE STORM WATER MANAGEMENT STAMP AND DETAIL PER USDOCA STD. DWG. NO. 421.
- SEE STRUCTURAL PLANS FOR ADDITIONAL STRUCTURAL DETAILS AND CONNECTIONS.
- ALL PIPES ARE PUBLICLY MAINTAINED.
- ADD SPECIAL INSPECTION REQUIRED FOR PIPE SEGMENTS WITH SACRIFICIAL CONCRETE.
- DIMENSIONS ARE TO BE BACK OF CURB, FACE OF CURB, OR FACE OF MEDIAN UNLESS OTHERWISE NOTED.
- SEE TY-SHEETS FOR TYPICAL SECTIONS.
- SEE UT-SHEETS FOR WATER AND SEWER PLAN AND PROFILES.

DROP INLET NOTE

WHERE 10 FEET PARALLEL SEPARATION IS NOT PRACTICABLE, CAST-IN-PLACE MONOLITHIC POUR WITH WATERSTOP BETWEEN SLAB AND WALLS. BASE, WALLS AND TOP TO BE CONSTRUCTED WITH WATERSTOPS, CENTER BULB, OR FLAT STRIP (WINYLEX, GREENSTREAK PLASTIC PRODUCTS OR APPROVED EQUAL).

LEGEND

X STORM DRAIN LATERAL (# (SEE LAT SHEETS))

I CERTIFY THAT THIS GRADING PLAN IS IN CONFORMANCE WITH THE APPROVED TECHNICAL DRAINAGE STUDY DS-4931 ON FILE AT THE CITY OF LAS VEGAS FOR THE SUBJECT PROJECT

DERICK D. J. YORO
DATE: 9/10/18
PROJECT NO. 126408

NOTE:

PROPERTY OWNER IS RESPONSIBLE TO MAINTAIN THE BEST MANAGEMENT PRACTICES, SUCH AS BUT NOT LIMITED TO, THE REMOVAL OF ACCUMULATED SEDIMENT AND DEBRIS AND CARE OF VEGETATION.

APPROVED FOR CONSTRUCTION

LVMED ENGINEERING SERVICES MANAGER DATE

PROJECT NO. 126408

AVOID HITTING OVERHEAD POWER LINES. IT'S DANGEROUS.

CALL BEFORE YOU DIG

1-702-227-2929

FAST

Call before you dig

UnderGround

1-702-432-5300

STREET AND UTILITY LOCATING SERVICE OF IDENTIFICATION

Call before you Dig

Call

811

1-800-227-2600

SLATER HANIFAN GROUP

a Westwood team

5740 S. ARVILLE STREET #216, LAS VEGAS, NV 89119

PHONE (702) 284-5300 FAX (702) 284-5399

NINETY-FIVE MANAGEMENT LLC

SKYE CANYON PHASE 3BC

SHAUMBER ROAD

CONSTRUCTION PLAN - "SR" 22+00 TO "SR" 28+00

DATE: 9/8/18

DRAFTER: HF

DESIGNER: HF


CHECKED: DY

PROJECT NO. OLY1609-000

DERICK D. J. YORO

PP-01

SHEET 5 OF 36

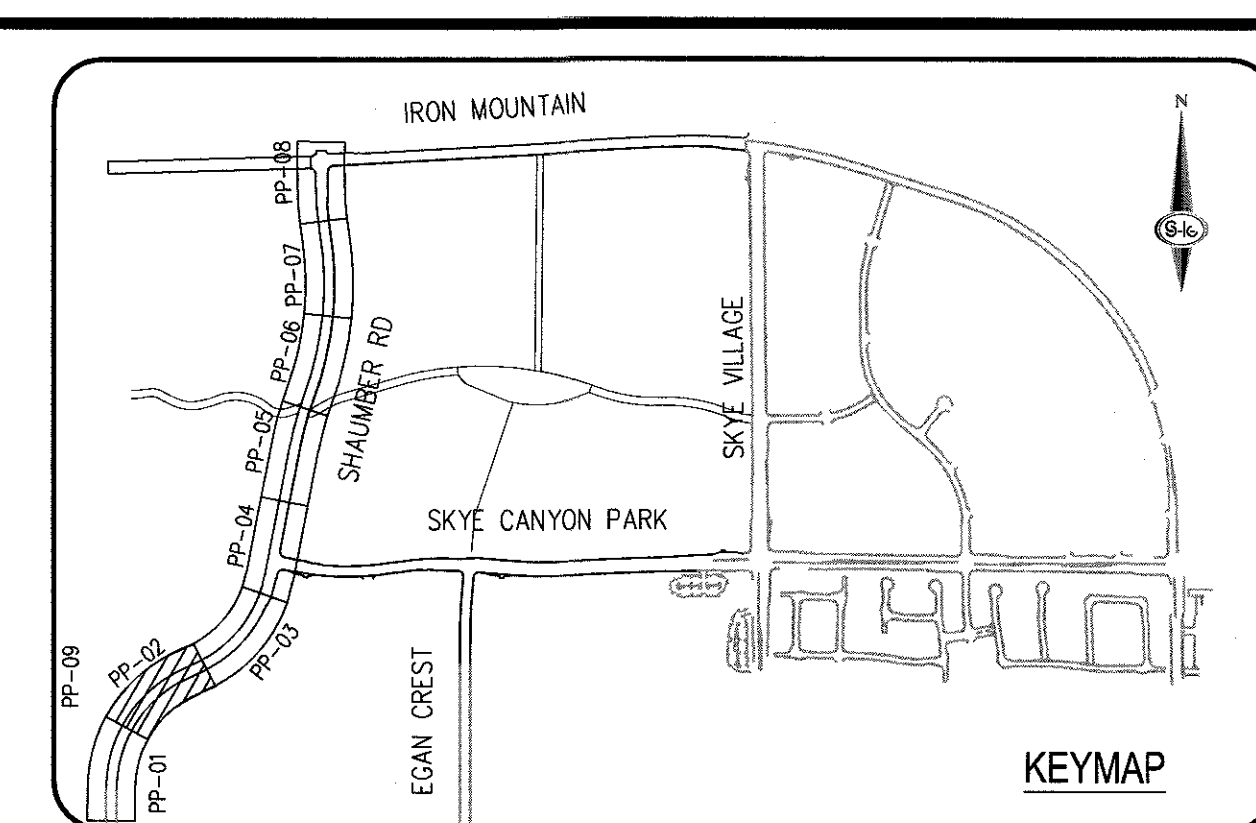

CONSTRUCTION NOTES	
1	CONSTRUCT 1" UTACS OVER 4.5" PBS OVER 4" TYPE II AGGREGATE BASE (SEE TY SHEETS)
2	CONSTRUCT 1" UTACS OVER 5.5" PBS OVER 6" TYPE II AGGREGATE BASE (SEE TY SHEETS)
3	CONSTRUCT "A" TYPE ISLAND CURB (USDCCA STD. DWG. NO. 219)
4	CONSTRUCT "L" TYPE CURB AND GUTTER (USDCCA STD. DWG. NO. 216)
5	CONSTRUCT SIDEWALK RAMP (CASE II) WITH TACTILE WARNING PANEL (USDCCA STD. DWG. NO. 235)
6	CONSTRUCT BUS TURN-OUT (USDCCA STD. DWG. NO. 234.1)
7	CONSTRUCT CONCRETE SIDEWALK (USDCCA STD. DWG. 234)
P	PROTECT IN PLACE (VERIFY LOCATION AND ELEVATION OF EX. IMPROVEMENT)

STORM DRAIN NOTES	
1	CONSTRUCT 48" TYPE II--SD MANHOLE (USDOCCA STD. DWG. NO. 405.2)
2	CONSTRUCT 60" TYPE III MANHOLE (USDOCCA STD. DWG. NO. 406.1)
3	INSTALL 18" RCP (USDOCCA STD. DWG. NO. 503.2)
4	INSTALL 24" RCP (USDOCCA STD. DWG. NO. 503.2)
5	INSTALL 30" RCP (USDOCCA STD. DWG. NO. 503.2)
6	INSTALL 36" RCP (USDOCCA STD. DWG. NO. 503.2)
7	INSTALL 42" RCP (USDOCCA STD. DWG. NO. 503.2)
8	INSTALL 54" RCP (USDOCCA STD. DWG. NO. 503.2)
9	INSTALL 60" RCP (USDOCCA STD. DWG. NO. 503.2)
10	INSTALL 72" RCP (USDOCCA STD. DWG. NO. 503.2)
11	INSTALL 30" RCP END SECTION (NDOOT STD. PLAN R-2.3.1)
12	INSTALL 36" RCP END SECTION (NDOOT STD. PLAN R-2.3.1)
13	INSTALL 42" RCP END SECTION (NDOOT STD. PLAN R-2.3.1)
14	INSTALL 72" RCP END SECTION (NDOOT STD. PLAN R-2.3.1)
15	CONSTRUCT TYPE "CM2" DROP INLET. SIZE PER PLAN (USDOCCA STD. DWG. NO. 412.1 & 421)
16	STRUCTURAL MANHOLE
17	CONSTRUCT CONCRETE COLLAR (SEE DETAIL 3/DTL-01)
18	CONSTRUCT INTERIM BRICK AND MORTAR PLUG SEE DETAIL 2/DTL-01
19	INSTALL 24" RCP END SECTION (NDOOT STD. PLAN R-2.3.1)
20	INSTALL 54" RCP END SECTION (NDOOT STD. PLAN R-2.3.1)
21	INSTALL 66" RCP END SECTION (NDOOT STD. PLAN R-2.3.1) w/1" SACRIFICIAL CONCRETE PER STRUCTURAL DWGS.

NOTES

1. ALL RCP SHALL BE CLASS III UNLESS OTHERWISE SHOWN.
2. ALL PIPE LENGTHS ARE MEASURED ALONG PIPE CENTERLINE TO CENTER OF MANHOLE OR INSIDE EDGE OF DI OR RCB/IRCA.
3. ALL DROP INLETS SHALL INCLUDE STORM WATER MANAGEMENT STAMP AND DETAIL PER USDOCSA STD. DWG. NO. 421.
4. SEE STRUCTURAL PLANS FOR ADDITIONAL STRUCTURAL DETAILS AND CONNECTIONS.
5. ALL PIPES ARE PUBLICLY MAINTAINED.
6. ADD SPECIAL INSPECTION REQUIRED FOR PIPE SEGMENTS WITH SACRIFICIAL CONCRETE.
7. DIMENSIONS ARE TO BE BACK OF CURB, FACE OF CURB, OR FACE OF MEDIAN UNLESS OTHERWISE NOTED.
8. SEE T-Y-SHEETS FOR TYPICAL SECTION.
9. SEE U-T-SHEETS FOR WATER AND SEWER PLAN AND PROFILES.

DROP INLET NOTE
WHERE 10 FEET PARALLEL SEPARATION IS NOT PRACTICABLE:
CAST-IN-PLACE MONOLITHIC POUR WITH WATERSTOP BETWEEN SLAB AND WALLS. BASE, WALLS AND TOP TO BE CONSTRUCTED WITH WATERSTOPS, CENTER BULB, OR FLAT STRIP (VINYLEX, GREENSTREAK PLASTIC PRODUCTS OR APPROVED EQUAL).

LEGEND

	STORM DRAIN LATERAL # (SEE LAT SHEETS)
---	--

I CERTIFY THAT THIS GRADING PLAN IS IN CONFORMANCE WITH THE APPROVED TECHNICAL DRAINAGE STUDY DS-4931 ON FILE AT THE CITY OF LAS VEGAS FOR THE SUBJECT PROJECT

9/10/8

FLOOD ZONE

THE PROJECT SITE IS LOCATED WITHIN A FEMA DESIGNATED ZONE "X" (OUTSIDE THE 500-YEAR FLOOD PLAIN) ON THE FLOOD INSURANCE RATE MAP (FIRM) PANEL: 32003C1750E, DATED SEPTEMBER 27, 2002

NOTE:
PROPERTY OWNER IS RESPONSIBLE TO MAINTAIN THE BEST MANAGEMENT PRACTICES, SUCH AS BUT NOT LIMITED TO, THE REMOVAL OF ACCUMULATED SEDIMENT AND DEBRIS AND CARE OF VEGETATION.

APPROVED FOR CONSTRUCTION	
LVVMD ENGINEERING SERVICES MANAGER PROJECT NO. 126408	DATE

AVOID HITTING DOWNED
POWER LINES (PO) COSTLY

**CALL BEFORE
YOU DIG
OVERHEAD**



1-702-227-2929

FAST

**Call
before you
Under Ground.**

1-702-432-5300


UTILITY AND INDUSTRIAL
SYSTEMS RELOCATION



Call before you Dig
Avoid costly interruptions
utility lines. It's easy.



Call



1-800-227-2600

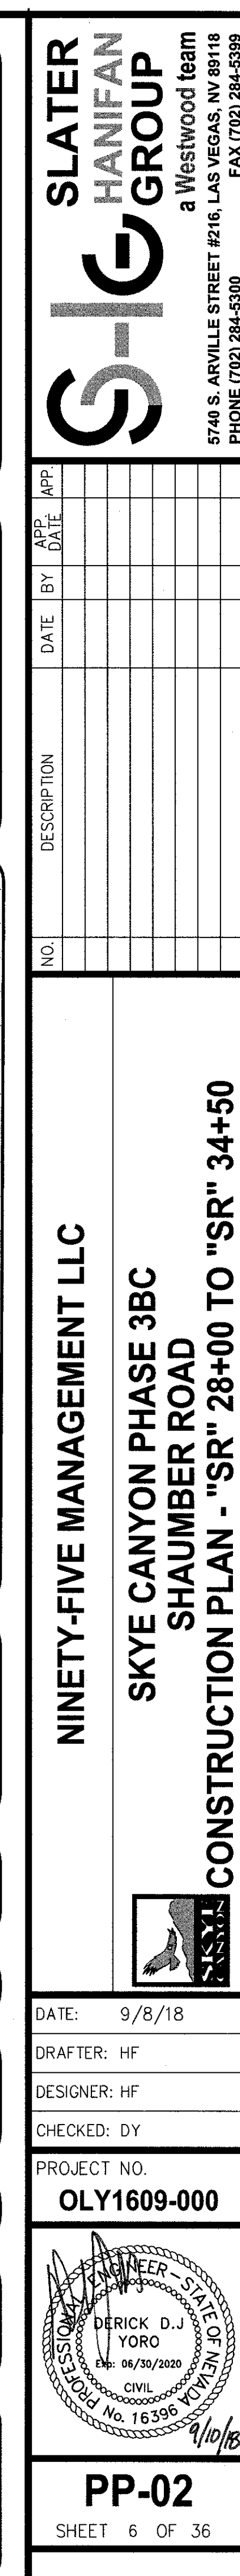

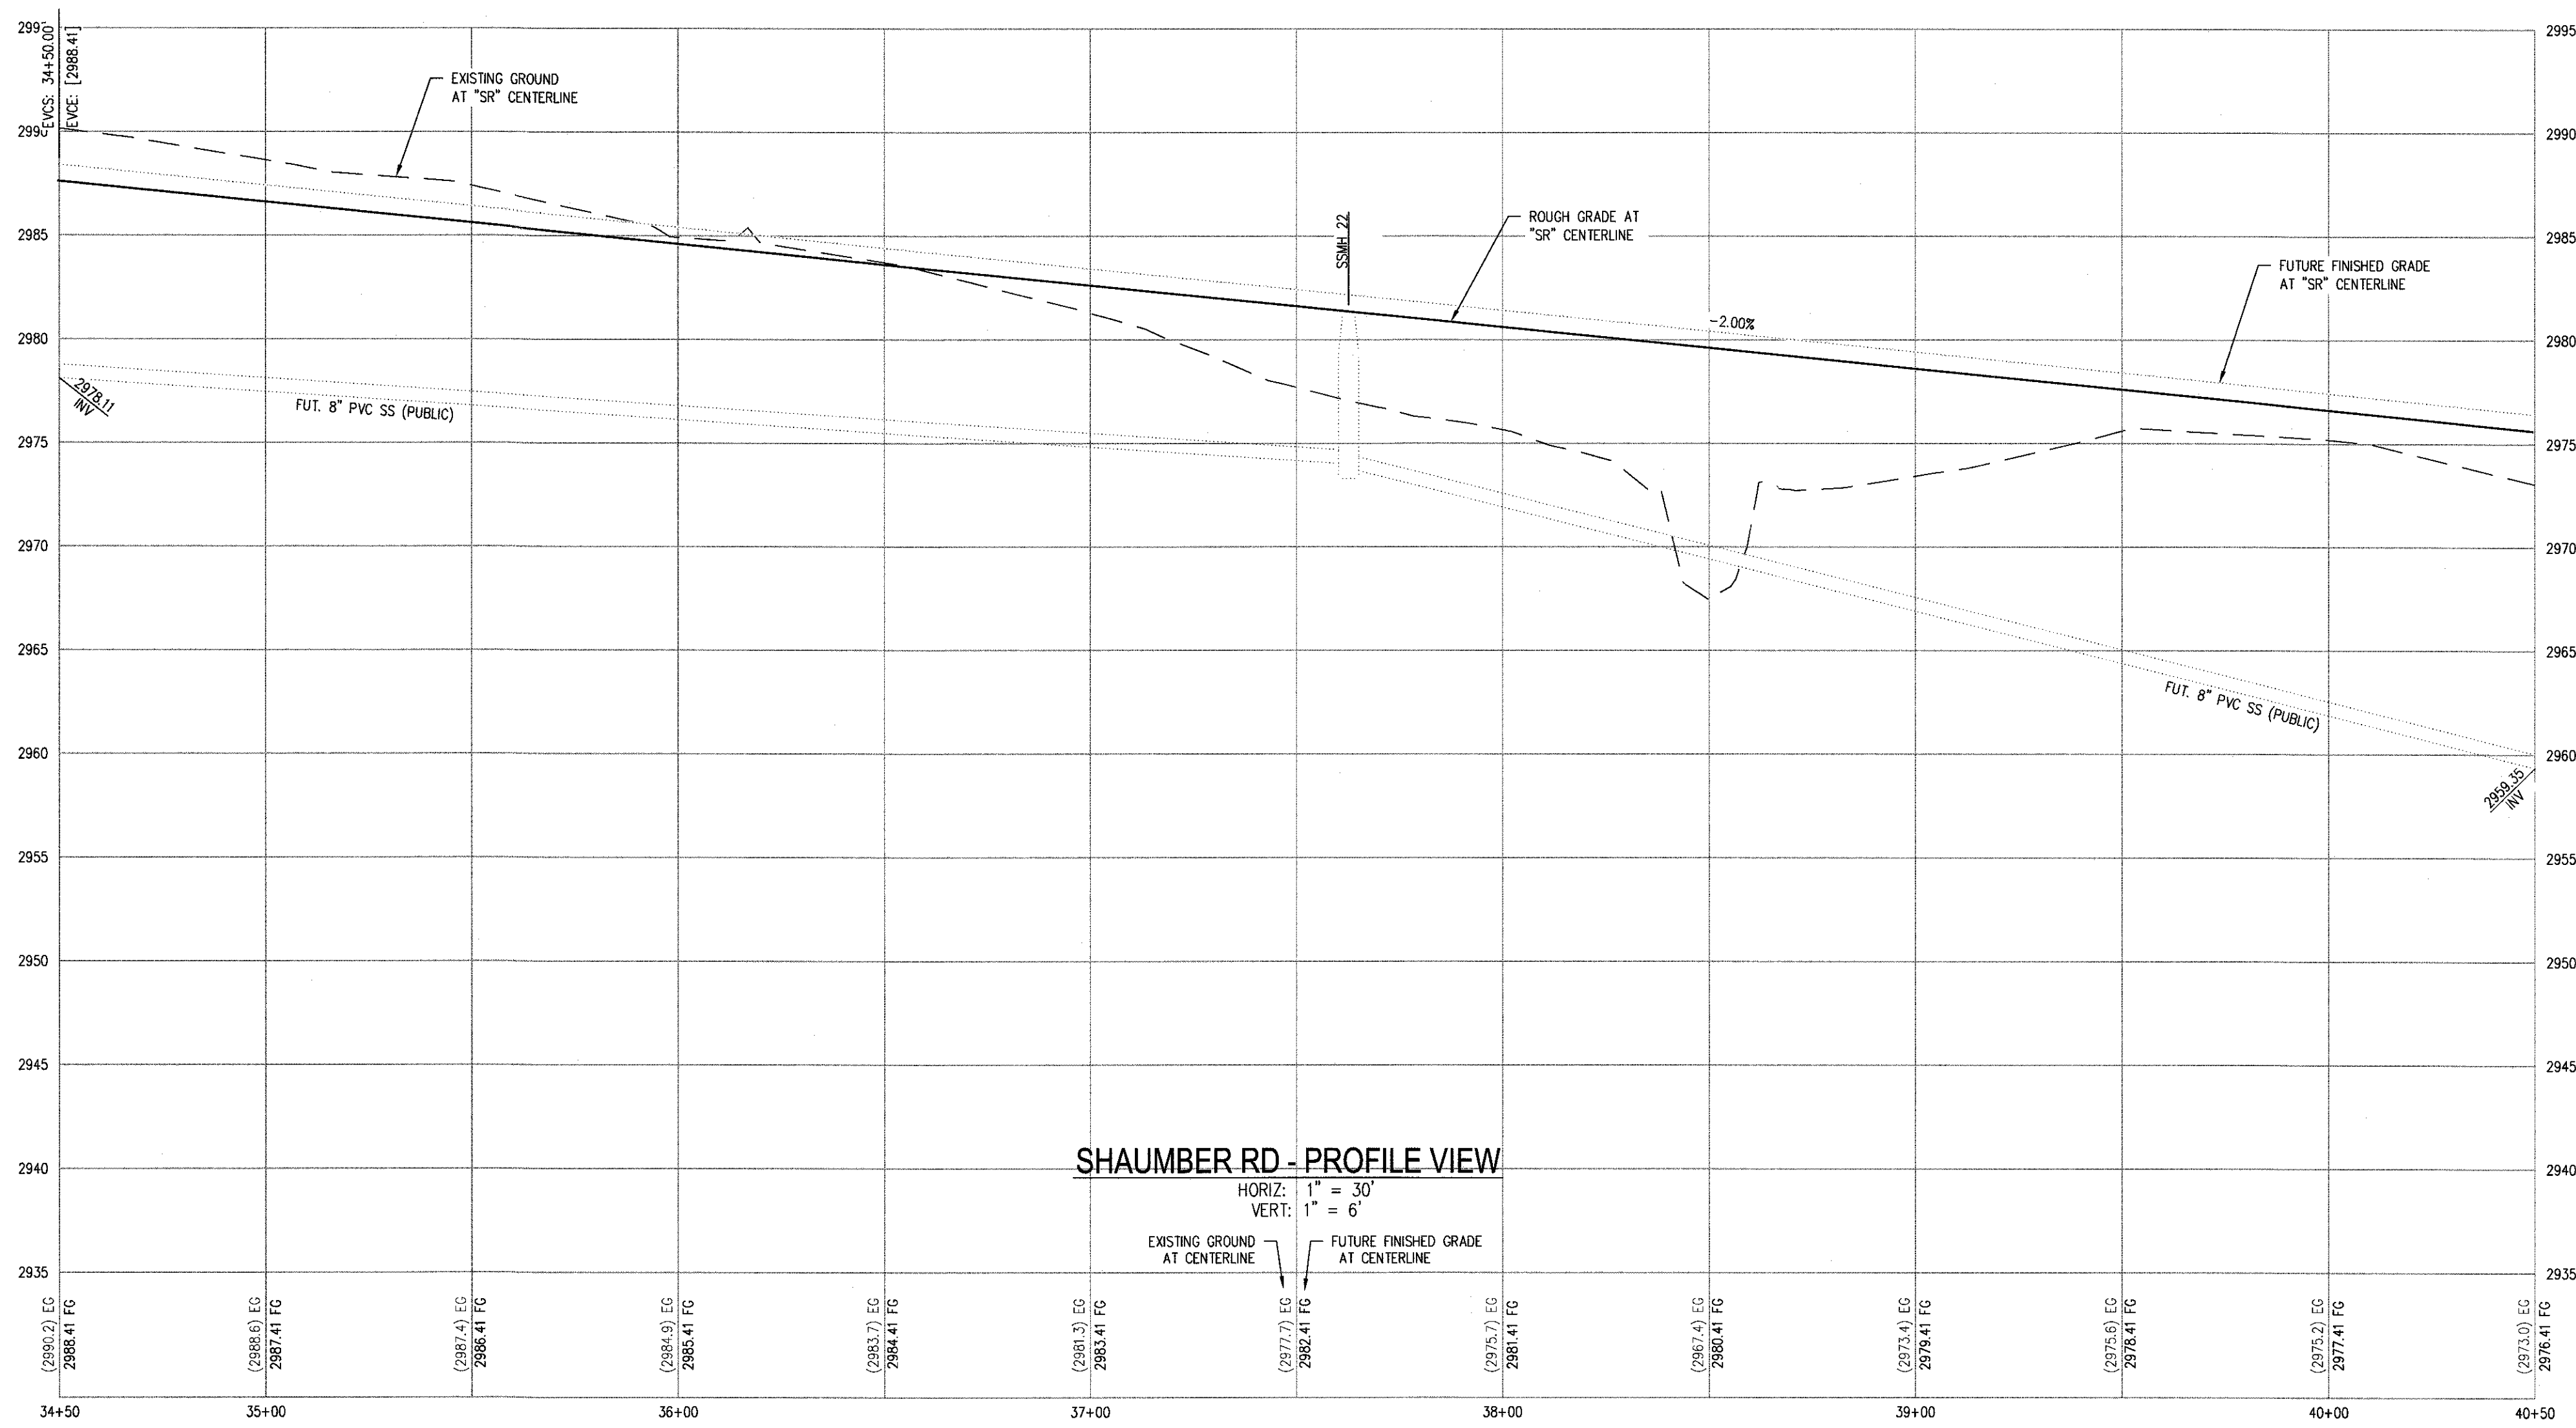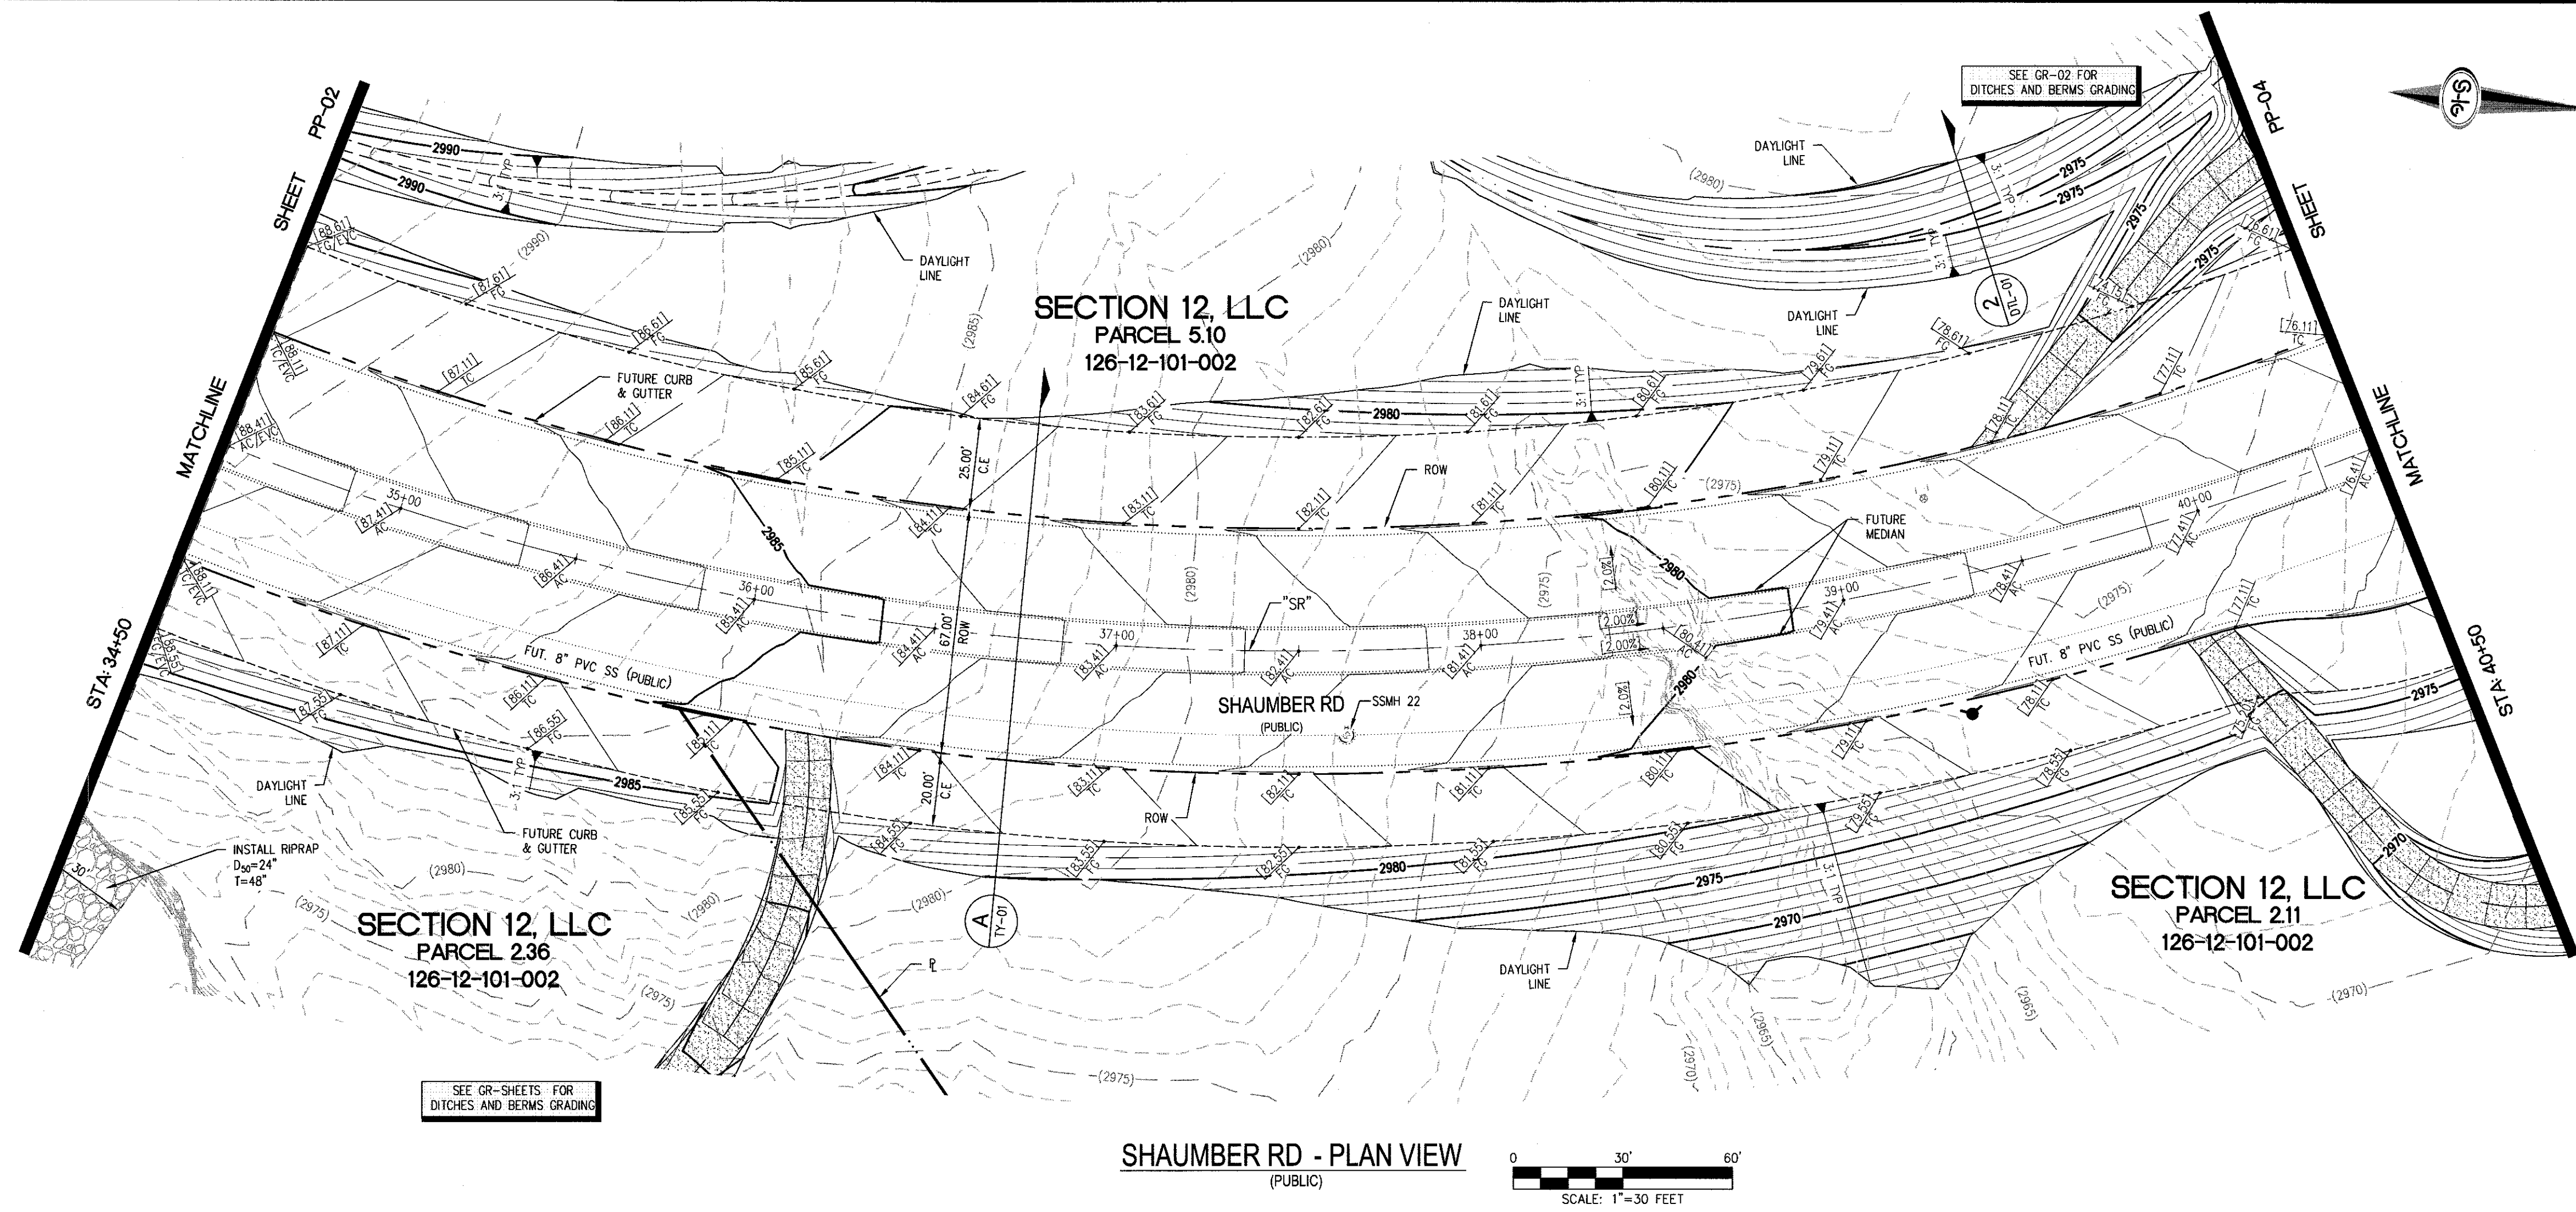

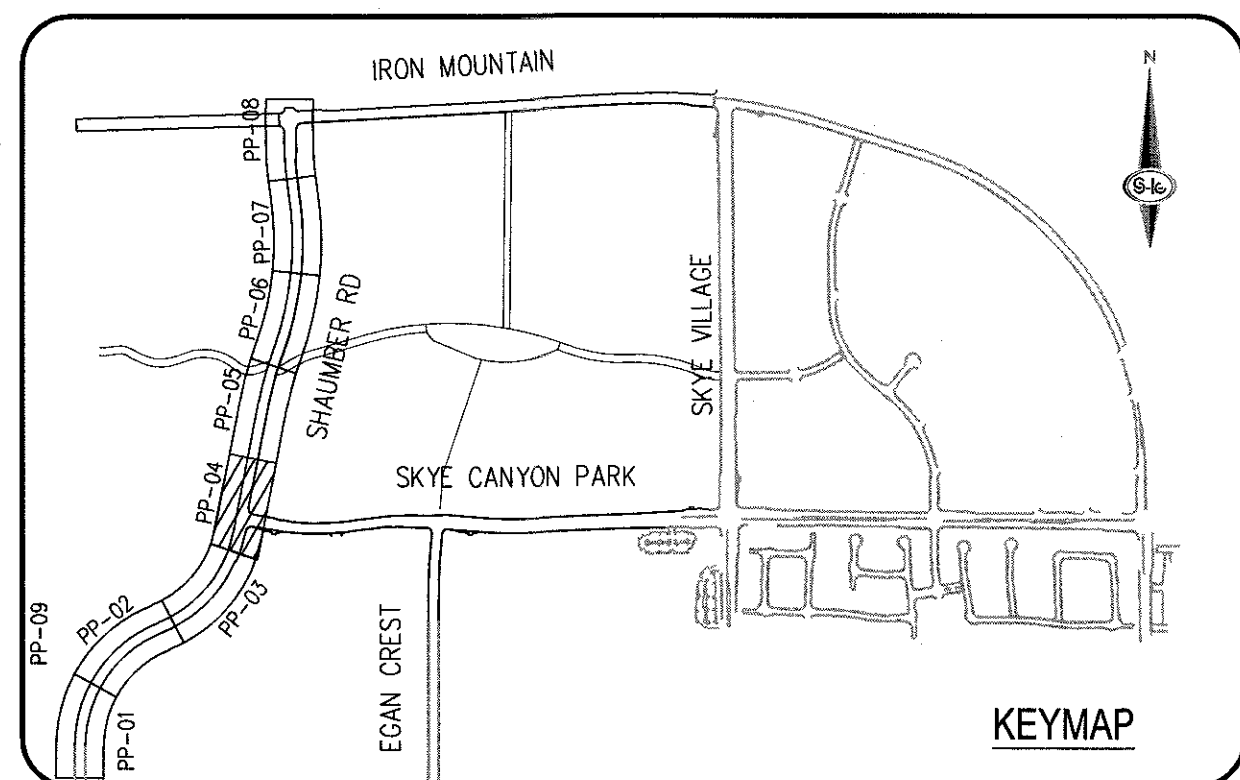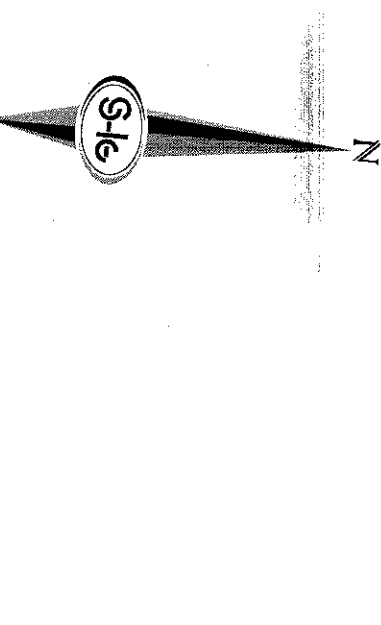

CONSTRUCTION NOTES	
1	CONSTRUCT 1" UTACS OVER 4.5" PBS OVER 4" TYPE II AGGREGATE BASE (SEE TY SHEETS)
2	CONSTRUCT 1" UTACS OVER 5.5" PBS OVER 6" TYPE II AGGREGATE BASE (SEE TY SHEETS)
3	CONSTRUCT "A" TYPE ISLAND CURB (USDCCA STD. DWG. NO. 219)
4	CONSTRUCT "L" TYPE CURB AND GUTTER (USDCCA STD. DWG. NO. 216)
5	CONSTRUCT SIDEWALK RAMP (CASE II) WITH TACTILE WARNING PANEL (USDCCA STD. DWG. NO. 235)
6	CONSTRUCT BUS TURN-OUT (USDCCA STD. DWG. NO. 234.1)
7	CONSTRUCT CONCRETE SIDEWALK (USDCCA STD. DWG. 234)
P	PROTECT IN PLACE (VERIFY LOCATION AND ELEVATION OF EX. IMPROVEMENT)

STORM DRAIN NOTES	
(1)	CONSTRUCT 48" TYPE II-SID MANHOLE (USDOCCA STD. DWG. NO. 405.2)
(2)	CONSTRUCT 60" TYPE III MANHOLE (USDOCCA STD. DWG. NO. 406.1)
(3)	INSTALL 18" RCP (USDOCCA STD. DWG. NO. 503.2)
(4)	INSTALL 24" RCP (USDOCCA STD. DWG. NO. 503.2)
(5)	INSTALL 30" RCP (USDOCCA STD. DWG. NO. 503.2)
(6)	INSTALL 36" RCP (USDOCCA STD. DWG. NO. 503.2)
(7)	INSTALL 42" RCP (USDOCCA STD. DWG. NO. 503.2)
(8)	INSTALL 54" RCP (USDOCCA STD. DWG. NO. 503.2)
(9)	INSTALL 60" RCP (USDOCCA STD. DWG. NO. 503.2)
(10)	INSTALL 72" RCP (USDOCCA STD. DWG. NO. 503.2)
(11)	INSTALL 30" RCP END SECTION (NDOT STD. PLAN R-2.3.1)
(12)	INSTALL 36" RCP END SECTION (NDOT STD. PLAN R-2.3.1)
(13)	INSTALL 42" RCP END SECTION (NDOT STD. PLAN R-2.3.1)
(14)	INSTALL 72" RCP END SECTION (NDOT STD. PLAN R-2.3.1)
(15)	CONSTRUCT TYPE "CM2" DROP INLET. SIZE PER PLAN (USDOCCA STD. DWG. NO. 412.1 & 421)
(16)	STRUCTURAL MANHOLE
(17)	CONSTRUCT CONCRETE COLLAR (SEE DETAIL 3/DTL-01)
(18)	CONSTRUCT INTERIM BRICK AND MORTAR PLUG SEE DETAIL 2/DTL-01
(19)	INSTALL 24" RCP END SECTION (NDOT STD. PLAN R-2.3.1)
(20)	INSTALL 54" RCP END SECTION (NDOT STD. PLAN R-2.3.1)
(21)	INSTALL 66" RCP END SECTION (NDOT STD. PLAN R-2.3.1) W/1" SACRIFICIAL CONCRETE PER STRUCTURAL DWGS

NOTES

1. ALL ROP SHALL BE CLASS 9 UNLESS OTHERWISE SHOWN.
2. ALL PIPE LENGTHS ARE MEASURED ALONG PIPE CENTERLINE TO CENTER OF MANHOLE OR INSIDE EDGE OF DI OR RCB/RCA.
3. ALL DROP INLETS SHALL INCLUDE STORM WATER MANAGEMENT STAMP AND DETAIL PER USDOCS STD. DWG. NO. 421.
4. SEE STRUCTURAL PLANS FOR ADDITIONAL STRUCTURAL DETAILS AND CONNECTIONS.
5. ALL PIPES ARE PUBLICLY MAINTAINED.
6. ADD SPECIAL INSPECTION REQUIRED FOR PIPE SEGMENTS WITH SACRIFICIAL CONCRETE.
7. FUNCTIONS ARE TO BE BACK OF CURB, FACE OF CURB, OR FACE OF MEDIAN UNLESS OTHERWISE NOTED.
8. SEE TY-SHEETS FOR TYPICAL SECTIONS.
9. SEE UT-SHEETS FOR WATER AND SEWER PLAN AND PROFILES.

DROP INLET NOTE

WHERE 10 FEET PARALLEL SEPARATION IS NOT PRACTICABLE:

CAST-IN-PLACE MONOLITHIC POUR WITH WATERSTOP BETWEEN SLAB AND WALLS. BASE, WALLS AND TOP TO BE CONSTRUCTED WITH WATERSTOPS, CENTER BULB, OR FLAT STRIP (VYNLEX, GREENSTREAK PLASTIC PRODUCTS OR APPROVED EQUAL).

LEGEND

X STORM DRAIN LATERAL # (SEE LAT SHEETS)

I CERTIFY THAT THIS GRADING PLAN IS IN CONFORMANCE WITH THE APPROVED TECHNICAL DRAINAGE STUDY DS-4931 ON FILE AT THE CITY OF CHANDLER FOR THE SUBJECT PROJECT

DATE: 9/10/18

DRAWN BY: J. L. "JL"

CHECKED BY: [Signature]

DESIGNED BY: [Signature]

SCALE: AS SHOWN

FLOOD ZONE

THE PROJECT SITE IS LOCATED WITHIN A FEMA DESIGNATED ZONE "X" (OUTSIDE THE 500-YEAR FLOOD PLAIN) ON THE FLOOD INSURANCE RATE MAP (FIRM) PANEL: 3200C1750E, DATED SEPTEMBER 27, 2002

NOTE: PROPERTY OWNER IS RESPONSIBLE TO MAINTAIN THE BEST MANAGEMENT PRACTICES, SUCH AS BUT NOT LIMITED TO THE REMOVAL OF ACCUMULATED SEDIMENT AND DEBRIS AND CARE OF VEGETATION

APPROVED FOR CONSTRUCTION	
LIVVMD ENGINEERING SERVICES MANAGER	DATE _____
PROJECT NO. 10C-100	

PROJECT NO. 126408



Call before you Dig
UnderGround.


1-702-227-2929




Call before you Dig
Avoid hitting overhead power lines. It's costly. Digging safely. It's easy.



OR

1-800-227-2800

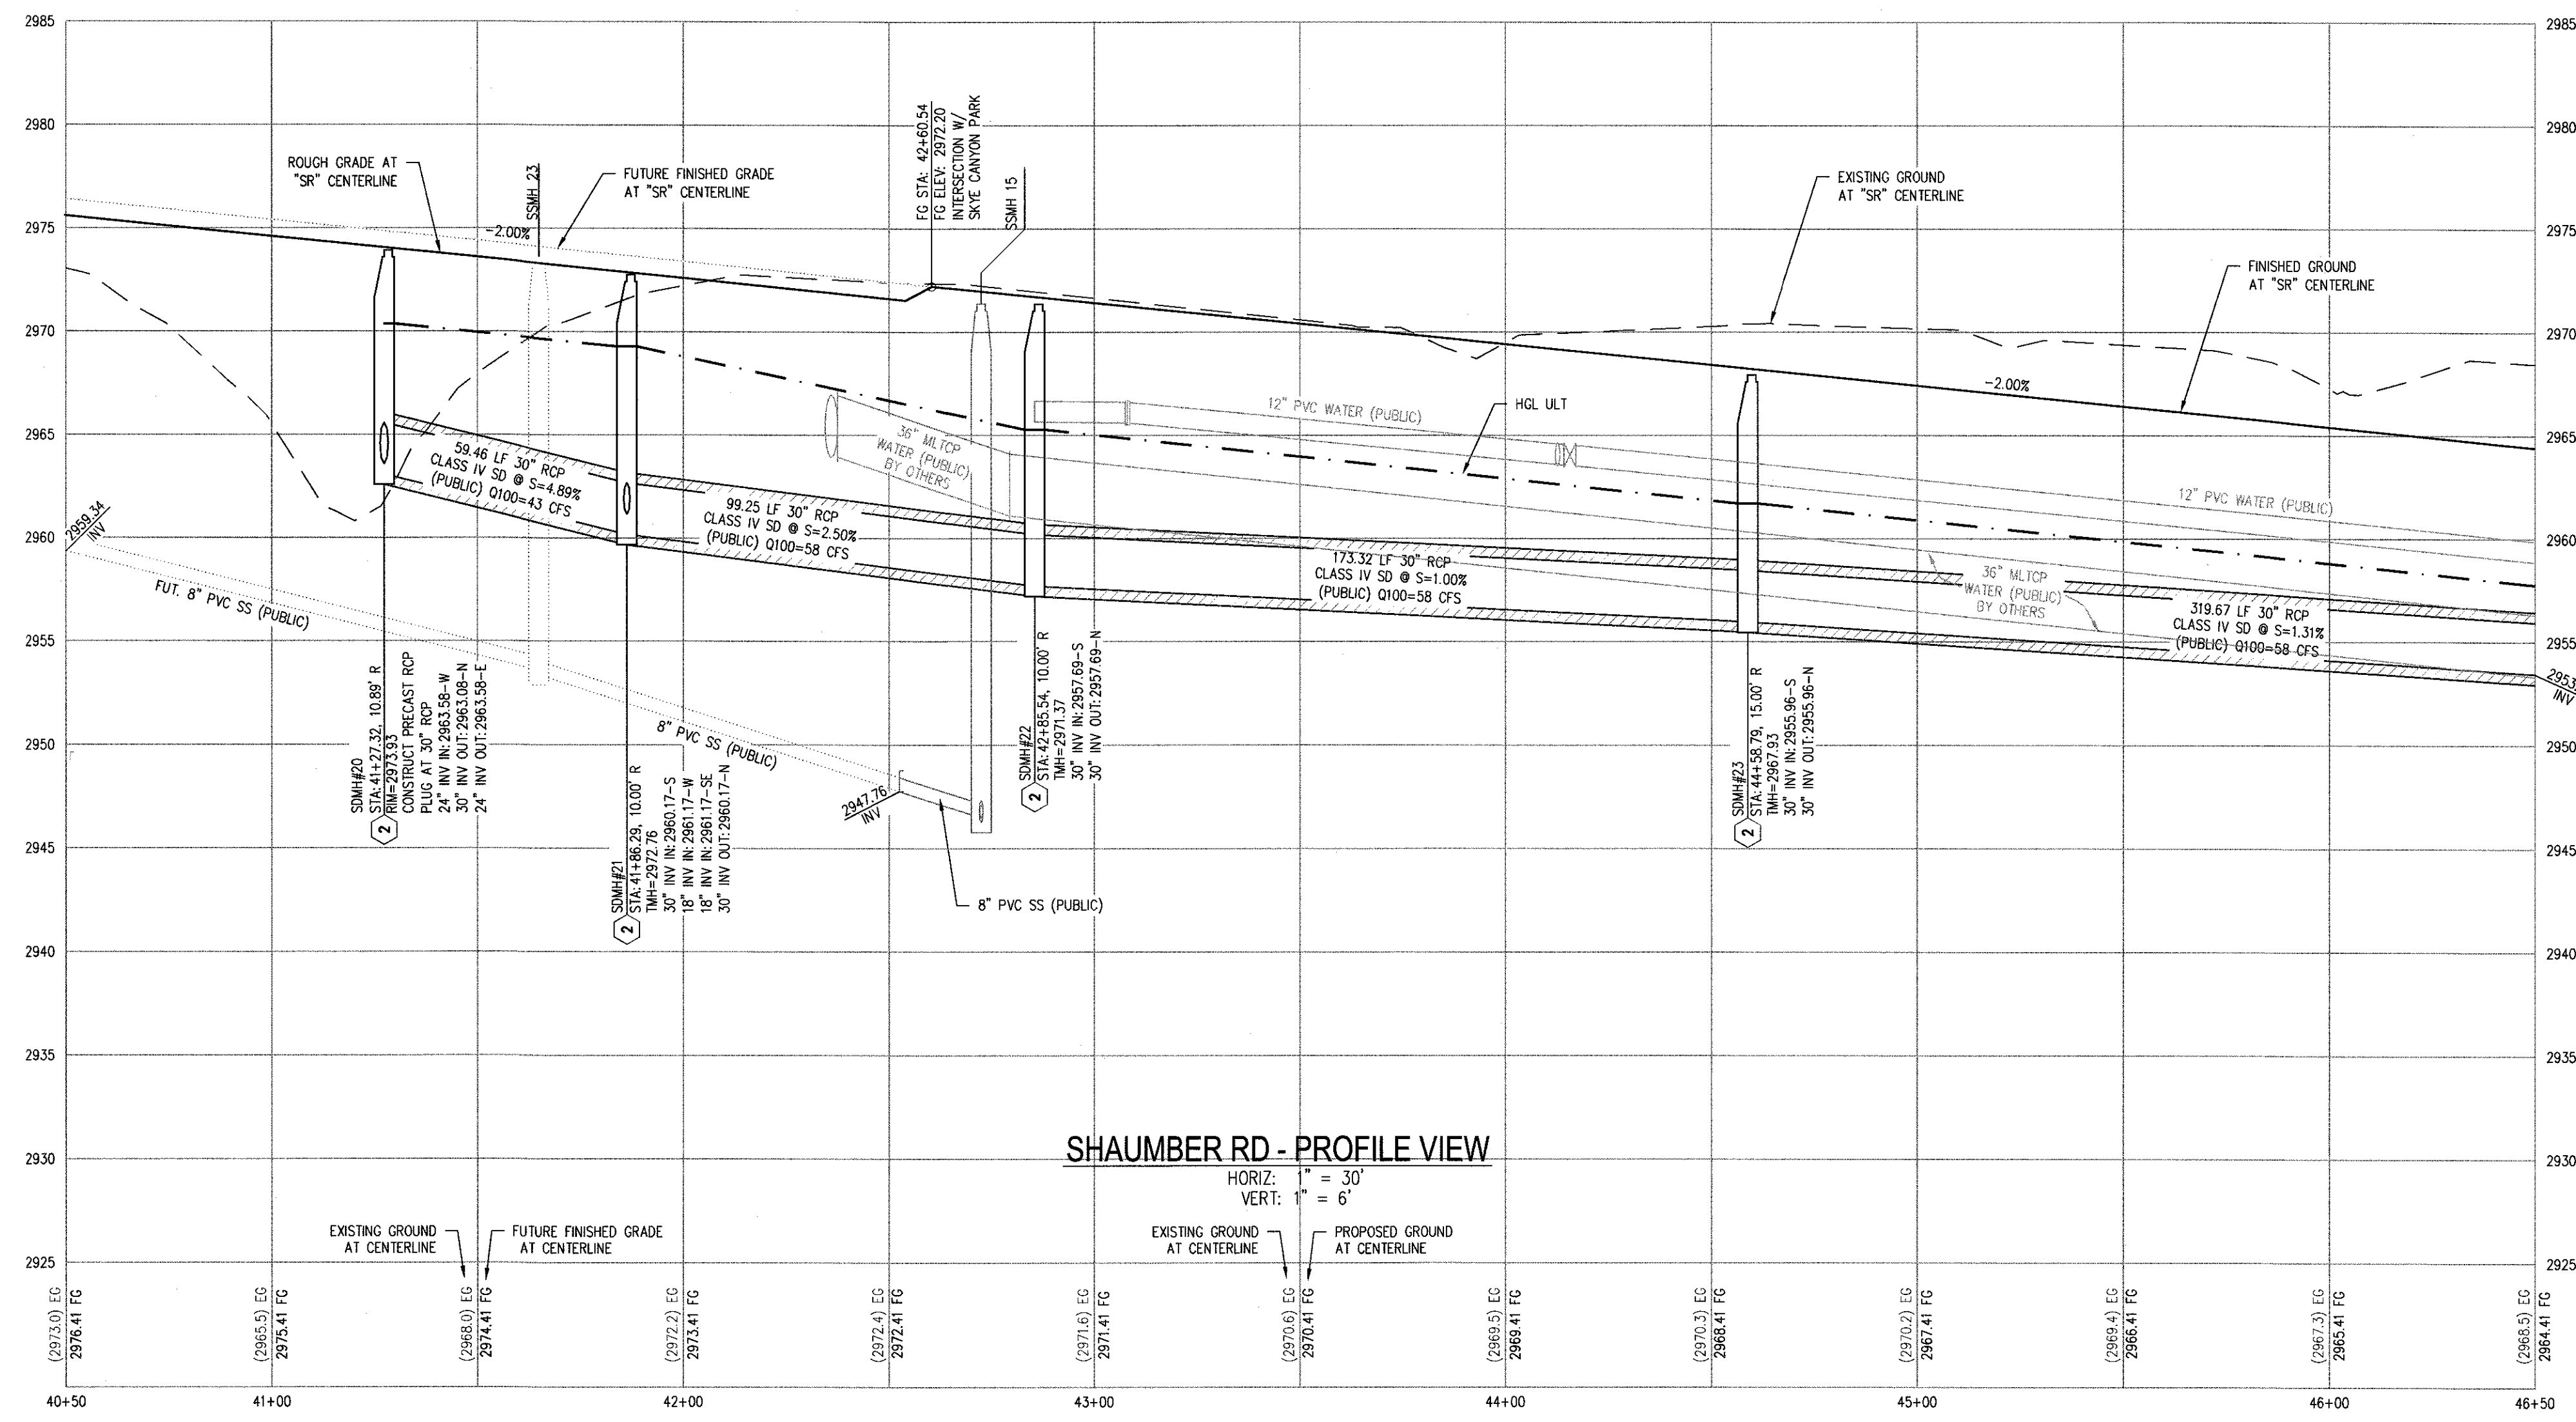

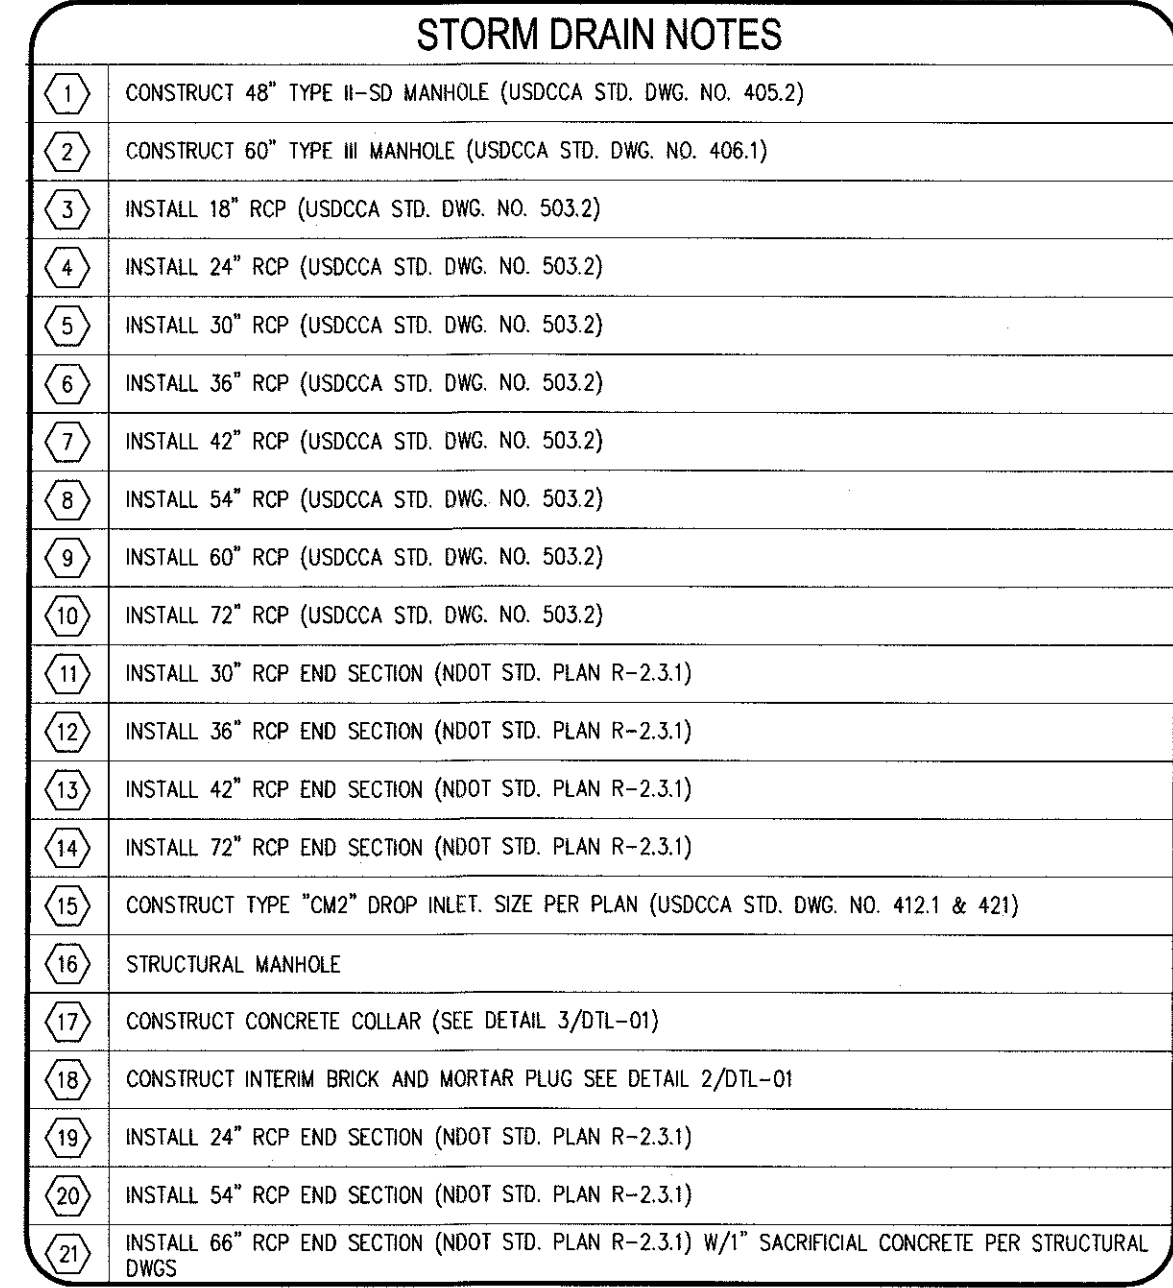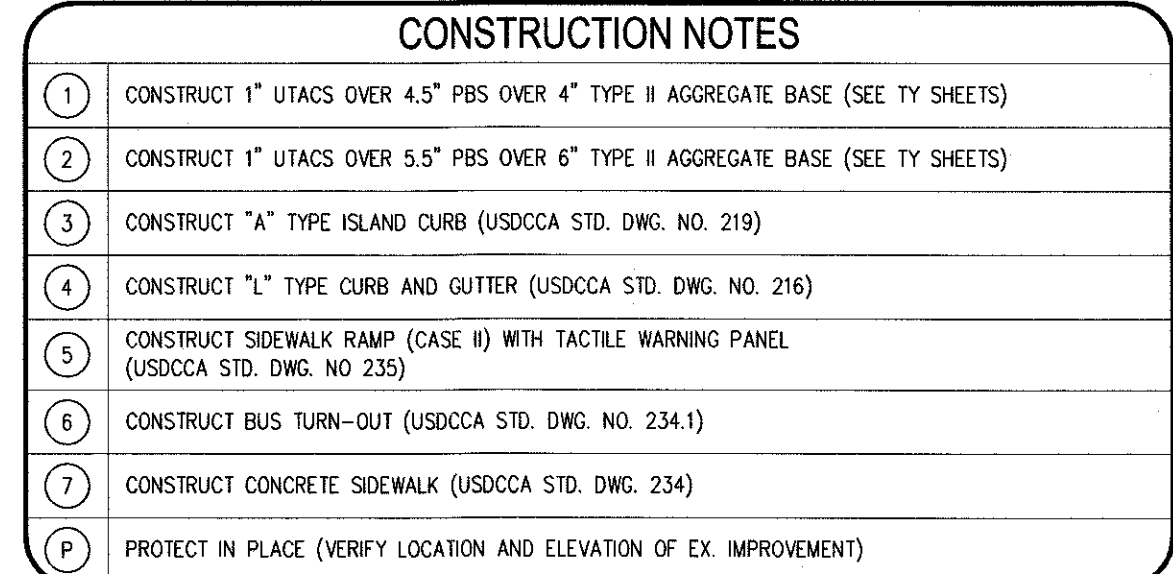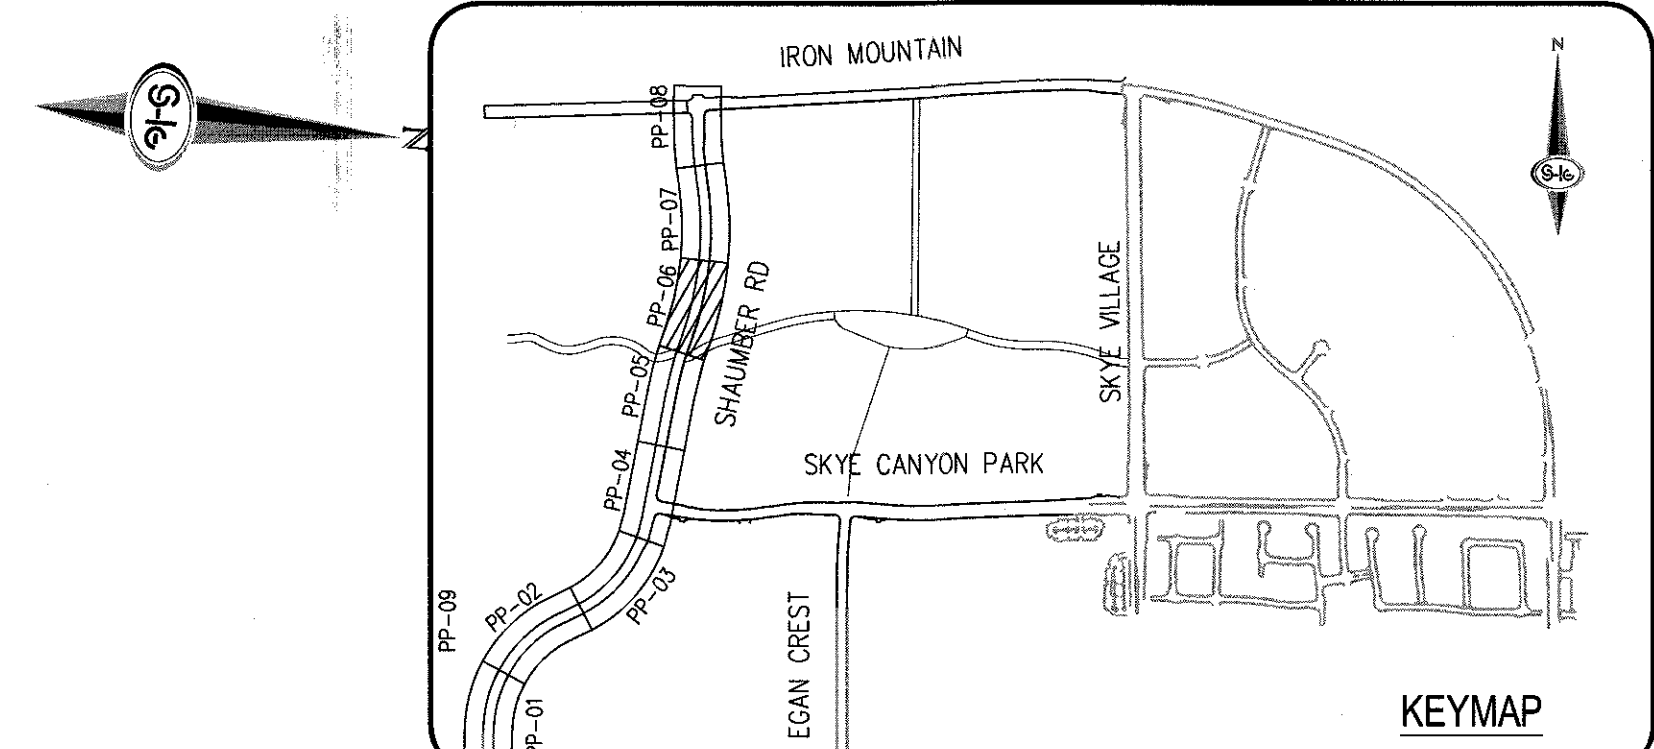

NOTES

1. ALL RCP SHALL BE CLASS III UNLESS OTHERWISE SPECIFIED.
2. ALL PIPE LENGTHS ARE MEASURED ALONG PIPE CENTERLINE TO CENTER OF MANHOLE OR INSIDE EDGE OF ID OR R/CB/RA.
3. ALL DROP INLETS SHALL INCLUDE STANDARD WATER MANAGEMENT STAMP AND DETAIL PER USDCSA STD. DWG. NO. 421.
4. SEE STRUCTURAL PLANS FOR ADDITIONAL STRUCTURAL DETAILS AND CONNECTIONS.
5. ALL PIPES ARE PUBLICLY MAINTAINED.
6. ADD SPECIAL INSPECTION REQUIRED FOR PIPE SEGMENTS WITH SACRIFICIAL CONCRETE.
7. DIMENSIONS ARE TO FACE OF CURB, FACE OF CURB, OR FACE OF MEDIAN UNLESS OTHERWISE NOTED.
8. SEE UT-SHEETS FOR TYPICAL SECTIONS.
9. SEE UT-SHEETS FOR WATER AND SEWER PLAN AND PROFILES.

DROP INLET NOTE
WHERE 10 FEET PARALLEL SEPARATION IS NOT PRACTICABLE:
CAST-IN-PLACE MONOLITHIC POUR WITH WATERSTOP BETWEEN SLAB AND WALLS. BASE, WALLS AND TOP TO BE CONSTRUCTED WITH WATERSTOPS, CENTER BULB,
OR FLAT STRIP (VINYLEX, GREENSTREAK PLASTIC PRODUCTS OR APPROVED EQUAL).

LEGEND

 STORM DRAIN LATERAL # (SEE LAT SHEETS)

I CERTIFY THAT THIS GRADING PLAN IS IN
CONFORMANCE WITH THE APPROVED TECHNICAL
DRAINAGE STUDY DS-4931 ON FILE AT THE CITY
OF LAS VEGAS FOR THE SUBJECT PROJECT

 9/10/18
DERICK FORD, P.E. 16396 DATE

FLOOD ZONE
THE PROJECT SITE IS LOCATED WITHIN A FEMA DESIGNATED ZONE 'X' (OUTSIDE THE 500-YEAR FLOOD PLAIN) ON THE FLOOD INSURANCE RATE MAP (FIRM) PANEL: 32003C1750E, DATED SEPTEMBER 27, 2002

NOTE: PROPERTY OWNER IS RESPONSIBLE TO MAINTAIN THE BEST MANAGEMENT PRACTICES, SUCH AS BUT NOT LIMITED TO, THE REMOVAL OF ACCUMULATED SEDIMENT AND DEBRIS AND CARE OF VEGETATION.

APPROVED FOR CONSTRUCTION

LVWD ENGINEERING SERVICES MANAGER DATE

PROJECT NO. 126408





FAST
Call before you dig
UnderGround.
1-702-432-5300
FREEWAY AND ARTERIAL
SYSTEM OF TRANSPORTATION

Call before you Dig
Avoid cutting underground utility lines. It's costly.

**Call
811**

OR
1-800-227-2600

J:\101609-000 SKYE CANYON PHASE 3B 3D\101609-000-PP-07-SR-000.dwg 9/8/2018 4:00 PM User: dms

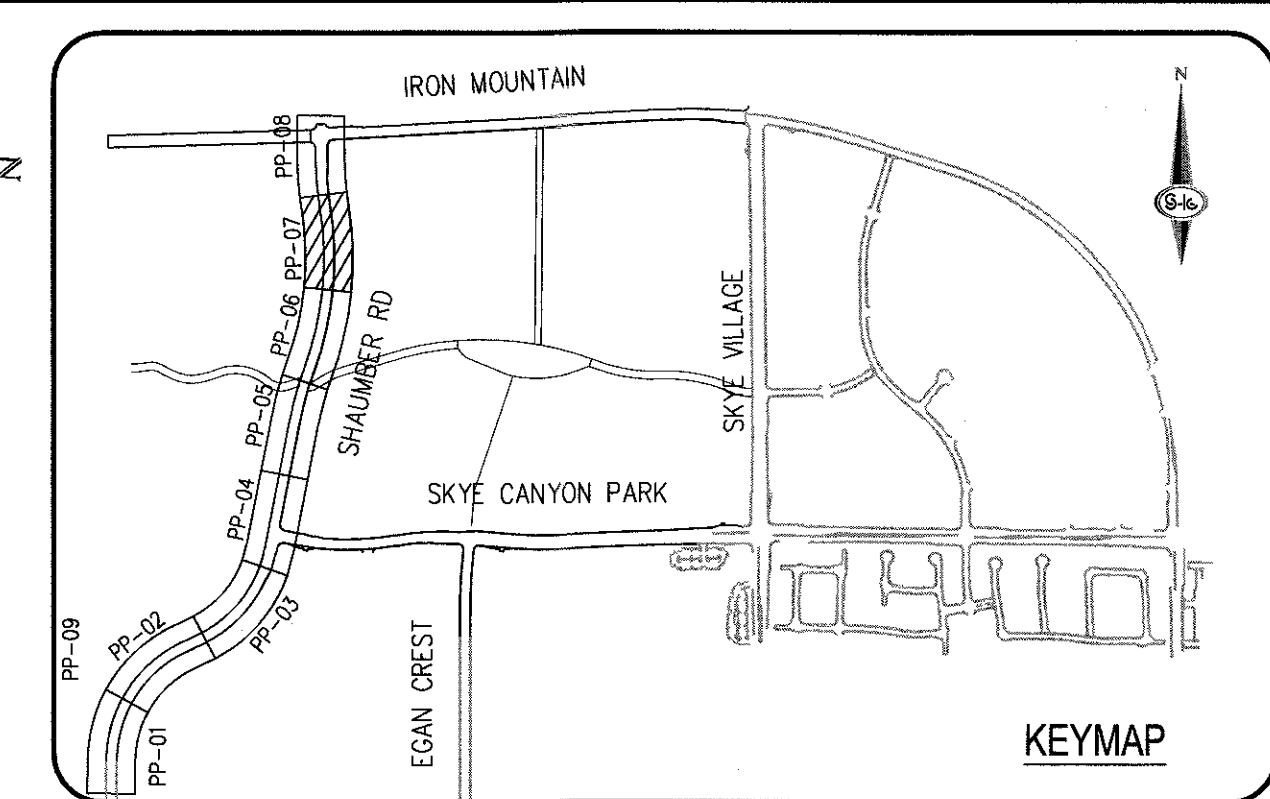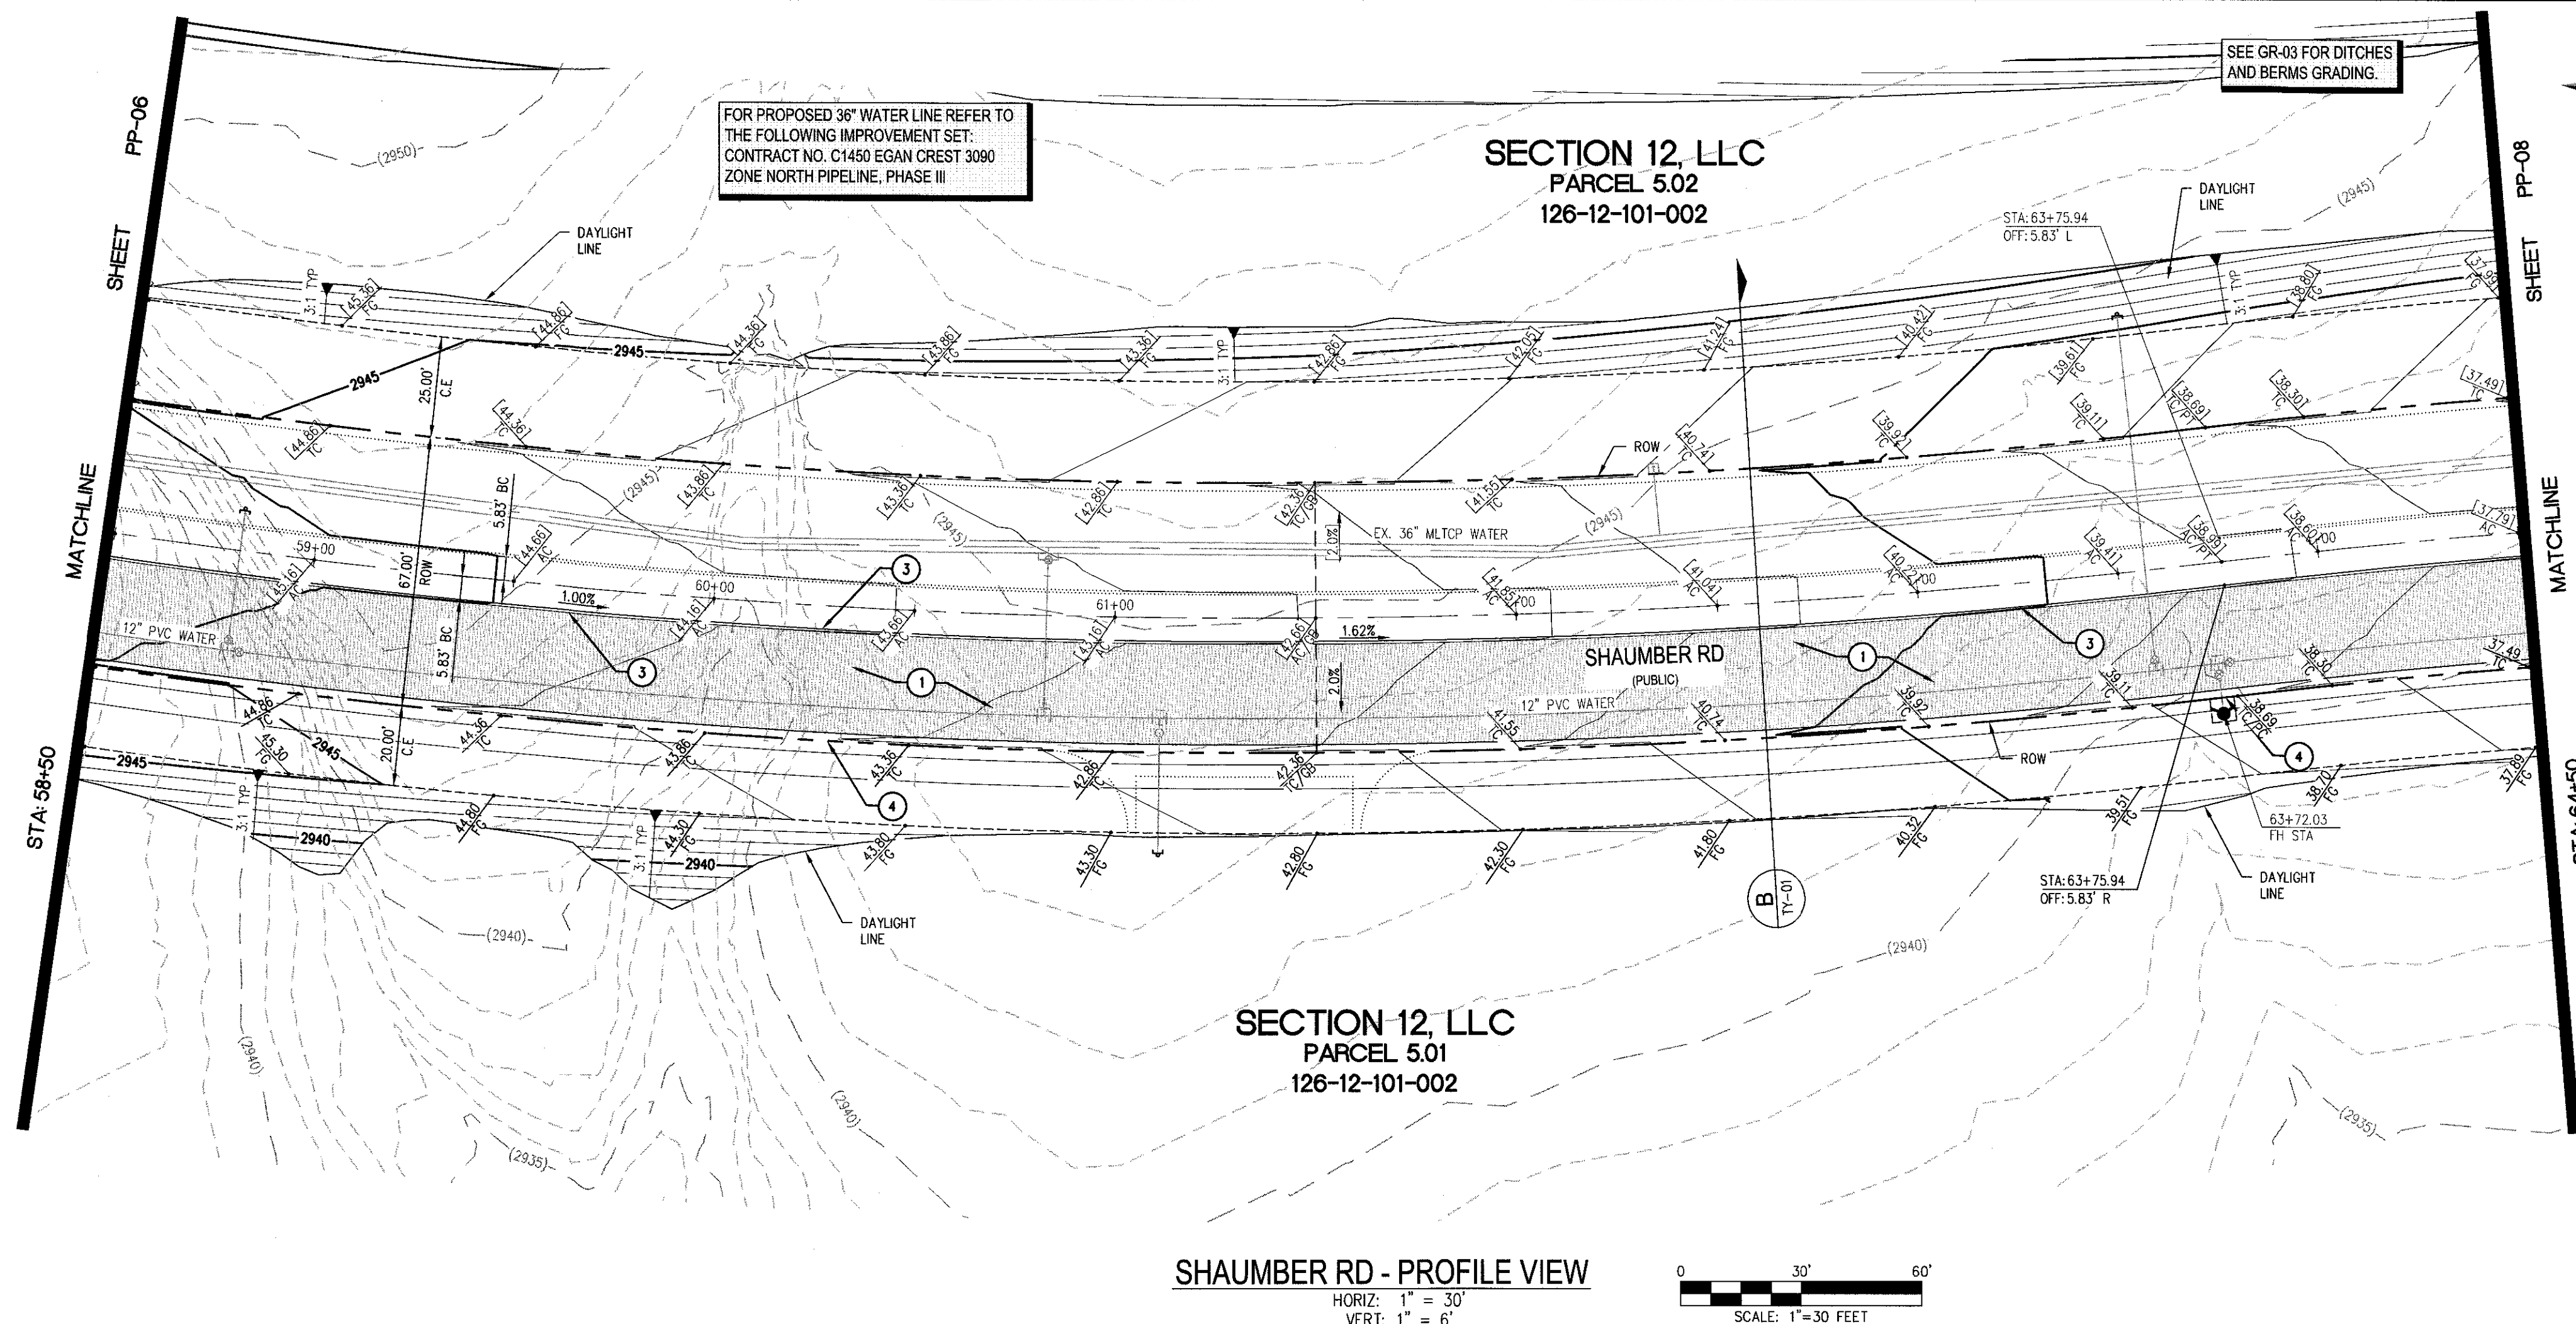

CONSTRUCTION NOTES

1. CONSTRUCT 1" UTACS OVER 4.5" PBS OVER 4" TYPE II AGGREGATE BASE (SEE TY SHEETS)
2. CONSTRUCT 1" UTACS OVER 5.5" PBS OVER 6" TYPE II AGGREGATE BASE (SEE TY SHEETS)
3. CONSTRUCT "A" TYPE ISLAND CURB (USDCCA STD. DWG. NO. 219)
4. CONSTRUCT "L" TYPE CURB AND GUTTER (USDCCA STD. DWG. NO. 216)
5. CONSTRUCT SIDEWALK RAMP (CASE II) WITH TACTILE WARNING PANEL (USDCCA STD. DWG. NO. 235)
6. CONSTRUCT BUS TURN-OUT (USDCCA STD. DWG. NO. 234.1)
7. CONSTRUCT CONCRETE SIDEWALK (USDCCA STD. DWG. 234)
8. PROTECT IN PLACE (VERIFY LOCATION AND ELEVATION OF EX. IMPROVEMENT)

STORM DRAIN NOTES

1. CONSTRUCT 48" TYPE III MANHOLE (USDCCA STD. DWG. NO. 405.2)
2. CONSTRUCT 60" TYPE III MANHOLE (USDCCA STD. DWG. NO. 406.1)
3. INSTALL 18" RCP (USDCCA STD. DWG. NO. 503.2)
4. INSTALL 24" RCP (USDCCA STD. DWG. NO. 503.2)
5. INSTALL 30" RCP (USDCCA STD. DWG. NO. 503.2)
6. INSTALL 36" RCP (USDCCA STD. DWG. NO. 503.2)
7. INSTALL 42" RCP (USDCCA STD. DWG. NO. 503.2)
8. INSTALL 54" RCP (USDCCA STD. DWG. NO. 503.2)
9. INSTALL 60" RCP (USDCCA STD. DWG. NO. 503.2)
10. INSTALL 72" RCP (USDCCA STD. DWG. NO. 503.2)
11. INSTALL 30" RCP END SECTION (NDOT STD. PLAN R-2.3.1)
12. INSTALL 36" RCP END SECTION (NDOT STD. PLAN R-2.3.1)
13. INSTALL 42" RCP END SECTION (NDOT STD. PLAN R-2.3.1)
14. INSTALL 72" RCP END SECTION (NDOT STD. PLAN R-2.3.1)
15. CONSTRUCT TYPE "CM2" DROP INLET. SIZE PER PLAN (USDCCA STD. DWG. NO. 412.1 & 421)
16. STRUCTURAL MANHOLE
17. CONSTRUCT CONCRETE COLLAR (SEE DETAIL 3/DTL-01)
18. CONSTRUCT INTERM BRICK AND MORTAR PLUG SEE DETAIL 2/DTL-01
19. INSTALL 24" RCP END SECTION (NDOT STD. PLAN R-2.3.1)
20. INSTALL 54" RCP END SECTION (NDOT STD. PLAN R-2.3.1)
21. INSTALL 66" RCP END SECTION (NDOT STD. PLAN R-2.3.1) W/1" SACRIFICIAL CONCRETE PER STRUCTURAL DWGS

NOTES

1. ALL RCP SHALL BE CLASS III UNLESS OTHERWISE SHOWN.
2. ALL PIPE LENGTHS ARE MEASURED ALONG PIPE CENTERLINE TO CENTER OF MANHOLE OR INSIDE EDGE OF DI OR RCB/RCA.
3. ALL DROP INLETS SHALL INCLUDE STORM WATER MANAGEMENT STAMP AND DETAIL PER USDCCA STD. DWG. NO. 421.
4. SEE STRUCTURAL PLANS FOR ADDITIONAL STRUCTURAL DETAILS AND CONNECTIONS.
5. ALL PIPES ARE PUBLICLY MAINTAINED.
6. ADD SPECIAL INSPECTION REQUIRED FOR PIPE SEGMENTS WITH SACRIFICIAL CONCRETE.
7. DIMENSIONS ARE TO BE BACK OF CURB, FACE OF CURB, OR FACE OF MEDIAN UNLESS OTHERWISE NOTED.
8. SEE TY-SHEETS FOR TYPICAL SECTIONS.
9. SEE UT-SHEETS FOR WATER AND SEWER PLAN AND PROFILES.

DROP INLET NOTE

WHERE 10 FEET PARALLEL SEPARATION IS NOT PRACTICABLE:
CAST-IN-PLACE MONOLITHIC POUR WITH WATERSTOP BETWEEN SLAB AND WALLS. BASE, WALLS AND TOP TO BE CONSTRUCTED WITH WATERSTOPS. CENTER GULB OR FLAT STRIP (VINYLEX, GREENSTREAK PLASTIC PRODUCTS OR APPROVED EQUAL).

LEGEND

X STORM DRAIN LATERAL # (SEE LAT SHEETS)

I CERTIFY THAT THIS GRADING PLAN IS IN CONFORMANCE WITH THE APPROVED TECHNICAL DRAINAGE STUDY DS-4931 ON FILE AT THE CITY OF LAS VEGAS FOR THE SUBJECT PROJECT

DERICK J. YORO, P.E. 16396

9/10/18

FLOOD ZONE

THE PROJECT SITE IS LOCATED WITHIN A FEMA DESIGNATED ZONE "X" (OUTSIDE THE 500-YEAR FLOOD PLAIN) ON THE FLOOD INSURANCE RATE MAP (FIRM) PANEL 32003C1750E, DATED SEPTEMBER 27, 2002.

NOTE:
PROPERTY OWNER IS RESPONSIBLE TO MAINTAIN THE BEST MANAGEMENT PRACTICES, SUCH AS BUT NOT LIMITED TO, THE REMOVAL OF ACCUMULATED SEDIMENT AND DEBRIS AND CARE OF VEGETATION.

APPROVED FOR CONSTRUCTION

LIVND ENGINEERING SERVICES MANAGER

PROJECT NO. 126408

DATE



SLATER HANIFAN GROUP

a Westwood team

5740 S. ARVILLE STREET #216, LAS VEGAS, NV 89118
PHONE (702) 284-5300 FAX (702) 284-5399

NINETY-FIVE MANAGEMENT LLC

SKYE CANYON PHASE 3BC
SHAUMBER ROAD

CONSTRUCTION PLAN - "SR" 58+50 TO "SR" 64+50

DATE: 9/8/18


DRAFTER: HF

DESIGNER: HF

CHECKED: DY


PROJECT NO.

OLY1609-000

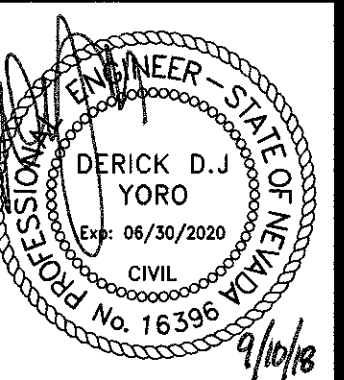

PP-07

SHEET 11 OF 36

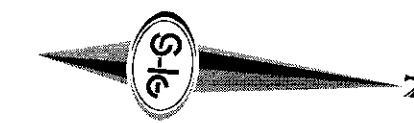STORM DRAIN NOTES

NOTES

- ### DROP INLET NOTE

LEGEND

IC PLAN IS IN

FLOOD ZONE
PROJECT SITE IS LOCATED WITHIN A FEMA
UNATED ZONE 'X' (OUTSIDE THE 500-YEAR
D PLAIN) ON THE FLOOD INSURANCE RATE
(FIRM) PANEL: 32003C1750E, DATED
EMBER 27, 2002

APPROVED FOR CONSTRUCTION




**SKYE CANYON PHASE 3BC
SHAUMBER ROAD**







CONSTRUCTION PLAN - "SR" 64+50 TO "SR" 69+50



OLY1609-000

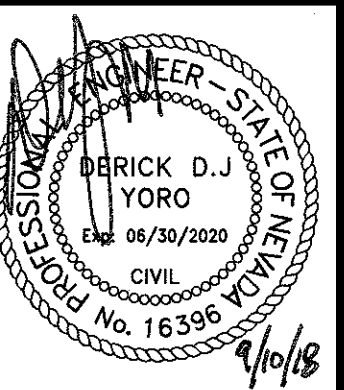

SHEET 12 OF 36

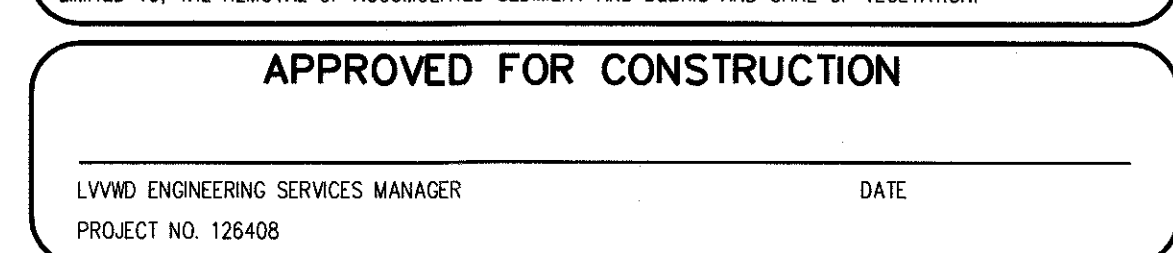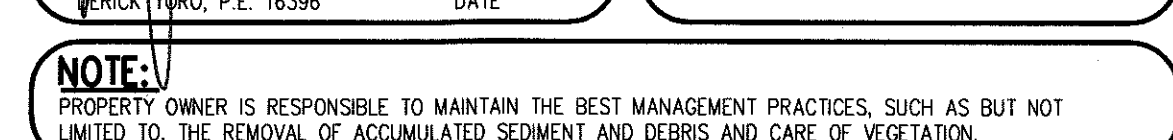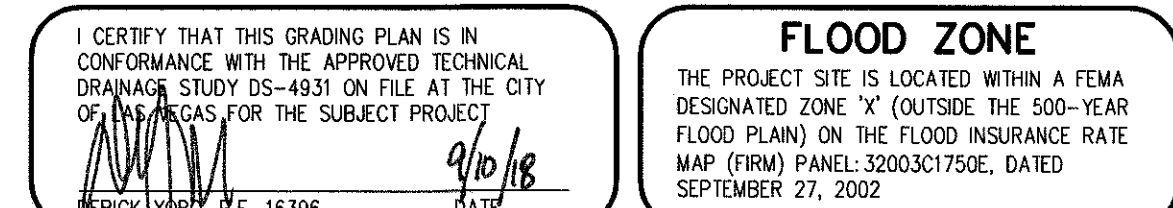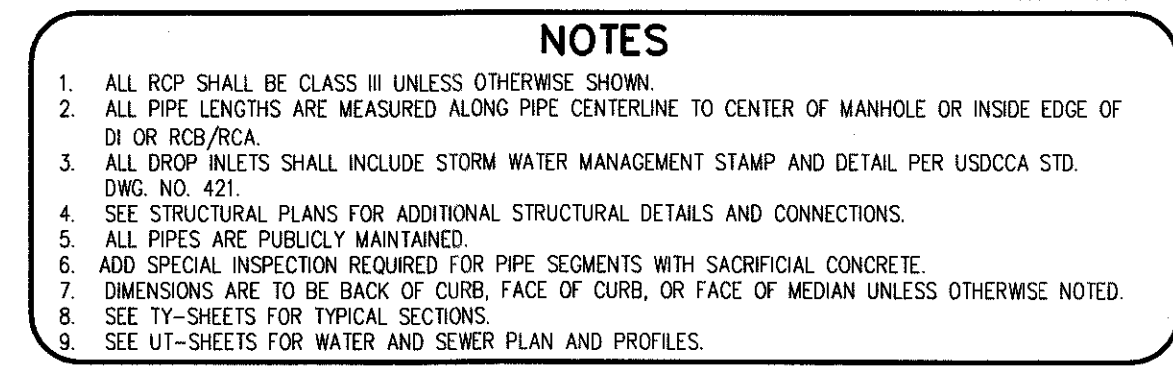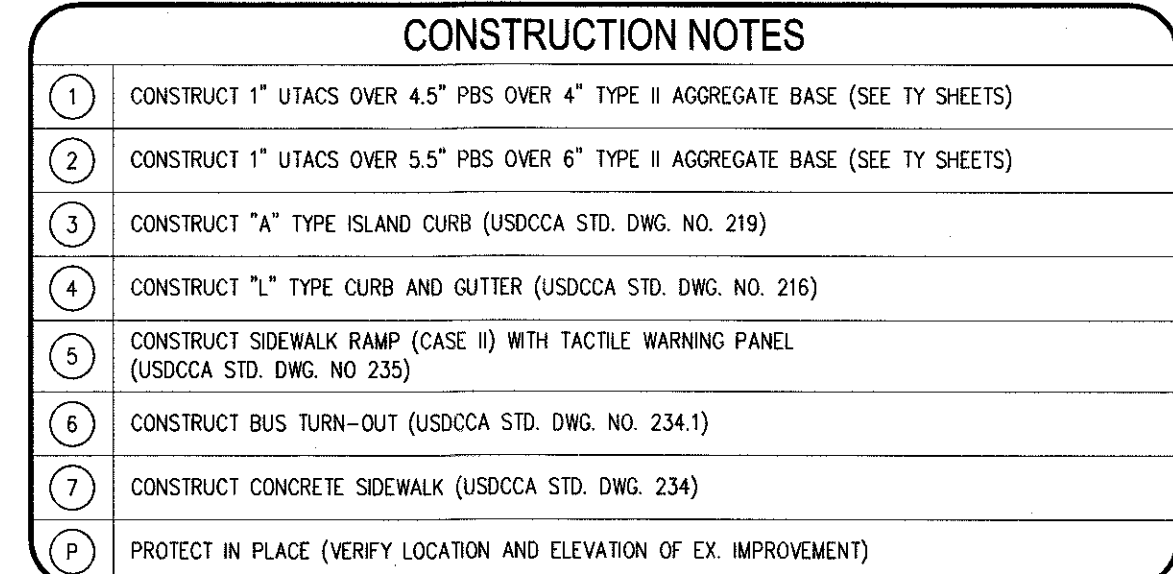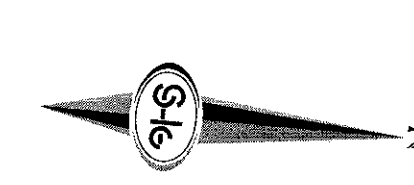


NO.	DESCRIPTION	DATE	BY	APP.


NINETY-FIVE MANAGEMENT LLC
SKYE CANYON PHASE 3BC
SHAUMBER ROAD
STORM DRAIN LATERALS I



DATE: 9/8/18
DRAFTER: HF
DESIGNER: HF
CHECKED: DY
PROJECT NO.
OLY1609-000

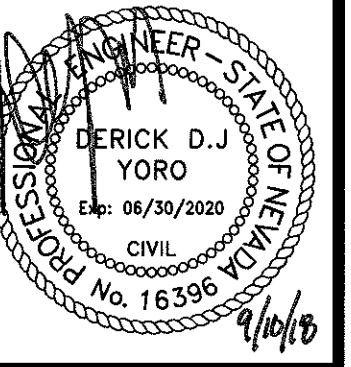


LAT-01
SHEET 14 OF 36

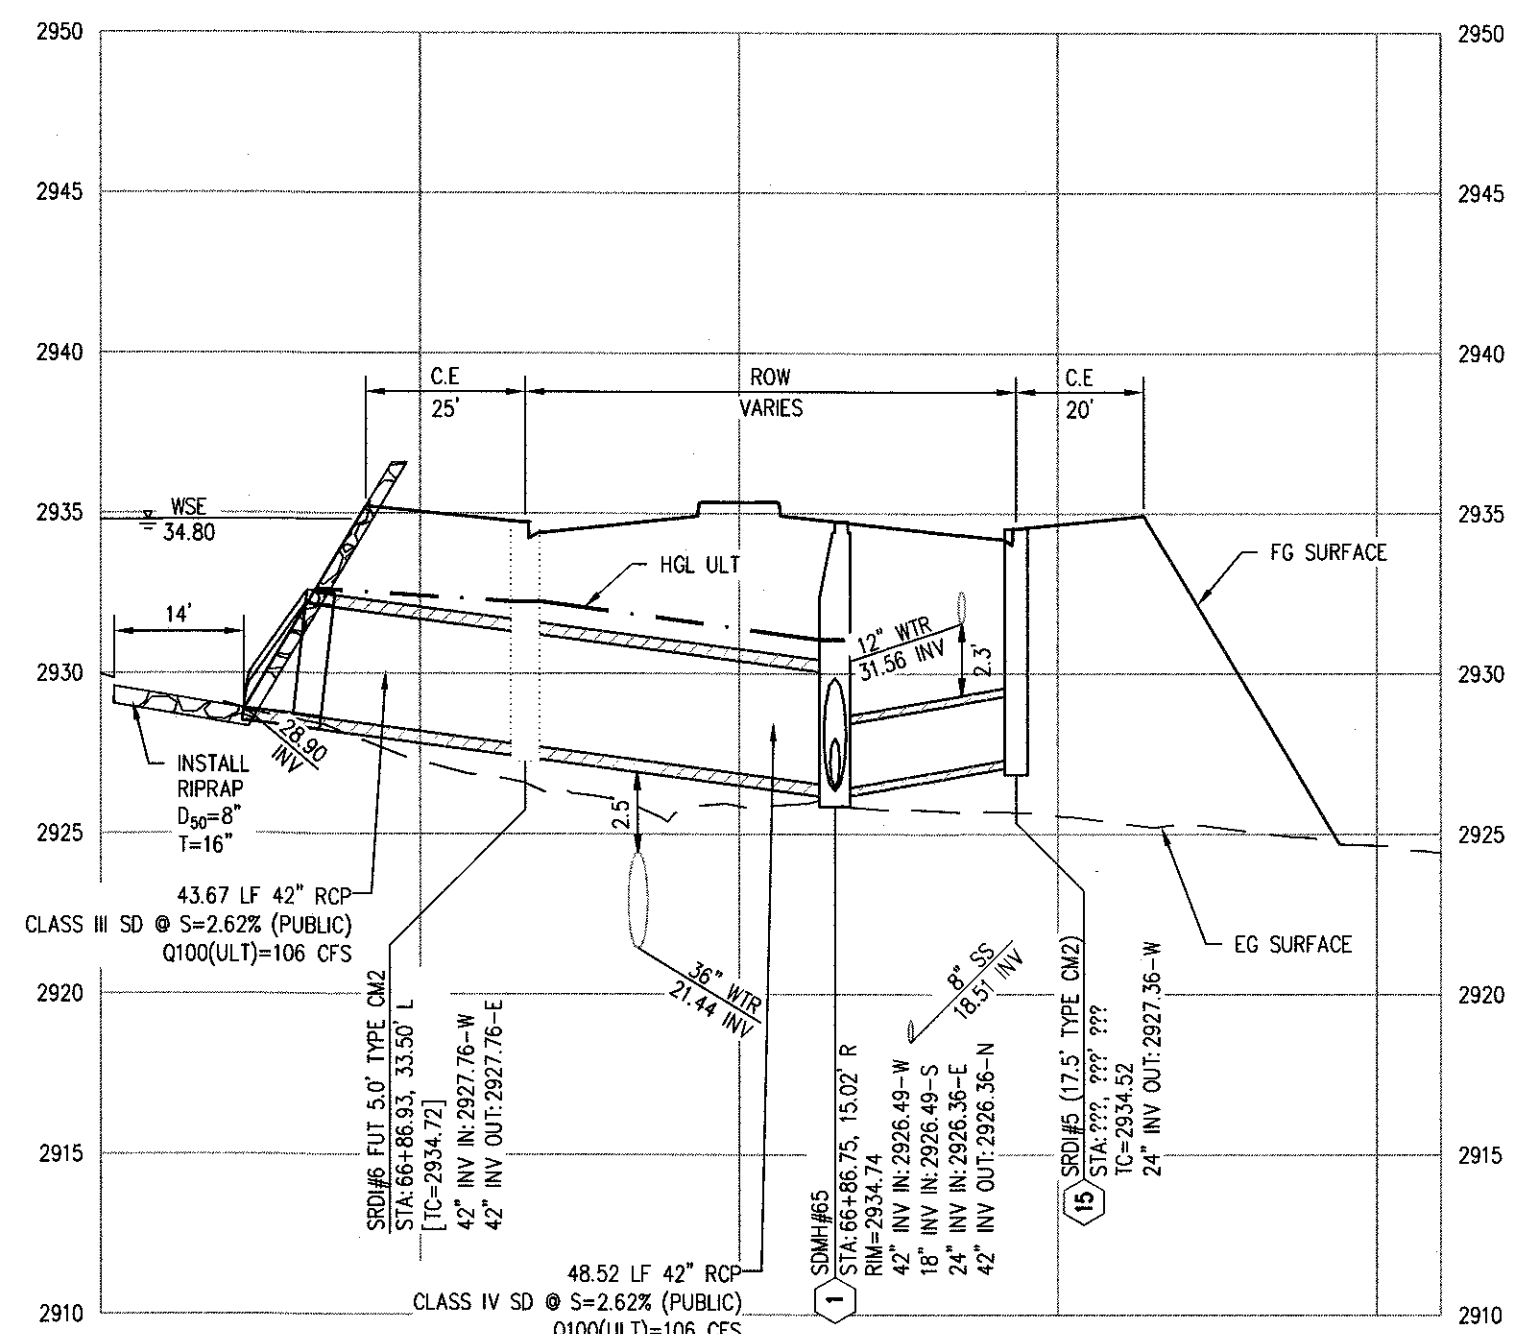

SHAUMBER RD
STORM DRAIN @ 66+86.75

SCALE: HORIZ. 1"=30' VERT. 1"=6'
SEE SHEET: PP-08


6

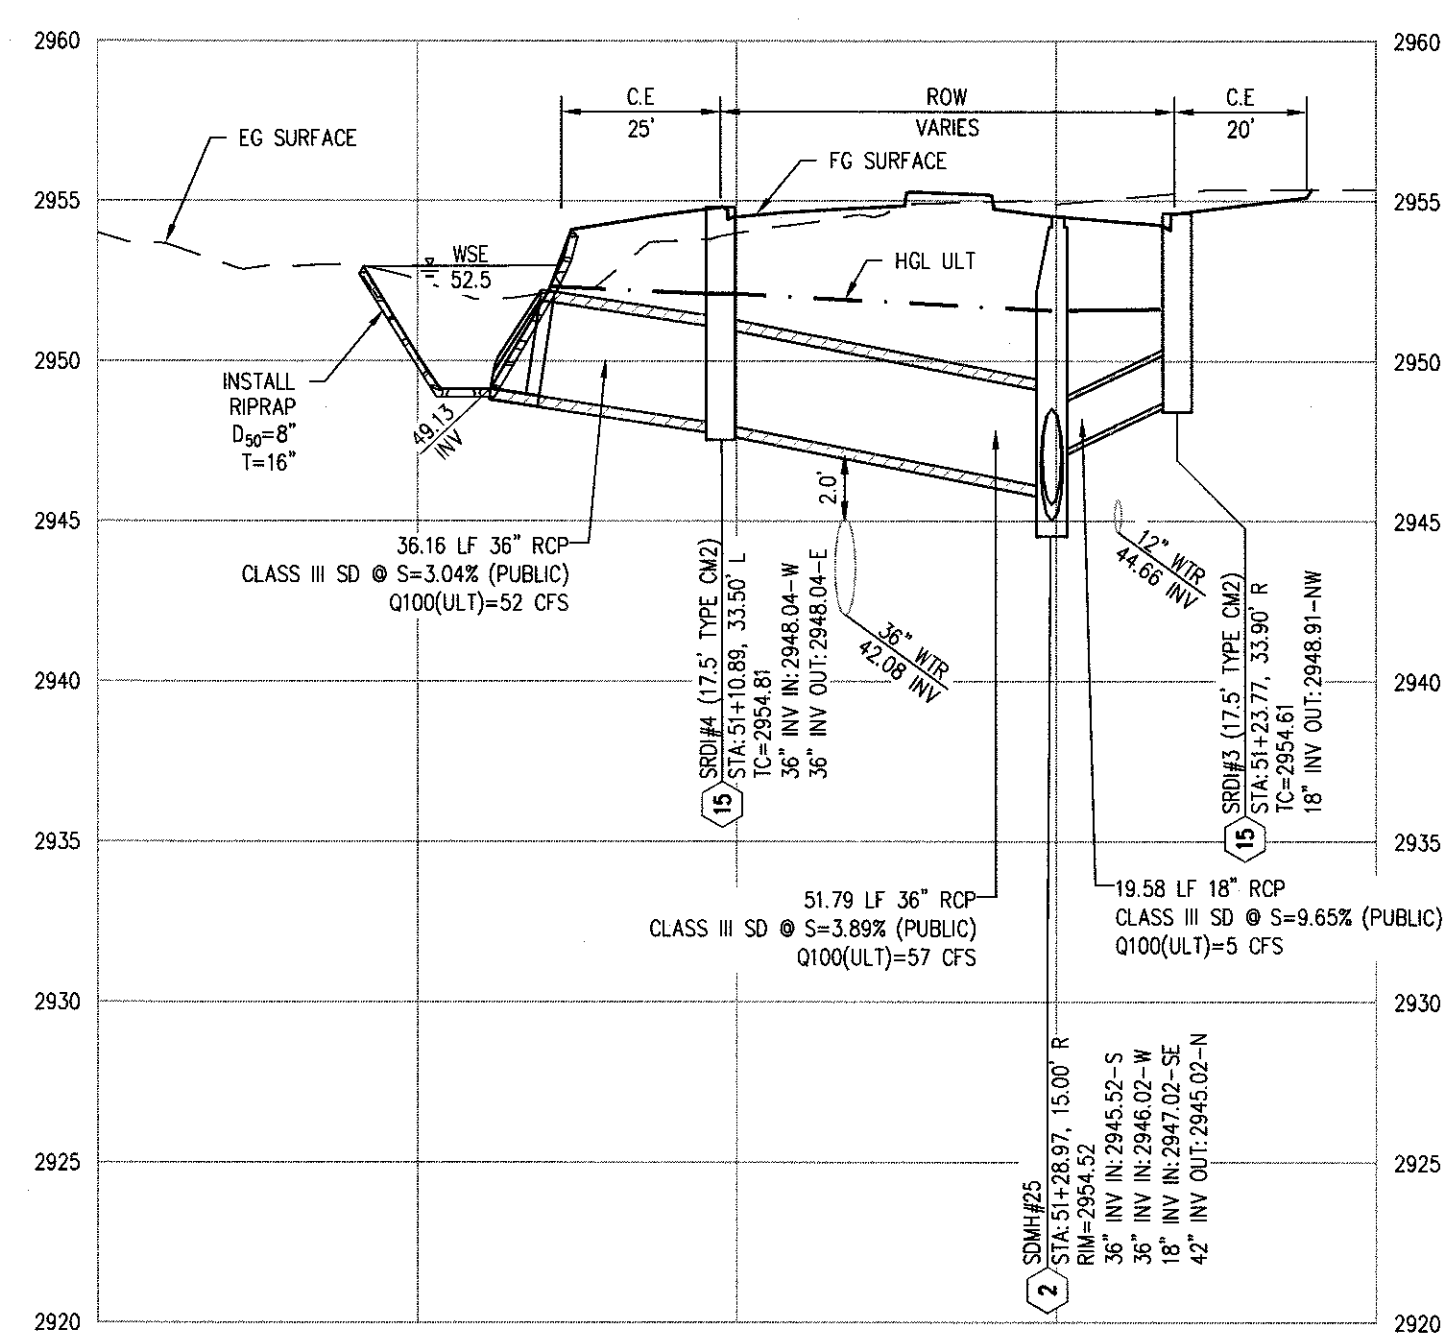

SHAUMBER RD
STORM DRAIN @ 51+28.97

SCALE: HORIZ. 1"=30' VERT. 1"=6'
SEE SHEET: PP-05


4

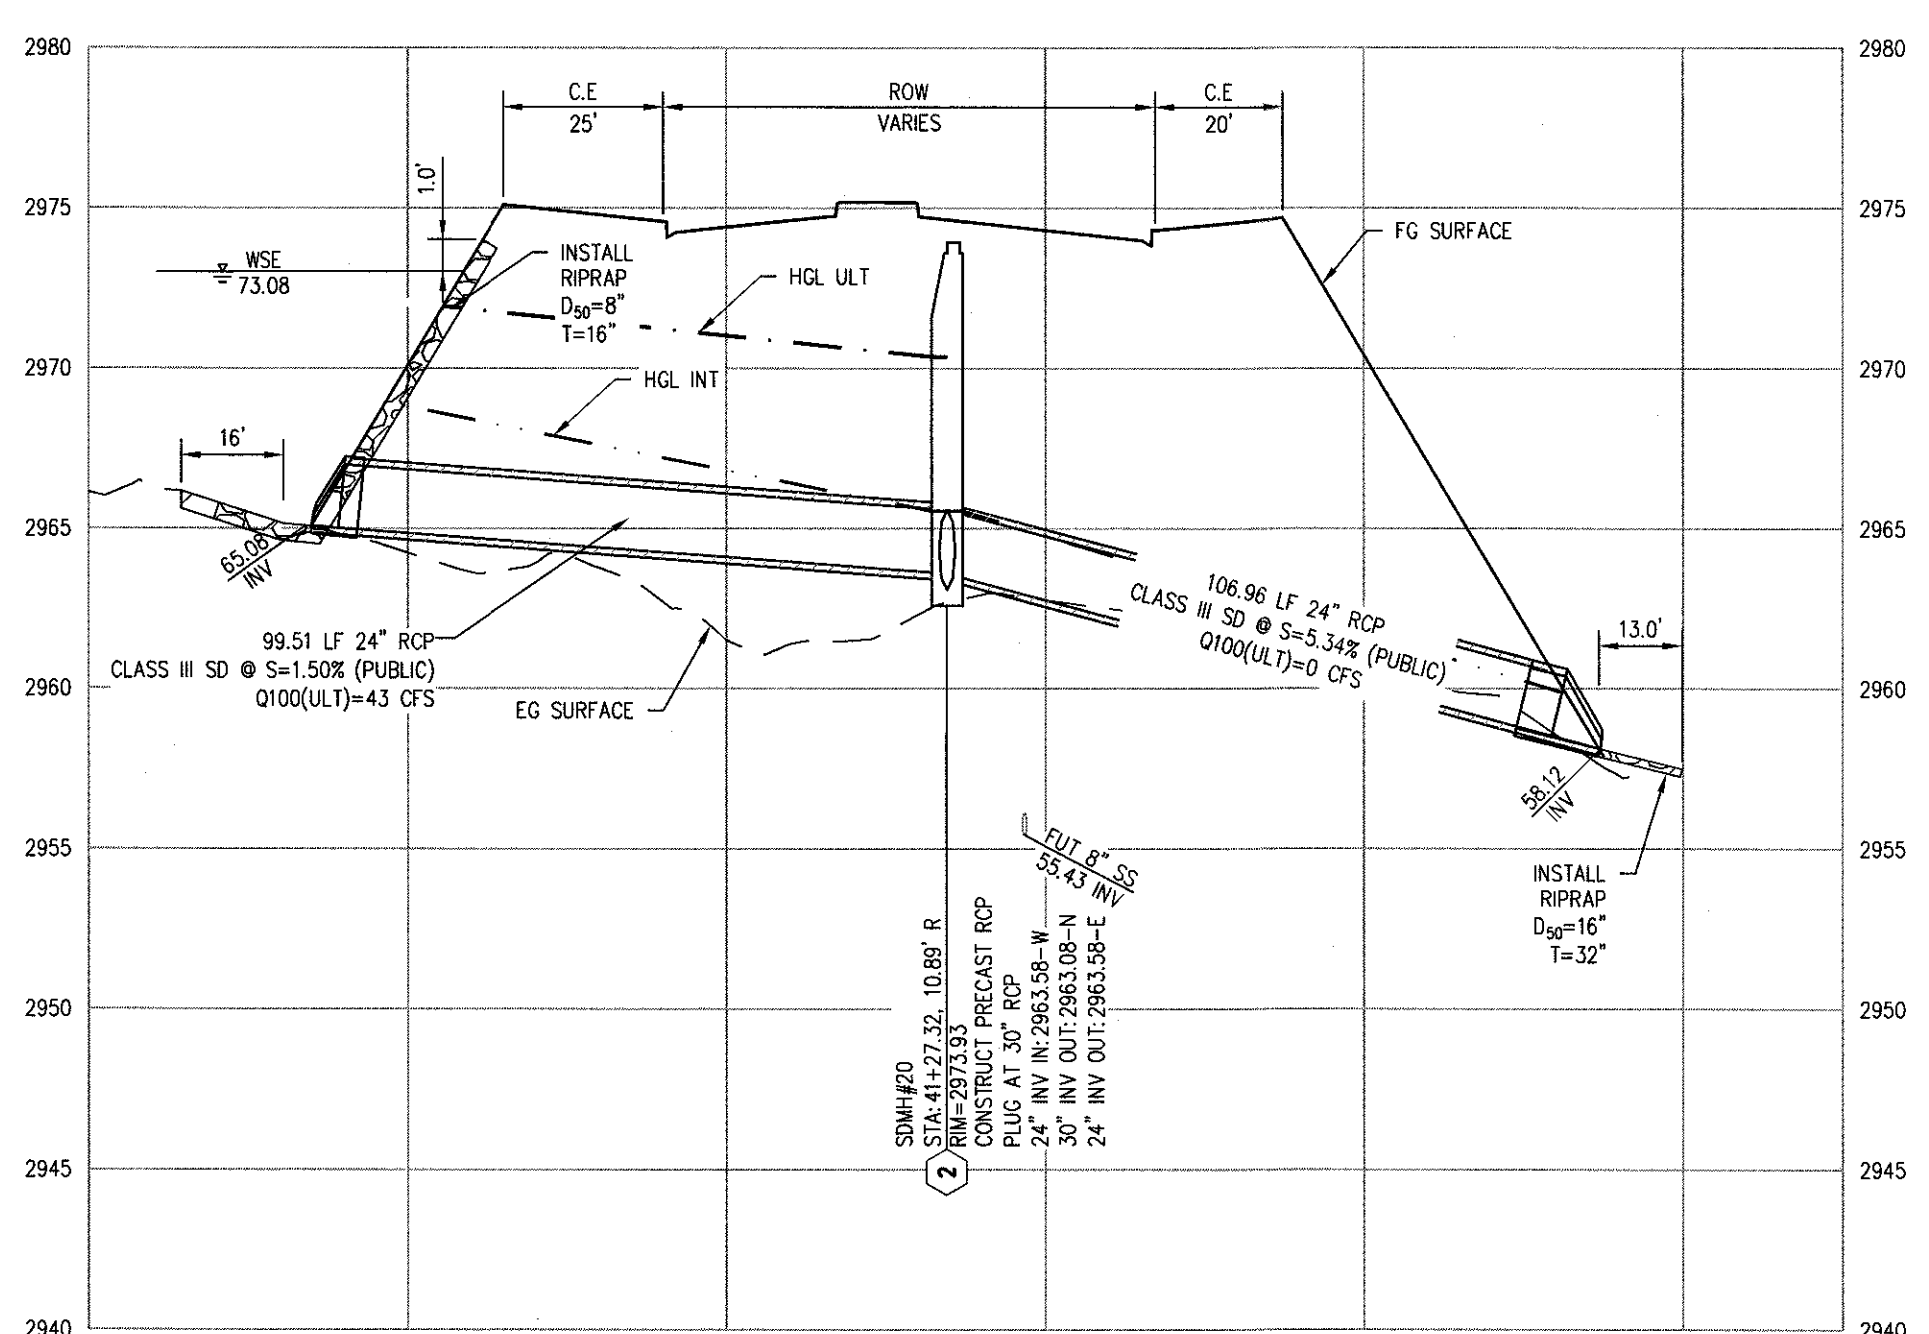

SHAUMBER RD
STORM DRAIN @ 41+27.32

SCALE: HORIZ. 1"=30' VERT. 1"=6'
SEE SHEET: PP-04


2

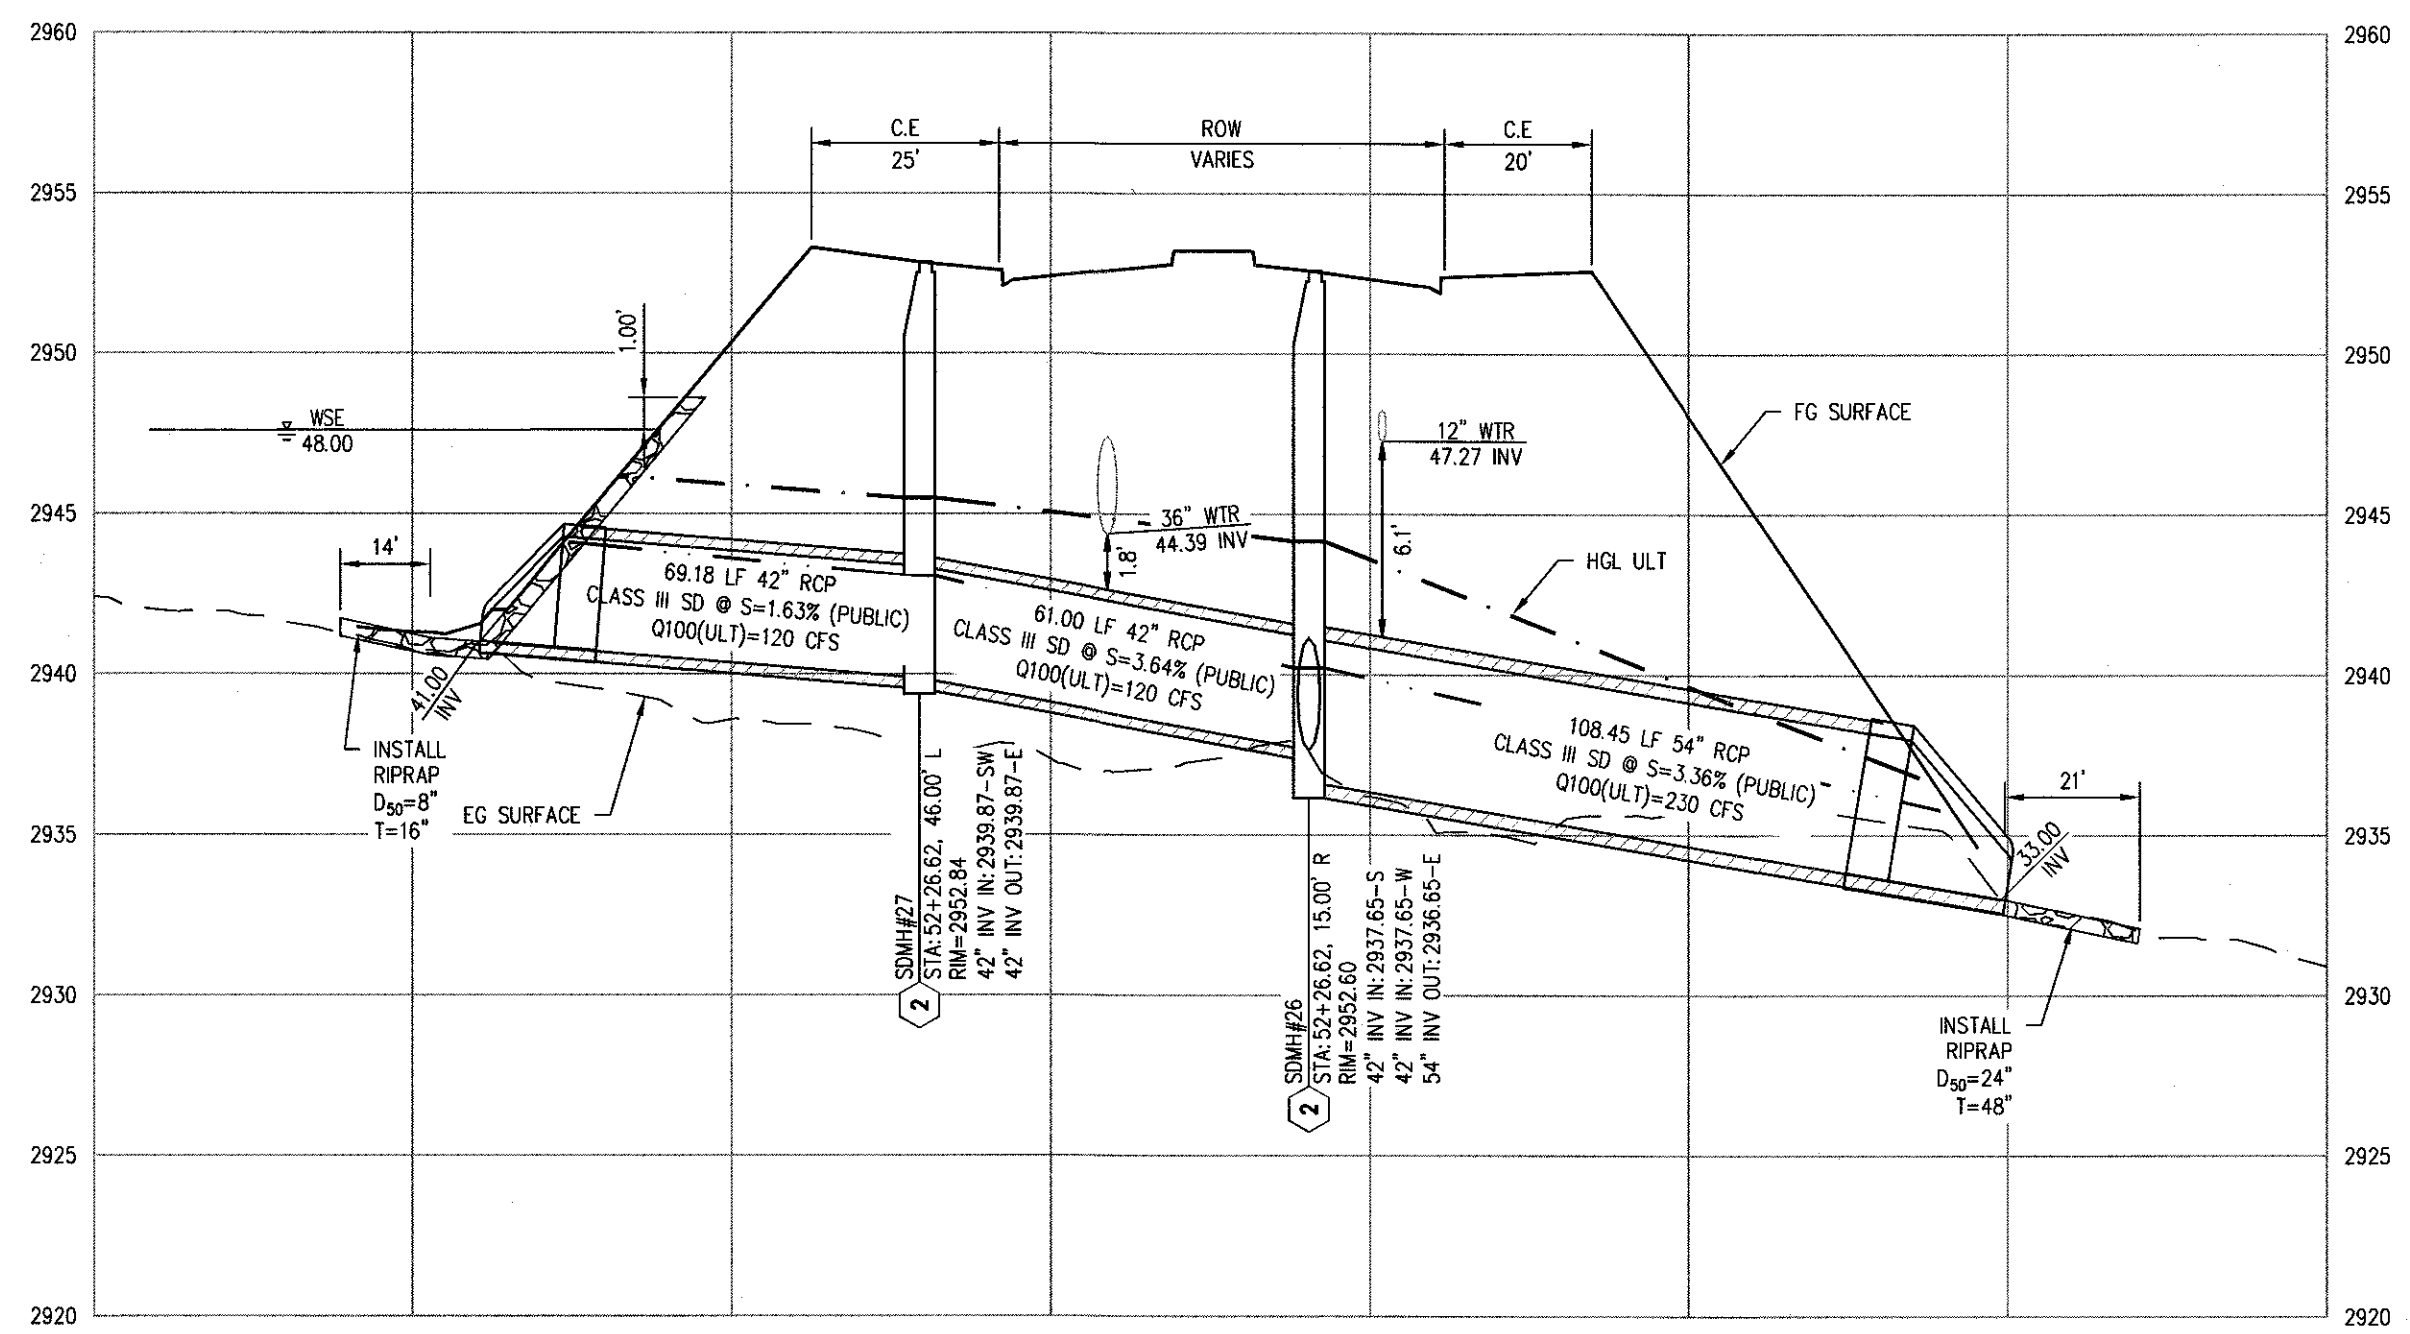

SHAUMBER RD
STORM DRAIN @ 52+26.62

SCALE: HORIZ. 1"=30' VERT. 1"=6'
SEE SHEET: PP-05


5

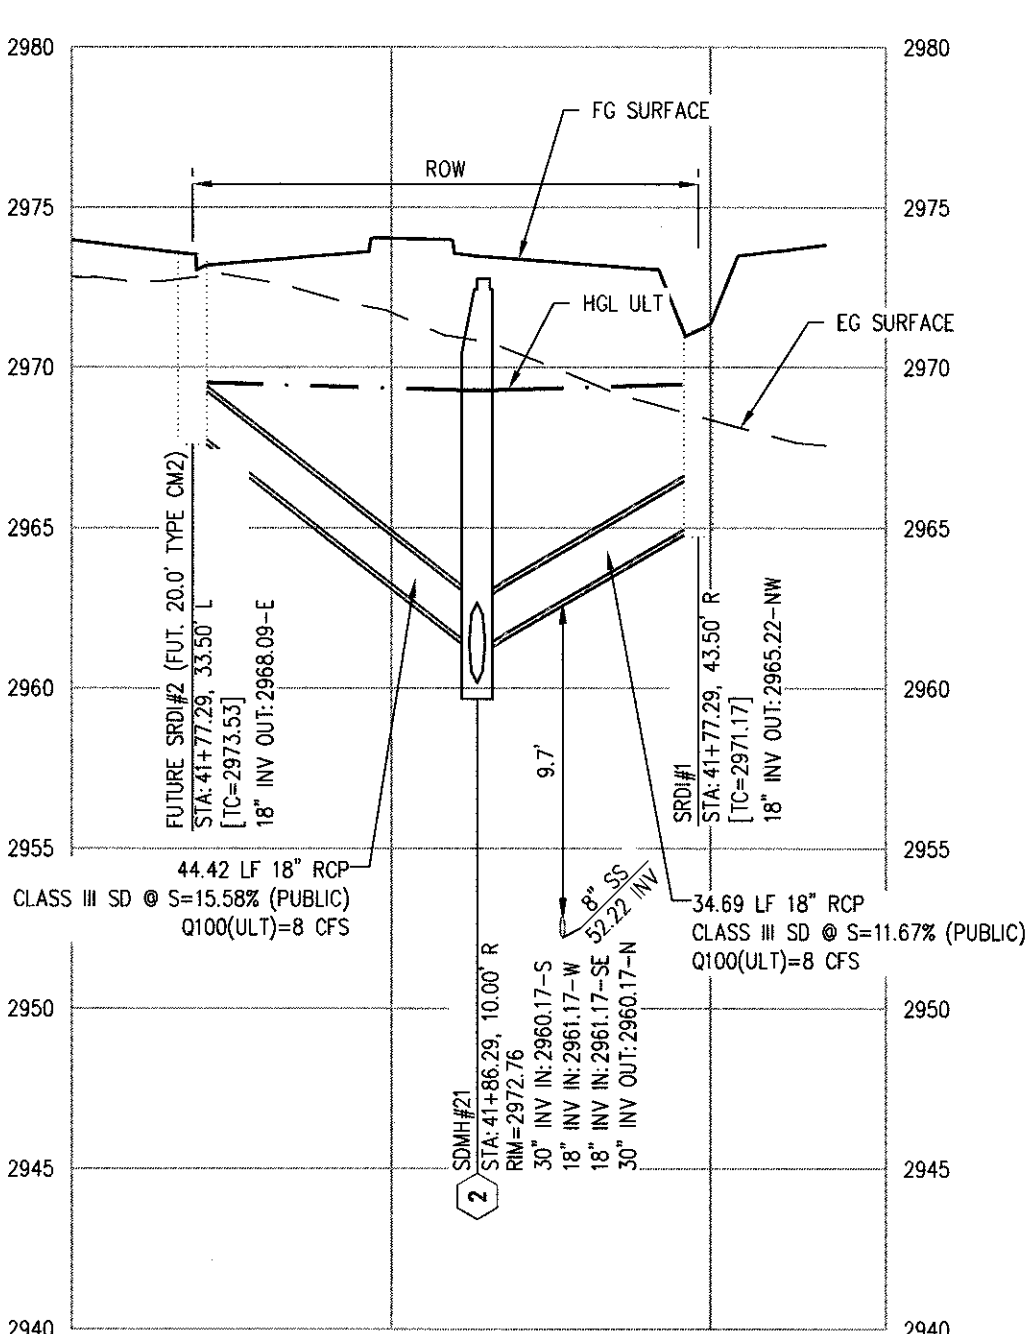

SHAUMBER RD
STORM DRAIN @ 41+86.29

SCALE: HORIZ. 1"=30' VERT. 1"=6'
SEE SHEET: PP-04

3

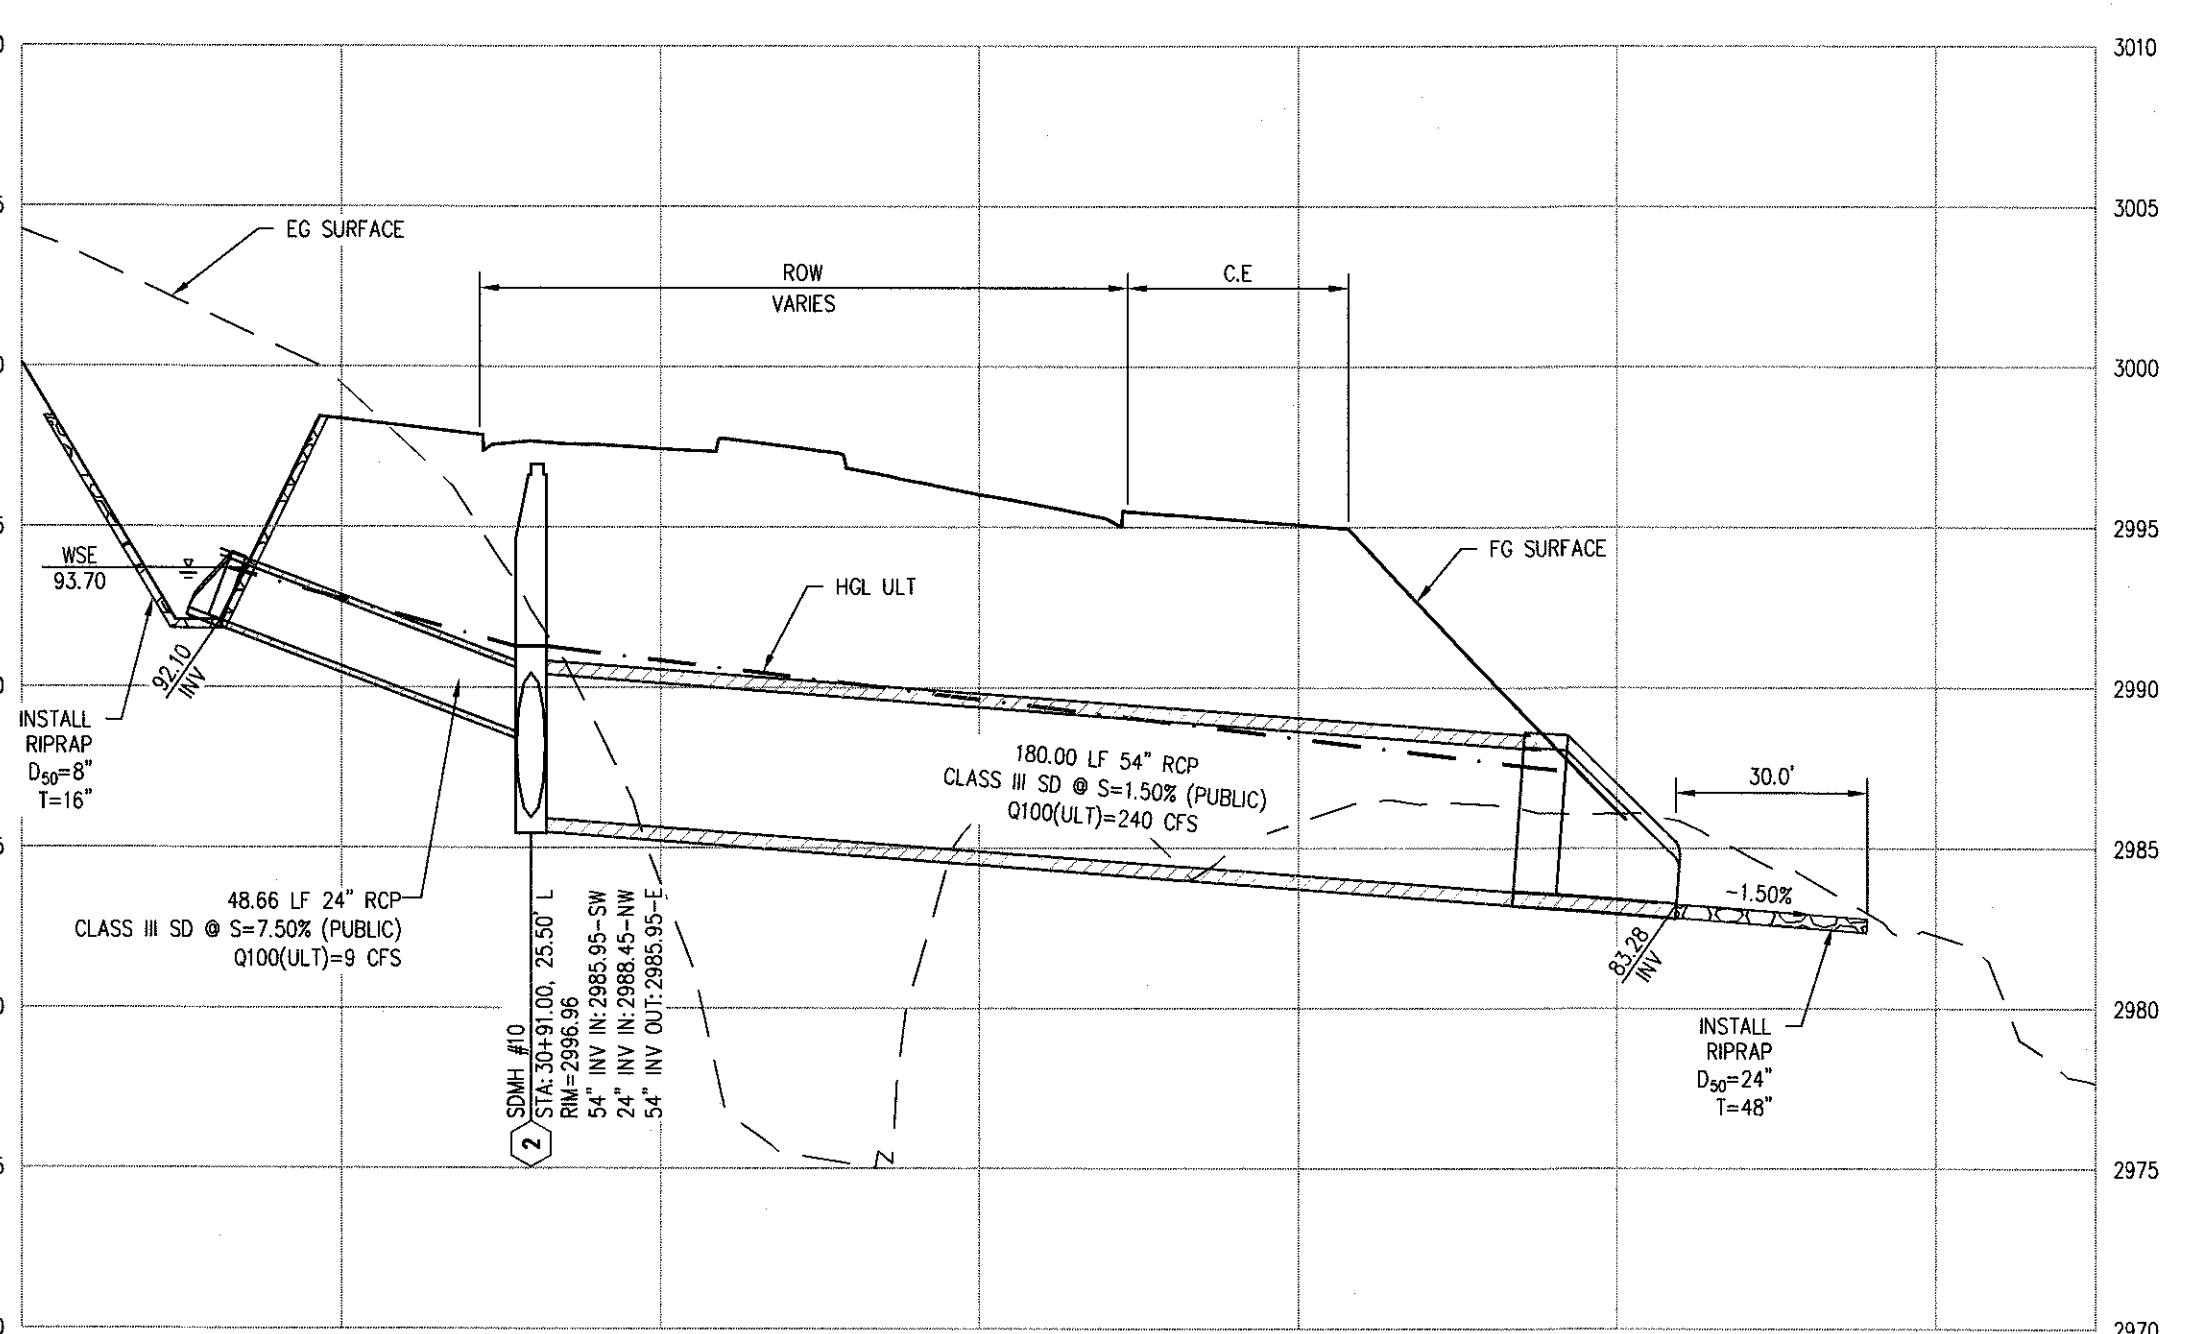

SHAUMBER RD
STORM DRAIN @ 30+91.00

SCALE: HORIZ. 1"=30' VERT. 1"=6'
SEE SHEET: PP-02


1

[illegible]


**SKYE CANYON PHASE 3BC
SHAUMBER ROAD
STORM DRAIN LATERALS II**



OLY1609-000


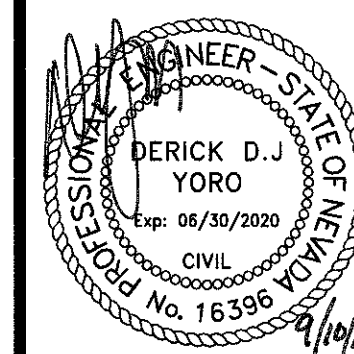


SHEET 15 OF 36

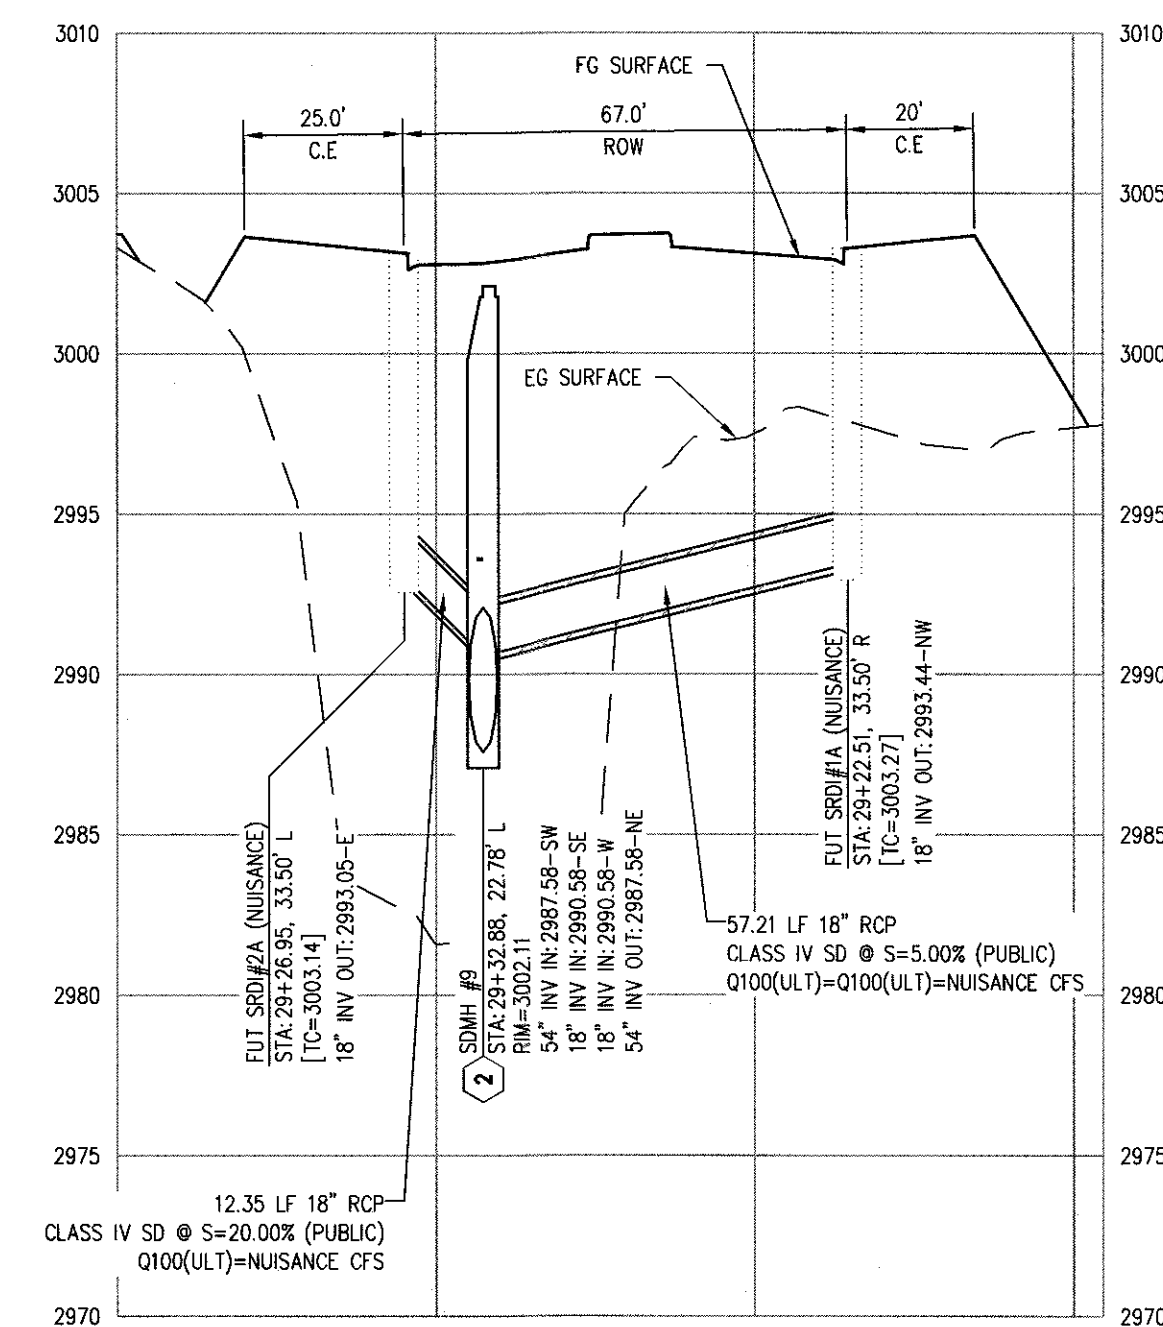



SHAUMBER RD
STORM DRAIN @ 29+32.28

 SCALE: HORZ. 1"=30' VERT. 1"=6'
SEE SHEET: PP-02

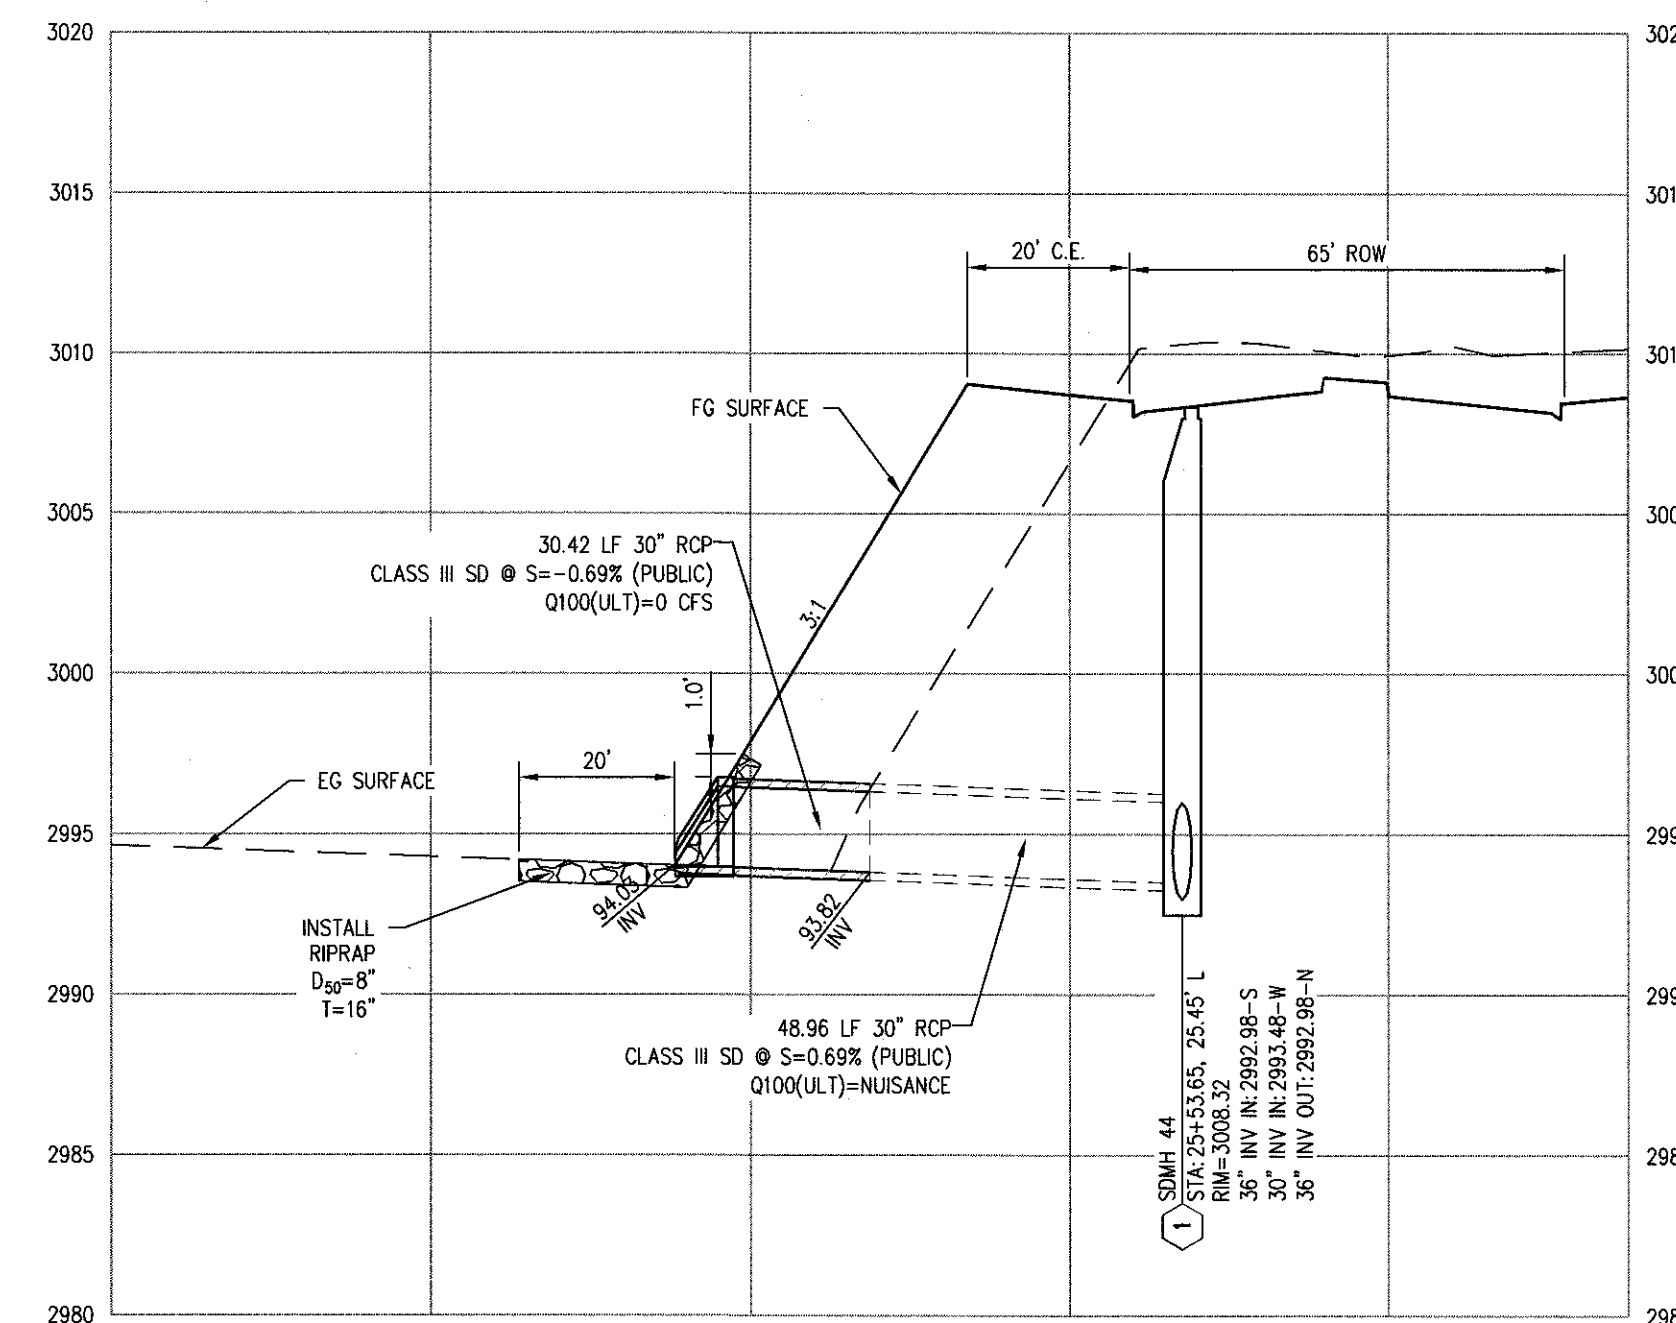


SHAUMBER RD
STORM DRAIN @ 25+27.48

 
SCALE: HORZ. 1"=30' VERT. 1"=6'
SEE SHEET: PP-01

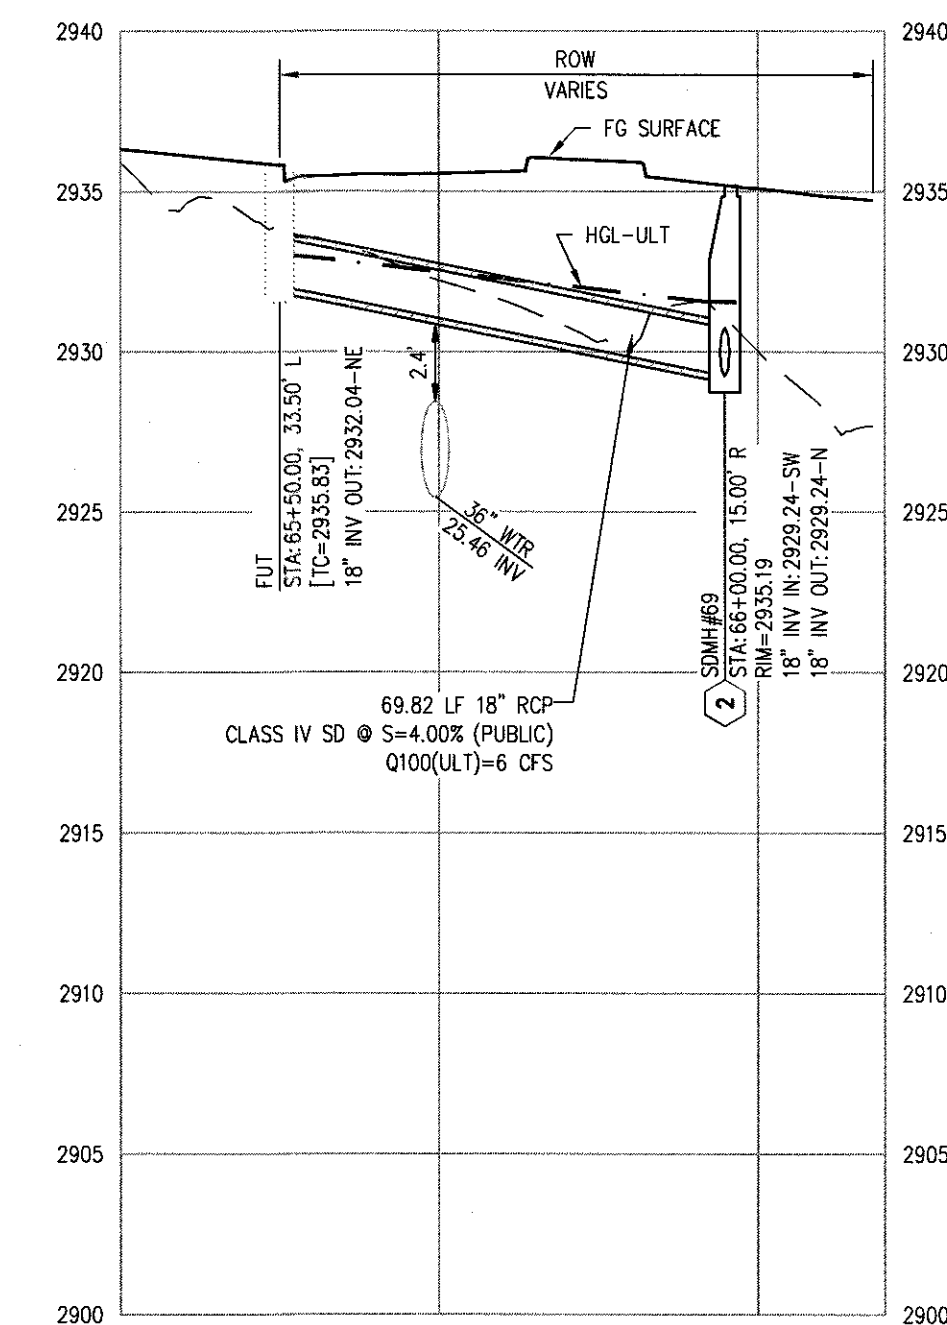


SHAUMBER RD
STORM DRAIN @ 66+00.00

 SCALE: HORIZ. 1"=30' VERT. 1"=6'
SEE SHEET: PP-08




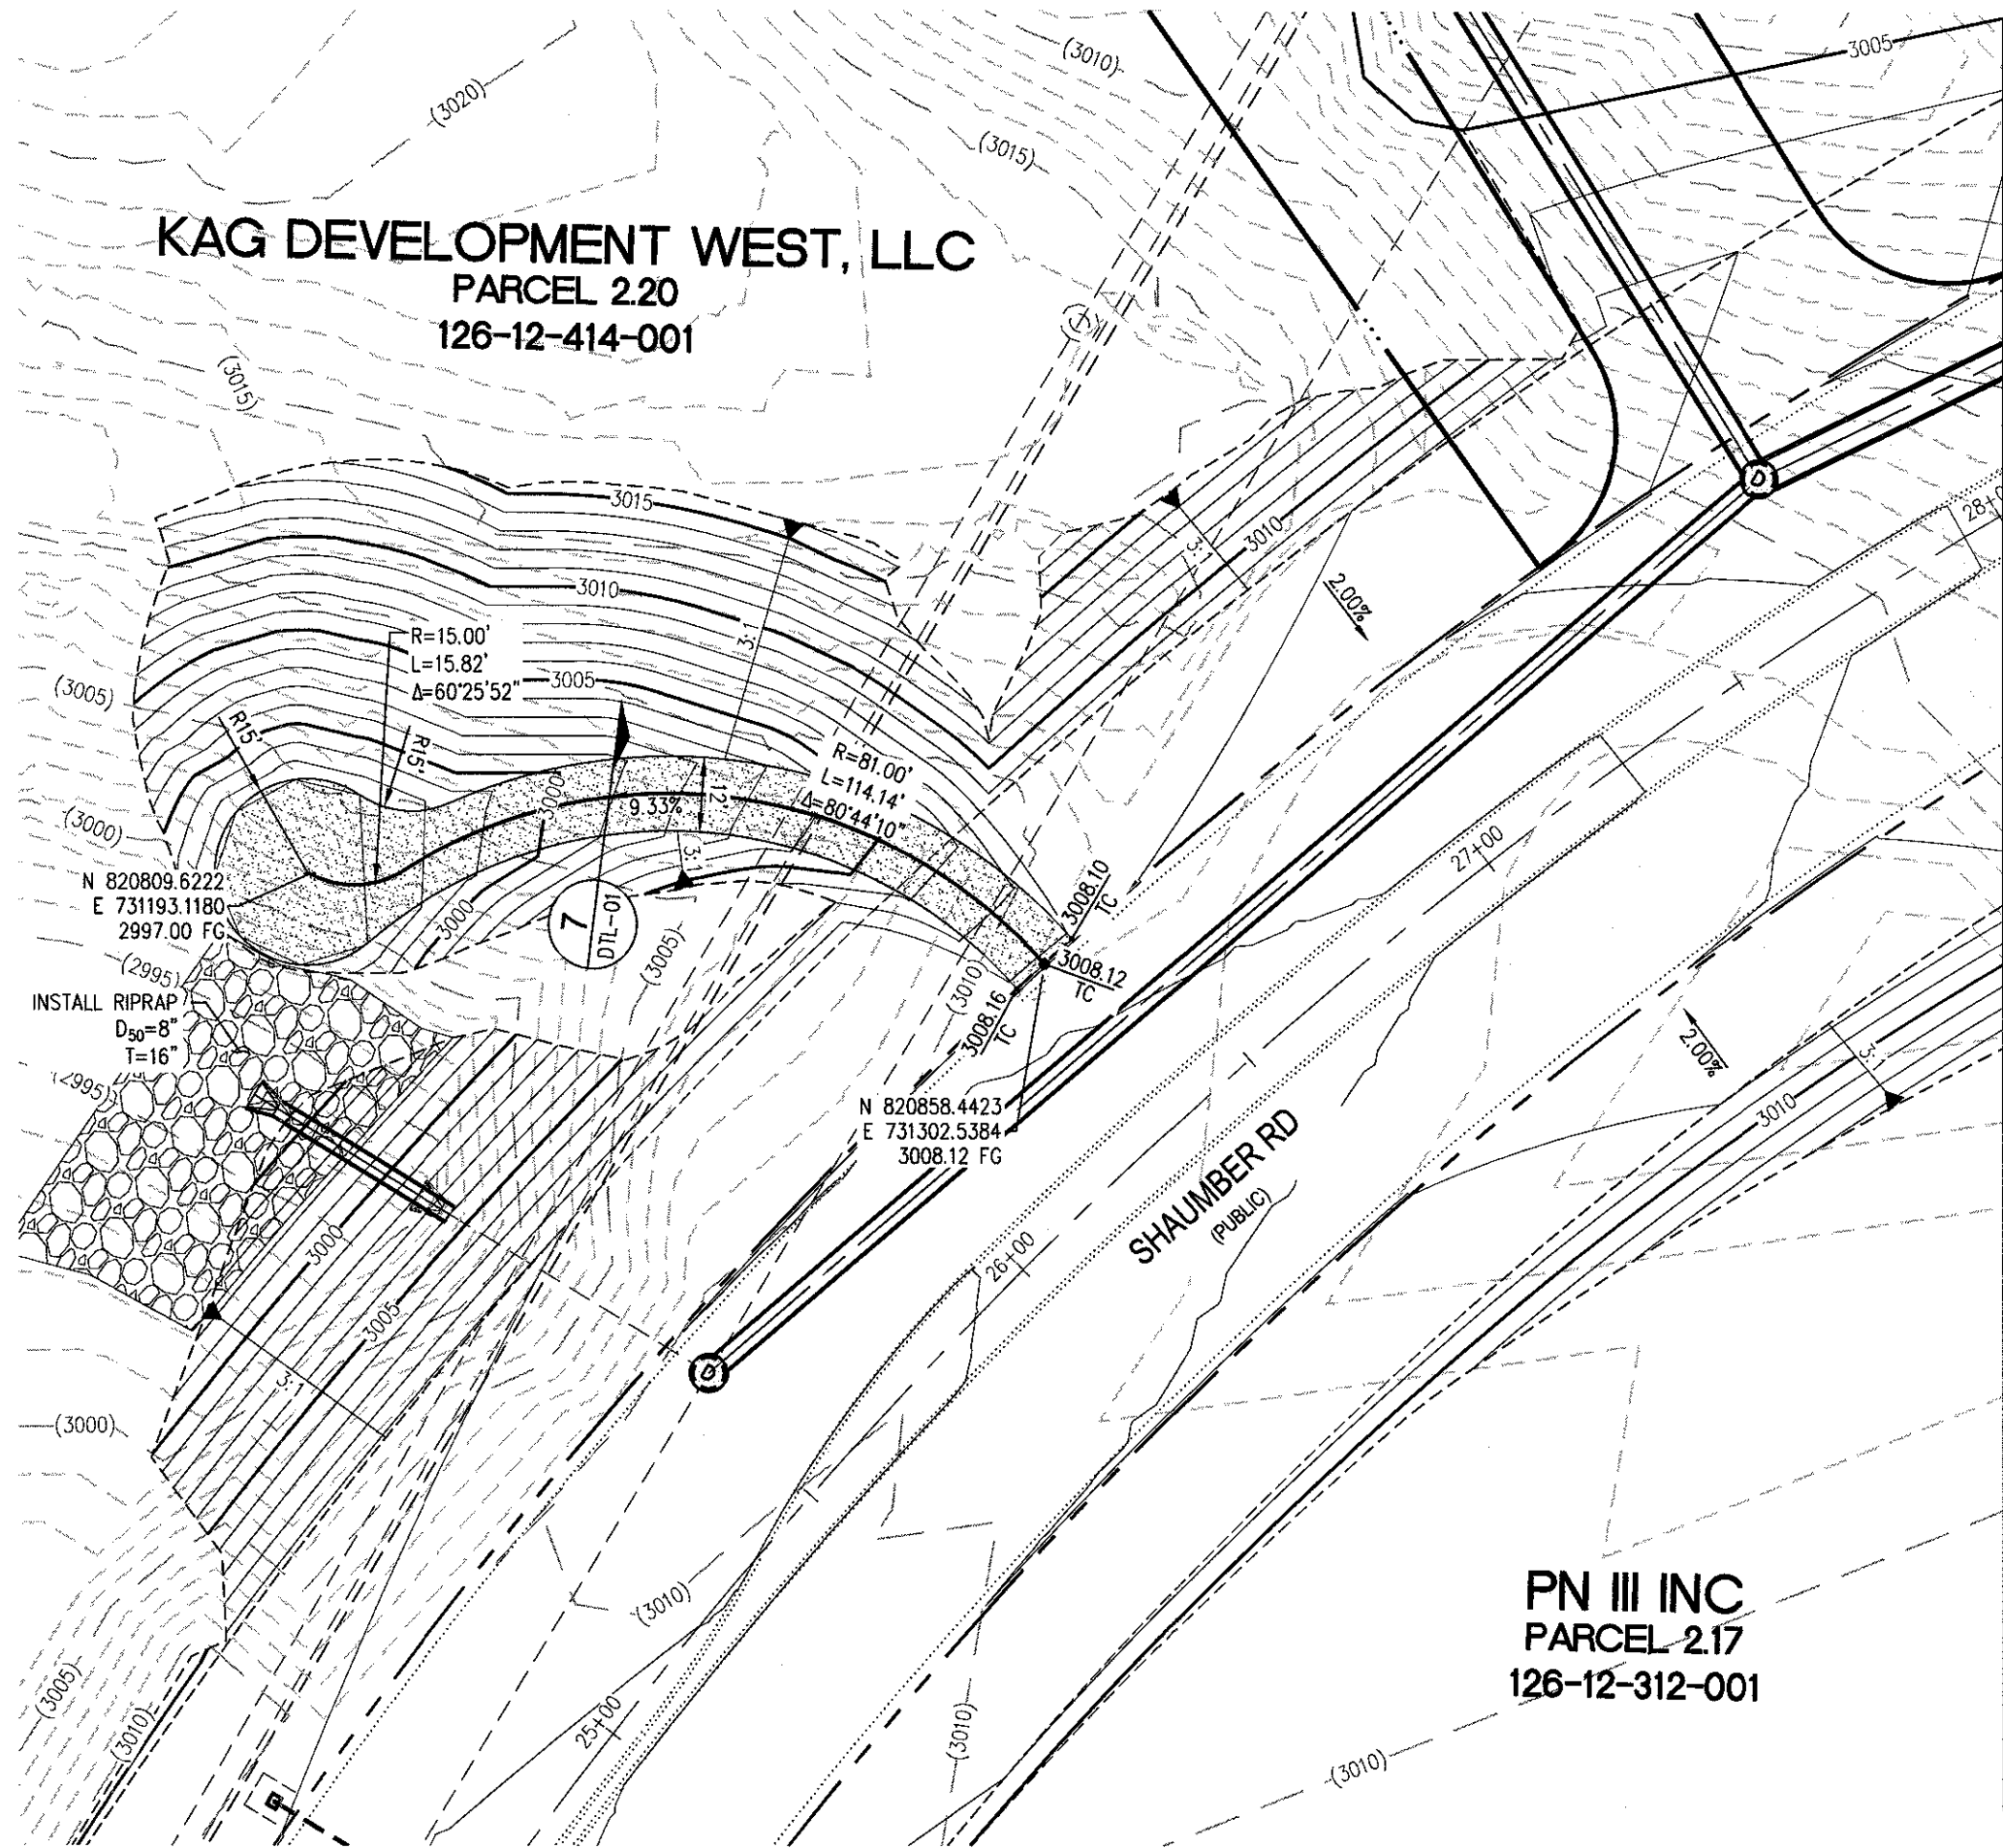


GRADING SITE "A" - PLAN VIEW
HORZ. 1"=30'

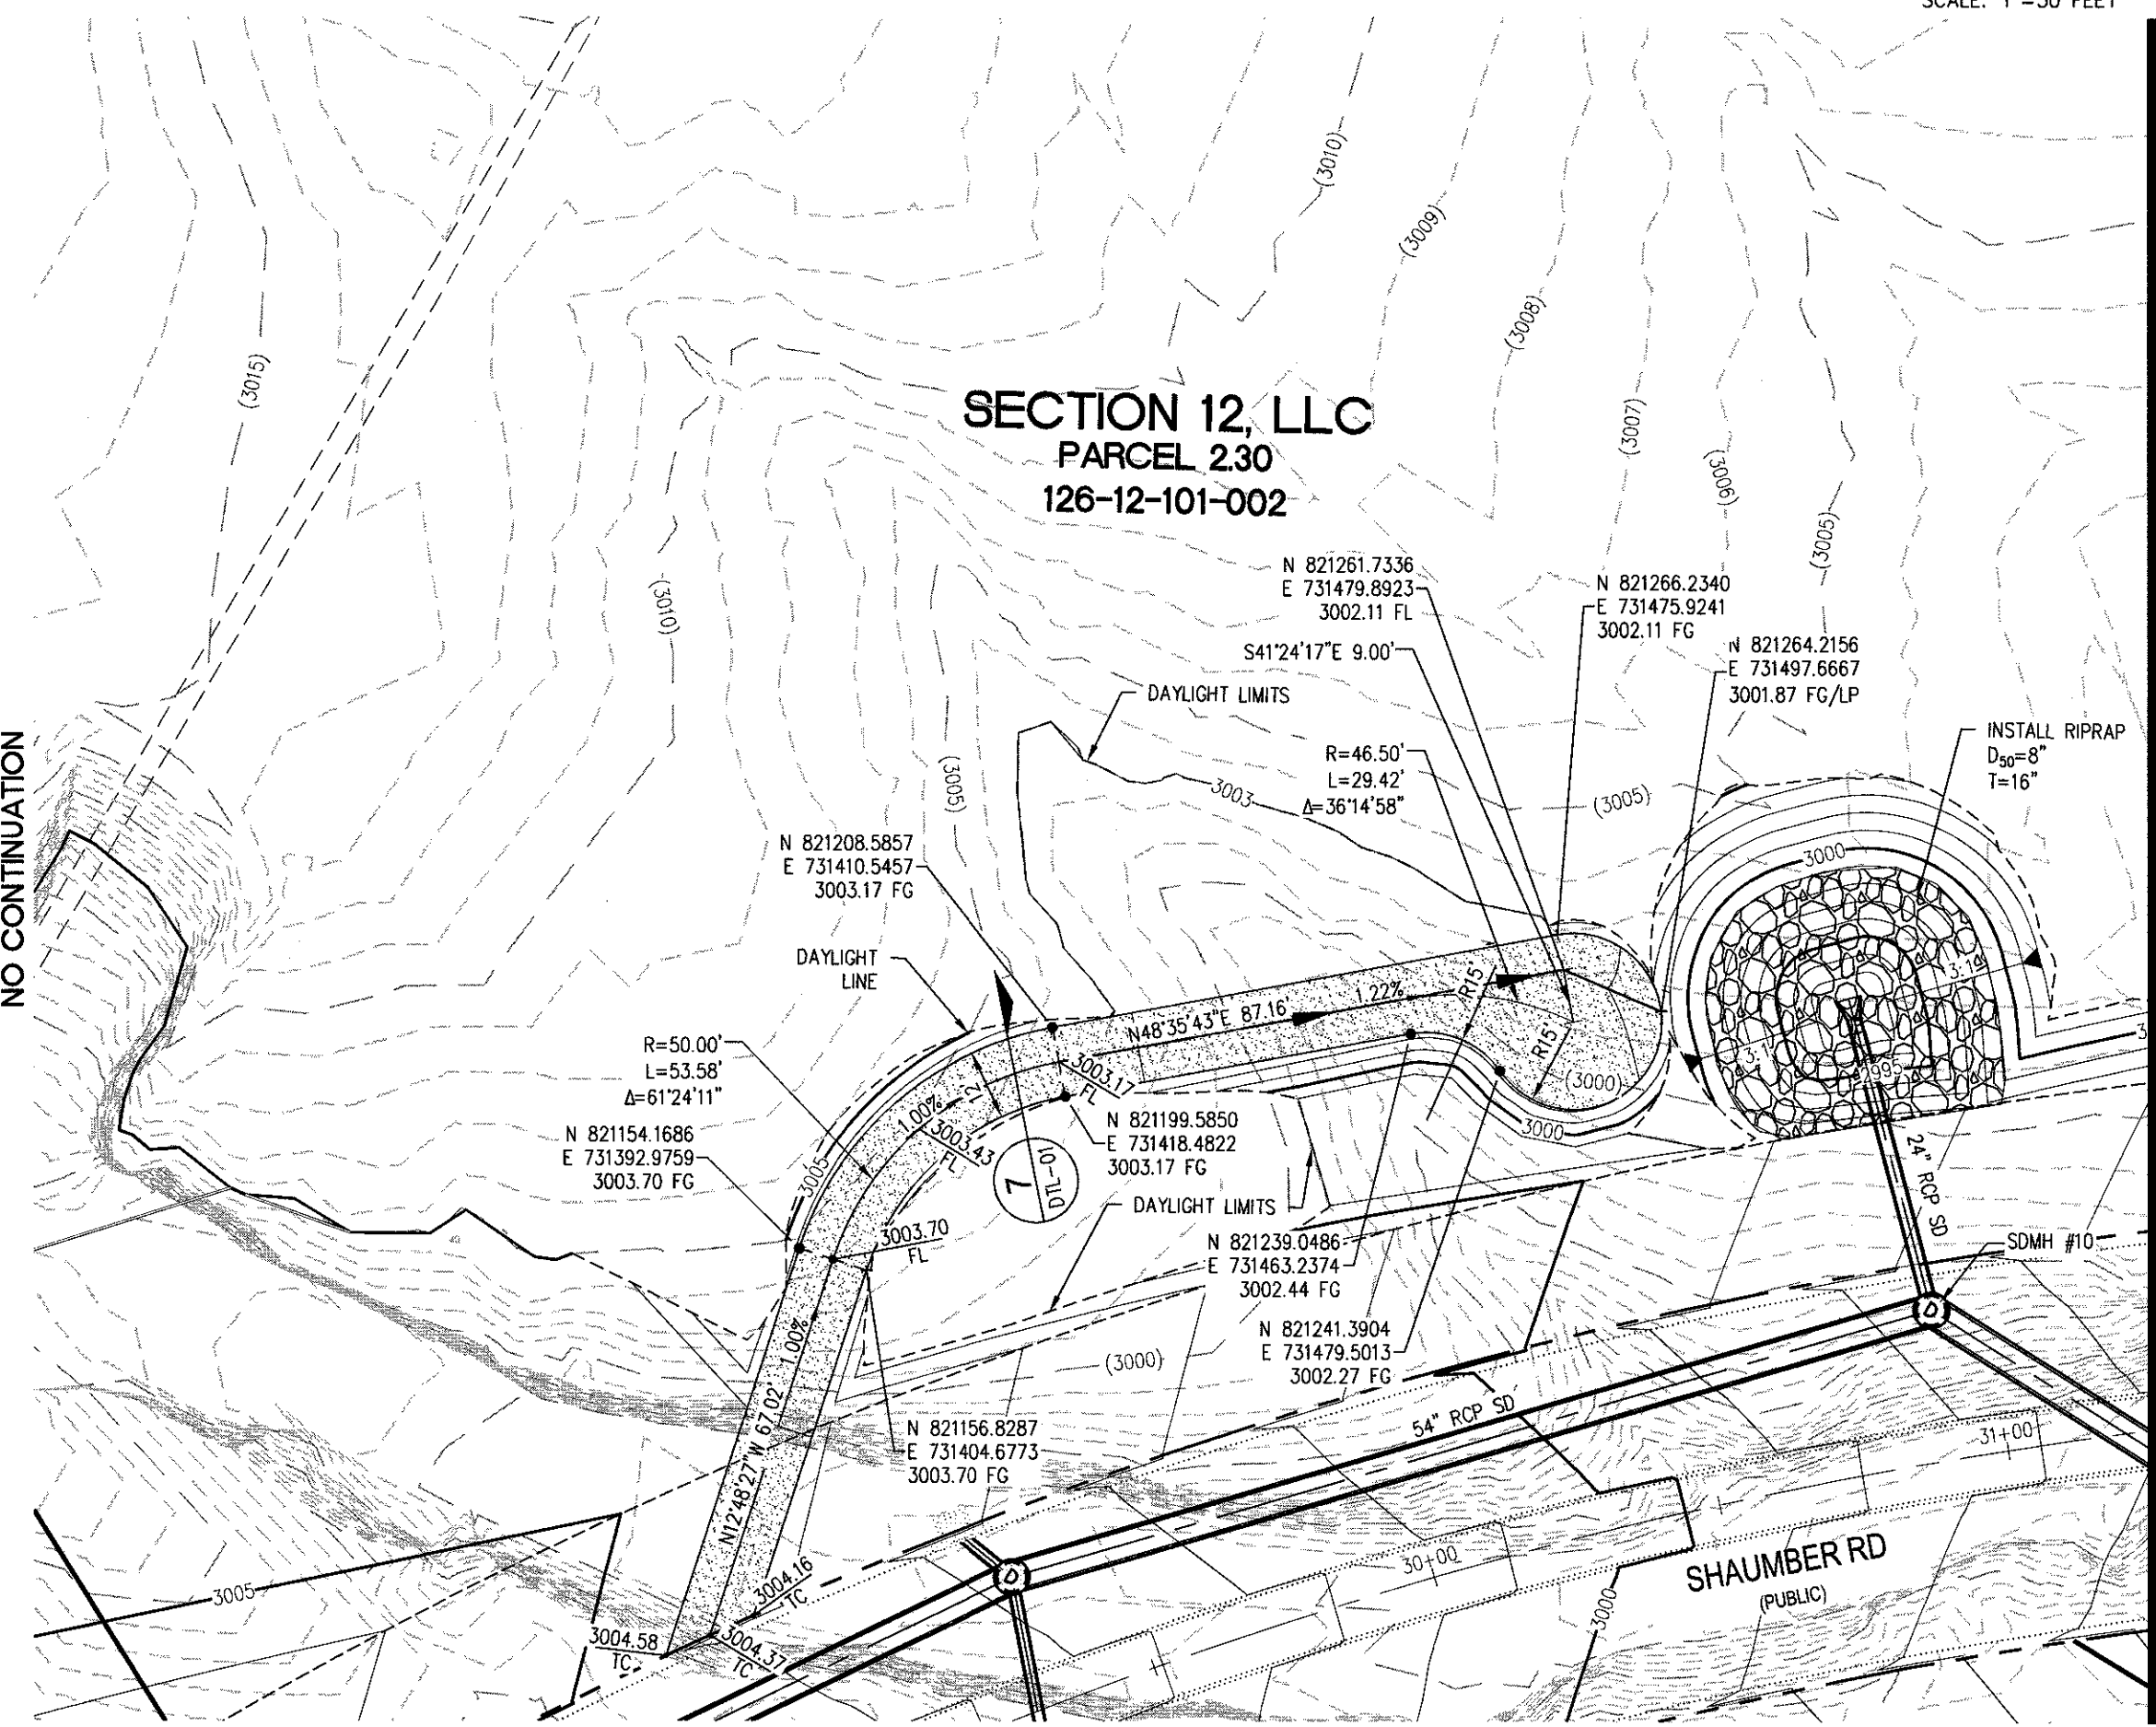

GRADING SITE "B" - PLAN VIEW
HORZ. 1"=30'

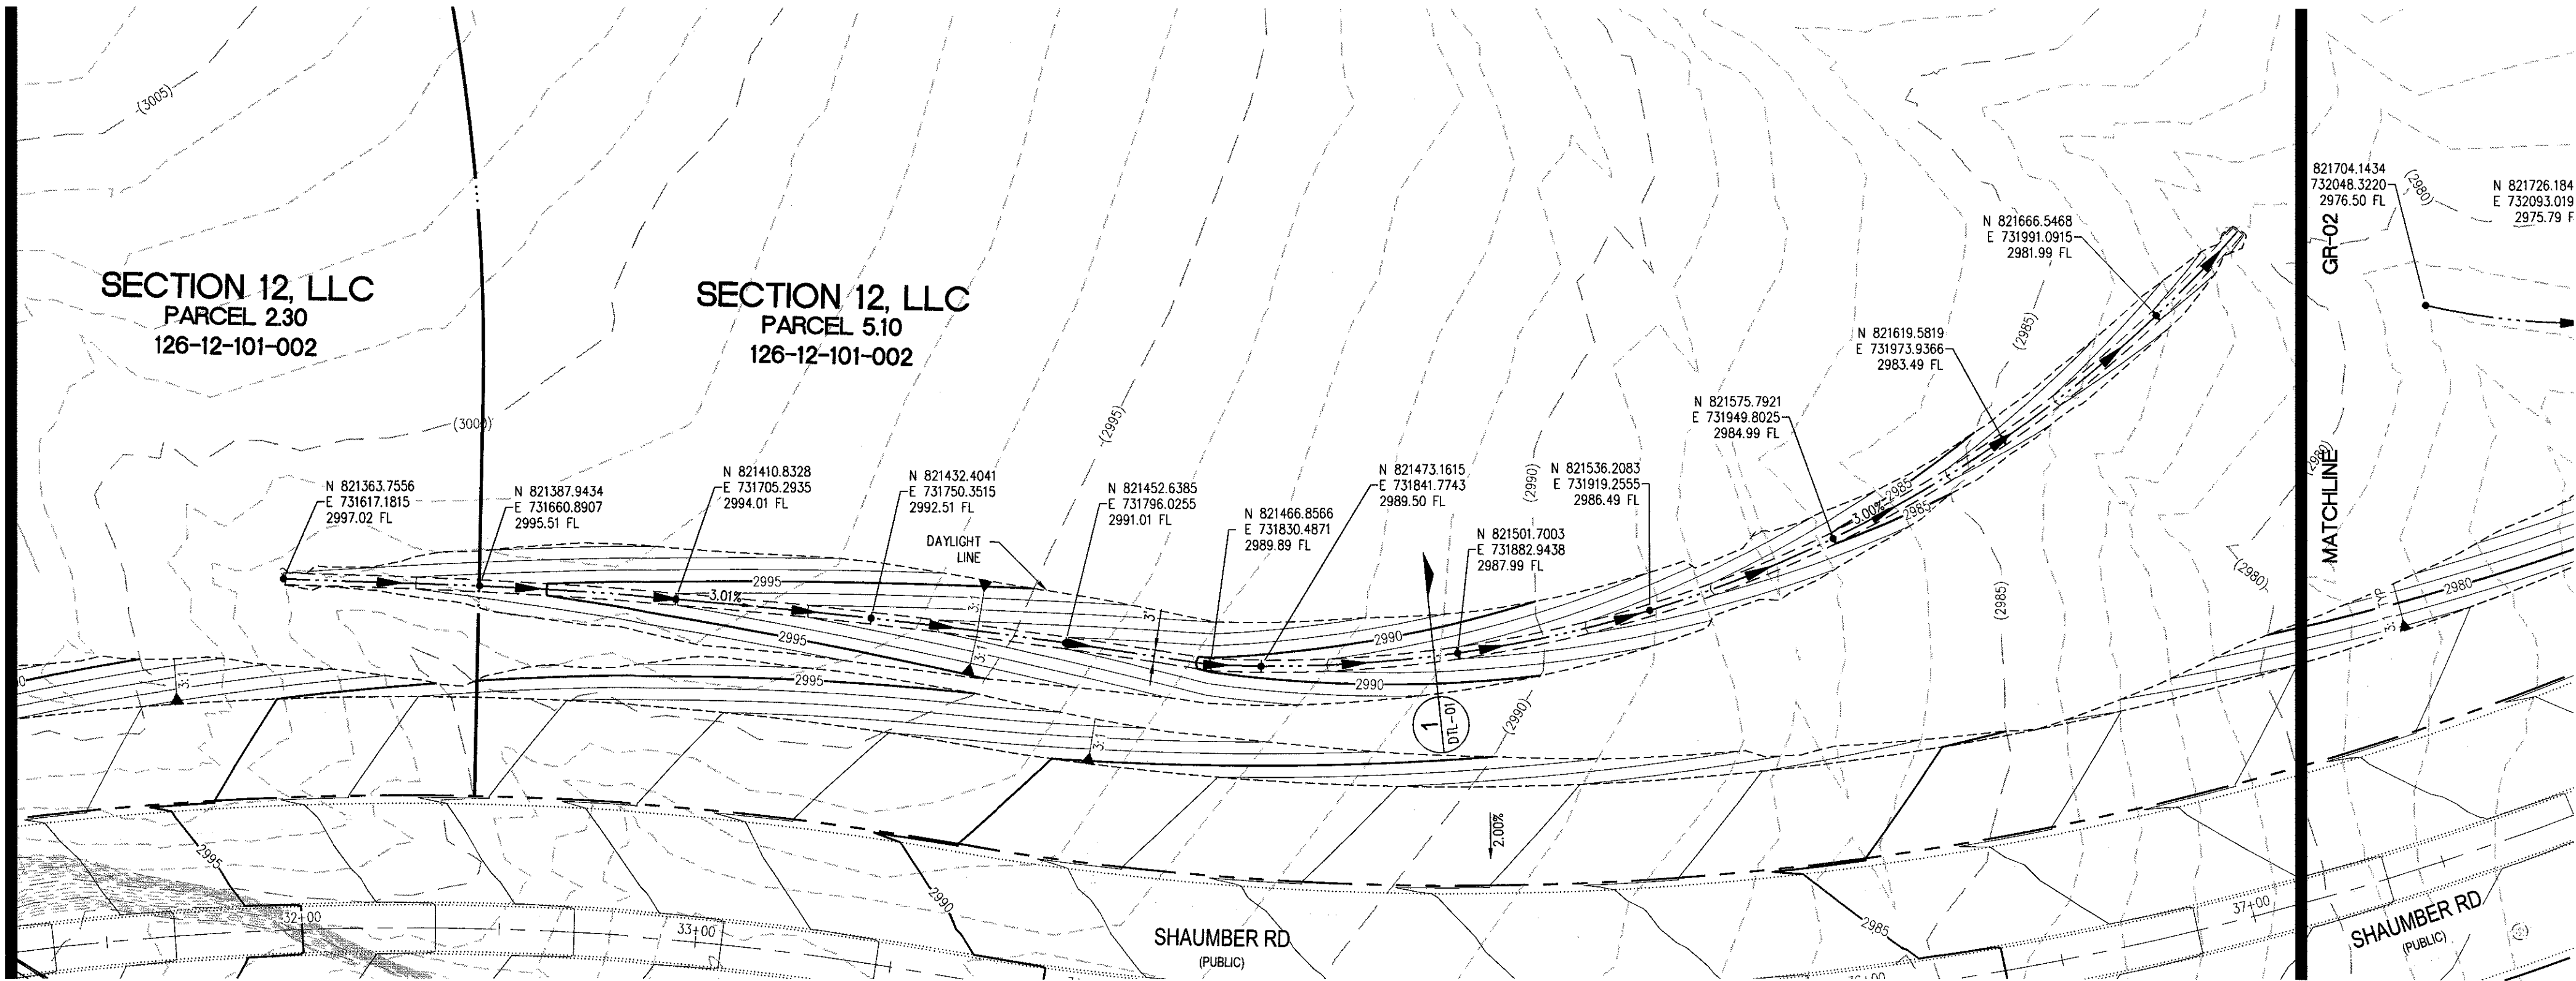

GRADING SITE "C" - PLAN VIEW
HORZ. 1"=30'

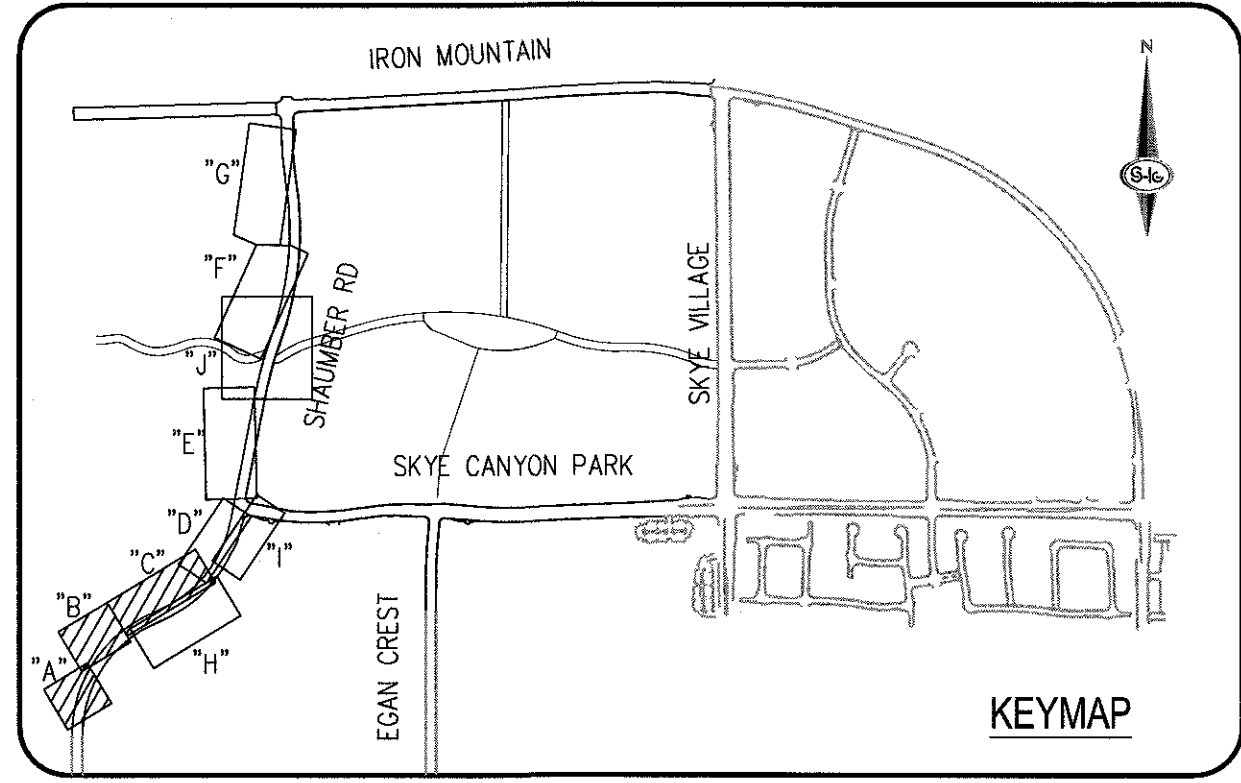

CONSTRUCTION NOTES			
1	CONSTRUCT 1" UTACS OVER 4.5" PBS OVER 4" TYPE II AGGREGATE BASE (SEE TY SHEETS)	DATE	BY
2	CONSTRUCT 1" UTACS OVER 5.5" PBS OVER 6" TYPE II AGGREGATE BASE (SEE TY SHEETS)	DATE	BY
3	CONSTRUCT "A" TYPE ISLAND CURB (USDOCA STD. DWG. NO. 219)	DATE	BY
4	CONSTRUCT "L" TYPE CURB AND GUTTER (USDOCA STD. DWG. NO. 216)	DATE	BY
5	CONSTRUCT SIDEWALK RAMP (CASE II) WITH TACTILE WARNING PANEL (USDOCA STD. DWG. NO. 235)	DATE	BY
6	CONSTRUCT BUS TURN-OUT (USDOCA STD. DWG. NO. 234.1)	DATE	BY
7	CONSTRUCT CONCRETE SIDEWALK (USDOCA STD. DWG. 234)	DATE	BY
8	PROTECT IN PLACE (VERIFY LOCATION AND ELEVATION OF EX. IMPROVEMENT)	DATE	BY

STORM DRAIN NOTES			
1	CONSTRUCT 48" TYPE II-SD MANHOLE (USDOCA STD. DWG. NO. 405.2)	NO.	DESCRIPTION
2	CONSTRUCT 60" TYPE III MANHOLE (USDOCA STD. DWG. NO. 406.1)	NO.	DESCRIPTION
3	INSTALL 18" RCP (USDOCA STD. DWG. NO. 503.2)	NO.	DESCRIPTION
4	INSTALL 24" RCP (USDOCA STD. DWG. NO. 503.2)	NO.	DESCRIPTION
5	INSTALL 30" RCP (USDOCA STD. DWG. NO. 503.2)	NO.	DESCRIPTION
6	INSTALL 36" RCP (USDOCA STD. DWG. NO. 503.2)	NO.	DESCRIPTION
7	INSTALL 42" RCP (USDOCA STD. DWG. NO. 503.2)	NO.	DESCRIPTION
8	INSTALL 54" RCP (USDOCA STD. DWG. NO. 503.2)	NO.	DESCRIPTION
9	INSTALL 60" RCP (USDOCA STD. DWG. NO. 503.2)	NO.	DESCRIPTION
10	INSTALL 72" RCP (USDOCA STD. DWG. NO. 503.2)	NO.	DESCRIPTION
11	INSTALL 30" RCP END SECTION (NDOT STD. PLAN R-2.3.1)	NO.	DESCRIPTION
12	INSTALL 36" RCP END SECTION (NDOT STD. PLAN R-2.3.1)	NO.	DESCRIPTION
13	INSTALL 42" RCP END SECTION (NDOT STD. PLAN R-2.3.1)	NO.	DESCRIPTION
14	INSTALL 72" RCP END SECTION (NDOT STD. PLAN R-2.3.1)	NO.	DESCRIPTION
15	CONSTRUCT TYPE "CM2" DROP INLET. SIZE PER PLAN (USDOCA STD. DWG. NO. 412.1 & 421)	NO.	DESCRIPTION
16	STRUCTURAL MANHOLE	NO.	DESCRIPTION
17	CONSTRUCT CONCRETE COLLAR (SEE DETAIL 3/DTL-01)	NO.	DESCRIPTION
18	CONSTRUCT INTERM BRICK AND MORTAR PLUG SEE DETAIL 2/DTL-01	NO.	DESCRIPTION
19	INSTALL 24" RCP END SECTION (NDOT STD. PLAN R-2.3.1)	NO.	DESCRIPTION
20	INSTALL 54" RCP END SECTION (NDOT STD. PLAN R-2.3.1)	NO.	DESCRIPTION
21	INSTALL 66" RCP END SECTION (NDOT STD. PLAN R-2.3.1) W/1" SACRIFICIAL CONCRETE PER STRUCTURAL DWG.	NO.	DESCRIPTION

- NOTES**
- ALL RCP SHALL BE CLASS III UNLESS OTHERWISE SHOWN.
 - ALL PIPE LENGTHS ARE MEASURED ALONG PIPE CENTERLINE TO CENTER OF MANHOLE OR INSIDE EDGE OF DI OR RCP/RCA.
 - ALL DROP INLETS SHALL INCLUDE STORM WATER MANAGEMENT STAMP AND DETAIL PER USDOCA STD. DWG. NO. 421.
 - SEE STRUCTURAL PLANS FOR ADDITIONAL STRUCTURAL DETAILS AND CONNECTIONS.
 - ALL PIPES ARE PUBLICLY MAINTAINED.
 - ADD SPECIAL INSCRIPTION REQUIRED FOR PIPE SEGMENTS WITH SACRIFICIAL CONCRETE.
 - DIMENSIONS ARE TO BE BACK OF CURB, FACE OF CURB, OR FACE OF MEDIAN UNLESS OTHERWISE NOTED.
 - SEE TY-SHEETS FOR TYPICAL SECTIONS.
 - SEE UT-SHEETS FOR WATER AND SEWER PLAN AND PROFILES.

DROP INLET NOTE
WHERE 10 FEET PARALLEL SEPARATION IS NOT PRACTICABLE, CAST-IN-PLACE MONOLITHIC POUR WITH WATERSTOP BETWEEN SLAB AND WALLS. BASE, WALLS AND TOP TO BE CONSTRUCTED WITH WATERSTOPS, CENTER BUILD, OR FLAT STRIP (VINYLEX, GREENSTREAK PLASTIC PRODUCTS OR APPROVED EQUAL).

LEGEND
X STORM DRAIN LATERAL # (SEE LAT SHEETS)

I CERTIFY THAT THIS GRADING PLAN IS IN CONFORMANCE WITH THE APPROVED TECHNICAL DRAINAGE STUDY DS-4931 ON FILE AT THE CITY OF LAS VEGAS FOR THE SUBJECT PROJECT.

9/1/18 DATE

NOTE:
PROPERTY OWNER IS RESPONSIBLE TO MAINTAIN THE BEST MANAGEMENT PRACTICES, SUCH AS BUT NOT LIMITED TO, THE REMOVAL OF ACCUMULATED SEDIMENT AND DEBRIS AND CARE OF VEGETATION.

APPROVED FOR CONSTRUCTION

LVWD ENGINEERING SERVICES MANAGER DATE

PROJECT NO. 126408

AVOID HITTING OVERHEAD POWER LINES. IT'S COSTLY.

CALL BEFORE YOU DIG OVERHEAD

1-702-227-2929

FAST

Call before you UnderGround.

1-702-432-5300

STREET AND UTILITY SYSTEMS OF NEVADA

Call before you Dig

Avoid cutting underground utility lines. It's costly.

Call

1-800-227-2800

SLATER HANIFAN GROUP
a Westwood team

5740 S. ARVILLE STREET #216, LAS VEGAS, NV 89118
PHONE (702) 284-5300 FAX (702) 284-5399

NINETY-FIVE MANAGEMENT LLC

SKYE CANYON PHASE 3BC
SHAUMBER ROAD
GRADING SHEET 1

DATE: 9/8/18

DRAFTER: HF

DESIGNER: HF

CHECKED: DY


PROJECT NO. OLY1609-000

DERICK D.J. YORO
CIVIL ENGINEER
No. 16396

9/1/18

GR-01

SHEET 16 OF 36

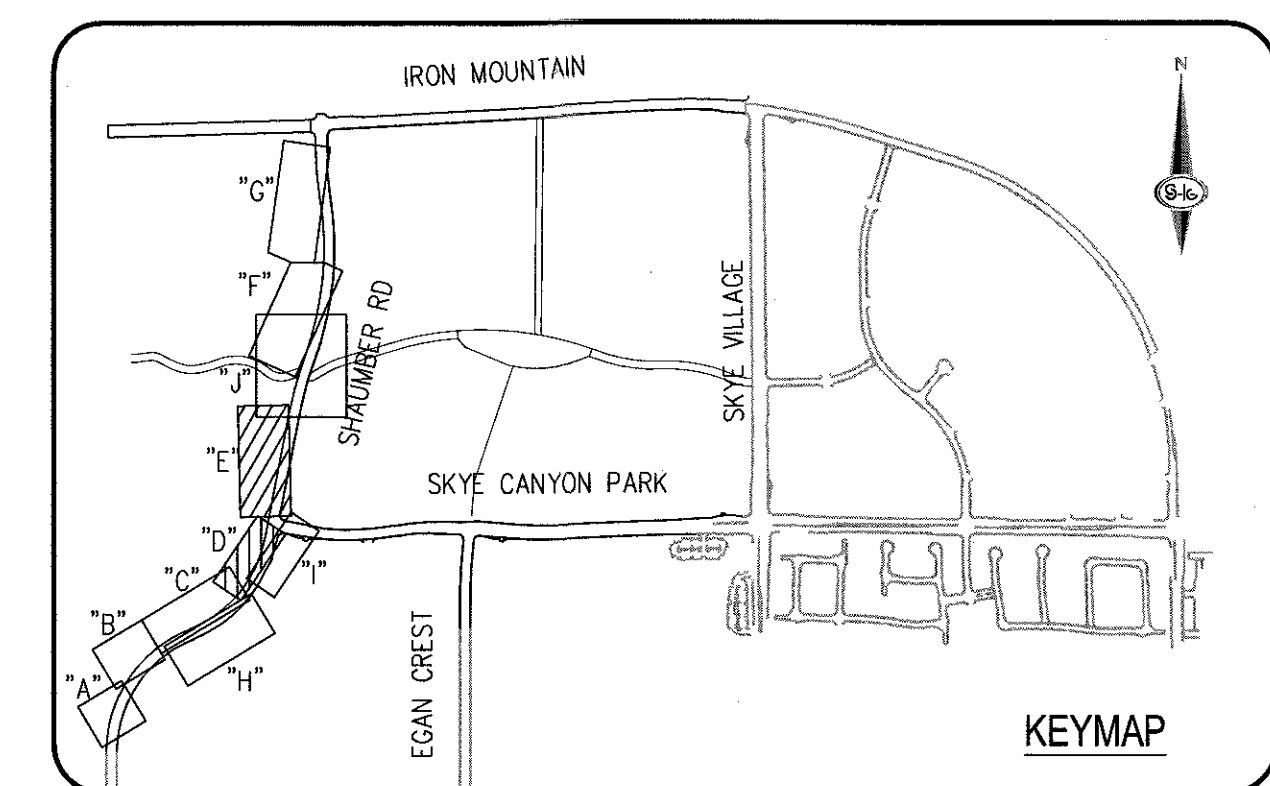

CONSTRUCTION NOTES	
1	CONSTRUCT 1" UTACS OVER 4.5" PBS OVER 4" TYPE II AGGREGATE BASE (SEE TY SHEETS)
2	CONSTRUCT 1" UTACS OVER 5.5" PBS OVER 6" TYPE II AGGREGATE BASE (SEE TY SHEETS)
3	CONSTRUCT "A" TYPE ISLAND CURB (USDCCA STD. DWG. NO. 219)
4	CONSTRUCT "L" TYPE CURB AND GUTTER (USDCCA STD. DWG. NO. 216)
5	CONSTRUCT SIDEWALK RAMP (CASE II) WITH TACTILE WARNING PANEL (USDCCA STD. DWG. NO. 235)
6	CONSTRUCT BUS TURN-OUT (USDCCA STD. DWG. NO. 234.1)
7	CONSTRUCT CONCRETE SIDEWALK (USDCCA STD. DWG. 234)
8	PROTECT IN PLACE (VERIFY LOCATION AND ELEVATION OF EX. IMPROVEMENT)

STORM DRAIN NOTES	
1	CONSTRUCT 48" TYPE II-SD MANHOLE (USDCCA STD. DWG. NO. 405.2)
2	CONSTRUCT 60" TYPE III MANHOLE (USDCCA STD. DWG. NO. 406.1)
3	INSTALL 18" RCP (USDCCA STD. DWG. NO. 503.2)
4	INSTALL 24" RCP (USDCCA STD. DWG. NO. 503.2)
5	INSTALL 30" RCP (USDCCA STD. DWG. NO. 503.2)
6	INSTALL 36" RCP (USDCCA STD. DWG. NO. 503.2)
7	INSTALL 42" RCP (USDCCA STD. DWG. NO. 503.2)
8	INSTALL 54" RCP (USDCCA STD. DWG. NO. 503.2)
9	INSTALL 60" RCP (USDCCA STD. DWG. NO. 503.2)
10	INSTALL 72" RCP (USDCCA STD. DWG. NO. 503.2)
11	INSTALL 30" RCP END SECTION (NDOT STD. PLAN R-2.3.1)
12	INSTALL 36" RCP END SECTION (NDOT STD. PLAN R-2.3.1)
13	INSTALL 42" RCP END SECTION (NDOT STD. PLAN R-2.3.1)
14	INSTALL 72" RCP END SECTION (NDOT STD. PLAN R-2.3.1)
15	CONSTRUCT TYPE "CM2" DROP INLET. SIZE PER PLAN (USDCCA STD. DWG. NO. 412.1 & 421)
16	STRUCTURAL MANHOLE
17	CONSTRUCT CONCRETE COLLAR (SEE DETAIL 3/DTL-01)
18	CONSTRUCT INTERM BRICK AND MORTAR PLUG SEE DETAIL 2/DTL-01
19	INSTALL 24" RCP END SECTION (NDOT STD. PLAN R-2.3.1)
20	INSTALL 54" RCP END SECTION (NDOT STD. PLAN R-2.3.1)
21	INSTALL 66" RCP END SECTION (NDOT STD. PLAN R-2.3.1) W/1" SACRIFICIAL CONCRETE PER STRUCTURAL DWGS

NOTES	
1.	ALL RCP SHALL BE CLASS II UNLESS OTHERWISE SHOWN.
2.	ALL PIPE LENGTHS ARE MEASURED ALONG PIPE CENTERLINE TO CENTER OF MANHOLE OR INSIDE EDGE OF DI OR RCP/RCA.
3.	ALL DROP INLETS SHALL INCLUDE STORM WATER MANAGEMENT STAMP AND DETAIL PER USDCCA STD. DWG. NO. 421.
4.	SEE STRUCTURAL PLANS FOR ADDITIONAL STRUCTURAL DETAILS AND CONNECTIONS.
5.	ALL PIPES ARE PUBLICLY MAINTAINED.
6.	ADD SPECIAL INSPECTION REQUIRED FOR PIPE SEGMENTS WITH SACRIFICIAL CONCRETE.
7.	DIMENSIONS ARE TO BE BACK OF CURB, FACE OF CURB, OR FACE OF MEDIAN UNLESS OTHERWISE NOTED.
8.	SEE TY-SHEETS FOR TYPICAL SECTIONS.
9.	SEE UT-SHEETS FOR WATER AND SEWER PLAN AND PROFILES.


DROP INLET NOTE	
WHERE 10 FEET PARALLEL SEPARATION IS NOT PRACTICABLE: CAST-IN-PLACE MONOLITHIC POUR WITH WATERSTOP BETWEEN SLAB AND WALLS. BASE, WALLS AND TOP TO BE CONSTRUCTED WITH WATERSTOPS, CENTER DRAIN, OR FLAT STRIP (VINYLX, GREENSTREAK PLASTIC PRODUCTS OR APPROVED EQUAL).	

LEGEND	
	STORM DRAIN LATERAL # (SEE LAT. SHEETS)


I CERTIFY THAT THIS GRADING PLAN IS IN CONFORMANCE WITH THE APPROVED TECHNICAL DRAINAGE STUDY DS-4231 ON FILE AT THE CITY OF LAS VEGAS FOR THE SUBJECT PROJECT. <i>[Signature]</i> 9/10/18 DERICK D.J. YORO DATE	FLOOD ZONE THE PROJECT SITE IS LOCATED WITHIN A FEMA DESIGNATED ZONE "X" (OUTSIDE THE 500-YEAR FLOOD PLAIN) ON THE FLOOD INSURANCE RATE MAP (FIRM) PANEL 32003C1750C, DATED SEPTEMBER 27, 2002.
--	--

NOTE: PROPERTY OWNER IS RESPONSIBLE TO MAINTAIN THE BEST MANAGEMENT PRACTICES, SUCH AS BUT NOT LIMITED TO, THE REMOVAL OF ACCUMULATED SEDIMENT AND DEBRIS AND CARE OF VEGETATION.	PROJECT NO. OLY1609-000
--	---

APPROVED FOR CONSTRUCTION	
LIVWD ENGINEERING SERVICES MANAGER	DATE
PROJECT NO. 126408	

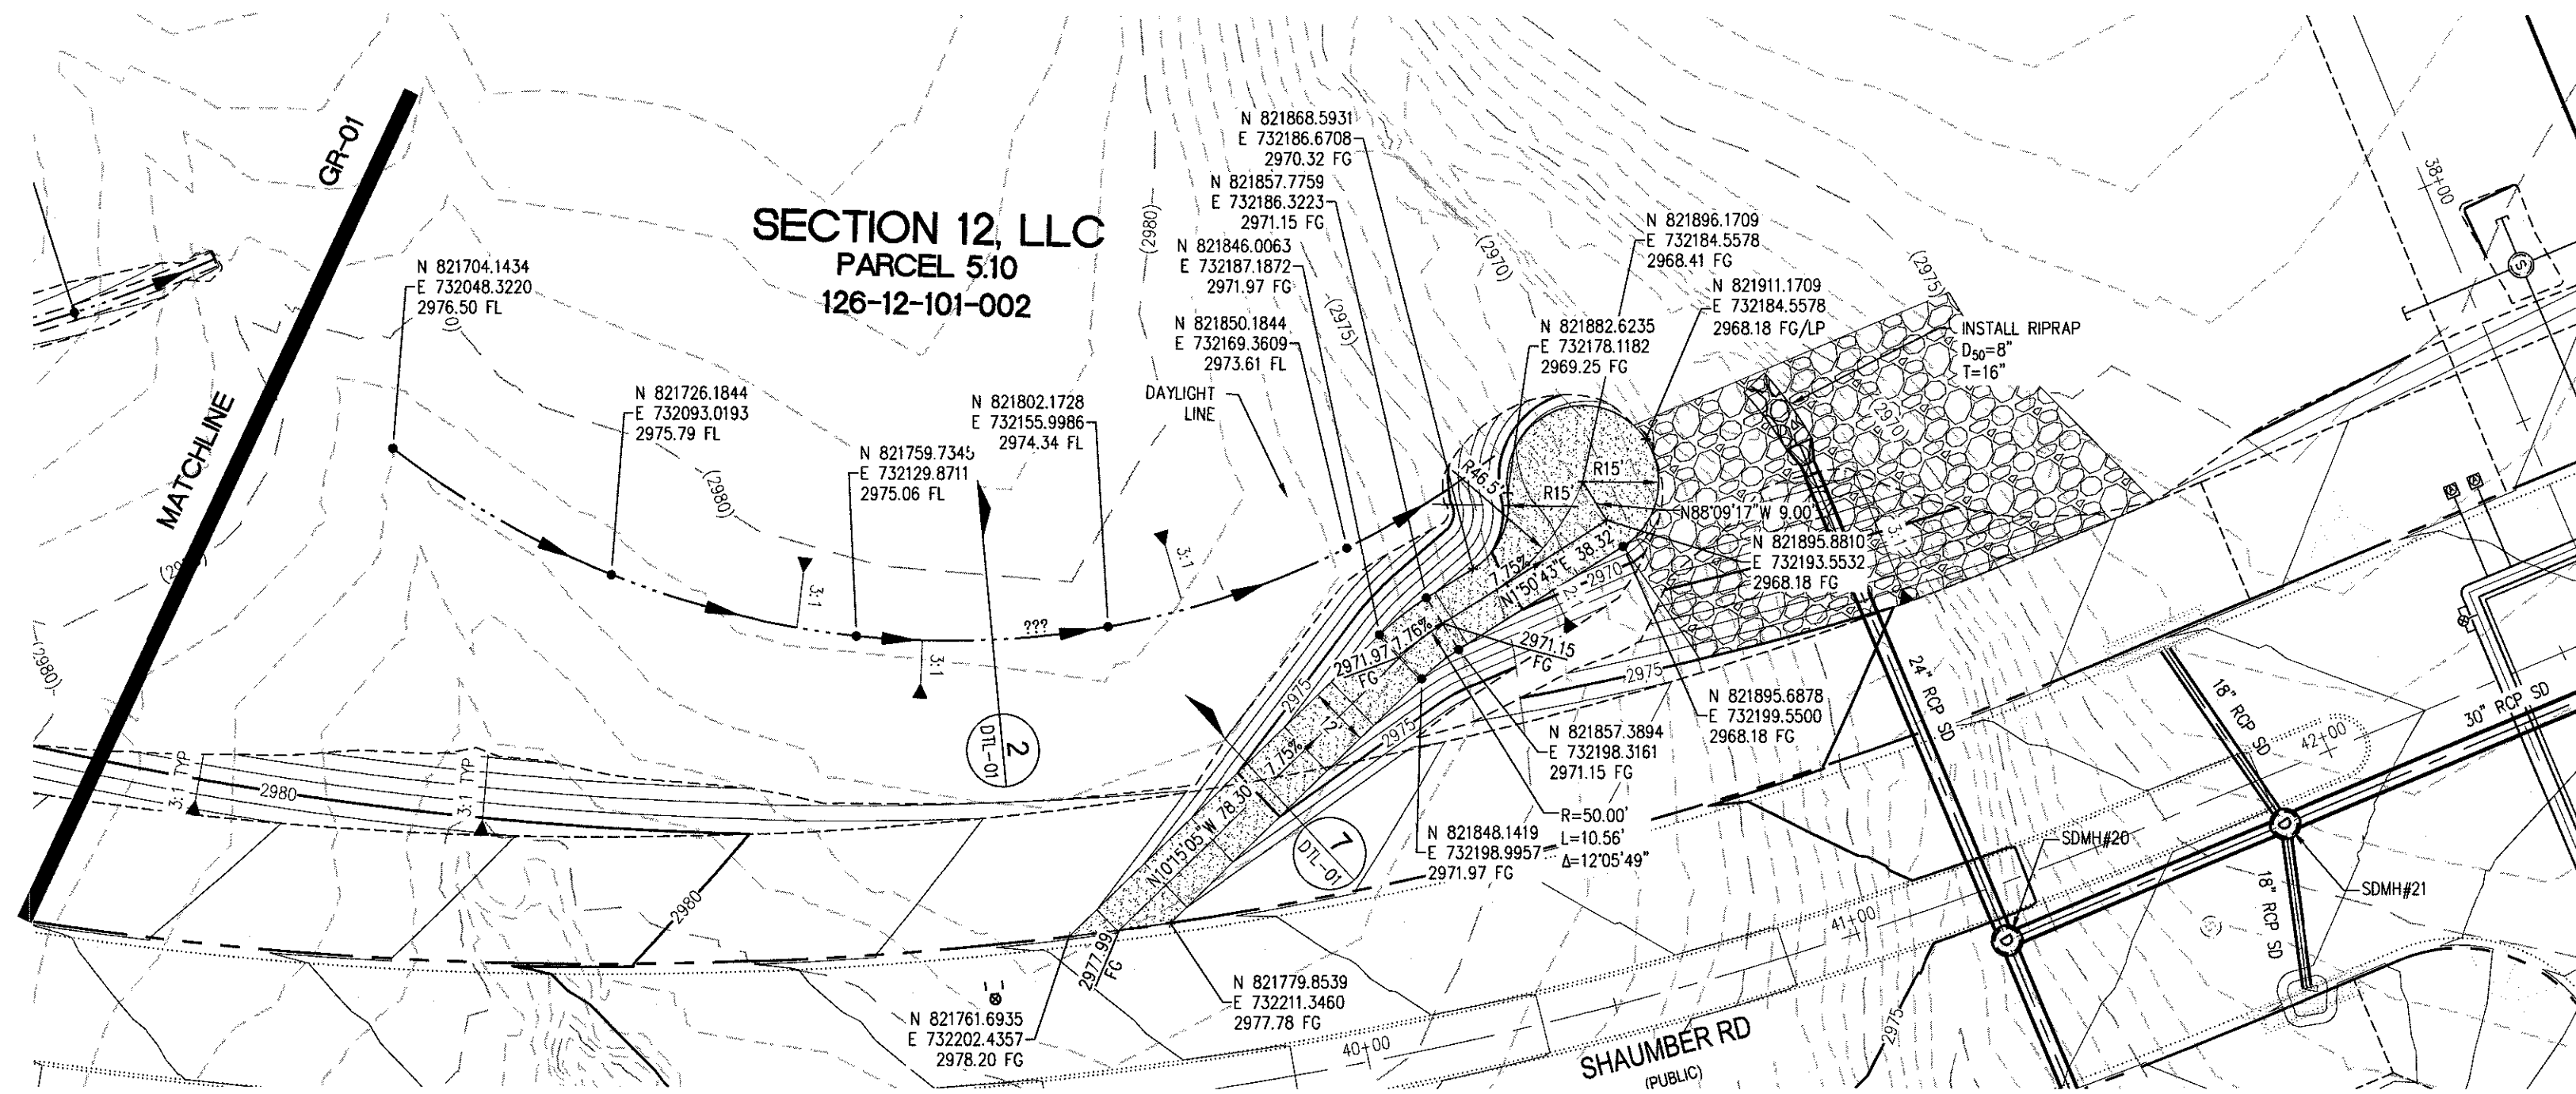

GRADING SITE "D" - PLAN VIEW
HORZ: 1"=30'

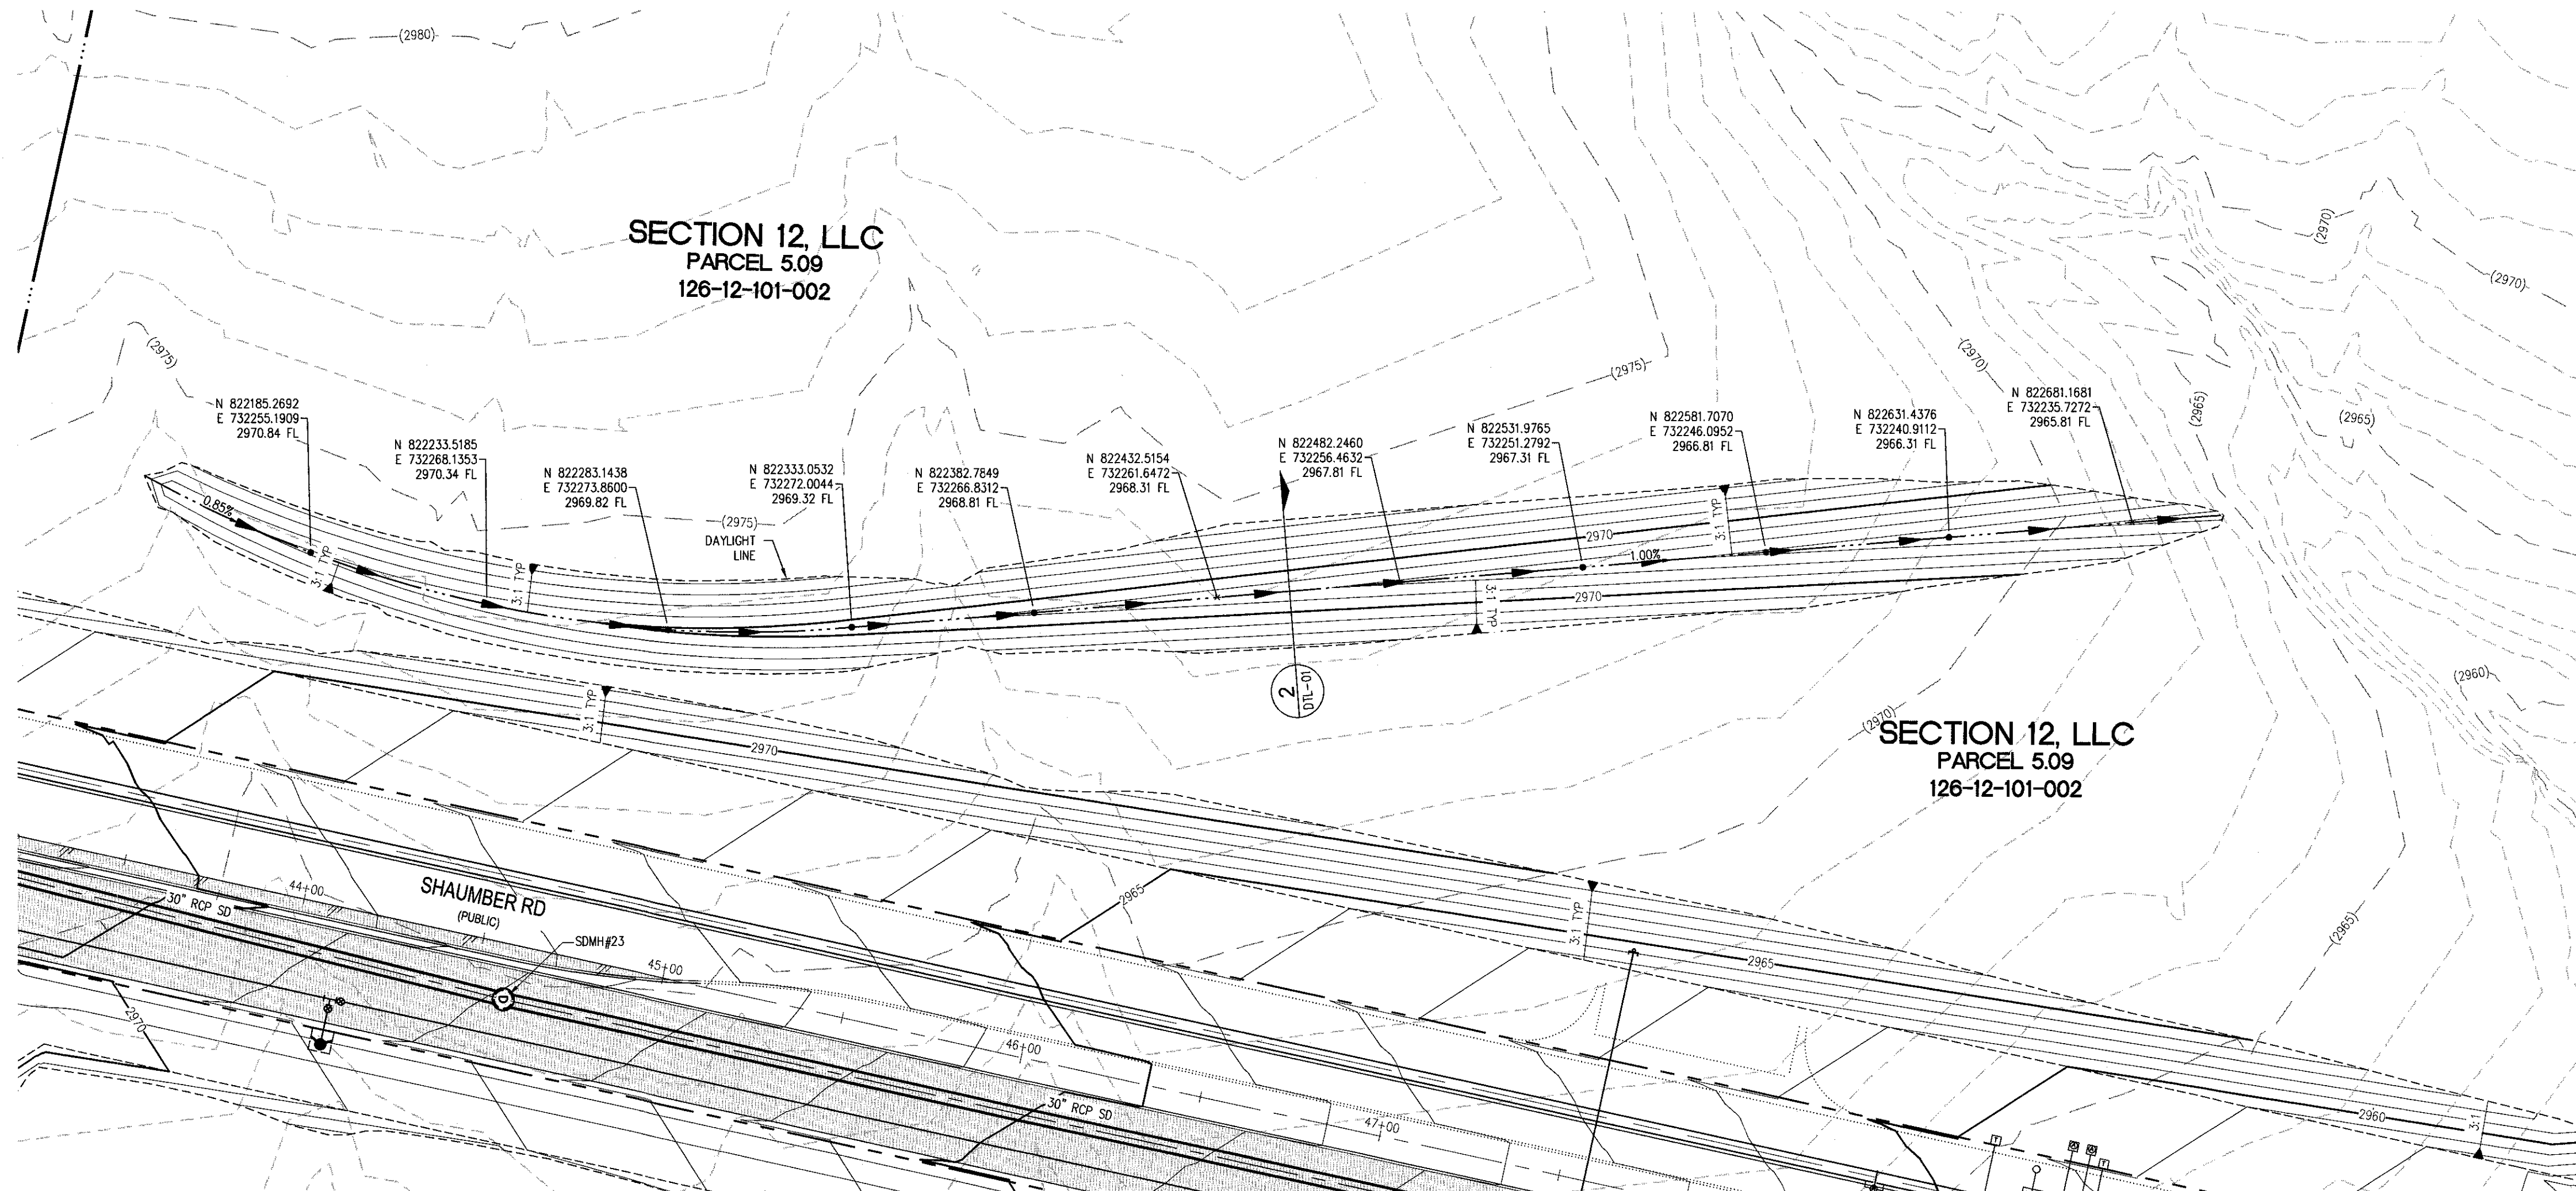

GRADING SITE "E" - PLAN VIEW
HORZ: 1"=30'






A:\OLY1609-000 SKYE CANYON PHASE 3B 3D\DWG\IMPROV\3B-C\3B-OLY1609-000-GRD-SEAMS 9/8/2018 4:03 PM Bart Rivers

SLATER HANIFAN GROUP
a Westwood team
5740 S. ARVILLE STREET #216, LAS VEGAS, NV 89118
PHONE (702) 284-5300 FAX (702) 284-5399

NINETY-FIVE MANAGEMENT LLC
SKYE CANYON PHASE 3BC
SHAMBER ROAD
GRADING SHEET II

DATE: 9/8/18
DRAFTER: HF
DESIGNER: HF
CHECKED: DY
PROJECT NO.
OLY1609-000

GR-02
SHEET 17 OF 36

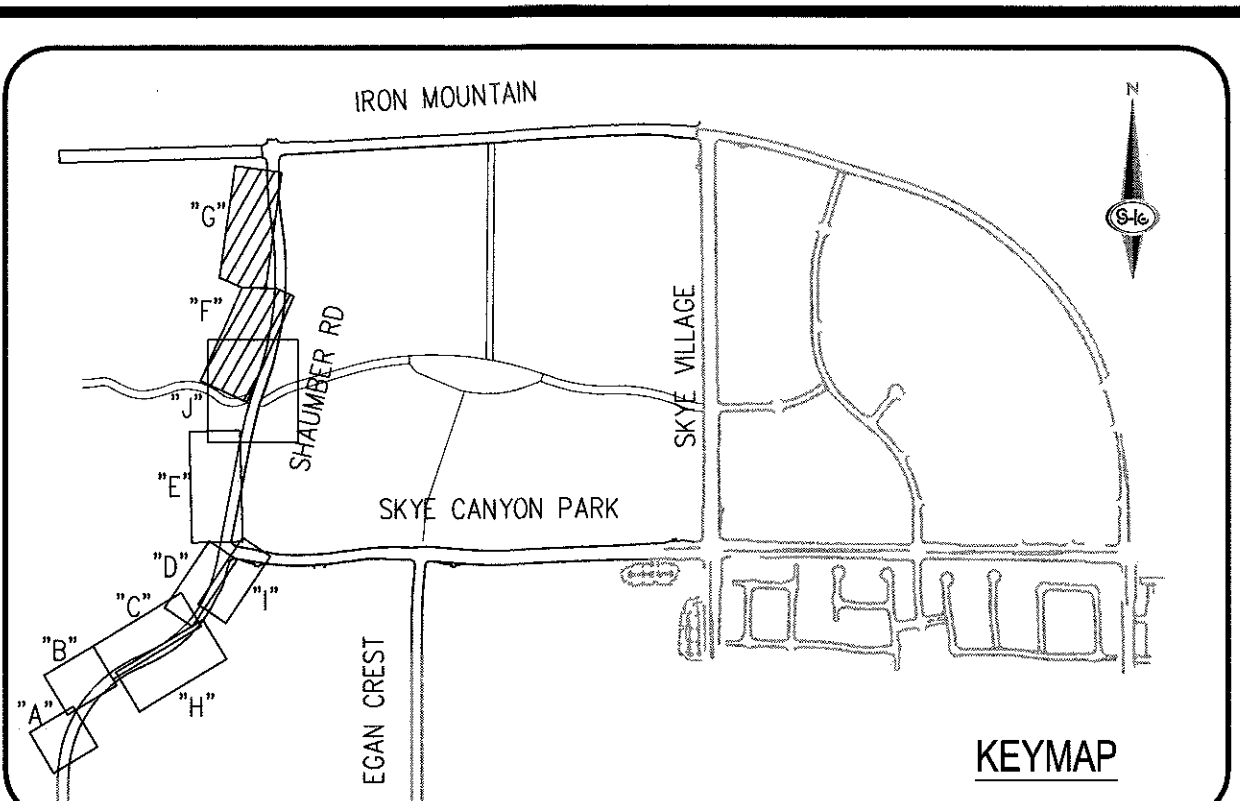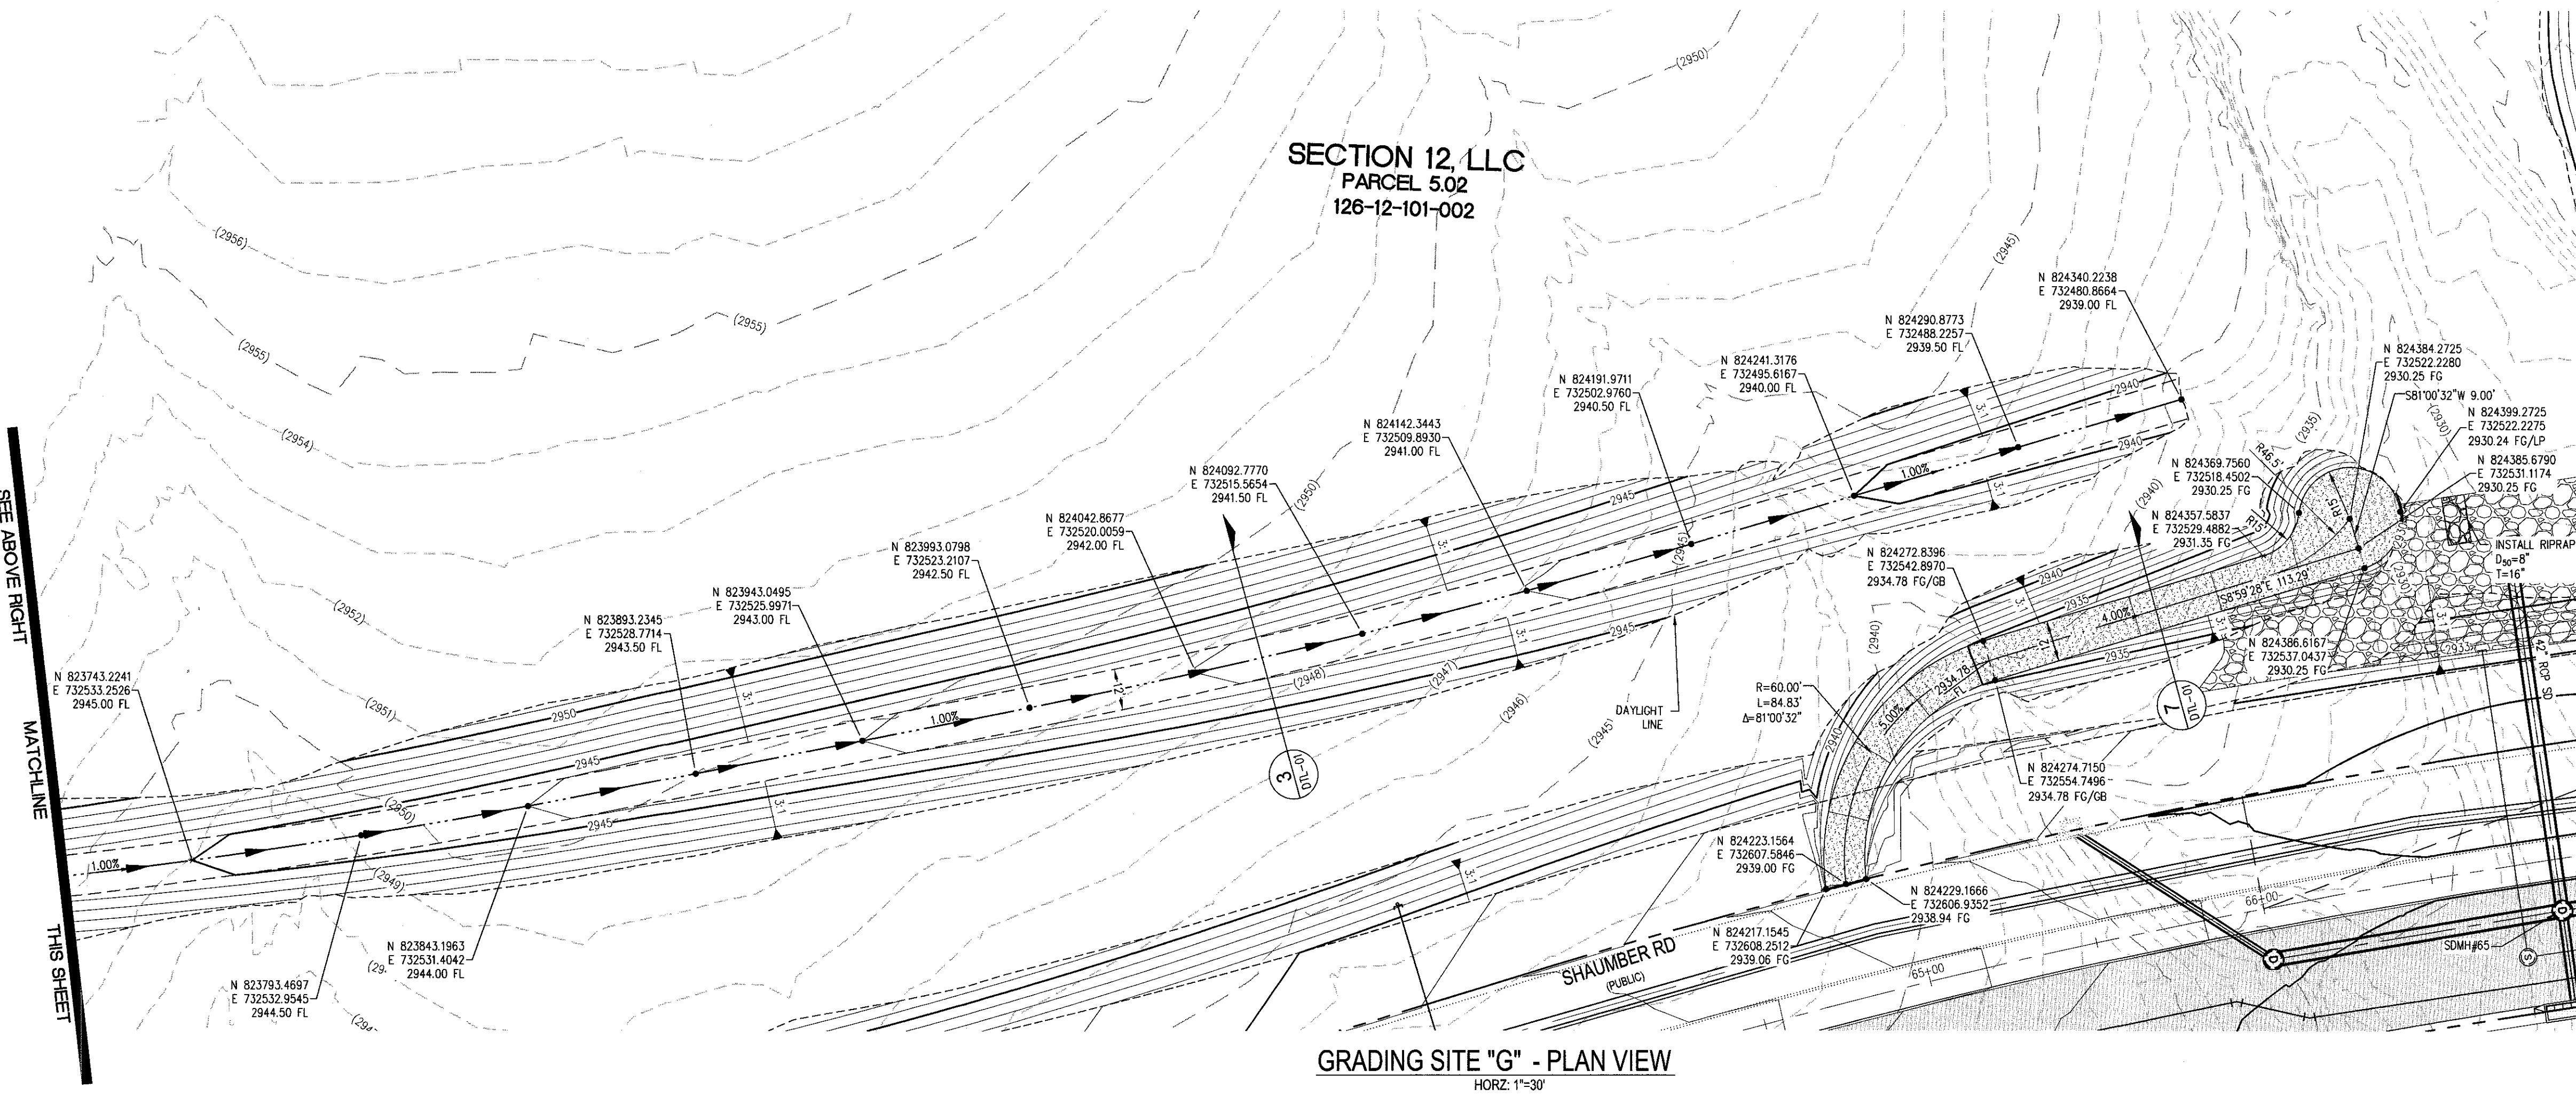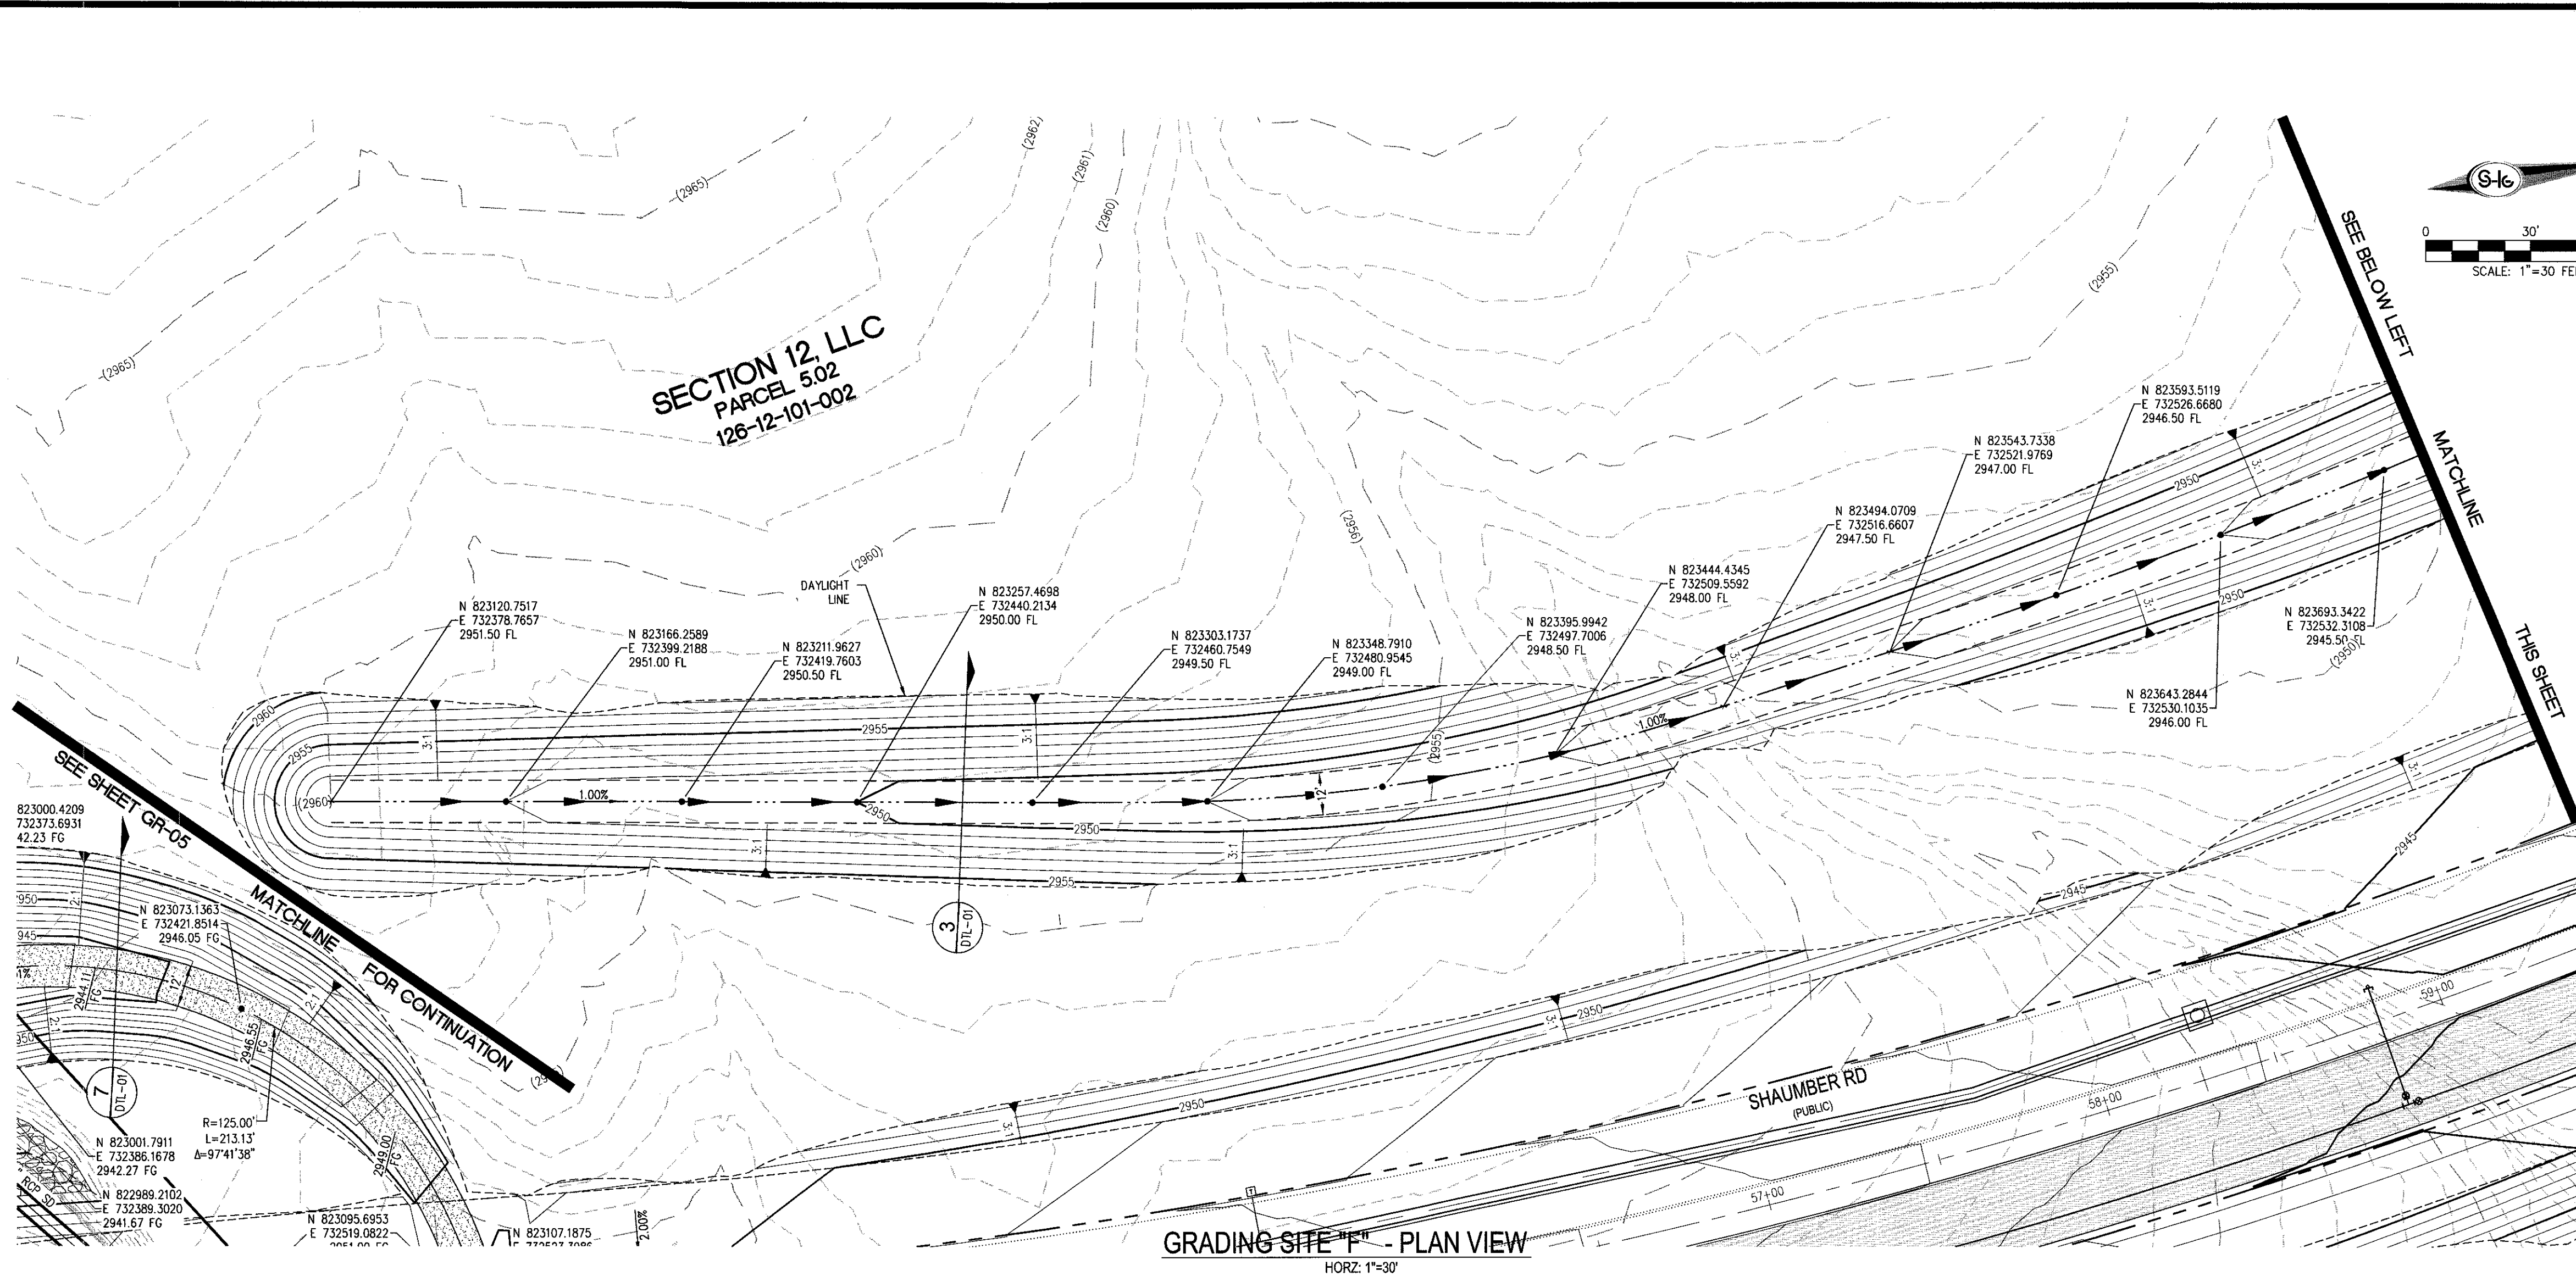

CONSTRUCTION NOTES			
NO.	DESCRIPTION	DATE	BY
1	CONSTRUCT 1" UTACS OVER 4.5" PBS OVER 4" TYPE II AGGREGATE BASE (SEE TY SHEETS)		
2	CONSTRUCT 1" UTACS OVER 5.5" PBS OVER 6" TYPE II AGGREGATE BASE (SEE TY SHEETS)		
3	CONSTRUCT "A" TYPE ISLAND CURB (USDCCA STD. DWG. NO. 219)		
4	CONSTRUCT "L" TYPE CURB AND GUTTER (USDCCA STD. DWG. NO. 216)		
5	CONSTRUCT SIDEWALK RAMP (CASE II) WITH TACTILE WARNING PANEL (USDCCA STD. DWG. NO. 235)		
6	CONSTRUCT BUS TURN-OUT (USDCCA STD. DWG. NO. 234.1)		
7	CONSTRUCT CONCRETE SIDEWALK (USDCCA STD. DWG. 234)		
8	PROTECT IN PLACE (VERIFY LOCATION AND ELEVATION OF EX. IMPROVEMENT)		

STORM DRAIN NOTES			
NO.	DESCRIPTION	DATE	BY
1	CONSTRUCT 48" TYPE II-SD MANHOLE (USDCCA STD. DWG. NO. 405.2)		
2	CONSTRUCT 60" TYPE III MANHOLE (USDCCA STD. DWG. NO. 406.1)		
3	INSTALL 18" RCP (USDCCA STD. DWG. NO. 503.2)		
4	INSTALL 24" RCP (USDCCA STD. DWG. NO. 503.2)		
5	INSTALL 30" RCP (USDCCA STD. DWG. NO. 503.2)		
6	INSTALL 36" RCP (USDCCA STD. DWG. NO. 503.2)		
7	INSTALL 42" RCP (USDCCA STD. DWG. NO. 503.2)		
8	INSTALL 54" RCP (USDCCA STD. DWG. NO. 503.2)		
9	INSTALL 60" RCP (USDCCA STD. DWG. NO. 503.2)		
10	INSTALL 72" RCP (USDCCA STD. DWG. NO. 503.2)		
11	INSTALL 30" RCP END SECTION (NDOT STD. PLAN R-2.3.1)		
12	INSTALL 36" RCP END SECTION (NDOT STD. PLAN R-2.3.1)		
13	INSTALL 42" RCP END SECTION (NDOT STD. PLAN R-2.3.1)		
14	INSTALL 72" RCP END SECTION (NDOT STD. PLAN R-2.3.1)		
15	CONSTRUCT TYPE "CM2" DROP INLET. SIZE PER PLAN (USDCCA STD. DWG. NO. 412.1 & 421)		
16	STRUCTURAL MANHOLE		
17	CONSTRUCT CONCRETE COLLAR (SEE DETAIL 3/DTL-01)		
18	CONSTRUCT INTERM BRICK AND MORTAR PLUG SEE DETAIL 2/DTL-01		
19	INSTALL 24" RCP END SECTION (NDOT STD. PLAN R-2.3.1)		
20	INSTALL 54" RCP END SECTION (NDOT STD. PLAN R-2.3.1)		
21	INSTALL 66" RCP END SECTION (NDOT STD. PLAN R-2.3.1) W/1" SACRIFICIAL CONCRETE PER STRUCTURAL DWGS		

NOTES			
1.	ALL RCP SHALL BE CLASS III UNLESS OTHERWISE SHOWN.		
2.	ALL PIPE LENGTHS ARE MEASURED ALONG PIPE CENTERLINE TO CENTER OF MANHOLE OR INSIDE EDGE OF DI OR RCP/RCA.		
3.	ALL DROP INLETS SHALL INCLUDE STORM WATER MANAGEMENT STAMP AND DETAIL PER USDCCA STD. DWG. NO. 421.		
4.	SEE STRUCTURAL PLANS FOR ADDITIONAL STRUCTURAL DETAILS AND CONNECTIONS.		
5.	ALL PIPES ARE PUBLICLY MAINTAINED.		
6.	ADD SPECIAL INSPECTION REQUIRED FOR PIPE SEGMENTS WITH SACRIFICIAL CONCRETE.		
7.	DIMENSIONS ARE TO BE BACK OF CURB, FACE OF CURB, OR FACE OF MEDIAN UNLESS OTHERWISE NOTED.		
8.	SEE TY-SHEETS FOR TYPICAL SECTIONS.		
9.	SEE UT-SHEETS FOR WATER AND SEWER PLAN AND PROFILES.		

DROP INLET NOTE			
WHERE 10 FEET PARALLEL SEPARATION IS NOT PRACTICABLE, CAST-IN-PLACE MONOLITHIC POUR WITH WATERSTOP BETWEEN SLAB AND WALLS. BASE, WALLS AND TOP TO BE CONSTRUCTED WITH WATERSTOPS, CENTER BUILD OR FLAT STRIP (VINYLEX, GREENSTREAK PLASTIC PRODUCTS OR APPROVED EQUAL).			

LEGEND			
X	STORM DRAIN LATERAL # (SEE LAT SHEETS)		

I CERTIFY THAT THIS GRADING PLAN IS IN CONFORMANCE WITH THE APPROVED TECHNICAL DRAINAGE STUDY DS-4931 ON FILE AT THE CITY OF LAS VEGAS FOR THE SUBJECT PROJECT.	DATE: 9/10/18
DERRICK D.J. YORO	DATE: 9/10/18

NOTE: PROPERTY OWNER IS RESPONSIBLE TO MAINTAIN THE BEST MANAGEMENT PRACTICES, SUCH AS BUT NOT LIMITED TO, THE REMOVAL OF ACCUMULATED SEDIMENT AND DEBRIS AND CARE OF VEGETATION.	
---	--

APPROVED FOR CONSTRUCTION			
LVWD ENGINEERING SERVICES MANAGER	DATE		
PROJECT NO. 126408			

SLATER HANIFAN GROUP
a Westwood team
5740 S. ARVILLE STREET #216, LAS VEGAS, NV 89118
PHONE (702) 284-5300 FAX (702) 284-5399

NINETY-FIVE MANAGEMENT LLC

SKYE CANYON PHASE 3BC
SHAUMBER ROAD
GRADING SHEET III

DATE: 9/8/18

DRAWN: HF

DESIGNER: HF

CHECKED: DY

PROJECT NO. OLY1609-000

GR-03

SHEET 18 OF 36

[illegible]

NINETY-FIVE MANAGEMENT LLC

SKYE CANYON PHASE 3BC

STORM DRAIN DETAILS



DATE: 9/8/18


DESIGNER: HF

CHECKED: DY

PROJECT NO.

PROJECT NO.

OLY1609-000

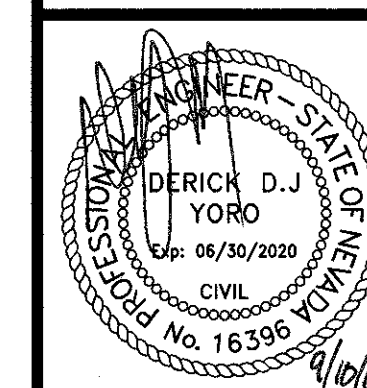

DTL-01

SHEET 21 OF 36

