



FOR CONTINUATION SEE SHEET 5

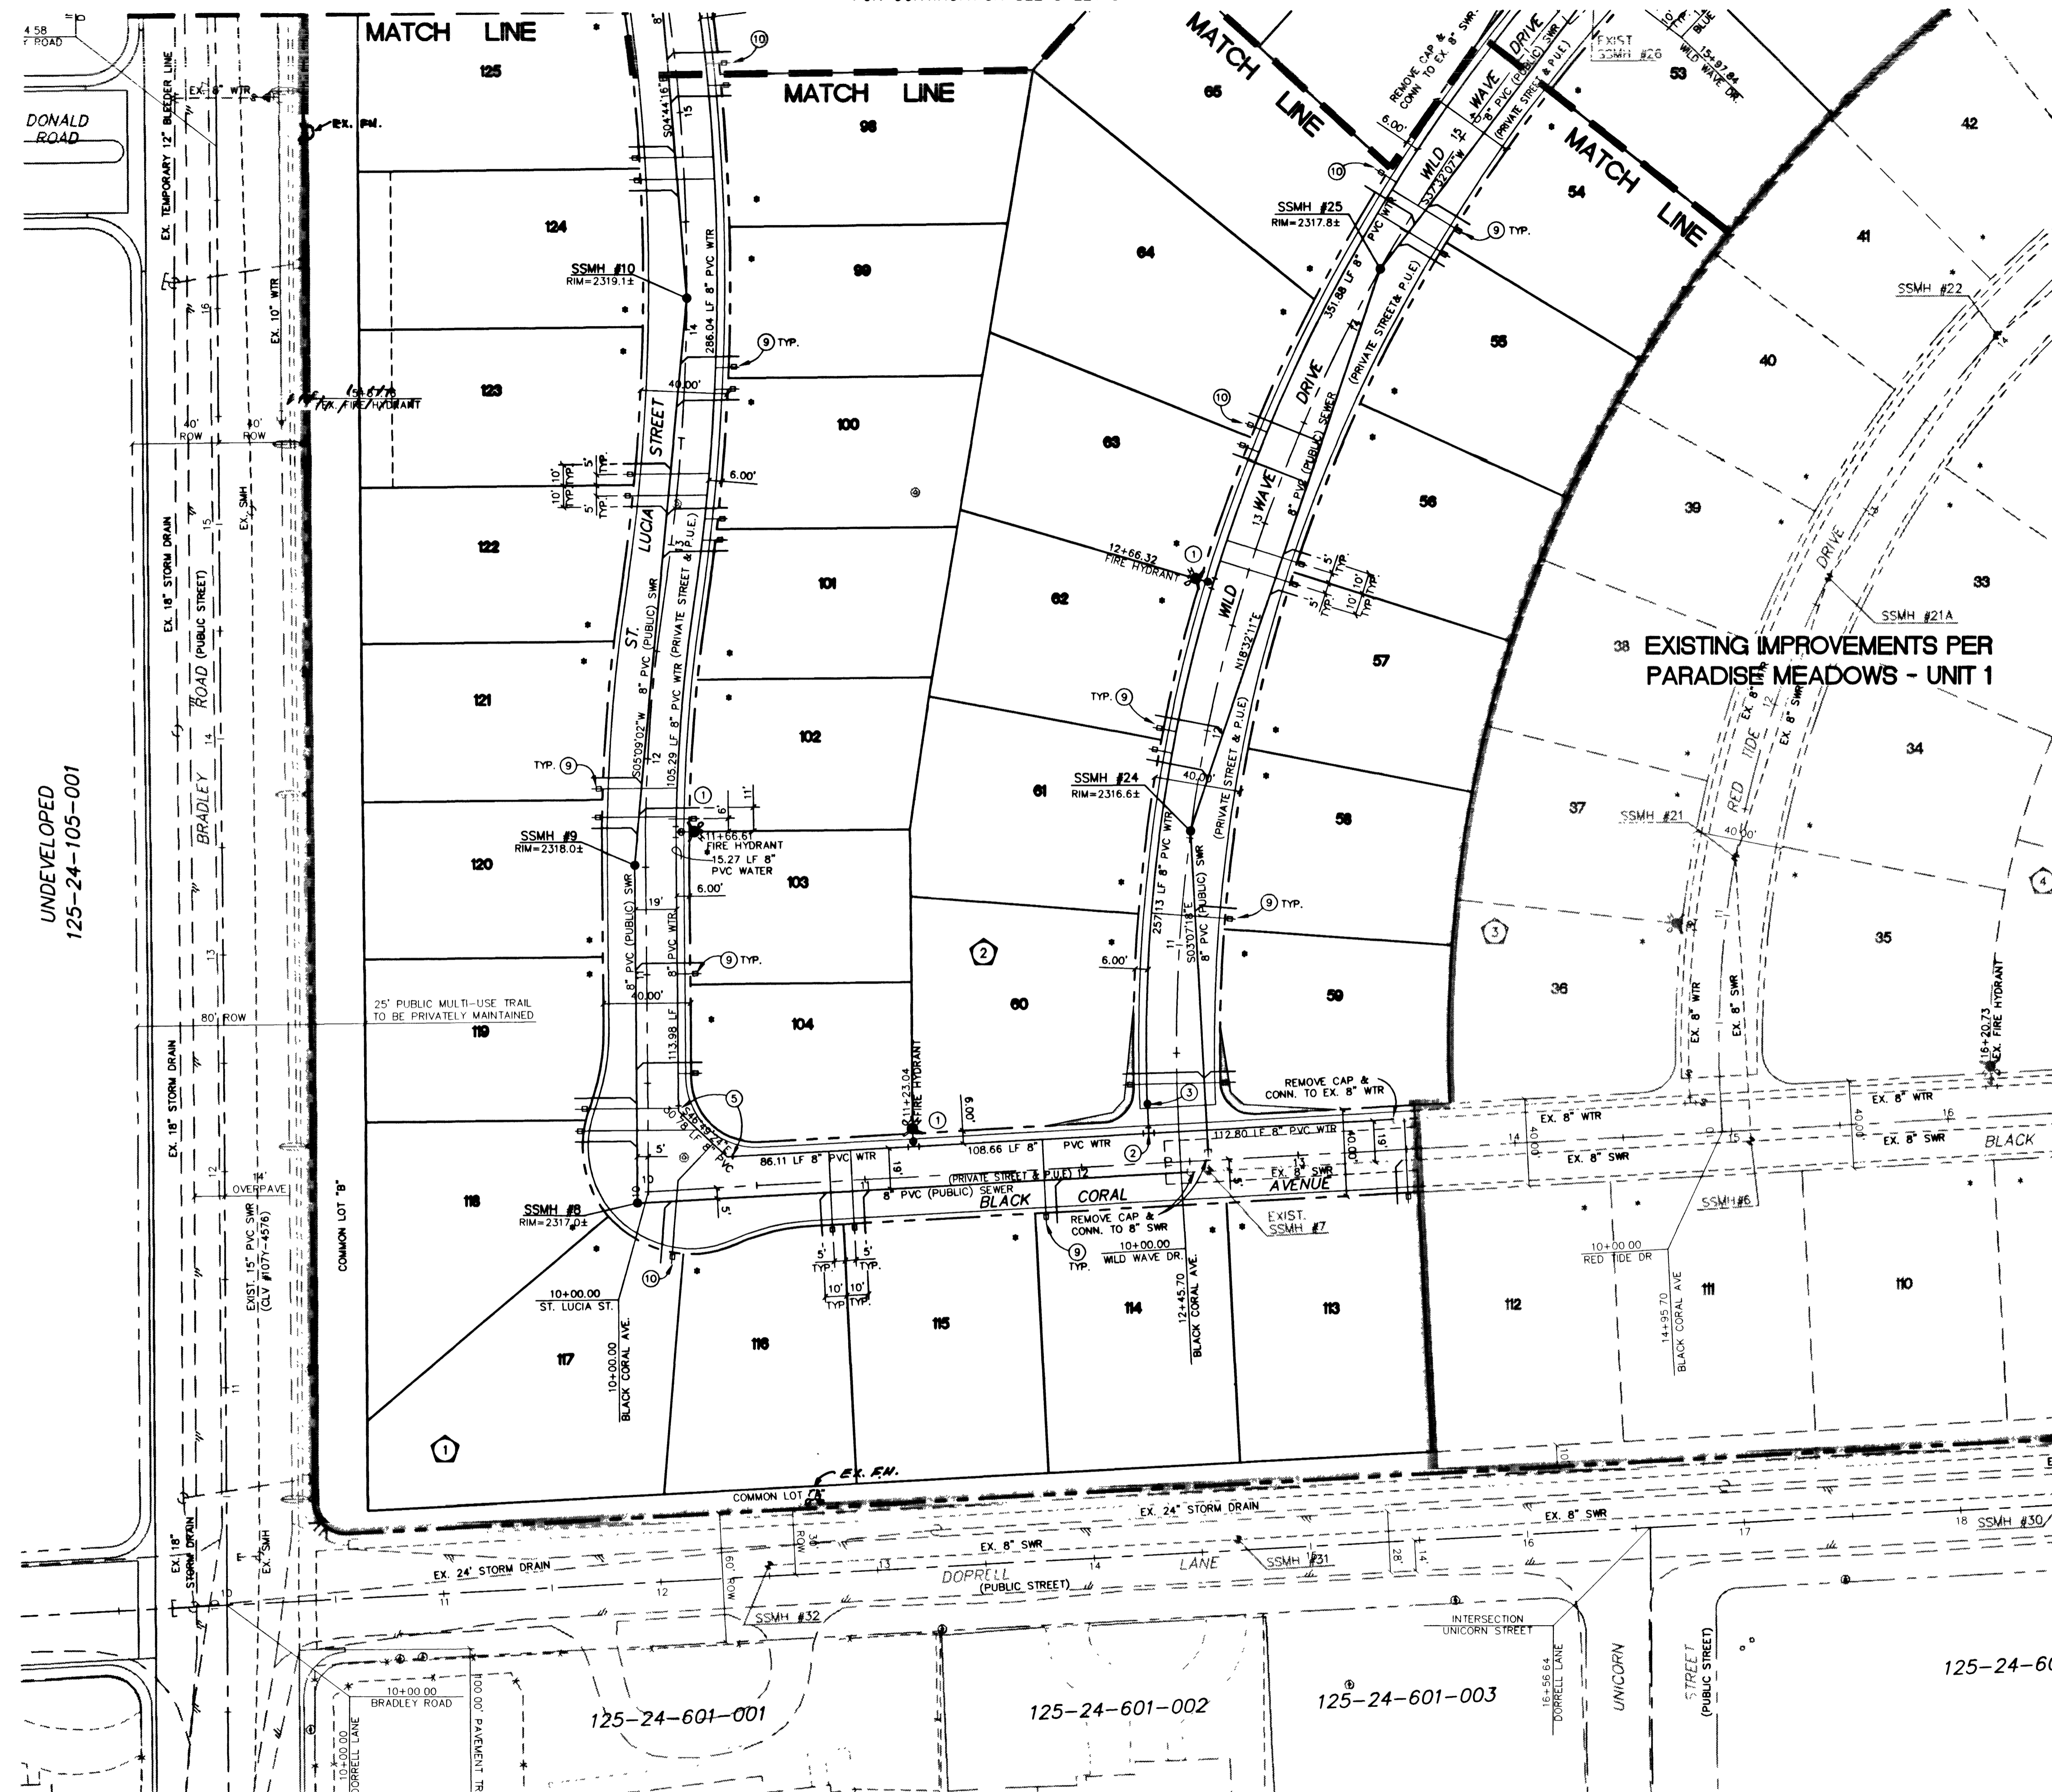


UNDEVELOPED
125-24-105-001

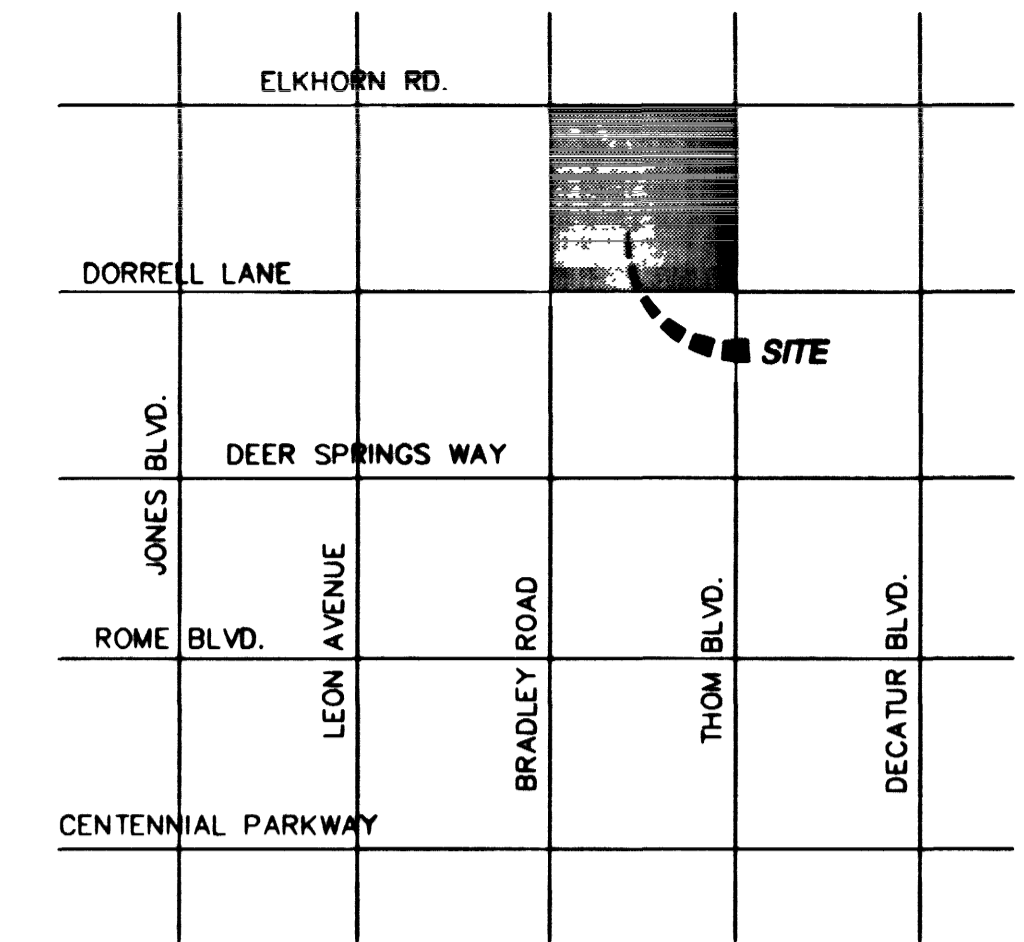

VICINITY MAP
N.T.S.



GRAPHIC SCALE

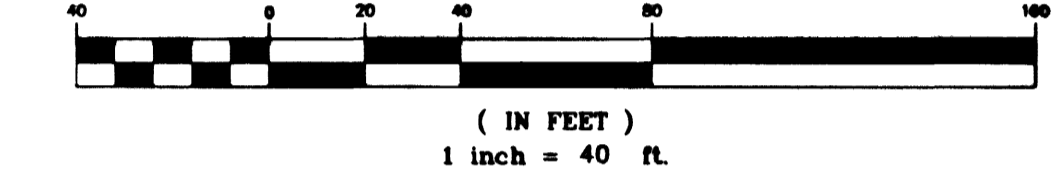

LEGEND

	MATCH LINE
	EXISTING WATER VALVE
	PROPOSED WATER VALVE
	EXISTING WATER MAIN
	PROPOSED WATER MAIN
	EXISTING SEWER MANHOLE
	PROPOSED SEWER MANHOLE
	EXISTING SEWER MAIN
	PROPOSED SEWER MAIN
	EXISTING FIRE HYDRANT
	PROPOSED FIRE HYDRANT
	EXISTING STORM DRAIN
	PROPOSED STORM DRAIN
	EXISTING DROP INLET
	PROPOSED DROP INLET
	EXISTING CURB & GUTTER
	PROPOSED CURB & GUTTER
	EXISTING GAS MAIN
	LOT NUMBER
	BLOCK NUMBER
	DRIVEWAY
	2\"/>

WATER CONSTRUCTION NOTES

- 1) STD. FIRE HYD. W/ASSY. PER UDACS PLATE 7
- 2) 8\"/>
- 3) 8\"/>
- 4) 8\"/>
- 5) 8\"/>
- 6) 2\"/>
- 7) 10\"/>
- 8) 8\"/>
- 9) 1\"/>
- 10) 1\"/>
- 11) CONCRETE ENCASUREMENT PER DETAIL SHT 7

THE PROPERTY MAY HAVE STATIC WATER PRESSURE IN EXCESS OF 80 PSI. THE UNIFORM PLUMBING CODE REQUIRES THAT INDIVIDUAL ON-SITE (PRIVATE) PRESSURE REDUCING VALVES BE INSTALLED WHENEVER THE PRESSURE EXCEEDS 80 PSI. PRIVATE DEVELOPER'S RESPONSIBILITY AND WILL NOT BE INSPECTED OR INCLUDED IN THE ACCEPTANCE OF LVWD FACILITIES.

L.V.W.D. STICKER

APPROVALS

C.L.V. LAND DEVELOPMENT	DATE
C.L.V. SEWER	DATE
C.L.V. FIRE DEPARTMENT	DATE
L.V.W.D.	DATE

SEE SHEET 2 FOR GENERAL UTILITY NOTES
SEE SHEET 7 FOR UTILITY DETAILS


NOTICE TO CONTRACTOR !
EXISTING UTILITY LOCATIONS SHOWN HEREON ARE APPROXIMATE ONLY. IT SHALL BE THE CONTRACTOR'S RESPONSIBILITY TO DETERMINE THE EXACT VERTICAL AND HORIZONTAL LOCATION OF ALL EXISTING UNDERGROUND UTILITIES PRIOR TO COMMENCING CONSTRUCTION. NO REPRESENTATION IS MADE THAT ALL EXISTING UTILITIES ARE SHOWN HEREON. THE ENGINEER ASSUMES NO RESPONSIBILITY FOR UTILITIES NOT SHOWN OR UTILITIES NOT SHOWN IN THEIR PROPER LOCATION.

AVOID CUTTING UNDERGROUND UTILITIES. IT'S COSTLY.
CALL before you Dig
1-800-227-2600
UNDERGROUND SERVICE (USA)
CALL 1-702-593-6111

NOTE
ALL PRIVATE STREETS ARE CLV SEWER & PUBLIC DRAINAGE EASEMENTS TO BE PRIVATELY MAINTAINED.

BENCHMARK
CITY OF LAS VEGAS VERTICAL CONTROL
ONLY BM #519118, SW COR OF WATER DISTRICT FENCE, DECATUR BLVD. & DEER SPRINGS WAY
STATION 11,980
ELEVATION = 701.4396 METERS (NAVDD8)
2301.306 FEET

NO.	DATE	BY	APPR.	REVISION DESCRIPTION

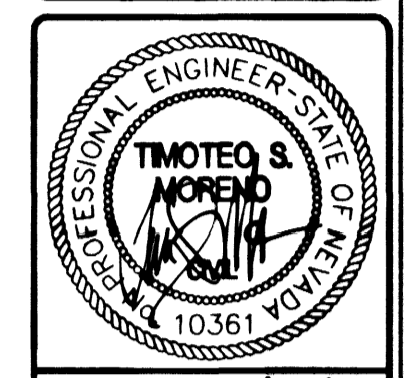

STAMP DATE: 10/3/00

3610 North Rancho Drive
Las Vegas, Nevada 89130
Telephone: (702) 644-1113
Fax: (702) 644-1113
ENGINEERING
SOUTHWEST
LAND PLANNING • MAPPING • DEVELOPMENT



UTILITY PLAN
PARADISE MEADOWS
UNIT 2
CITY OF LAS VEGAS, NEVADA

TITLE	PROJECT	CITY OF LAS VEGAS
WORK ORDER NO. 000313	DESIGN BY: SJW	DATE: 7/24/00
SCALE: 1"=40'	CADFILE: pm2up	SHEET 6 OF 16 SHEETS
C.L.V. D.W. NO. 307Y-4651-2	DATE: 11/7/00	DATE: 11/7/00