

CITY OF LAS VEGAS GENERAL NOTES	
1.	ALL CONSTRUCTION AND MATERIALS SHALL BE IN ACCORDANCE WITH THE "UNIFORM STANDARD SPECIFICATIONS FOR PUBLIC WORKS CONSTRUCTION OFF-SITE IMPROVEMENTS, CLARK COUNTY AREA NEVADA," LATEST EDITION, THE "UNIFORM STANDARD DRAWINGS FOR PUBLIC WORKS CONSTRUCTION, CLARK COUNTY AREA NEVADA," LATEST REVISED EDITION, THE "UNIFORM STANDARD SPECIFICATIONS FOR HIGHWAY CONSTRUCTION, CLARK COUNTY AREA NEVADA," LATEST REVISED EDITION, THE "UNIFORM STANDARD SPECIFICATIONS FOR WATER SUPPLY CONSTRUCTION, CLARK COUNTY AREA NEVADA," LATEST REVISED EDITION, THE "UNIFORM STANDARD SPECIFICATIONS FOR SEWER CONSTRUCTION, CLARK COUNTY AREA NEVADA," LATEST REVISED EDITION, THE "UNIFORM STANDARD SPECIFICATIONS FOR STORM DRAIN CONSTRUCTION, CLARK COUNTY AREA NEVADA," LATEST REVISED EDITION, THE "UNIFORM STANDARD SPECIFICATIONS FOR TRAFFIC CONTROL DEVICES, CLARK COUNTY AREA NEVADA," LATEST EDITION, AND OTHER APPLICABLE APPROVED STANDARDS ISSUED BY THE CONTROLLING AGENCY, THE "UNIFORM BUILDING CODE," AND ALL LOCAL CITY CODES AND ORDINANCES APPLICABLE, EXCEPT AS NOTED ON THIS SHEET AS "DEVIATIONS FROM STANDARDS."
2.	THE EXISTENCE AND LOCATION OF ANY OVERHEAD OR UNDERGROUND UTILITY LINES, PIPES, OR STRUCTURES SHOWN ON THESE PLANS ARE OBTAINED BY A RESEARCH OF THE AVAILABLE RECORDS. EXISTING UTILITIES AS SHOWN FROM CITY PLANS, PLANS, MAPS, AND RECORDS, AND FOR ALL UTILITIES NOT SHOWN, EXISTING UTILITIES ARE LOCATED ON PLANS ONLY FOR THE CONVENIENCE OF THE CONTRACTOR. EXISTING UTILITY SERVICE LATERALS MAY NOT BE SHOWN ON THE PLANS. THE CONTRACTOR SHALL, AT HIS OWN EXPENSE, LOCATE ALL UNDERGROUND AND OVERHEAD INTERFERENCES WHICH MAY AFFECT HIS OPERATION DURING CONSTRUCTION AND SHALL TAKE ALL NECESSARY PRECAUTIONS TO AVOID DAMAGE TO SAME. THE CONTRACTOR SHALL USE EXTREME CAUTION WHEN LOCATING UTILITIES. THE CONTRACTOR SHALL BE RESPONSIBLE FOR THE LOCATION OF ALL PERSONNEL AND EQUIPMENT, AND SHALL BE RESPONSIBLE FOR ALL COST AND LIABILITY IN CONNECTION THEREWITH.
3.	THE CONTRACTOR SHALL TAKE ALL PRECAUTIONARY MEASURES NECESSARY TO PROTECT EXISTING UTILITY LINES, STRUCTURES AND STREET IMPROVEMENTS WHICH ARE TO REMAIN IN PLACE. FROM DAMAGE, AND ALL SUCH IMPROVEMENTS OR STRUCTURES DAMAGED BY THE CONTRACTOR'S OPERATIONS SHALL BE REPAIRED OR REPLACED SATISFACTORY TO THE CITY ENGINEER AND OWNING UTILITY COMPANY AT THE EXPENSE OF THE CONTRACTOR.
4.	ALL CONSTRUCTION SHALL BE AS SHOWN ON THESE PLANS, ANY REVISIONS SHALL HAVE THE PRIOR WRITTEN APPROVAL OF THE CITY ENGINEER.
5.	TYPE V CEMENT SHALL BE USED IN ALL OFF-SITE CONCRETE WORK. CONCRETE TO BE 3000 P.S.I. MINIMUM @ 28 DAYS. MIX DESIGNS TO BE APPROVED BY THE CITY, PRIOR TO THE USE ON THE PROJECT.
6.	PERMITS ARE REQUIRED FOR ANY WORK IN THE PUBLIC RIGHT-OF-WAY. THE CONTRACTOR SHALL SECURE ALL PERMITS AND INSPECTIONS REQUIRED FOR THIS CONSTRUCTION.
7.	EXPANSION JOINTS REQUIRED, MAXIMUM EVERY 300' IN EXTRUDED-TYPE CURB.
8.	AC PAVEMENT TO BE ONE-HALF INCH (1/2") ABOVE UP OF ALL GUTTERS AFTER COMPACTION, EXCEPT AT SIDEWALK RAMPS AND CROSS GUTTERS.
9.	CURB AND GUTTER FOUND TO BE UNACCEPTABLE TO THE CITY OF LAS VEGAS SHALL BE REMOVED AND REPLACED PER STANDARD DRAWING 216.
10.	SIDEWALK RAMPS SHALL BE CONSTRUCTED IN EACH QUADRANT OF AN INTERSECTION PER STANDARD DRAWING 235. EXACT LOCATION OF RAMPS MAY BE ADJUSTED IN THE FIELD BY A CITY INSPECTOR.
11.	CONTRACTOR SHALL PROVIDE ALL NECESSARY HORIZONTAL AND VERTICAL TRANSITIONS BETWEEN NEW CONSTRUCTION AND EXISTING SURFACES TO PROVIDE FOR PROPER DRAINAGE AND FOR INGRESS AND EGRESS TO NEW CONSTRUCTION AND EXISTING SURFACES TO BE SHOWN ON THESE PLANS.
12.	ALL GRADING WORK SHALL CONFORM TO THE SOILS REPORT AS PREPARED BY GEOTEK, 6260-C JULY 19, 2021 APPROVED BY THE CITY ENGINEER, AND AS SHOWN ON THESE PLANS.
13.	EXACT LOCATION OF ALL SAWCUT LINES MAY BE ADJUSTED OR DETERMINED IN THE FIELD BY A CITY OF LAS VEGAS INSPECTOR IF LOCATION ON PLANS IS NOT CLEARLY SHOWN, OR EXISTING PAVEMENT CONDITION REQUIRES RELOCATION.
14.	THE CONTRACTOR SHALL TAKE ALL PRECAUTIONS NECESSARY TO PROTECT EXISTING PERMANENT SURVEY MONUMENTS. ANY MONUMENTS DISTURBED SHALL BE REPLACED AND ADJUSTED PER STANDARD DRAWING 216, IN ACCORDANCE WITH N.R.S. STATUTE NO. 625.380 & CITY OF LAS VEGAS TITLE 18, APPENDIX D.
15.	UTILITY COMPANY METER BOXES, MANHOLE LIDS, VALVE COVERS, ETC., SHALL BE LOCATED OUT OF DRIVEWAYS, DRIVEWAY INTERSECTIONS, CROSS GUTTERS, OR CROSS GUTTERS UNLESS WRITTEN APPROVAL IS GRANTED BY THE UTILITY COMPANY AND THE CITY ENGINEER.
16.	ALL WALLS, NEW OR EXISTING, ARE ONLY SHOWN ON CIVIL PLANS FOR THE PURPOSE OF REVIEWING GRADING RELATIONSHIPS. FLOOD CONTROL AND SIGHT DISTANCE AT INTERSECTIONS. NEW WALLS REQUIRE A SEPARATE PERMIT AND INSPECTION BY THE BUILDING DEPARTMENT.
17.	ASPHALT MIX DESIGN MUST BE SUBMITTED AND APPROVED BY THE CITY ENGINEER PRIOR TO THE PLACEMENT OF ASPHALT WITHIN CITY RIGHT OF WAY.
18.	CONTRACTOR SHALL ADJUST ALL NEW AND EXISTING INLET, VALVE BOXES, MANHOLE RIMS, AND SEWER CLEAN OUTS, ETC. TO FINISH GRADE AS APPLICABLE WHETHER OR NOT THEY ARE SHOWN ON THE PLANS.
19.	MATERIALS, HANDLING AND PLACEMENT OF PORTLAND CEMENT CONCRETE SHALL BE IN ACCORDANCE WITH APPLICABLE SECTIONS OF THE CODE OR THE CLARK COUNTY AREA SPECIFICATIONS (AS APPLICABLE) AND THE PLANS AND DETAILS SHOWN HEREON.
20.	WHEN INSTALLING UNDERGROUND FACILITIES THAT REQUIRE UNDERGROUND LOCATING DEVICES SUCH AS MARKER BALLS, LOCATING RIBBON, ETC. THE CONTRACTOR SHALL PROVIDE WRITTEN DOCUMENTATION TO OFFSITE INSPECTION AND TESTING CERTIFYING THAT ALL DEVICES HAVE BEEN PLACED AND VERIFIED TO BE IN GOOD WORKING CONDITION PRIOR TO THE CONSTRUCTION OF ANY ROAD BASE.
21.	SANITARY SEWER AND STORM DRAIN FINAL LOCATION MAP(S) SHALL BE PROVIDED TO THE CITY AND APPROVED PRIOR TO ACCEPTANCE OF FACILITY VIDEO INSPECTION. THE MAP(S) SHALL INCLUDE THE HORIZONTAL AND VERTICAL (INVERT) LOCATION OF PUBLIC SEWER MANHOLES, STORM DRAIN MANHOLES AND TRANSITION STRUCTURES, STORM DRAIN LATERALS AT THE CONNECTION TO THE STORM DRAIN MAIN AND AT THE CONNECTION TO A DROP INLET, THE CONNECTION OF SEWER SERVICE LATERALS TO THE STORM DRAIN MAIN AND WHERE THE SEWER SERVICE LATERALS EXIT THE PUBLIC RIGHT-OF-WAY, AND STORM DRAIN MAIN ALIGNMENT, INCLUDING DEFLECTION POINTS. THE LOCATION SHALL BE DESCRIBED BY COORDINATES WHICH SHALL BE BASED ON THE HORIZONTAL AND VERTICAL CONTROL NETWORKS OF THE CITY OF LAS VEGAS. FINAL LOCATION MAPS MUST BE SEALED AND CERTIFIED BY A NEVADA PROFESSIONAL LAND SURVEYOR TO HAVE POSITIONAL CERTANTIES OF ± 0.09 METERS (± 0.3 FEET) HORIZONTALLY AND VERTICALLY. A SEPARATE ELECTRONIC COMMA DELIMITED FILE FOR THE SANITARY SEWER AND STORM DRAIN COORDINATES SHALL ALSO ACCOMPANY THE SANITARY SEWER AND STORM DRAIN FINAL LOCATION MAP(S).
22.	CITY VIDEO INSPECTION IS REQUIRED FOR ALL SEWER AND STORM DRAINS. THE CITY VIDEO INSPECTIONS NEED TO BE PERFORMED PER THE DESIGN AND CONSTRUCTION STANDARDS FOR WASTEWATER COLLECTION SYSTEMS LATEST EDITION.
23.	A SEPARATE BORING PERMIT IS REQUIRED FOR ALL BORING ACTIVITIES.

CITY OF LAS VEGAS TRAFFIC NOTES	
1.	ALL CONSTRUCTION SIGNING, BARRICADING, AND TRAFFIC DELINEATION SHALL CONFORM TO THE "MANUAL ON UNIFORM TRAFFIC CONTROL DEVICES", LATEST EDITION.
2.	THE STREET SIGN CONTRACTOR SHALL OBTAIN STREET NAMES AND BLOCK NUMBERING FROM THE PLANNING DEPARTMENT PRIOR TO CONSTRUCTION.
3.	BEFORE ANY WORK IS STARTED IN THE RIGHT-OF-WAY, THE CONTRACTOR SHALL INSTALL ALL ADVANCE WARNING SIGNS FOR THE CONSTRUCTION ZONE. THE CONTRACTOR SHALL INSTALL TEMPORARY STOP SIGNS AT ALL NEW STREET ENCROACHMENTS INTO EXISTING CITY STREETS WHERE WARRANTED IMMEDIATELY AFTER FIRST GRADING WORK IS ACCOMPLISHED, AND SHALL MAINTAIN SAID SIGNS UNTIL PERMANENT SIGNS ARE INSTALLED.
4.	WHEN A DESIGNATED "SAFE ROUTE TO SCHOOL" IS ENCRoACHED UPON BY A CONSTRUCTION WORK ZONE AND PUBLIC WORKS STAFF IDENTIFIES A NEED FOR STUDENTS TO BE ASSISTED IN THE SAFE CROSSING THROUGH THAT WORK ZONE, THE CONTRACTOR SHALL BE REQUIRED TO PROVIDE A QUALIFIED "CROSSING GUARD", THE GUARD SHALL BE PRESENT FOR THE FULL DURATION OF TIME THAT CHILDREN ARE LIKELY TO BE PRESENT.
5.	IF THE IMPROVEMENTS NECESSITATE THE OBLITERATION, TEMPORARY OBSTRUCTION, TEMPORARY REMOVAL OR RELOCATION OF ANY EXISTING TRAFFIC PAVEMENT MARKING, SUCH PAVEMENT MARKING SHALL BE RESTORED OR REPLACED WITH LIKE MATERIALS TO THE SATISFACTION OF THE CITY TRAFFIC ENGINEER.
6.	THE CONTRACTOR SHALL BE RESPONSIBLE FOR PROVIDING AND INSTALLING ALL PERMANENT SIGNS SHOWN ON THE PLANS. ALL NEW TRAFFIC SIGNS SHALL BE FABRICATED WITH DIAMOND GRADE VPI CLASS 6 REFLECTIVE SHEETING OR APPROVED EQUAL. ALL NEW TRAFFIC SIGNS, EXCEPT STREETNAME AND SCHOOL SPEED LIMIT SIGNS, SHALL HAVE M-SERIES 1160 OR APPROVED EQUIVALENT ANTI-GRAFFITI PROTECTIVE OVERLAY FILM; SCHOOL ZONE SIGNS SHALL HAVE M-SERIES 1150 ANTI-GRAFFITI PROTECTIVE OVERLAY FILM. STREET NAME SIGNS SHALL CONFORM IN THEIR ENTIRETY TO CURRENT CITY STANDARDS. ALL OTHER SIGNS SHALL BE STANDARD SIZE UNLESS OTHERWISE SPECIFIED ON THE PLANS. ALL SIGN POSTS SHALL BE INSTALLED IN ACCORDANCE WITH THE CURRENT CITY STANDARDS.
7.	WHEN A PROPOSED STREET LIGHT STANDARD IS LOCATED WITHIN FIVE (5') FEET OF ANY PROPOSED SIGN SHOWN ON THE PLANS TO BE MOUNTED ON SIGNPOST, THE SIGN SHALL BE MOUNTED ON THE STREET LIGHT STANDARD AND THE SIGNPOST SHALL BE ELIMINATED.
8.	ALL PERMANENT TRAFFIC CONTROL DEVICES CALLED FOR HEREON SHALL BE IN PLACE AND IN FINAL POSITION PRIOR TO ALLOWING ANY PUBLIC TRAFFIC onto the PORTIONS OF the ROAD(S) BEING IMPROVED HERE UNDER, REGARDLESS OF THE STATUS OF COMPLETION OF PAVING OR OTHER OFF-SITE IMPROVEMENTS CALLED FOR BY THESE PLANS.
9.	STREET SIGNS AND STOP SIGNS SHALL BE INSTALLED PER CITY STANDARD SPECIFICATIONS FOR PLACEMENT OF STREET NAME SIGNS.
10.	THE CONTRACTOR SHALL PROVIDE ALL NECESSARY TRAFFIC CONTROL DEVICES AND FLAGGERS TO INSURE THE SAFETY OF THE PUBLIC IN OR AROUND THE WORK AREA. THE CONTRACTOR SHALL HAVE A CERTIFIED ATSSA TRAFFIC CONTROL TECHNICIAN OR IMA WORK ZONE SAFETY SPECIALIST SET UP, MAINTAIN AND/OR REMOVE ALL TRAFFIC CONTROL DEVICES IN THE CITY OF LAS VEGAS RIGHT OF WAY.
11.	WORK IN PUBLIC STREETS, ONCE BEGUN, SHALL BE EXPEDITED TO COMPLETION SO AS TO PROVIDE MINIMUM INCONVENIENCE TO ADJACENT PROPERTY OWNERS AND TO THE TRAVELING PUBLIC.
12.	THE CONTRACTOR SHALL BE RESPONSIBLE FOR NOTIFYING CITIZENS AREA TRANSIT (C.A.T.) IF THE CONSTRUCTION INTERRUPTS OR RELOCATES A BUS STOP OR HAS AN ADVERSE EFFECT ON BUS SERVICE ON THAT STREET TO ARRANGE FOR TEMPORARY RELOCATION OF STOP.
13.	GUARDS SHALL BE OBTAINED BY CONTACTING THE METROPOLITAN POLICE DEPARTMENT SPECIAL EVENTS UNIT (PHONE # 828-3442) WHO WILL PROVIDE OFFICERS PROPERLY TRAINED IN TRAFFIC CONTROL, FEES FOR THE USE OF THESE OFFICERS SHALL BE SET BY METRO AND WILL BE PAID BY THE CONTRACTOR. THE CONTRACTOR IS RESPONSIBLE FOR ALL ARRANGEMENTS WITH METRO.
14.	ANY WORK WITHIN 300' OF A SIGNALIZED INTERSECTION WILL BE NIGHT WORK, UNLESS OTHERWISE DIRECTED BY THE CITY OF LAS VEGAS TRAFFIC ENGINEER.
15.	THE CONTRACTOR SHALL CONTACT THE TRAFFIC ENGINEERING DIVISION (TRANSPORTATION SECTION) THROUGH THE PROJECT'S OFFSITE INSPECTOR PRIOR TO INITIATING PAVING TO RECEIVE DIRECTION FOR ANY PERMANENT OR TEMPORARY MODIFICATIONS TO THE APPROVED DRAWINGS REGARDING FINAL PAVEMENT TRANSITIONS, MARKINGS AND SIGNING THAT ARE REQUIRED TO MATCH ADJACENT ROADWAY SEGMENTS. THE CONTRACTOR SHALL PROVIDE A DRAWING FOR APPROVAL BY THE TRAFFIC ENGINEERING DIVISION DEPICTING ANY ADJUSTMENTS TO THE FINAL PAVEMENT MARKINGS AND SIGNAGE, WHICH MAY INCLUDE OMITTING, ADDING OR MODIFYING PAVEMENT MARKINGS AND TRAFFIC CONTROL SIGNS SUCH THAT ADEQUATE TRANSITIONS AND LANE TERMINATIONS BETWEEN ADJACENT ROADWAY SEGMENTS ARE CONSTRUCTED.

CITY OF LAS VEGAS HYDRANT AND ACCESS GENERAL NOTES	
1.	ALL WORK SHALL BE DONE IN STRICT ACCORDANCE WITH THE LAS VEGAS FIRE AND RESCUE ADOPTED FIRE CODE ORDINANCE #6631 FOR HYDRANT INSTALLATION SPECIFICATIONS.
2.	ONLY FIRE HYDRANTS THAT ARE ON THE LAS VEGAS VALLEY WATER DISTRICTS - APPROVED PRODUCTS LIST ARE ALLOWED TO BE INSTALLED.
3.	A PERMIT IS REQUIRED FROM LAS VEGAS FIRE AND RESCUE FOR THE INSTALLATION OF ON-SITE WATER LINES AND FIRE HYDRANTS. THE PERMIT AND CONTRACTOR MATERIAL TEST CERTIFICATE FOR UNDERGROUND PIPING FORM SHALL BE OBTAINED FROM THE FIRE PROTECTION ENGINEER BEFORE COMMENCEMENT OF WORK. IFC § 105.6.15
4.	ON ANY RESIDENTIAL OR COMMERCIAL INSTALLATIONS, FIRE HYDRANTS SHALL BE INSTALLED AND FIRE APPARATUS ACCESS ROADS SHALL BE MAINTAINED BEFORE COMMENCEMENT OF ANY CONSTRUCTION CONSTRUCTION. ALL FIRE HYDRANTS SHALL BE IN GOOD WORKING ORDER AND SHALL BE CAPABLE OF DELIVERING THE REQUIRED FIRE FLOW. IFC § 3310, § 3312
5.	TO IDENTIFY THE FIRE HYDRANT LOCATIONS, THE CONTRACTOR SHALL PLACE A BLUE REFLECTIVE MARKER AT THE CENTER LINE OF THE STREET ADJACENT TO THE FIRE HYDRANTS. IFC § 507.5.7.3
6.	ALL UNDERGROUND INSPECTIONS, PORTURES AND FLUSH VERIFICATIONS OF ALL FIRE HYDRANTS AND FIRE LINES, SHALL BE CONDUCTED BEFORE COVERING THE LINES. CENTER LOADING IS ACCEPTABLE FOR THE HYDRO TESTS WITH PRIOR FIRE PREVENTION APPROVAL. IFC § 106.3
7.	ALL ON-SITE UNDERGROUND WATER MAINS AND MATERIALS SHALL BE U.L. LISTED, A.W.W.A APPROVED AND SHALL BE RATED FOR THE APPROPRIATE WORKING PRESSURE. IFC § 507.2.1, NFPA 21
8.	ALL FIRE APPARATUS ACCESS ROADS SHALL BE PAVED TO PROVIDE ALL-WEATHER DRIVING CAPABILITIES, AND ALL OTHER WORK NECESSARY PER PLANS SHALL BE COMPLETED BEFORE APPROVAL BY LAS VEGAS FIRE AND RESCUE, FIRE PREVENTION DIVISION. IFC § 507
9.	PRIVATE HYDRANTS SHALL BE PAINTED RED. IFC § 507.5.7.1
10.	PRIOR TO THE FINAL OCCUPANCY, A FIRE FLOW TEST SHALL BE WITNESSED BY LAS VEGAS FIRE AND RESCUE, FIRE PREVENTION DIVISION TO VERIFY AVAILABILITY OF THE REQUIRED FIRE FLOW. IFC § 507
11.	FIRE HYDRANT SPACING SHALL BE AS FOLLOWS: IFC § C102
12.	• RESIDENTIAL - 500 FT UNSPRINKLERED; 600 FT SPRINKLERED.
13.	• COMMERCIAL - 300 FT UNSPRINKLERED; 400 FT SPRINKLERED.
14.	WHERE THE WATER MAINS ARE EXTENDED ALONG STREETS OR NEW STREETS ARE INSTALLED WHERE FIRE HYDRANTS ARE NOT NEEDED FOR PROTECTION OF THE STRUCTURES, FIRE HYDRANTS SHALL BE INSTALLED AT A MAXIMUM OF 1000 FT SPACING. TO PROVIDE TRAFFIC ROUTES FOR TRANSPORTATION, FIRE HYDRANTS SHALL BE PROVIDED WITH MEDIAN DIVIDERS OR HAVE FOUR (4) OR MORE TRAFFIC LANES AND HAVE A TRAFFIC COUNT OF MORE THAN 30,000 PER DAY, HYDRANTS ARE REQUIRED ON EACH SIDE OF THE STREET SPACED AT 500 FT ON AN ALTERNATING BASIS. IFC § C102.8
15.	NO FIRE HYDRANTS SHALL BE LOCATED WITHIN THE RADIUS OF A CUL-DE-SAC OR WITHIN 20 FT OF THE PERIMETER OF THE RADIUS OF THE CUL-DE-SAC. IFC § 503.2.15
16.	NO FIRE HYDRANTS SHALL BE LOCATED WITHIN 6 FT OF ANY CURB RETURN, DRIVEWAY, POWER POLE, STREETLIGHT OR ANY OTHER OBSTRUCTION. IFC § C102.10
17.	A MAXIMUM DISTANCE FROM A FIRE HYDRANT TO A ONE-TWO FAMILY DWELLING SHALL NOT EXCEED 300 FT, AS MEASURED BY AN APPROVED ROUTE. IFC § 503
18.	THE MAXIMUM DISTANCE FROM A FIRE HYDRANT TO A FIRE DEPARTMENT CONNECTION (FDC) SHALL NOT EXCEED 100 FT, AS MEASURED BY AN APPROVED ROUTE. IFC § C102.7
19.	THE MAXIMUM DISTANCE FROM A HYDRANT TO THE END OF A DEAD-END STREET SHALL NOT EXCEED 200 FT. IFC § C102.6
20.	TWO (2) SOURCES OF SUPPLY ARE REQUIRED WHENEVER THERE IS 4 OR MORE FIRE HYDRANTS/SPRINKLER LEAD-INS ARE INSTALLED ON A SINGLE ROUTE TO HAVE TWO TAP LOCATIONS TO THE SOURCE OF WATER SUPPLY. SECTIONAL CONTROL VALVES SHALL BE INSTALLED SO THAT NO MORE THAN 2 FIRE HYDRANTS AND/OR FIRE SPRINKLER LEAD-INS CAN BE OUT OF SERVICE DUE TO A SERVICE INTERRUPTION. FOR SYSTEMS PERMITTED TO HAVE ONE SOURCE OF WATER SUPPLY, SECTIONAL CONTROL VALVES SHALL BE INSTALLED SO THAT NO MORE THAN 3 FIRE HYDRANTS AND/OR FIRE SPRINKLER LEAD-INS CAN BE OUT OF SERVICE DUE TO A SERVICE INTERRUPTION. IFC § C104
21.	ALL FIRE APPARATUS ACCESS ROADS SHALL BE PAVED TO PROVIDE ALL-WEATHER DRIVING CAPABILITIES, AND SHALL BE DESIGNED AND MAINTAINED TO SUPPORT THE IMPOSED LOADS OF THE FIRE APPARATUS. IFC § 503.2.3
22.	THE GRADIENT FOR THE FIRE APPARATUS ACCESS ROADS SHALL NOT EXCEED 12%. ANGLES OF APPROACH AND ANGLES OF DEPARTURE SHALL NOT EXCEED 6% FOR 25 FT PRIOR TO OR AFTER THE GRADE CHANGE. ADJACENT TO THE STRUCTURES GRADIENT SHALL NOT EXCEED 6%. IFC § 503.2.7, § 503.2.8
23.	THE TURNING RADIUS OF THE FIRE APPARATUS ACCESS ROADS SHALL BE NO LESS THAN 52 FT OUTSIDE AND 28 FT INSIDE TURNING RADIUS IFC § 503.2.4
24.	VERTICAL CLEARANCE OF ALL FIRE APPARATUS ACCESS ROADS SHALL NOT BE LESS THAN 13 FT 6 INS. IFC § 503.2.1
25.	FIRE DEPARTMENT ACCESS ROADS SHALL HAVE A MINIMUM UNOBSTRUCTED WIDTH OF NOT LESS THAN 33 FT WITH PARKING ON BOTH SIDES MEASURED TO FACE OF CURB. NOT LESS THAN 28 FT WIDE WITH PARKING RESTRICTED TO ONE SIDE MEASURED TO FACE OF CURB. NOT LESS THAN 24 FT WIDE WITH NO PARKING ON EITHER SIDE MEASURED TO FACE OF CURB. FIRE LINES THROUGH PARKING LOTS SHALL BE NOT LESS THAN 24 FT. IFC § 503.2.1
26.	A FIRE APPARATUS ACCESS ROAD SHALL BE REQUIRED WHEN ANY PORTION OF AN EXTERIOR WALL OF THE FIRST STORY IS LOCATED MORE THAN 150 FT FROM A FIRE DEPARTMENT VEHICLE ACCESS. IFC § 503.1.1
27.	APPROVED SECONDARY FIRE APPARATUS ACCESS SHALL BE PROVIDED FOR 200 OR MORE DWELLING UNITS, ROAD(S) WITH DEADENDS OR A SINGLE POINT OF ACCESS IN EXCESS OF 600 FT. CLV REGULATION AND MOV
28.	ALL DEAD-END FIRE APPARATUS ROADS AND/OR FIRE LINES, PUBLIC OR PRIVATE, IN EXCESS OF 150 FT IN LENGTH SHALL BE PROVIDED WITH AN APPROVED TURN AROUND HAVING A MINIMUM DIAMETER OF 81 FT. CLV REGULATION
29.	ALL FIRE APPARATUS ACCESS ROADS SHALL BE MARKED BY PLACING APPROVED SIGNS AT THE START OF THE DESIGNATED FIRE LANE, ONE SIGN AT THE END OF THE FIRE LANE AND WITH SIGNS AT INTERVALS OF 100 FT ALONG THE DESIGNATED FIRE LINES. SIGNS TO BE PLACED ON BOTH SIDES OF THE FIRE LANE. IF THE FIRE LANE IS ON EITHER SIDE OF THE ROAD, SIGNS TO BE INSTALLED NO HIGHER THAN 10 FT OR LESS THAN 6 FT FROM THE ROADWAY LEVEL. THE CURB ALONG OR ON THE PAVEMENT OR CEMENT (IF NO CURB IS PROVIDED) SHALL BE PAINTED WITH A RED WEATHER RESISTANT PAINT IN ADDITION TO THE SIGNS. IFC § 503.3
30.	ELECTRICALLY CONTROLLED ACCESS GATES SHALL BE PROVIDED WITH AN APPROVED EMERGENCY VEHICLE DETECTOR/RECEIVER SYSTEM IFC § 503.6
31.	WHERE STREETS ARE PROVIDED WITH MEDIAN DIVIDERS, OR HAVING FOUR OR MORE TRAVEL LANES AND A TRAFFIC COUNT OF MORE THAN 30,000 VEHICLES PER DAY, THE HYDRANT SHALL BE LOCATED TO DELIVER FIRE FLOW TO THE PROPOSED LOCATION SHALL BE UTILIZED ON THE SAME SIDE OF THE STREET AS THE PROPOSED DEVELOPMENT. CLV REGULATION

CITY OF LAS VEGAS GRADING NOTES	
1.	IN THE EVENT THAT ANY UNFORESEEN CONDITIONS NOT COVERED BY THESE NOTES ARE ENCOUNTERED DURING GRADING OPERATIONS, THE OWNER/ENGINEER SHALL BE IMMEDIATELY NOTIFIED FOR DIRECTION.
2.	IT SHALL BE THE RESPONSIBILITY OF THE CONTRACTOR TO PERFORM ALL NECESSARY CUTS AND FILLS WITHIN THE LIMITS OF THIS PROJECT AND THE RELATED OFF-SITE WORK, SO AS TO GENERATE THE DESIRED SUBGRADE, FINISH GRADES AND SLOPES SHOWN.
3.	CONTRACTOR SHALL TAKE FULL RESPONSIBILITY FOR ALL EXCAVATION, ADEQUATE SHORING SHALL BE DESIGNED AND PROVIDED BY THE CONTRACTOR TO PREVENT UNDERMINING OF ANY ADJACENT FEATURES OR FACILITIES AND/OR CAVING OF THE EXCAVATION.
4.	THE CONTRACTOR IS WARNED THAT AN EARTHWORK BALANCE WAS NOT NECESSARILY THE INTENT OF THIS PROJECT. ANY ADDITIONAL MATERIAL REQUIRED OR LEFTOVER MATERIAL FOLLOWING EARTHWORK OPERATIONS BECOMES THE RESPONSIBILITY OF THE CONTRACTOR.
5.	THE GRADING CONTRACTOR IS RESPONSIBLE TO COORDINATE WITH THE OWNER TO PROVIDE FOR THE REQUIREMENTS OF THE PROJECT STORM WATER POLLUTION PREVENTION PLAN (SWPPP) AND ASSOCIATED PERMIT.
6.	CONTRACTOR SHALL GRADE TO THE LINES AND ELEVATIONS SHOWN ON THE PLANS WITHIN THE FOLLOWING HORIZONTAL AND VERTICAL TOLERANCES AND DEGREES OF COMPACTION, IN THE AREAS INDICATED:
7.	HORIZONTAL VERTICAL COMPACTION
8.	A. PAVEMENT AREA SUBGRADE 0.1+ ±0.0 TO -0.1 SEE SOILS REPORT
9.	B. ENGINEERED FILL 0.5+ ±0.1 TO -0.1 SEE SOILS REPORT
10.	COMPACTION TESTING WILL BE PERFORMED BY THE OWNER OR HIS REPRESENTATIVE.
11.	ALL CUT AND FILL SLOPES SHALL BE PROTECTED UNTIL EFFECTIVE EROSION CONTROL HAS BEEN ESTABLISHED.
12.	THE USE OF POTABLE WATER WITHOUT A SPECIAL PERMIT FOR BUILDING OR CONSTRUCTION PURPOSES INCLUDING CONSOLIDATION OF BACKFILL OR DUST CONTROL IS PROHIBITED. THE CONTRACTOR SHALL OBTAIN ALL NECESSARY PERMITS FOR CONSTRUCTION WATER.
13.	THE CONTRACTOR SHALL MAINTAIN THE STREETS, SIDEWALKS AND ALL OTHER PUBLIC RIGHT-OF-WAY IN A CLEAN, SAFE AND USABLE CONDITION. ASPHALT ROCK OR CONCRETE SHALL BE PROTECTED FROM THE PUBLICLY OWNED PROPERTY DURING CONSTRUCTION AND UPON COMPLETION OF THE PROJECT. ALL ADJACENT PROPERTY, PRIVATE OR PUBLIC SHALL BE MAINTAINED IN A CLEAN, SAFE AND USABLE CONDITION.
14.	IN THE EVENT THAT ANY TEMPORARY CONSTRUCTION ITEM IS REQUIRED THAT IS NOT SHOWN ON THESE DRAWINGS, THE OWNER APPROVES THE TRAFFIC AND CITY ENGINEER. ANY DEVIATION FROM THE PLAN LOCATION WILL REQUIRE COMPLIANCE WITH SECTION 623 OF THE U.S.
15.	CONSTRUCTION INCLUDES DITCHES, BERMS, ROAD SIGNS AND BARRICADES, ETC

STORMWATER RUNOFF MANAGEMENT	
(REQUIRED FOR ALL SITES GREATER THAN 1 ACR (43,560 SQ.FT.))	
1.	THE OWNER, SITE DEVELOPER, CONTRACTOR, AND/OR THEIR AUTHORIZED AGENTS SHALL EACH DAY REMOVE ALL SEDIMENT, MUD, CONSTRUCTION DEBRIS, OR OTHER POTENTIAL POLLUTANTS THAT MAY HAVE BEEN DISCHARGED TO, OR ACCUMULATED IN, THE PUBLIC RIGHTS OF WAY OF CLARK COUNTY AS A RESULT OF CONSTRUCTION ACTIVITIES ASSOCIATED WITH THIS SITE. DEVELOPMENT OR CONSTRUCTION PROJECT. SUCH MATERIALS SHALL BE PREVENTED FROM ENTERING THE STORM SEWER SYSTEM.
2.	ADDITIONAL CONSTRUCTION SITE DISCHARGE BEST MANAGEMENT PRACTICES MAY BE REQUIRED OF THE OWNER AND HIS OR HER AGENTS DUE TO UNFORESEEN EROSION PROBLEMS OR IF THE SUBMITTED PLAN DOES NOT MEET THE PERFORMANCE STANDARDS SPECIFIED IN THE CITY OF LAS VEGAS AND THE LAS VEGAS VALLEY CONSTRUCTION SITE BEST MANAGEMENT PRACTICES MANUAL.
3.	TEMPORARY OR PERMANENT STABILIZATION PRACTICES WILL BE INSTALLED ON DISTURBED AREAS AS SOON AS PRACTICABLE AND NO LATER THAN 14 DAYS AFTER THE CONSTRUCTION ACTIVITY IN THAT PORTION OF THE SITE HAS TEMPORARILY OR PERMANENTLY CEASED. SOME EXCEPTION MAY APPLY. REFER TO THE NEVADA STORMWATER GENERAL PERMIT FOR CONSTRUCTION ACTIVITY NVR100000, SECTION III.A.5
4.	AT A MINIMUM, THE CONTRACTOR OR HIS AGENT SHALL INSPECT ALL DISTURBED AREAS, AREAS USED FOR STORAGE OF MATERIALS AND EQUIPMENT THAT ARE EXPOSED TO PRECIPITATION, VEHICLE ENTRANCE AND EXIT LOCATIONS, AND ALL BMPs WEEKLY, AND WITHIN 24 HOURS AFTER AN RAIN EVENT OF 0.5 INCHES OR MORE. THE CONTRACTOR OR HIS AGENT SHALL UPDATE OR MODIFY THE STORMWATER POLLUTION PREVENTION PLAN AS NECESSARY. SOME EXCEPTIONS TO WEEKLY INSPECTIONS MAY APPLY, SUCH AS SUSPENSION OF LAND DISTURBANCE ACTIVITIES. REFER TO THE NEVADA STORMWATER GENERAL PERMIT FOR CONSTRUCTION ACTIVITY NVR100000, SECTION III.A.12.
5.	ACCUMULATED SEDIMENT IN BMPs SHALL BE REMOVED WITHIN SEVEN DAYS AFTER A STORMWATER RUNOFF EVENT OR PRIOR TO THE NEXT ANTICIPATED STORM EVENT, WHICHEVER IS EARLIER. SEDIMENT MUST BE REMOVED WHEN BMP DESIGN CAPACITY HAS BEEN REDUCED BY 50 PERCENT OR MORE.

SOUTHWEST GAS CONSTRUCTION NOTES	
SOUTHERN NEVADA - SOUTHWEST GAS CORPORATION GENERAL NOTES	
1.	IN THE EVENT OF NATURAL GAS EMERGENCIES CALL 911 AND 1-877-860-6020
2.	MINIMUM HORIZONTAL AND VERTICAL CLEARANCES BETWEEN NATURAL GAS FACILITIES AND ANY UNDERGROUND UTILITIES AND/OR STRUCTURES, INCLUDING BUT NOT LIMITED TO WATER, SEWER, STORM DRAIN, COMMUNICATIONS, AND ELECTRIC SHALL BE AT LEAST 12-INCHES OR GREATER AS DICTATED BY LOCAL CODES AND STANDARDS
3.	(A) ANY DEVIATION FROM SPECIFIED MINIMUM CLEARANCES MUST BE APPROVED BY ALL AFFECTED UTILITIES AND/OR MUNICIPALITIES
4.	FOR VALVE ADJUSTMENT CONTACT 702-528-7881 14 DAYS PRIOR TO CONSTRUCTION
5.	IN THE EVENT OF A NATURAL GAS CONFLICT WITH PROPOSED UTILITIES AND STRUCTURES CONTACT 702-365-2099
6.	FOR STANDBY WHEN EXCAVATING (INCLUDING SAW CUTTING AND PAVEMENT REMOVAL) OVER OR NEAR HIGH PRESSURE GAS LINES CONTACT 702-778-8451 48 HOURS PRIOR TO CONSTRUCTION

CITY OF LAS VEGAS SEWER NOTES	
1.	ALL CONSTRUCTION AND MATERIALS SHALL BE IN ACCORDANCE WITH THE LATEST EDITION OF THE DESIGN AND CONSTRUCTION STANDARDS FOR WASTEWATER COLLECTION SYSTEMS AND THE "UNIFORM STANDARD SPECIFICATIONS FOR PUBLIC WORKS CONSTRUCTION OFF-SITE IMPROVEMENTS, CLARK COUNTY AREA, NEVADA, AS AMENDED. IT WILL BE THE RESPONSIBILITY OF THE CONTRACTOR TO BE AWARE OF THE CONTENTS OF THE ABOVE SPECIFICATIONS.
2.	IT SHALL BE THE CONTRACTOR'S RESPONSIBILITY TO PERFORM CONSTRUCTION AS PER PLANS. ANY ADDITIONS, DELETIONS, OR CHANGES SHALL FIRST MEET WITH THE APPROVAL OF THE CITY ENGINEER.
3.	CHISEL "S" OR "G" IN CURBS WHERE SEWER OR GAS LATERALS PASS UNDER THE CURB.
4.	POLYVINYL (PVC) SEWER PIPE SHALL MEET ASTM D-3034 SDR 35 SPECIFICATIONS, INSTALLED WITH SAND BEDDING AND BACKFILL OF TYPE II AGGREGATE BASE.
5.	ALL MANHOLES PAVED IN STREETS EIGHTY (80') FOOT R/W AND LARGER SHALL HAVE CONCRETE COLLARS. STREETS LESS THAN EIGHTY (80') FOOT R/W WILL REQUIRE RETROFIT IF PAVING DOES NOT CONFORM TO CITY STANDARDS AT THE MANHOLE.
6.	TEE SADDLES SHALL BE USED TO CONNECT SEWER LATERALS TO EXISTING MAIN LINES UP TO TWELVE INCH (12") DIAMETER. CONNECTIONS TO FIFTEEN INCH (15") OR LARGER MAINS SHALL REQUIRE SPECIAL PROCEDURES. IN LINE "Y" "S" SHALL BE USED ON LINES TWELVE INCHES (12") OR ABOVE.
7.	WATER MAINS SHALL BE PROTECTED IN ACCORDANCE WITH LVVWD STANDARDS WHENEVER A SEWER MAIN CROSSES OVER A WATER MAIN OR THE SEWER IS LESS THAN EIGHTEEN INCH (18") UNDER A WATER MAIN.
8.	ALL CONTRACTORS INSTALLING SEWER MAINS THAT WILL BE UNDER THE JURISDICTION OF THE CITY OF LAS VEGAS MUST BE STATE OF NEVADA CLASS "A" CONTRACTORS.
9.	THE CITY OF LAS VEGAS WILL NOT ACCEPT ANY SEWER MAINS WHICH HAVE A VERTICAL DEFLECTION OF MORE THAN ONE TENTH (0.1) OF A FOOT FROM THE APPROVED CONSTRUCTION PLANS AT ANY LOCATION. SEWER MAINS FOUND TO EXCEED THIS TOLERANCE WILL NOT BE REPAIRED OR EXCHANGED OR REPLACED TO THE SATISFACTION OF THE CITY ENGINEER PRIOR TO ACCEPTANCE BY THE CITY OF LAS VEGAS.
10.	INSTALLATION OF CURVED SEWER REQUIRES THE USE OF C-900 PIPE WHICH ALLOWS FOR PIPE DEFLECTION AT THE JOINTS.

LAS VEGAS VALLEY WATER DISTRICT (LVVWD) STANDARD NOTES	
LVVWD PROJECT # (REVISED 01/19/2021)	

1.	NO WORK SHALL BEGIN UNTIL THE WATER PLANS HAVE BEEN APPROVED FOR CONSTRUCTION BY THE LVVWD. FOLLOWING WATER PLAN APPROVAL, NOTICE SHALL BE GIVEN TO THE LVVWD COMMUNICATION SUPPORT CENTER (702-258-7171) TWO (2) WORKING DAYS PRIOR TO THE START OF CONSTRUCTION. FOR FUTURE INSPECTIONS, NOTICES MUST BE GIVEN BY 2:00 P.M. THE BUSINESS DAY PRIOR TO THE REQUESTED LVVWD INSPECTION. WHEN REQUESTING INSPECTIONS, PLEASE REFER TO THE PROJECT # IDENTIFIED ABOVE.
2.	ALL WORK SHALL CONFORM TO LVVWD STANDARD PLATES, DRAWINGS, AND SPECIFICATIONS, AND TO THE 2010 EDITION OF THE UNIFORM DESIGN AND CONSTRUCTION STANDARDS FOR POTABLE WATER SYSTEMS (UDACS). THE LATEST EDITION OF UDACS SHALL SUPERSEDE ANY CONFLICTS CONTAINED IN THE APPROVED DRAWINGS AND/OR SPECIFICATIONS.
3.	ALL WORK, EXCEPT AS MODIFIED BY THESE PLANS OR BY NOTE 2 ABOVE, SHALL BE DONE IN ACCORDANCE WITH THE MOST RECENT DRAFT OR EDITION OF THE UNIFORM STANDARD SPECIFICATIONS FOR PUBLIC WORKS CONSTRUCTION OFFSITE IMPROVEMENT, CLARK COUNTY AREA.
4.	A SINGLE PIPE LATERAL SHALL BE USED THROUGHOUT THE PROJECT UNLESS OTHERWISE APPROVED BY THE LVVWD.
5.	ALL SERVICE LATERALS TWO (2) INCHES IN DIAMETER AND SMALLER SHALL BE TYPE K COPPER TUBING WITH LVVWD APPROVED SERVICE SADDLES.
6.	ALL WATER METER BOXES SHALL BE LOCATED OUTSIDE OF DRIVEWAY AREAS.
7.	ALL VALVES SHALL BE LOCATED OUTSIDE OF DRIVEWAYS, VALLEY AND CURB GUTTERS.
8.	ALL WATER AND STORM DRAIN OR SANITARY SEWER CROSSINGS SHALL CONFORM TO SECTION 2.22 OF THE 2010 EDITION OF THE UDACS.
9.	ALL WATER FACILITIES AND APPURTENANCES SHALL BE DISINFECTED, PRESSURE TESTED, AND HAVE AN ACCEPTABLE PASSING HEALTH WATER SAMPLE OBTAINED, PRIOR TO OPERATION AND USE.
10.	THE CONTRACTOR MUST OBTAIN ALL METERS TWO (2) INCHES AND SMALLER FROM LVVWD CENTRAL STORES. TELEPHONE 702-258-3152 OR 702-258-3802, TWO (2) WORKING DAYS PRIOR TO METER PICKUP.
11.	ANY INTERRUPTION OF SERVICE MUST BE PERFORMED IN ACCORDANCE WITH UDACS SECTION 3.14.01, AND APPROVED BY THE LVVWD INSPECTION DIVISION PRIOR TO SHUTDOWN. PRIOR WRITTEN NOTIFICATION MUST BE GIVEN TO ALL AFFECTED CUSTOMERS.
12.	ALL WATER FACILITY CONSTRUCTION MATERIALS USED MUST BE AS LISTED ON THE LVVWD APPROVED PRODUCTS' LIST FOR NEW FACILITIES, LATEST REVISION, OR SPECIFICALLY APPROVED ON THESE PLANS BY SUBMITTING SHOP DRAWINGS.
13.	TELEPHONE "CALL BEFORE YOU DIG" AT "811" OR 1-800-642-2444.
14.	THE INSTALLATION OF LVVWD MUNICIPAL WATER FACILITIES WITHIN ALL STREETS IS ASSUMED TO BE IN COMPLIANCE WITH THE UNIFORM STANDARDS, INCLUDING THE PLACEMENT OF ASPHALT PAVING STREET SURFACES. ANY REPAIR WORK DONE BY THE LVVWD TO THE MUNICIPAL WATER FACILITIES WILL INCLUDE THE PLACEMENT OF AN APPROPRIATELY SIZED ASPHALT REPAIR PATCH ON THE STREET SURFACE.
15.	ANY DECORATIVE PAVING SURFACE WITHIN THE STREET IS THE RESPONSIBILITY OF THE OWNER'S ASSOCIATION, OR THE INDIVIDUAL PROPERTY OWNERS IF NO OWNER'S ASSOCIATION IS IN EXISTENCE, OR THE AGENCY HAVING JURISDICTION. DECORATIVE SURFACE MATERIALS PLACED WITHIN THE TEN FOOT EASEMENT ABUTTING A PUBLIC OR PRIVATE STREET, IF DISTURBED BY THE LVVWD DURING THE REPAIR OR OPERATION OF ITS FACILITIES, WILL BE REPLACED BY LVVWD WITH AN APPROPRIATELY SIZED PLAIN FINISH CONCRETE PATCH. THE LVVWD WILL NOT RESTORE, OR WILL NOT BE RESPONSIBLE FOR THE RESTORATION OF, ANY DECORATIVE PAVING SURFACE WITHIN THE STREET. THE LVVWD WILL NOT ATTEMPT TO MATCH COLOR OR FINISH OF ANY ADJACENT MATERIALS.

NO LEAD COMPLIANCE NOTE:	
TO COMPLY WITH THE FEDERAL SAFE DRINKING WATER ACT, ALL WATER BRASS PRODUCTS PROPOSED TO BE RELOCATED, OR INSTALLED AS NEW MUST BE INSTALLED WITH THE LEAD FREE APPROVED PRODUCT. THE OLD LEADED PRODUCT MAY NOT BE REUSED.	
APPROVED FOR CONSTRUCTION	
PROJECT NO. _____	FIRST APPROVED DATE: _____

CITY OF LAS VEGAS STREETLIGHT NOTES	
1.	ALL STREET LIGHTING INSTALLATIONS SHALL BE IN ACCORDANCE WITH THE STREET LIGHTING PLANS, THE "UNIFORM STANDARD SPECIFICATIONS FOR PUBLIC WORKS CONSTRUCTION OFF-SITE IMPROVEMENTS, CLARK COUNTY AREA, NEVADA," LATEST REVISION, AND THE "UNIFORM STANDARD DRAWINGS FOR PUBLIC WORKS CONSTRUCTION OFF-SITE IMPROVEMENTS, CLARK COUNTY AREA, NEVADA," LATEST REVISION.
2.	DESIGN PROFESSIONAL AND CONTRACTOR SHALL VERIFY CITY'S LATEST LED FIXTURE SPECIFICATIONS AND APPROVED FIXTURES PER CLV WEBSITE, UNDER BUILDING AND SAFETY FORMS, PRIOR TO ORDERING MATERIALS.
3.	LUMINAIRES SHALL BE MARKED TO INDICATE INSTALLATION ORIENTATION, AND SHALL HAVE EXTERNAL LABELS PER ANSI C136 THAT INDICATE WATTAGE AND ARE CLEARLY VISIBLE FROM STREET LEVEL.
4.	NO DEVIATION OF STREET LIGHT, PULL BOX, CONDUITS, ETC., LOCATIONS SHALL BE PERMITTED WITHOUT WRITTEN APPROVAL OF THE TRAFFIC AND CITY ENGINEER. ANY DEVIATION FROM THE PLAN LOCATION WILL REQUIRE COMPLIANCE WITH SECTION 623 OF THE U.S.
5.	ALL EXISTING STREET LIGHTING SHALL REMAIN OPERATIONAL DURING CONSTRUCTION IN ACCORDANCE WITH SECTION 623 G.03.01 OF THE U.S.
6.	ALL EMPTY CONDUIT SHALL HAVE AT LEAST ONE GREEN NO. #8 AWG WIRE INSTALLED AS TRACER WIRE IN ACCORDANCE WITH SECTION 623 G.02.01 OF THE U.S. PRIOR TO THE START OF CONSTRUCTION AND FINAL INSPECTION.
7.	ANY STRUCTURE SUCH AS BLOCK WALLS, CHAIN LINK FENCES, RETAINING WALLS, ETC., SHALL LEAVE A MINIMUM CLEARANCE IN COMPLIANCE WITH USD NO. 320A WHEN POLE IS INSTALLED BETWEEN SIDEWALK, AND SHALL AT NO TIME COMPLETELY ENCLOSE THE STREET LIGHTING POLE.
8.	AS-BUILT DRAWINGS SHALL BE SUPPLIED TO THE TRAFFIC ENGINEERING DIVISION PRIOR TO ANY PRE-FINAL INSPECTION. THE AS-BUILT DRAWING NEEDS TO BE STAMPED AS-BUILT AND SIGNED BY THE PREPARER.
9.	SERVICE POINTS SHALL BE COORDINATED WITH NV ENERGY, AND WHEREVER POSSIBLE, BE LOCATED NEAR THE CENTER OF THE CIRCUIT. SERVICE POINTS SHALL BE SHOWN ON THE PLANS.
10.	NEW STREETLIGHT SERVICES SHALL BE 200 AMP PAD MOUNT AND SHALL PROVIDE CAPACITY FOR 20 OR 24 AVAILABLE CIRCUITS.
11.	WHEREVER THERE IS AN OVERHEAD UTILITY THAT MAY CONFLICT WITH THE INSTALLATION OF STREETLIGHTING CIRCUITS AND/OR POLES, THE CONFLICTS MUST BE RESOLVED BETWEEN THE DEVELOPER AND THE UTILITIES INVOLVED BEFORE THE INSTALLATION OF THE STREETLIGHTS. AT NO EXCEPT LAS VEGAS.
12.	THE CONTRACTOR SHALL FURNISH COMPLETE CONDUIT, WIRE, ETC. FROM SERVICE TO TRANSFORMERS AND CONTROL SYSTEMS IF REQUIRED ON THE PLANS.

Call before you Dig

AVOID HITTING UNDERGROUND UTILITIES, IT'S COSTLY.

Call before you Dig

AVOID HITTING OVERHEAD POWER LINES, IT'S COSTLY.

Call before you Dig

Underground

1-800-642-2444

1-702-432-5300

1-702-227-2929

Call before you Dig

Underground

1-800-642-2444

1-702-432-5300

1-702-227-2929

LEGEND	
EXISTING	PROPOSED
ROW OR PROPERTY LINE	ROW OR PROPERTY LINE
EASEMENT LINE	EASEMENT LINE
CENTERLINE	CENTERLINE
CURB	CURB
VALLEY GUTTER	VALLEY GUTTER
EDGE OF PAVEMENT	EDGE OF PAVEMENT
SIDEWALK	SIDEWALK
SIDEWALK RAMP	SIDEWALK RAMP
DRIVEWAY	DRIVEWAY
SAWCUT LINE	SAWCUT LINE
RETAINING WALL	RETAINING WALL
FLOOD WALL	FLOOD WALL
WROUGHT IRON VEHICULAR GATES	WROUGHT IRON VEHICULAR GATES
WROUGHT IRON PEDESTRIAN GATES	WROUGHT IRON PEDESTRIAN GATES
INDEX CONTOURS	INDEX CONTOURS
INTERMEDIATE CONTOURS	

UTILITY LOCATIONS SHOWN HEREON ARE APPROXIMATE ONLY. IT SHALL BE THE CONTRACTORS RESPONSIBILITY TO DETERMINE THE EXACT HORIZONTAL AND VERTICAL LOCATION OF ALL EXISTING UNDERGROUND OR OVERHEAD UTILITIES PRIOR TO COMMENCING CONSTRUCTION. NO REPRESENTATION IS MADE THAT ALL EXISTING UTILITIES ARE SHOWN HEREON. THE ENGINEER ASSUMES NO RESPONSIBILITY FOR UTILITIES NOT SHOWN OR UTILITIES NOT SHOWN IN THEIR PROPER LOCATION. CONTRACTOR TO NOTIFY ENGINEER OF ANY CHANGES OR DISCREPANCIES,

FAST

Call
before you
UnderGround
1-702-432-5300
FREeway and ARTERIAL
SYSTEM OF TRANSPORTATION

AVOID HITTING OVERHEAD
POWER LINES. IT'S COSTLY.

CALL BEFORE
YOU DO
OVERHEAD

1-702-227-2929

BENCHMARK

MONUMENT ID: USDA (1934) 19

U.S. DEPARTMENT OF AGRICULTURE BRASS DISC AT THE
SOUTHWEST CORNER OF U.S. 95 AND KYLE CANYON ROAD

ELEVATION = 2817.61 FEET, 858.810 METERS
NAVD 88 DATUM

PER THE CITY OF LAS VEGAS BENCHMARK BOOK-2008
ADJUSTMENT (UPDATED 05/24/2010)

BASIS OF BEARINGS

NORTH 00°01'50" WEST, BEING THE BEARING OF THE EAST LINE OF THE NORTHEAST QUARTER (NE1/4) OF SECTION 6, TOWNSHIP 19 SOUTH, RANGE 60 EAST, M.D.M., CITY OF LAS VEGAS, CLARK COUNTY, NEVADA, AS SHOWN BY MAP THEREOF IN FILE 151, PAGE 14 OF SURVEYS IN THE CLARK COUNTY RECORDER'S OFFICE, NEVADA,

BUILDING PERMIT NOTE

ALL STRUCTURES SHOWN OR INDICATED ON THIS SUBMITTAL WITHIN THE PROPERTY REQUIRE A BUILDING PERMIT APPLICATION AND SUBMITTAL THIS INCLUDES BUILDINGS, ABOVE GROUND TANKS, SIGNS, RETAINING WALLS, FENCES, TRASH ENCLOSURES, SHADE STRUCTURES, STAIRWAYS, RAMPS, LIGHT POLES, LIGHT BOLLARDS, ETC. THIS DOES NOT INCLUDE ANY FLOOD CONTROL STRUCTURE SUCH AS PILES, CULVERTS, ARCH CULVERTS, HEADWALLS, ETC. THIS DOES NOT INCLUDE ANY ROAD WORK OR PUBLIC STREET RIGHT-OF-WAY. THIS DOES NOT INCLUDE PRIVATE STREETS. THE REVIEW OF CIVIL IMPROVEMENT AND/OR GRADING PLANS DOES NOT INCLUDE ANY REVIEW OF ANY STRUCTURE THAT REQUIRES A BUILDING PERMIT APPLICATION."

FLOOD ZONE NOTE

ACCORDING TO THE FEMA FLOOD INSURANCE RATE MAP (FIRM) COMMUNITY PANEL NUMBERS 32003C 1735E DATED SEPTEMBER 27, 2002, THE SITE IS LOCATED IN A ZONE "X".

SURVEY MONUMENT NOTE

OWNER RESPONSIBLE TO PROVIDE SURVEY MONUMENTATION AS
REQUIRED BY CITY OF LAS VEGAS AND CLARK COUNTY UNIFORM
STANDARD DRAWING NUMBER 243. OWNER IS ALSO RESPONSIBLE TO
REPLACE ALL SURVEY MONUMENTATION DAMAGED, DESTROYED, OR
OBSCURED DURING CONSTRUCTION.

SIGHT VISIBILITY ZONE

NO STRUCTURE, VEGETATION, OR OBJECTS OF ANY KIND IS PERMITTED OVER TWENTY-FOUR (24) INCHES IN HEIGHT (MEASURED FROM THE TOP OF THE ADJACENT CURB IF CURB EXISTS) WITHIN THE SIGHT VISIBILITY ZONES.

ENGINEERS NOTES

1. CONTRACTOR IS RESPONSIBLE FOR DUST AND EROSION CONTROL DURING CONSTRUCTION.
2. SEE DETAIL SHEET FOR ON-SITE PAVEMENT SECTIONS. CONTRACTOR TO VERIFY WITH SOILS REPORT.
3. SEE FINAL MAP FOR EXACT PROPERTY LINE DIMENSIONS.
4. ENGINEER TO BE NOTIFIED OF ANY DISCREPANCIES IMMEDIATELY.
5. THESE PLANS SHALL NOT, IN PART OR IN WHOLE, BE USED FOR CONSTRUCTION UNTIL APPROVED AND SIGNED BY THE GOVERNING AGENCIES
6. ALL GRADING SHALL CONFORM TO SOILS REPORT RECOMMENDATIONS.
7. DURING CONSTRUCTION, SURVEYORS AND CONTRACTORS MUST VERIFY THAT ALL STREETS AND LOTS HAVE POSITIVE DRAINAGE. SAME MUST UTILIZE AT LEAST 2% GRADES ON VERTICAL TRANSVERSE, SAME MUST SLOPE.
8. SOIL REPORT NOTE:
GRADING SHALL BE IN ACCORDANCE
WITH SOILS REPORT PREPARED BY:
ENGINEER: GEOTEK
PROJECT NO. 16260.C
DATED: JULY 19, 2021
9. CUT/FILL ESTIMATES
EXISTING TO FINISH GRADE ELEVATIONS
NET CUT: 3,300 CY
NET FILL: 3,300 CY
10. SEE DETAIL 23/D-2 FOR TYPICAL LOT DRAINAGE
11. FOR STORMWATER RUNOFF MANAGEMENT NOTES REFER TO SHEET N-1

CONSTRUCTION NOTES

- 1 CONSTRUCT AC PAVEMENT PER DETAILS 1 & 2 ON SHEET D-1
- 2 CONSTRUCT 30" MODIFIED ROLL CURB PER CCAUSD #217.1
- 3 CONSTRUCT 8" CROSS GUTTER PER CCAUSD #228
- 4 CONSTRUCT 8" MODIFIED (ROLLED CURB) CROSS GUTTER PER CCAUSD #228
- 5 CONSTRUCT 5" SIDEWALK PER CCAUSD #234 (6" THICK WHEN ADJACENT TO ROLL CURB)
- 6 CONSTRUCT SIDEWALK RAMPS USING ARMOR TILE TRUNCATED DOWNS OR EQUIVALENT PER CCAUSD #235 (CASE I) SEE PLAN AND PROFILE SHEET CURVE TABLES FOR "A" AND "B" DIMENSIONS
- 7 REMOVE EXISTING RIPRAP

NOTE
ALL ONSITE STORM DRAINS AND THE
ASSOCIATED FACILITIES ARE PRIVATELY
OWNED AND TO BE PRIVATELY MAINTAINED
BY THE HOA

NOTE
ALL PRIVATE STREETS ARE P.U.E., PUBLIC
SEWER EASEMENTS AND PUBLIC DRAINAGE
EASEMENTS TO BE PRIVATELY MAINTAINED
BY HOA.

SEWER EASEMENT NOTE

NO STRUCTURES AND NO TREES OR VEGETATION TALLER
THAN THREE FEET ALLOWED WITHIN CLV SEWER EASEMENT



I HEREBY CERTIFY THAT THIS GRADING PLAN IS IN CONFORMANCE WITH THE APPROVED DRAINAGE STUDY DS #- ON FILE WITH CITY OF LAS VEGAS FOR THIS PROJECT.

CHRISTOPHER R ZRINYI, PE NO. 13976

DATE _____

REV	DESCRIPTION	BY	APPD	DATE
	DATE: November 03, 2021			
	HORIZ. SCALE: 1" = 30'			
	VERT. SCALE: N/A			
	DRAWN BY: SRC/NS			
	DESIGNED BY: SC			
	CHECKED BY: CZ			
	APPROVED BY: CZ			
	PROJECT #:			
	4320.001.4			

Woodside Homes®
BETTER BY DESIGN

RCI ENGINEERING
 500 SOUTH RANCHO DRIVE, SUITE 17, LAS VEGAS, NV 89106
 MAIN: 702.453.0800 FAX: 702.453.0801

IMPROVEMENT PLANS FOR
ESTRELLA AT SUNSTONE UNIT 2
A SINGLE FAMILY RESIDENTIAL SUBDIVISION
GRADING PLAN (SHEET 1 OF 3)

DRAWING
G-1
SHT **3** OF **19**
CLV DRAWING NUMBER
CLV PROJECT #

O:\4320_Woodside\0014_Sunstone C\civil\IPS\U2\S0003_G-1_SUNSTONE_C UNIT 2.dwg sclark 11/03/21 5:41pm

DISCLAIMER NOTE:

UTILITY LOCATIONS SHOWN HEREON ARE APPROXIMATE ONLY. IT SHALL BE THE CONTRACTORS RESPONSIBILITY TO DETERMINE THE EXACT HORIZONTAL AND VERTICAL LOCATION OF ALL EXISTING UNDERGROUND OR OVERHEAD UTILITIES PRIOR TO COMMENCING CONSTRUCTION. NO REPRESENTATION IS MADE THAT ALL EXISTING UTILITIES ARE SHOWN HEREON. THE ENGINEER ASSUMES NO RESPONSIBILITY FOR UTILITIES NOT SHOWN OR UTILITIES NOT SHOWN IN THEIR PROPER LOCATION. CONTRACTOR TO NOTIFY ENGINEER OF ANY CHANGES OR DISCREPANCIES.

Call before you Dig
Call
811
OR
1-800-642-2444

FAST
Call before you UnderGround
1-702-432-5300
FREEWAY AND ARTERIAL SYSTEM OF TRANSPORTATION

AVOID HITTING OVERHEAD POWER LINES. IT'S COSTLY.
CALL BEFORE YOU DO OVERHEAD
1-702-227-2929

NOTE

ALL ON-SITE STORM DRAINS AND THE ASSOCIATED FACILITIES ARE PRIVATELY OWNED AND TO BE PRIVATELY MAINTAINED BY THE HOA

NOTE

ALL PRIVATE STREETS ARE P.U.E., PUBLIC SEWER EASEMENTS AND PUBLIC DRAINAGE EASEMENTS TO BE PRIVATELY MAINTAINED BY HOA.
SEWER EASEMENT NOTE
NO STRUCTURES AND NO TREES OR VEGETATION TALLER THAN THREE FEET ALLOWED WITHIN CLV SEWER EASEMENT

BENCHMARK

MONUMENT ID: USDA (1934) 19

U.S. DEPARTMENT OF AGRICULTURE BRASS DISC AT THE SOUTHWEST CORNER OF U.S. 95 AND KYLE CANYON ROAD

ELEVATION = 2817.61 FEET, 858.810 METERS
NAVD 88 DATUM

PER THE CITY OF LAS VEGAS BENCHMARK BOOK--2008
ADJUSTMENT (UPDATED 05/24/2010)

BASIS OF BEARINGS

NORTH 00°01'50" WEST, BEING THE BEARING OF THE EAST LINE OF THE NORTHEAST QUARTER (NE1/4) OF SECTION 6, TOWNSHIP 19 SOUTH, RANGE 60 EAST, M.D.M. CITY OF LAS VEGAS, CLARK COUNTY, NEVADA, AS SHOWN BY MAP THEREOF IN FILE 151, PAGE 14 OF SURVEYS IN THE CLARK COUNTY RECORDER'S OFFICE, NEVADA.

BUILDING PERMIT NOTE

ALL STRUCTURES SHOWN OR INDICATED ON THIS SUBMITTAL WITHIN THE PROPERTY REQUIRE A BUILDING PERMIT APPLICATION AND SUBMITTAL. THIS INCLUDES BUILDINGS, ABOVE GROUND TANKS, SIGNS, RETAINING WALLS, FENCES, TRASH ENCLOSURES, SHADE STRUCTURES, STAIRWAYS, RAMPS, LIGHT POLES, LIGHT BOLLARDS, ETC. THIS DOES NOT INCLUDE ANY FLOOD CONTROL STRUCTURE SUCH AS PIPES, CULVERTS, ARCH CULVERTS, HEADWALLS, ETC. THIS DOES NOT INCLUDE ANY WORK WITHIN A PUBLIC STREET RIGHT-OF-WAY. THIS DOES NOT INCLUDE PRIVATE STREETS. THE REVIEW OF CIVIL IMPROVEMENT AND/OR GRADING PLANS DOES NOT INCLUDE ANY REVIEW OF ANY STRUCTURE THAT REQUIRES A BUILDING PERMIT APPLICATION."

FLOOD ZONE NOTE

ACCORDING TO THE FEMA FLOOD INSURANCE RATE MAP (FIRM) COMMUNITY PANEL NUMBERS 32003C 1735E DATED SEPTEMBER 27, 2002, THE SITE IS LOCATED IN A ZONE "X".

SURVEY MONUMENT NOTE

OWNER RESPONSIBLE TO PROVIDE SURVEY MONUMENTATION AS REQUIRED BY CITY OF LAS VEGAS AND CLARK COUNTY UNIFORM STANDARD DRAWING NUMBER 243. OWNER IS ALSO RESPONSIBLE TO REPLACE ALL SURVEY MONUMENTATION DAMAGED, DESTROYED, OR OBSCURED DURING CONSTRUCTION.

SIGHT VISIBILITY ZONE

NO STRUCTURE, VEGETATION, OR OBJECTS OF ANY KIND IS PERMITTED OVER TWENTY-FOUR (24) INCHES IN HEIGHT (MEASURED FROM THE TOP OF THE ADJACENT CURB IF CURB EXISTS) WITHIN THE SIGHT VISIBILITY ZONES.

ENGINEERS NOTES

- CONTRACTOR IS RESPONSIBLE FOR DUST AND EROSION CONTROL DURING CONSTRUCTION.
- SEE DETAIL SHEET FOR ON-SITE PAVEMENT SECTIONS. CONTRACTOR TO VERIFY WITH SOILS REPORT.
- SEE FINAL MAP FOR EXACT PROPERTY LINE DIMENSIONS.
- ENGINEER TO BE NOTIFIED OF ANY DISCREPANCIES IMMEDIATELY.
- THESE PLANS SHALL NOT, IN PART OR IN WHOLE, BE USED FOR CONSTRUCTION UNTIL APPROVED AND SIGNED BY THE GOVERNING AGENCIES.
- ALL GRADING SHALL CONFORM TO SOILS REPORT RECOMMENDATIONS.
- DURING CONSTRUCTION, SURVEYORS AND CONTRACTORS MUST VERIFY THAT ALL STREETS AND LOTS HAVE POSITIVE DRAINAGE. SAME MUST UTILIZE AT LEAST THREE GRADES ON VERTICAL TANGENTS TO VERIFY SLOPES.
- SOIL REPORT NOTE:
GRADING SHALL BE IN ACCORDANCE WITH SOILS REPORT PREPARED BY:
ENGINEER: GEOTEK
PROJECT NO. 16360.C
DATED: JULY 19, 2021
- CUT/FILL ESTIMATES
EXISTING TO FINISH GRADE ELEVATIONS
NET CUT: 3,300 CY
NET FILL: 3,300 CY
- SEE DETAIL 23/D-2 FOR TYPICAL LOT DRAINAGE
- FOR STORMWATER RUNOFF MANAGEMENT NOTES REFER TO SHEET N-1

CONSTRUCTION NOTES

- CONSTRUCT AC PAVEMENT PER DETAILS 1 & 2 ON SHEET D-1
- CONSTRUCT 30" MODIFIED ROLL CURB PER CCAUSD #217.1
- CONSTRUCT 8" CROSS GUTTER PER CCAUSD #228
- CONSTRUCT 8" MODIFIED (ROLLED CURB) CROSS GUTTER PER CCAUSD #228
- CONSTRUCT 5" SIDEWALK PER CCAUSD #234
(6" THICK WHEN ADJACENT TO ROLL CURB)
- CONSTRUCT SIDEWALK RAMPS USING ARMOR TILE TRUNCATED DOMES OR EQUIVALENT PER CCAUSD #235 (CASE 1) SEE PLAN AND PROFILE SHEET CURVE TABLES FOR "A" AND "B" DIMENSIONS
- REMOVE EXISTING RIPRAP



DISCLAIMER NOTE:

UTILITY LOCATIONS SHOWN HEREON ARE APPROXIMATE ONLY. IT SHALL BE THE CONTRACTORS RESPONSIBILITY TO DETERMINE THE EXACT HORIZONTAL AND VERTICAL LOCATION OF ALL EXISTING UNDERGROUND OR OVERHEAD UTILITIES PRIOR TO COMMENCING CONSTRUCTION. NO REPRESENTATION IS MADE THAT ALL EXISTING UTILITIES ARE SHOWN HEREON. THE ENGINEER ASSUMES NO RESPONSIBILITY FOR UTILITIES NOT SHOWN OR UTILITIES NOT SHOWN IN THEIR PROPER LOCATION. CONTRACTOR TO NOTIFY ENGINEER OF ANY CHANGES OR DISCREPANCIES.

Call before you Dig
AVOID CUTTING UNDERGROUND
UTILITY LINES. IT'S COSTLY.



1-800-642-2444



Call before you
UnderGround
1-702-432-5300
FREEWAY AND ARTERIAL
SYSTEM OF TRANSPORTATION

AVOID HITTING OVERHEAD
POWER LINES. IT'S COSTLY.



1-702-227-2929

BENCHMARK

MONUMENT ID: USDA (1934) 19

U.S. DEPARTMENT OF AGRICULTURE BRASS DISC AT THE
SOUTHWEST CORNER OF U.S. 95 AND KYLE CANYON ROAD

ELEVATION = 2817.61 FEET, 858.810 METERS
NAVD 88 DATUM

PER THE CITY OF LAS VEGAS BENCHMARK BOOK--2008
ADJUSTMENT (UPDATED 05/24/2010)

BASIS OF BEARINGS

NORTH 00°01'50" WEST, BEING THE BEARING OF THE
EAST LINE OF THE NORTHEAST QUARTER (NE1/4) OF
SECTION 6, TOWNSHIP 19 SOUTH, RANGE 60 EAST,
M.D.M. CITY OF LAS VEGAS, CLARK COUNTY, NEVADA,
AS SHOWN BY MAP THEREOF IN FILE 151, PAGE 14 OF
SURVEYS IN THE CLARK COUNTY RECORDER'S OFFICE,
NEVADA.

BUILDING PERMIT NOTE

ALL STRUCTURES SHOWN OR INDICATED ON THIS SUBMITTAL
WITHIN THE PROPERTY REQUIRE A BUILDING PERMIT
APPLICATION AND SUBMITTAL THIS INCLUDES BUILDINGS, ABOVE
GROUND TANKS, SIGNS, RETAINING WALLS, FENCES, TRASH
ENCLOSURES, SHADE STRUCTURES, STAIRWAYS, RAMPS, LIGHT
POLES, LIGHT BOLLARDS, ETC. THIS DOES NOT INCLUDE ANY
FLOOD CONTROL STRUCTURE SUCH AS PIPES, CULVERTS, ARCH
CULVERTS, HEADWALLS, ETC. THIS DOES NOT INCLUDE ANY
WORK WITHIN A PUBLIC STREET RIGHT-OF-WAY, THIS DOES
NOT INCLUDE PRIVATE STREETS. THE REVIEW OF CIVIL
IMPROVEMENT AND/OR GRADING PLANS DOES NOT INCLUDE
ANY REVIEW OF ANY STRUCTURE THAT REQUIRES A BUILDING
PERMIT APPLICATION.

FLOOD ZONE NOTE

ACCORDING TO THE FEMA FLOOD INSURANCE RATE MAP
(FIRM) COMMUNITY PANEL NUMBERS 32003C 1735E DATED
SEPTEMBER 27, 2002, THE SITE IS LOCATED IN A ZONE "X".

SURVEY MONUMENT NOTE

OWNER RESPONSIBLE TO PROVIDE SURVEY MONUMENTATION AS
REQUIRED BY CITY OF LAS VEGAS AND CLARK COUNTY UNIFORM
STANDARD DRAWING NUMBER 243. OWNER IS ALSO RESPONSIBLE TO
REPLACE ALL SURVEY MONUMENTATION DAMAGED, DESTROYED, OR
OBSOLETE DURING CONSTRUCTION.

SIGHT VISIBILITY ZONE

NO STRUCTURE, VEGETATION, OR OBJECTS OF ANY KIND IS
PERMITTED OVER TWENTY-FOUR (24) INCHES IN HEIGHT
(MEASURED FROM THE TOP OF THE ADJACENT CURB IF CURB
EXISTS) WITHIN THE SIGHT VISIBILITY ZONES.

ENGINEERS NOTES

1. CONTRACTOR IS RESPONSIBLE FOR DUST AND EROSION CONTROL DURING
CONSTRUCTION.
2. SEE DETAIL SHEET FOR ON-SITE PAVEMENT SECTIONS. CONTRACTOR TO
VERIFY WITH SOILS REPORT.
3. SEE FINAL MAP FOR EXACT PROPERTY LINE DIMENSIONS.
4. ENGINEER TO BE NOTIFIED OF ANY DISCREPANCIES IMMEDIATELY.
5. THESE PLANS SHALL NOT, IN PART OR IN WHOLE, BE USED FOR
CONSTRUCTION UNTIL APPROVED AND SIGNED BY THE GOVERNING AGENCIES.
6. ALL GRADING SHALL CONFORM TO SOILS REPORT RECOMMENDATIONS.
7. DURING CONSTRUCTION, SURVEYORS AND CONTRACTORS MUST VERIFY THAT
ALL STREETS AND LOTS HAVE POSITIVE DRAINAGE. SAME MUST UTILIZE
AT LEAST THREE GRADES ON VERTICAL TANGENTS TO VERIFY SLOPES.
8. SOIL REPORT NOTE:
GRADING SHALL BE IN ACCORDANCE
WITH SOILS REPORT PREPARED BY:
ENGINEER: GEOTEK
PROJECT NO. 16260.C
DATED: JULY 19, 2021
9. CUT/FILL ESTIMATES
EXISTING TO FINISH GRADE ELEVATIONS
NET CUT: 3,300 CY
NET FILL: 3,300 CY
10. SEE DETAIL 23/D-2 FOR TYPICAL LOT DRAINAGE
11. FOR STORMWATER RUNOFF MANAGEMENT NOTES REFER TO SHEET N-1

CONSTRUCTION NOTES

1. CONSTRUCT AC PAVEMENT PER DETAILS 1 & 2 ON SHEET
D-1
2. CONSTRUCT 30" MODIFIED ROLL CURB PER CCAUSD #217.1
3. CONSTRUCT 8" CROSS GUTTER PER CCAUSD #228
4. CONSTRUCT 8" MODIFIED (ROLLED CURB) CROSS GUTTER PER
CCAUSD #228
5. CONSTRUCT 5" SIDEWALK PER CCAUSD #234
(6" THICK WHEN ADJACENT TO ROLL CURB)
6. CONSTRUCT SIDEWALK RAMPS USING ARMOR TILE TRUNCATED
DOMES OR EQUIVALENT PER CCAUSD #235 (CASE I) SEE PLAN
AND PROFILE SHEET CURVE TABLES FOR "A" AND "B" DIMENSIONS
7. REMOVE EXISTING RIPRAP

NOTE



ALL ON-SITE STORM DRAINS AND THE
ASSOCIATED FACILITIES ARE PRIVATELY
OWNED AND TO BE PRIVATELY MAINTAINED
BY THE HOA

NOTE

ALL PRIVATE STREETS ARE P.U.E., PUBLIC
SEWER EASEMENTS AND PUBLIC DRAINAGE
EASEMENTS TO BE PRIVATELY MAINTAINED
BY HOA.

SEWER EASEMENT NOTE

NO STRUCTURES AND NO TREES OR VEGETATION TALLER
THAN THREE FEET ALLOWED WITHIN CLV SEWER EASEMENT

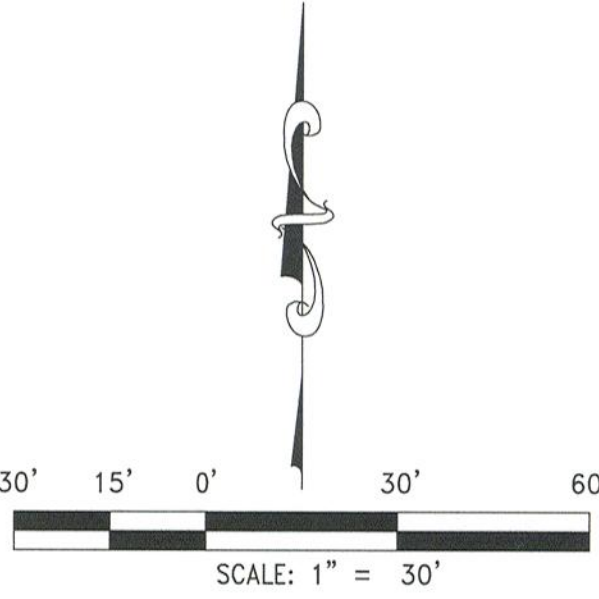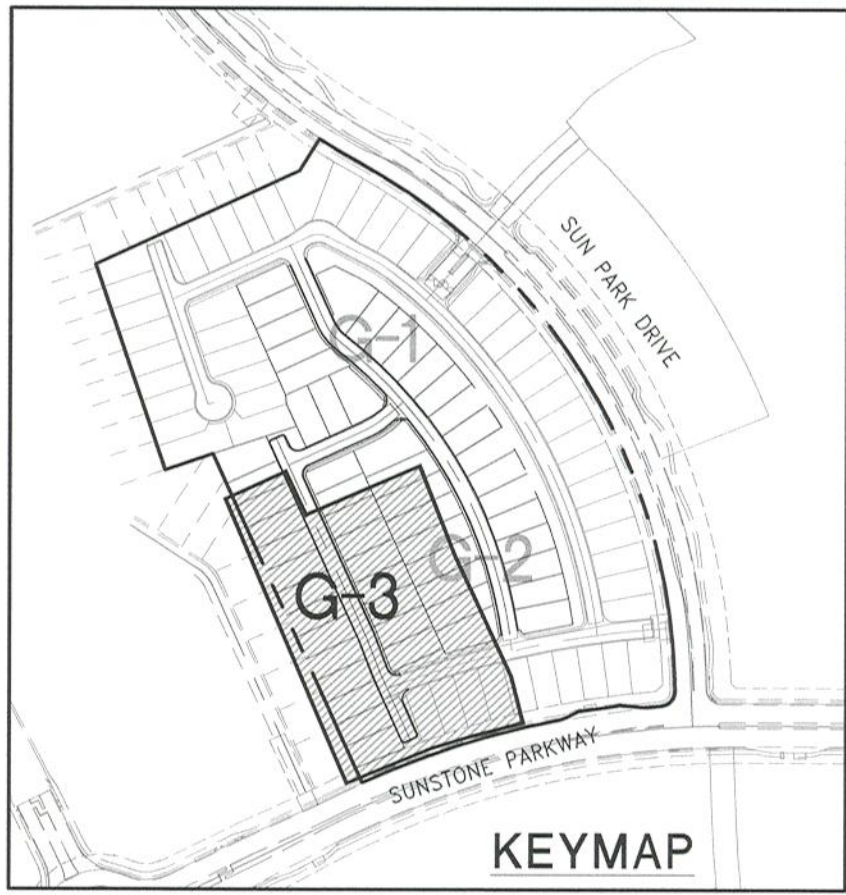

FOR REVIEW ONLY	
DATE: November 03, 2021	BY: [Signature]
HORIZ. SCALE: 1"=30'	VERT. SCALE: 1"=30'
DRAWN BY: SRC/NG	CHECKED BY: SC
DESIGNED BY: SC	APPROVED BY: CZ
PROJECT #:	4320.0014

WOODSIDE HOMES® BETTER BY DESIGN	RCI ENGINEERING 500 SOUTH RANCH DRIVE, SUITE 17, LAS VEGAS, NV 89106 MAIL: 702.453.0800 FAX: 702.453.0801
-------------------------------------	---

IMPROVEMENT PLANS FOR ESTRELLA AT SUNSTONE UNIT 2 A SINGLE FAMILY RESIDENTIAL SUBDIVISION GRADING PLAN (SHEET 3 OF 3)	NEVADA
--	--------

DATE: 11-3-21	DRAWING G-3 SHT 5 OF 19 CLV DRAWING NUMBER
---------------	---

CHARTERED PROFESSIONAL ENGINEER CHRISTOPHER R. ZRINYI Exp. 6/30/2022 CIVIL No. 13976	DATE: 11/03/21 5:41 PM
--	------------------------



CLV PROJECT #	DATE
---------------	------

I HEREBY CERTIFY THAT THIS GRADING PLAN IS IN CONFORMANCE WITH THE APPROVED
DRAINAGE STUDY DS #- ON FILE WITH CITY OF LAS VEGAS FOR THIS PROJECT.

CHRISTOPHER R. ZRINYI, PE NO. 13976

DATE

  NOT: ALL PRIVATE STREETS ARE P.U.E., PUBLIC SEWER EASEMENTS AND PUBLIC DRAINAGE EASEMENTS TO BE PRIVATELY MAINTAINED BY THE HOA.



1. CONTRACTOR TO CONSTRUCT ALL SCARP AND MAINTAIN PROPER COVER OVER AND FROM ALL WALL FOOTINGS PER THE SOILS REPORT REFERRED TO ON THE GRADING PLANS, REPORT ANY PROBLEMS IN DOING SO TO THE DEVELOPER AND THE ENGINEER IMMEDIATELY.
2. SCARP LESS THAN 1' VERTICAL NOT SHOWN ON PLANS.
3. ALL WALL ALIGNMENTS SHALL FOLLOW SIGHT VISIBILITY ZONE ALIGNMENT AND REMAIN OUTSIDE OF SIGHT VISIBILITY ZONE.

DATE: 11-3-21

DRAWING







D-1

SHT **6** OF **19**

CLV DRAWING NUMBER

CLV PROJECT # _____

Path: 4320_Woodside\0014_Sunstone C\CIVIL_IPS\U2\S0004_D-1_SUNSTONE_C UNIT 2.dwg scarabay 11/03/21 4:07pm

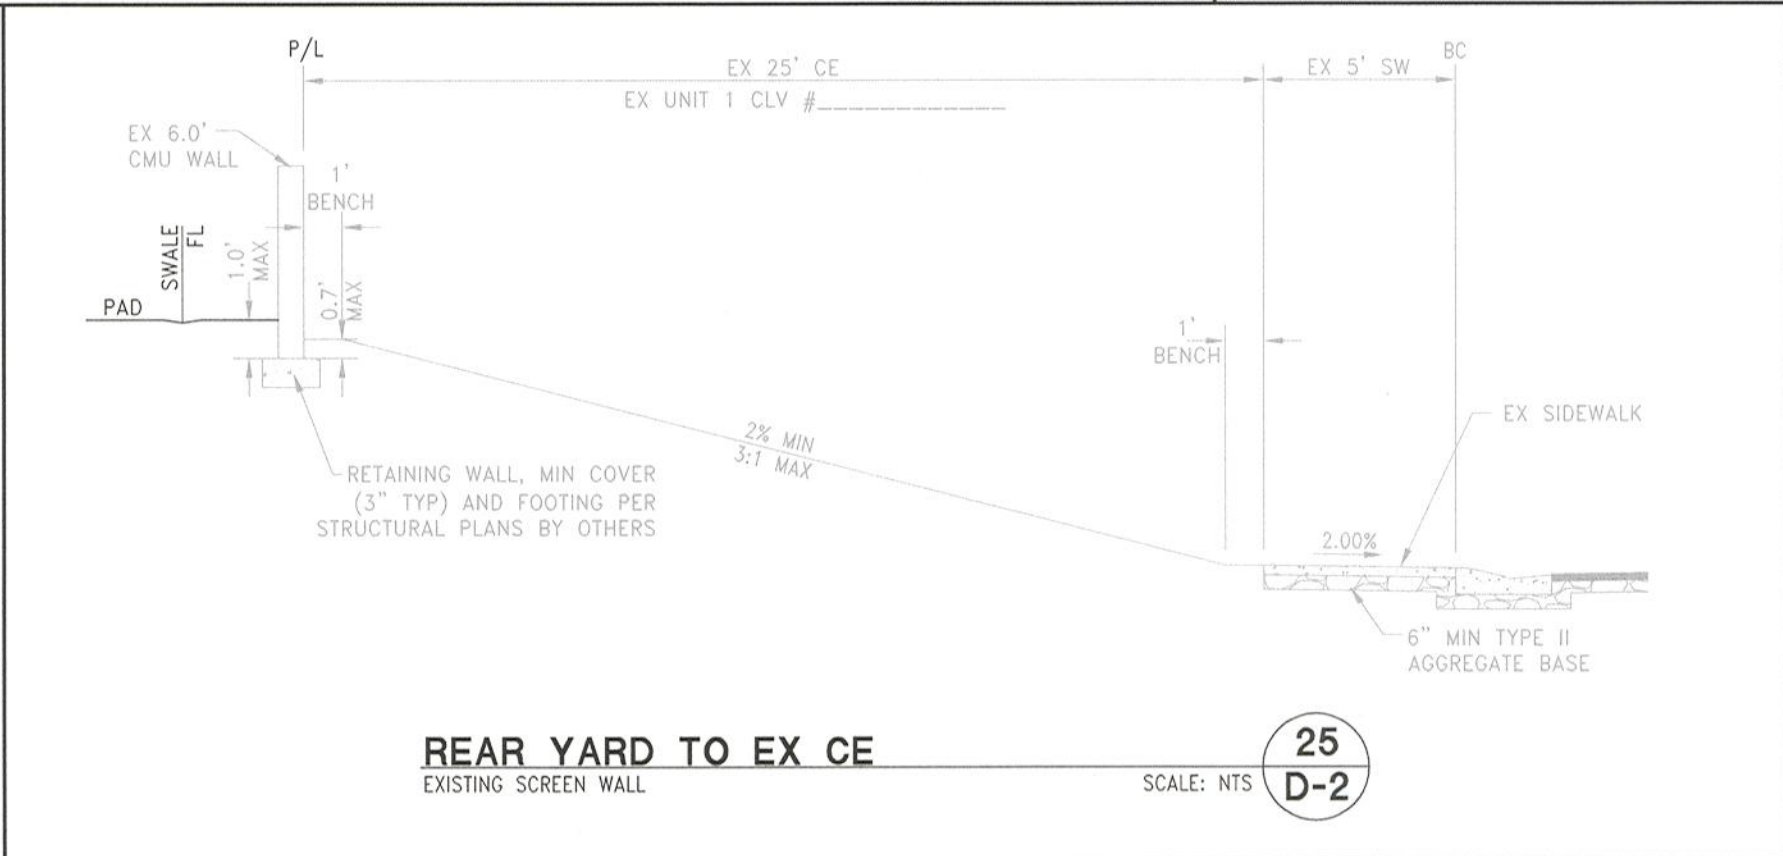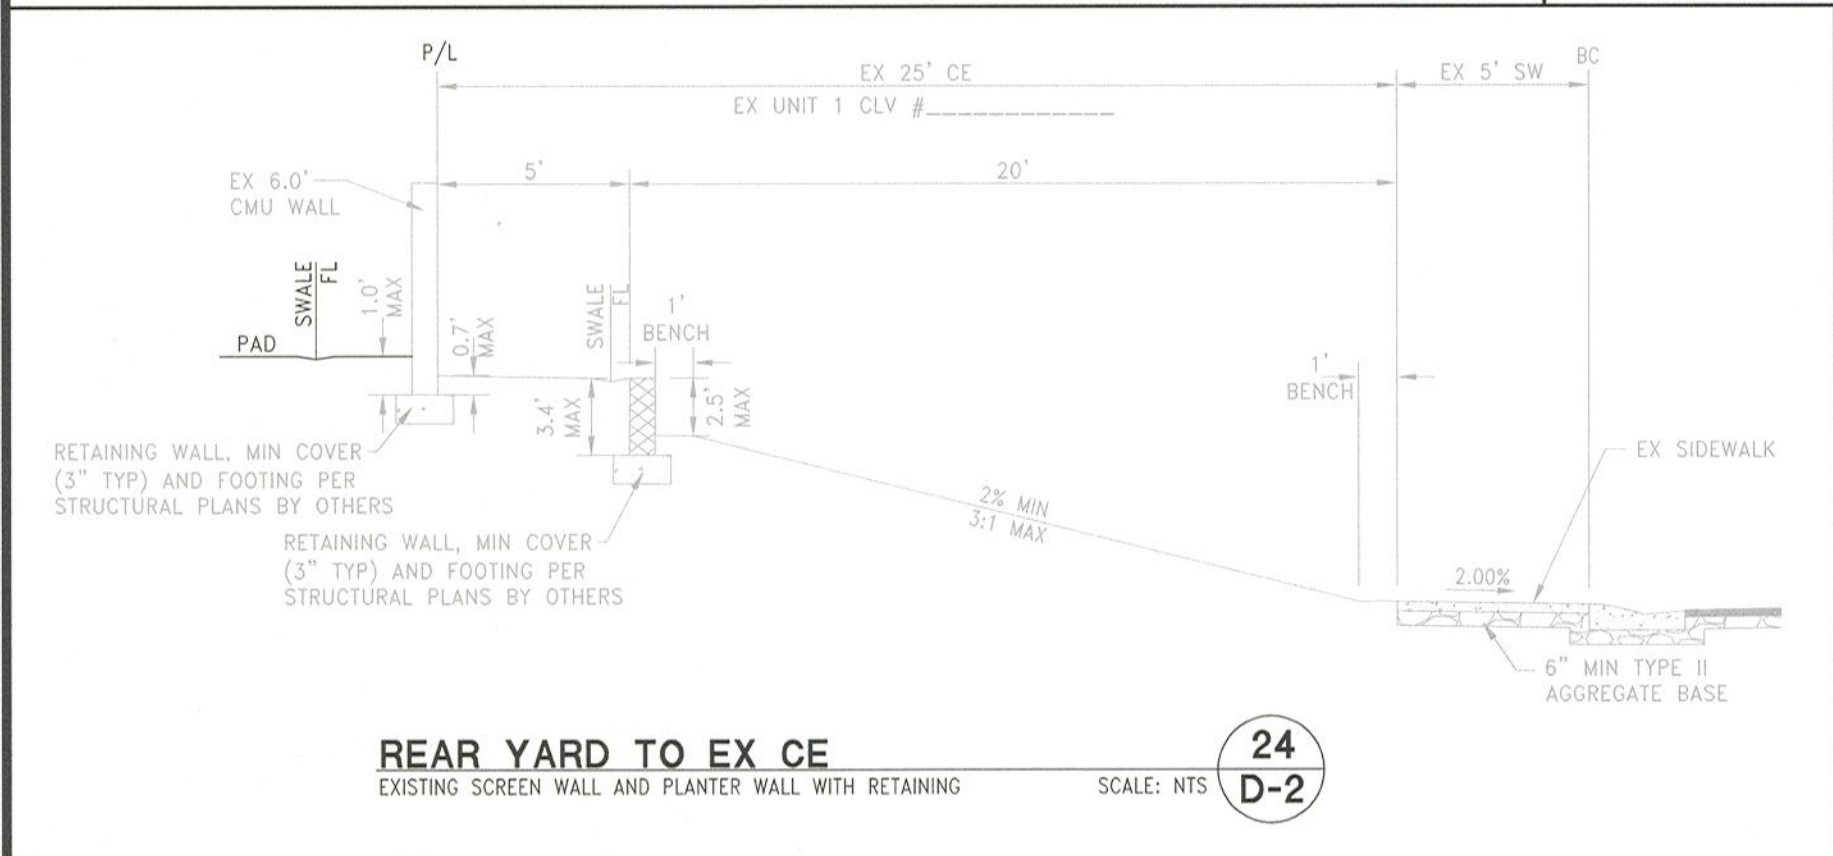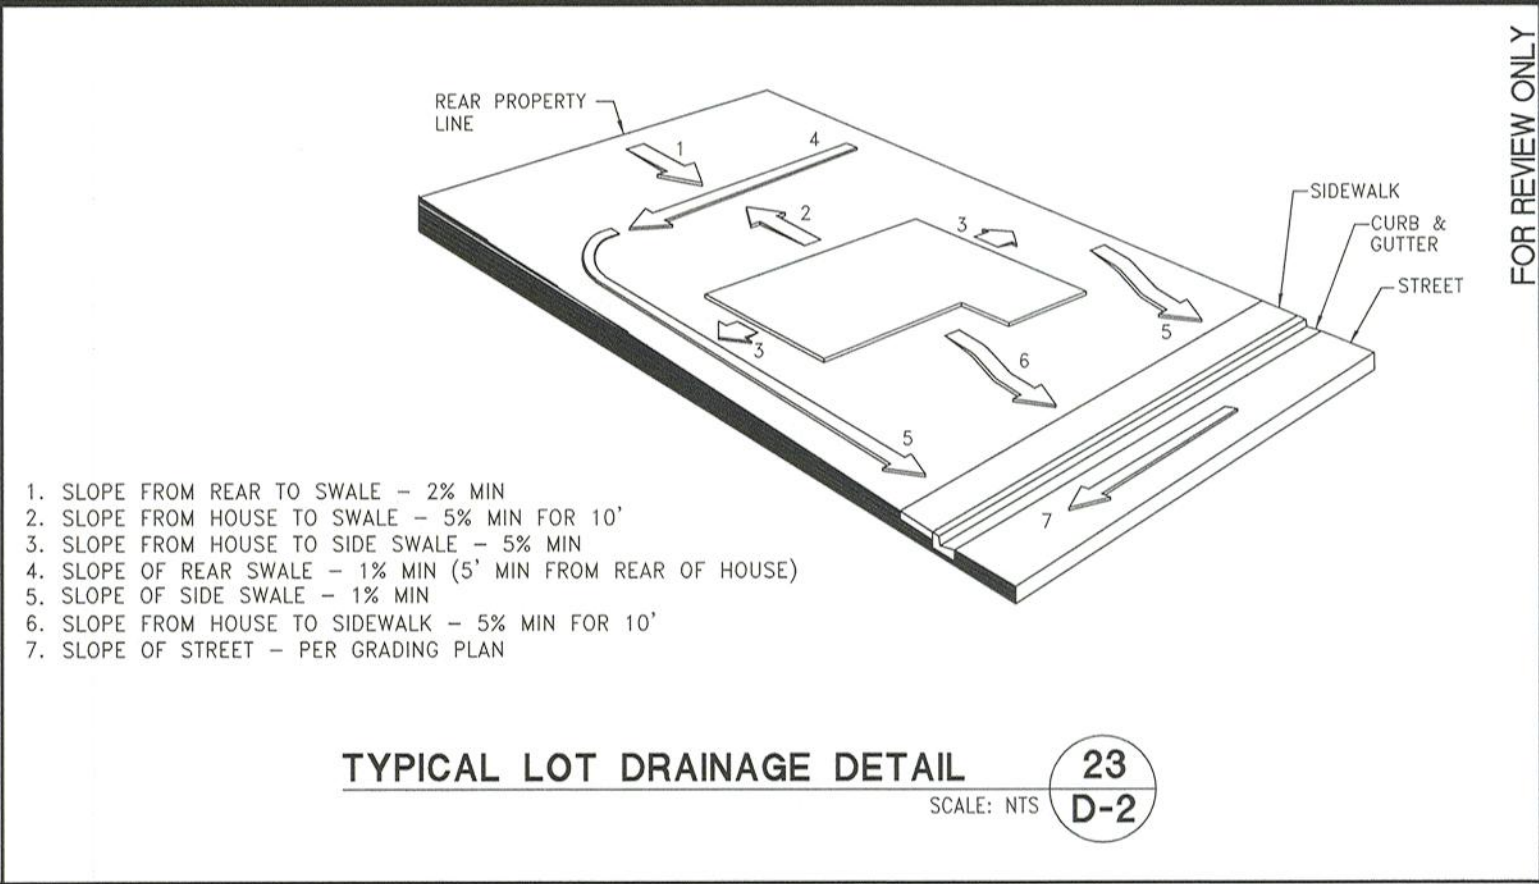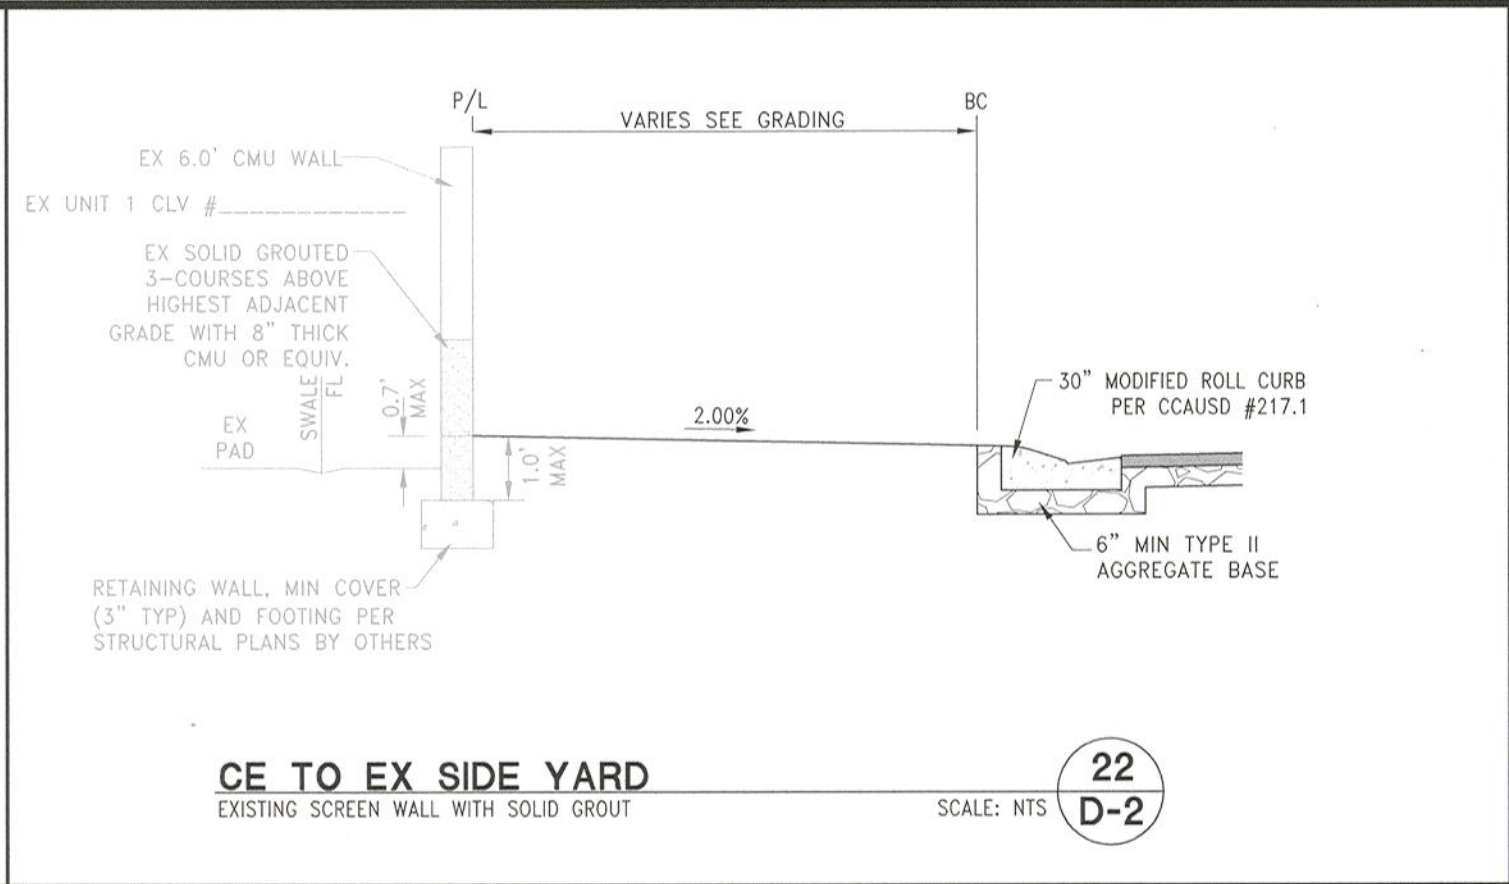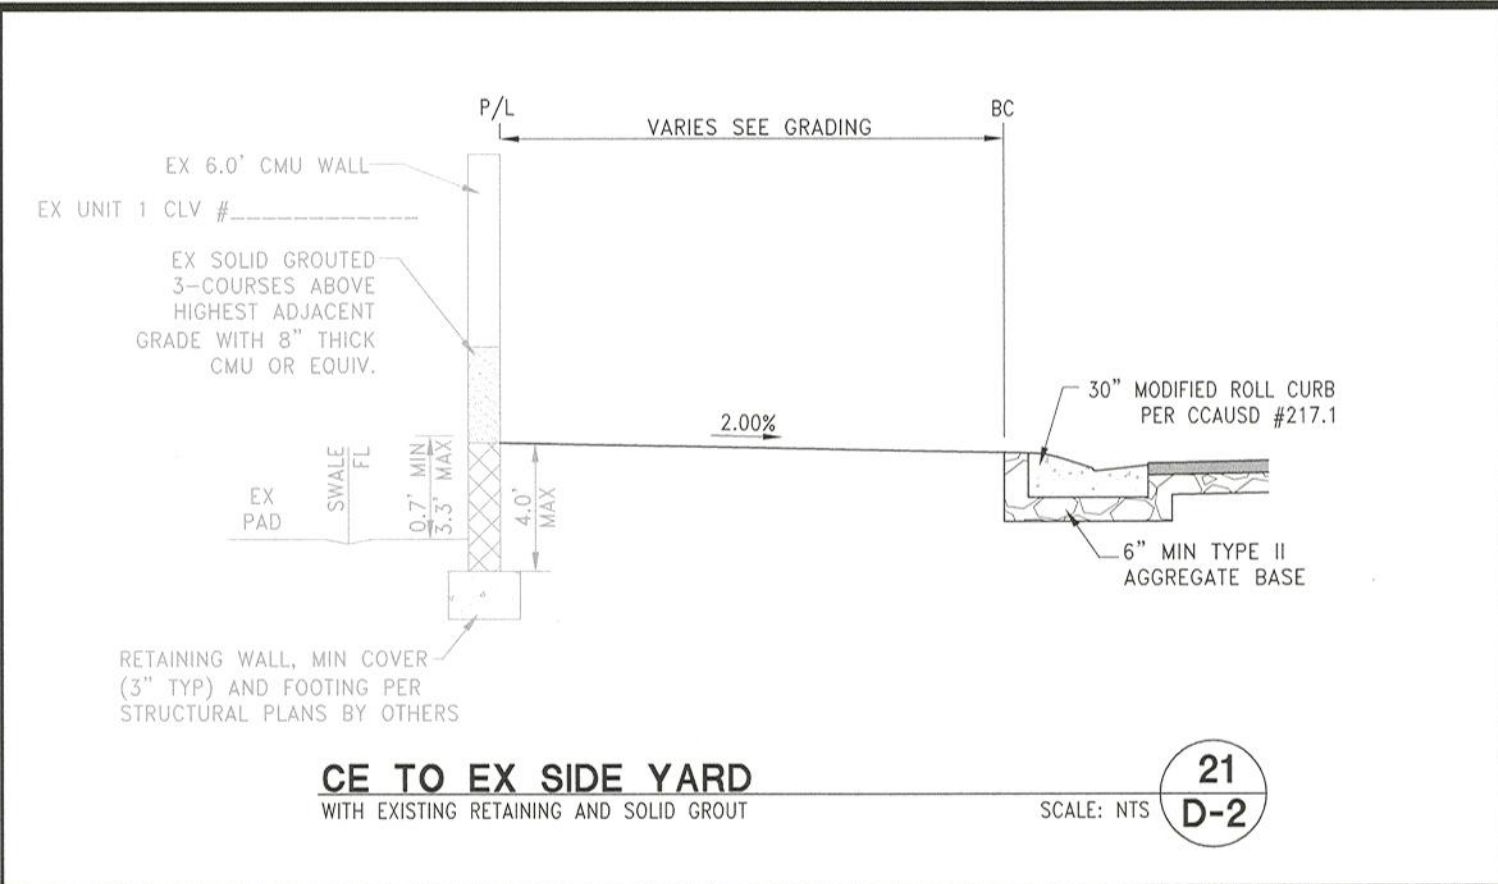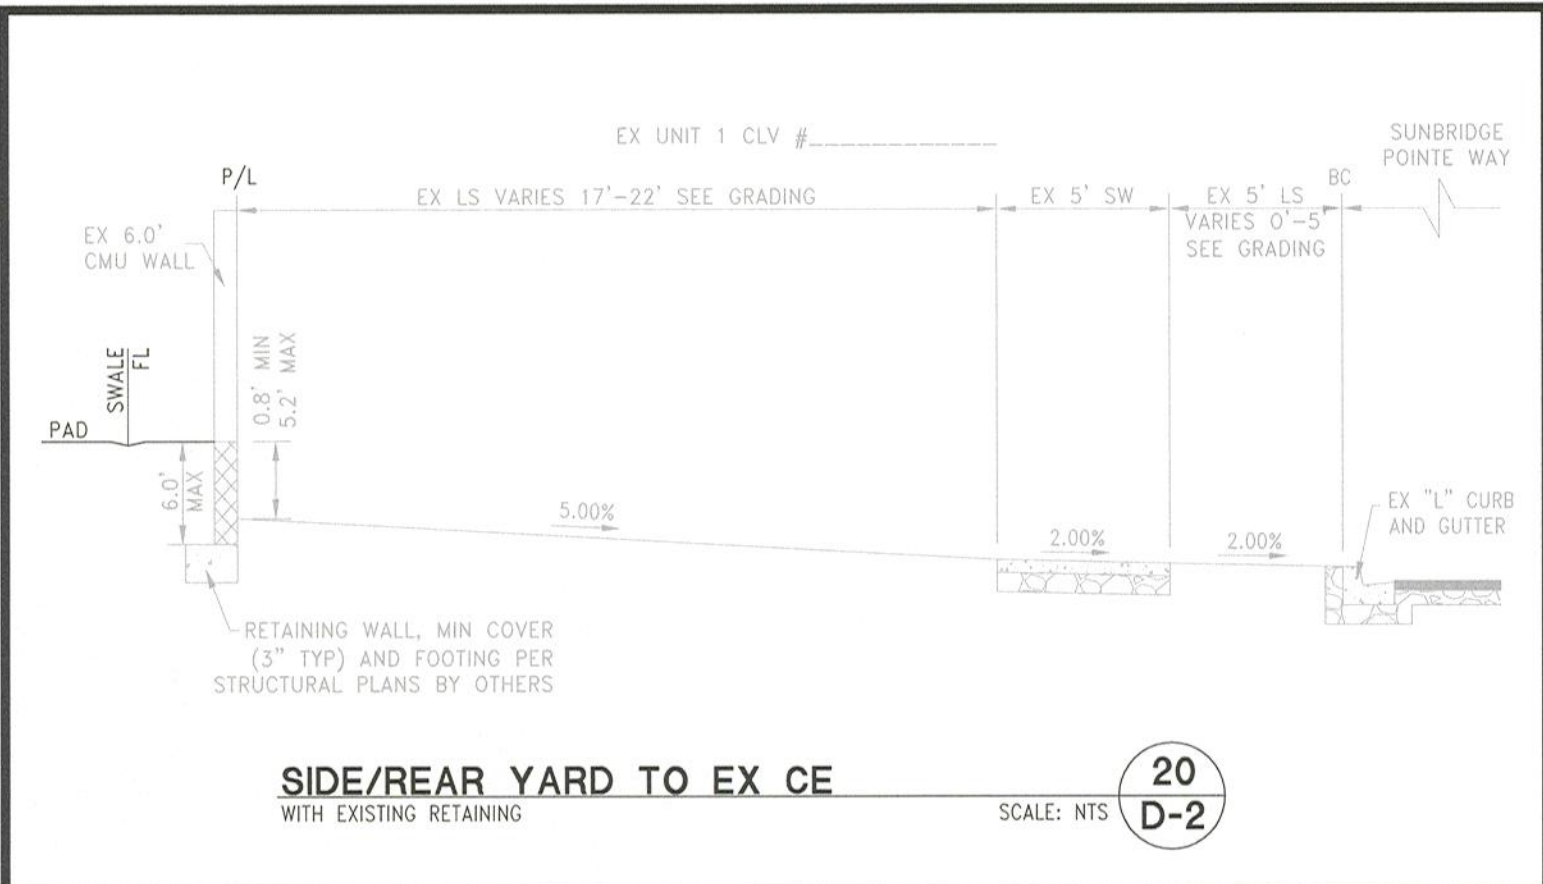

GEOTECHNICAL NOTE:
A GEOLOGIST OR GEOTECHNICAL ENGINEER SHALL BE ON SITE DURING EXCAVATION AND MASS GRADING OPERATIONS TO EXAMINE THE SOIL CHARACTERISTICS AND GEOLOGICAL CONDITIONS ENCOUNTERED, AND TO PROVIDE PROFESSIONAL ADVICE TO THE OWNER IN THE EVENT THAT UNANTICIPATED SOIL PROBLEMS ARISE AND/OR SUBSURFACE SITE CONDITIONS ARE FOUND TO BE SIGNIFICANTLY DIFFERENT THAN DEFINED BY PRE EXPLORATION AND TESTING.

WALL & SCARP NOTE:
1. CONTRACTOR TO CONSTRUCT ALL SCARP AND MAINTAIN PROPER COVER OVER AND FROM ALL WALL FOOTINGS PER THE SOILS REPORT REFERRED TO ON THE GRADING PLANS. REPORT ANY PROBLEMS IN DOING SO TO THE DEVELOPER AND THE ENGINEER IMMEDIATELY.
2. SCARP LESS THAN 1' VERTICAL NOT SHOWN ON PLANS.
3. ALL WALL ALIGNMENTS SHALL FOLLOW SIGHT VISIBILITY ZONE ALIGNMENT AND REMAIN OUTSIDE OF SIGHT VISIBILITY ZONE.

FOR REVIEW ONLY	
REV	DESCRIPTION
BY	DATE
DATE: November 03, 2021	
HORIZ. SCALE: 1"=30'	VERT. SCALE: N/A
DRAWN BY: SRC/NG	DESIGNED BY: SC
CHECKED BY: CZ	APPROVED BY: CZ
PROJECT #:	4320.0014

Woodside Homes
BETTER BY DESIGN

RCI ENGINEERING
500 SOUTH RANGING DRIVE, SUITE 112 LAS VEGAS, NV 89106
PHONE: 702.453.0800 FAX: 702.453.0801

IMPROVEMENT PLANS FOR

ESTRELLA AT SUNSTONE UNIT 2

A SINGLE FAMILY RESIDENTIAL SUBDIVISION

GRADING DETAILS (SHEET 2 OF 2)

CITY OF LAS VEGAS

NEVADA

DATE: 11-3-21

DRAWING

D-2

SHT 7 OF 19

CLV DRAWING NUMBER

CLV PROJECT #